

CONTRACT PLANS COMPONENTS

ROADWAY PLANS
SIGNING AND PAVEMENT MARKING PLANS
INTELLIGENT TRANSPORTATION SYSTEMS PLANS
LIGHTING PLANS
TOLL FACILITIES PLANS

A DETAILED INDEX APPEARS ON THE
KEY SHEET OF EACH COMPONENT

INDEX OF ROADWAY PLANS

SHEET NO.	SHEET DESCRIPTION
1	KEY SHEET
2 - 21	DRAINAGE MAP
22 - 44	TYPICAL SECTIONS
45	OPTIONAL MATERIALS TABULATION
46 - 51	PROJECT LAYOUT
52 - 53	CURVE DATA AND COORDINATES
54	PROJECT NOTES
55 - 97	PLAN
98 - 231	PROFILE
232 - 236	MISCELLANEOUS DETAILS
237 - 250	DRAINAGE STRUCTURES
251 - 256	DRAINAGE DETAILS
257 - 263	POND DETAIL SHEET
264 - 747	CROSS SECTIONS
748 - 791	EROSION CONTROL PLAN
792 - 795	TRAFFIC CONTROL PLAN
GR-1	ROADWAY SOIL SURVEY
UTV-1 thru UTV-12	SUMMARY OF VERIFIED UTILITIES

* These sheets are included in the Index of Roadway Plans
only to indicate that they are part of the Roadway Plans.
These sheets are contained in a separate digitally
signed and sealed document.

*** Traffic Control Plans are included in the Phase II Utility Submittal

GOVERNING DESIGN STANDARDS:

Florida Department of Transportation, FY2017-18 Design Standards eBook (DSeB)
and applicable Design Standards Revisions (DSRs) at the following website:
<http://www.dot.state.fl.us/rddesign/DesignStandards/Standards.shtm>

GOVERNING STANDARD SPECIFICATIONS:

Florida Department of Transportation, July 2017 Standard Specifications
for Road and Bridge Construction at the following website:
<http://www.dot.state.fl.us/programmanagement/Implemented/SpecBooks>

STATE OF FLORIDA DEPARTMENT OF TRANSPORTATION

CONTRACT PLANS

FINANCIAL PROJECT ID 406144-1-52-01

PALM BEACH COUNTY (93470)

STATE ROAD NO. 91

WIDENING OF FLORIDA'S TURNPIKE FROM NORTH OF SR 804
(BOYNTON BEACH BLVD) (MP 88) TO NORTH OF SR 802 (LAKE WORTH ROAD) (MP 94)
(WIDENING FROM 4 LANES TO 8 LANES)

END PROJECT FPID 406144-1-52-01
STA 2454+00.00
Q CONST SR 91
(FLORIDA'S TURNPIKE)
COUNTY MP 21.023
TURNPIKE MP 94.083



END BRIDGE
#931002(NB) &
#931003(SB)
Q CONST SR 91
STA 2299+88.32

BEGIN BRIDGE
#931002(NB) &
#931003(SB)
Q CONST SR 91
STA 2298+55.82


END BRIDGE #931010
Q CONST SR 91
STA 2112+54.11

BEGIN BRIDGE #931010
Q CONST SR 91
STA 2111+67.11

BEGIN PROJECT FPID 406144-1-52-01
STA 2084+97.25
Q CONST SR 91
(FLORIDA'S TURNPIKE)
COUNTY MP 14.034
TURNPIKE MP 87.094

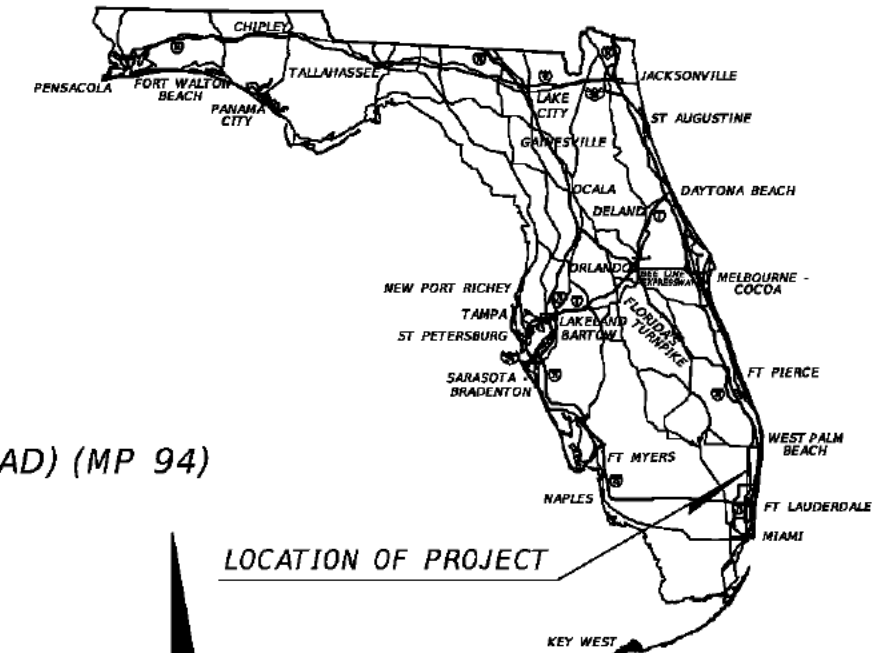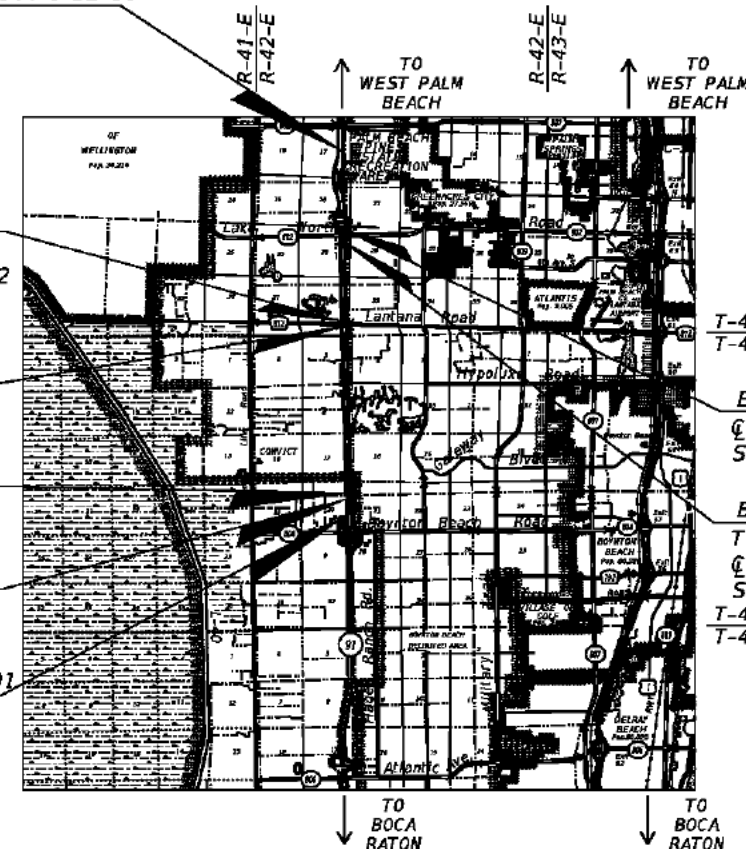

LOCATION OF PROJECT

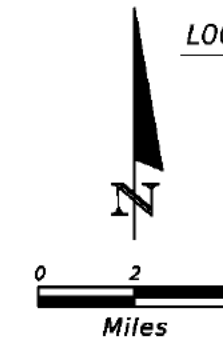

This project is design to NAVD, 1988 Datum.

ROADWAY PLANS ENGINEER OF RECORD:

HOOI GIN NG, P.E.
P.E. NO.: 58123
KIMLEY-HORN AND ASSOCIATES, INC.
CONSULTING ENGINEERS AND PLANNERS
1920 WEKIVA WAY, SUITE 200
WEST PALM BEACH, FLORIDA 33411
PHONE (561) 845-0665
CONTRACT NO. C-8E12
VENDOR NUMBER: VF-560-885-615-001
CERTIFICATE OF AUTHORIZATION NO. 696


FDOT PROJECT MANAGER:
PATRICK MUENCH, P.E.

GEC PROJECT MANAGER:
CRAIG BOSTIC, P.E.


REVISIONS:

KEY SHEET REVISIONS	
DATE	DESCRIPTION


CONSTRUCTION CONTRACT NO.	FISCAL YEAR	SHEET NO.
	18	1

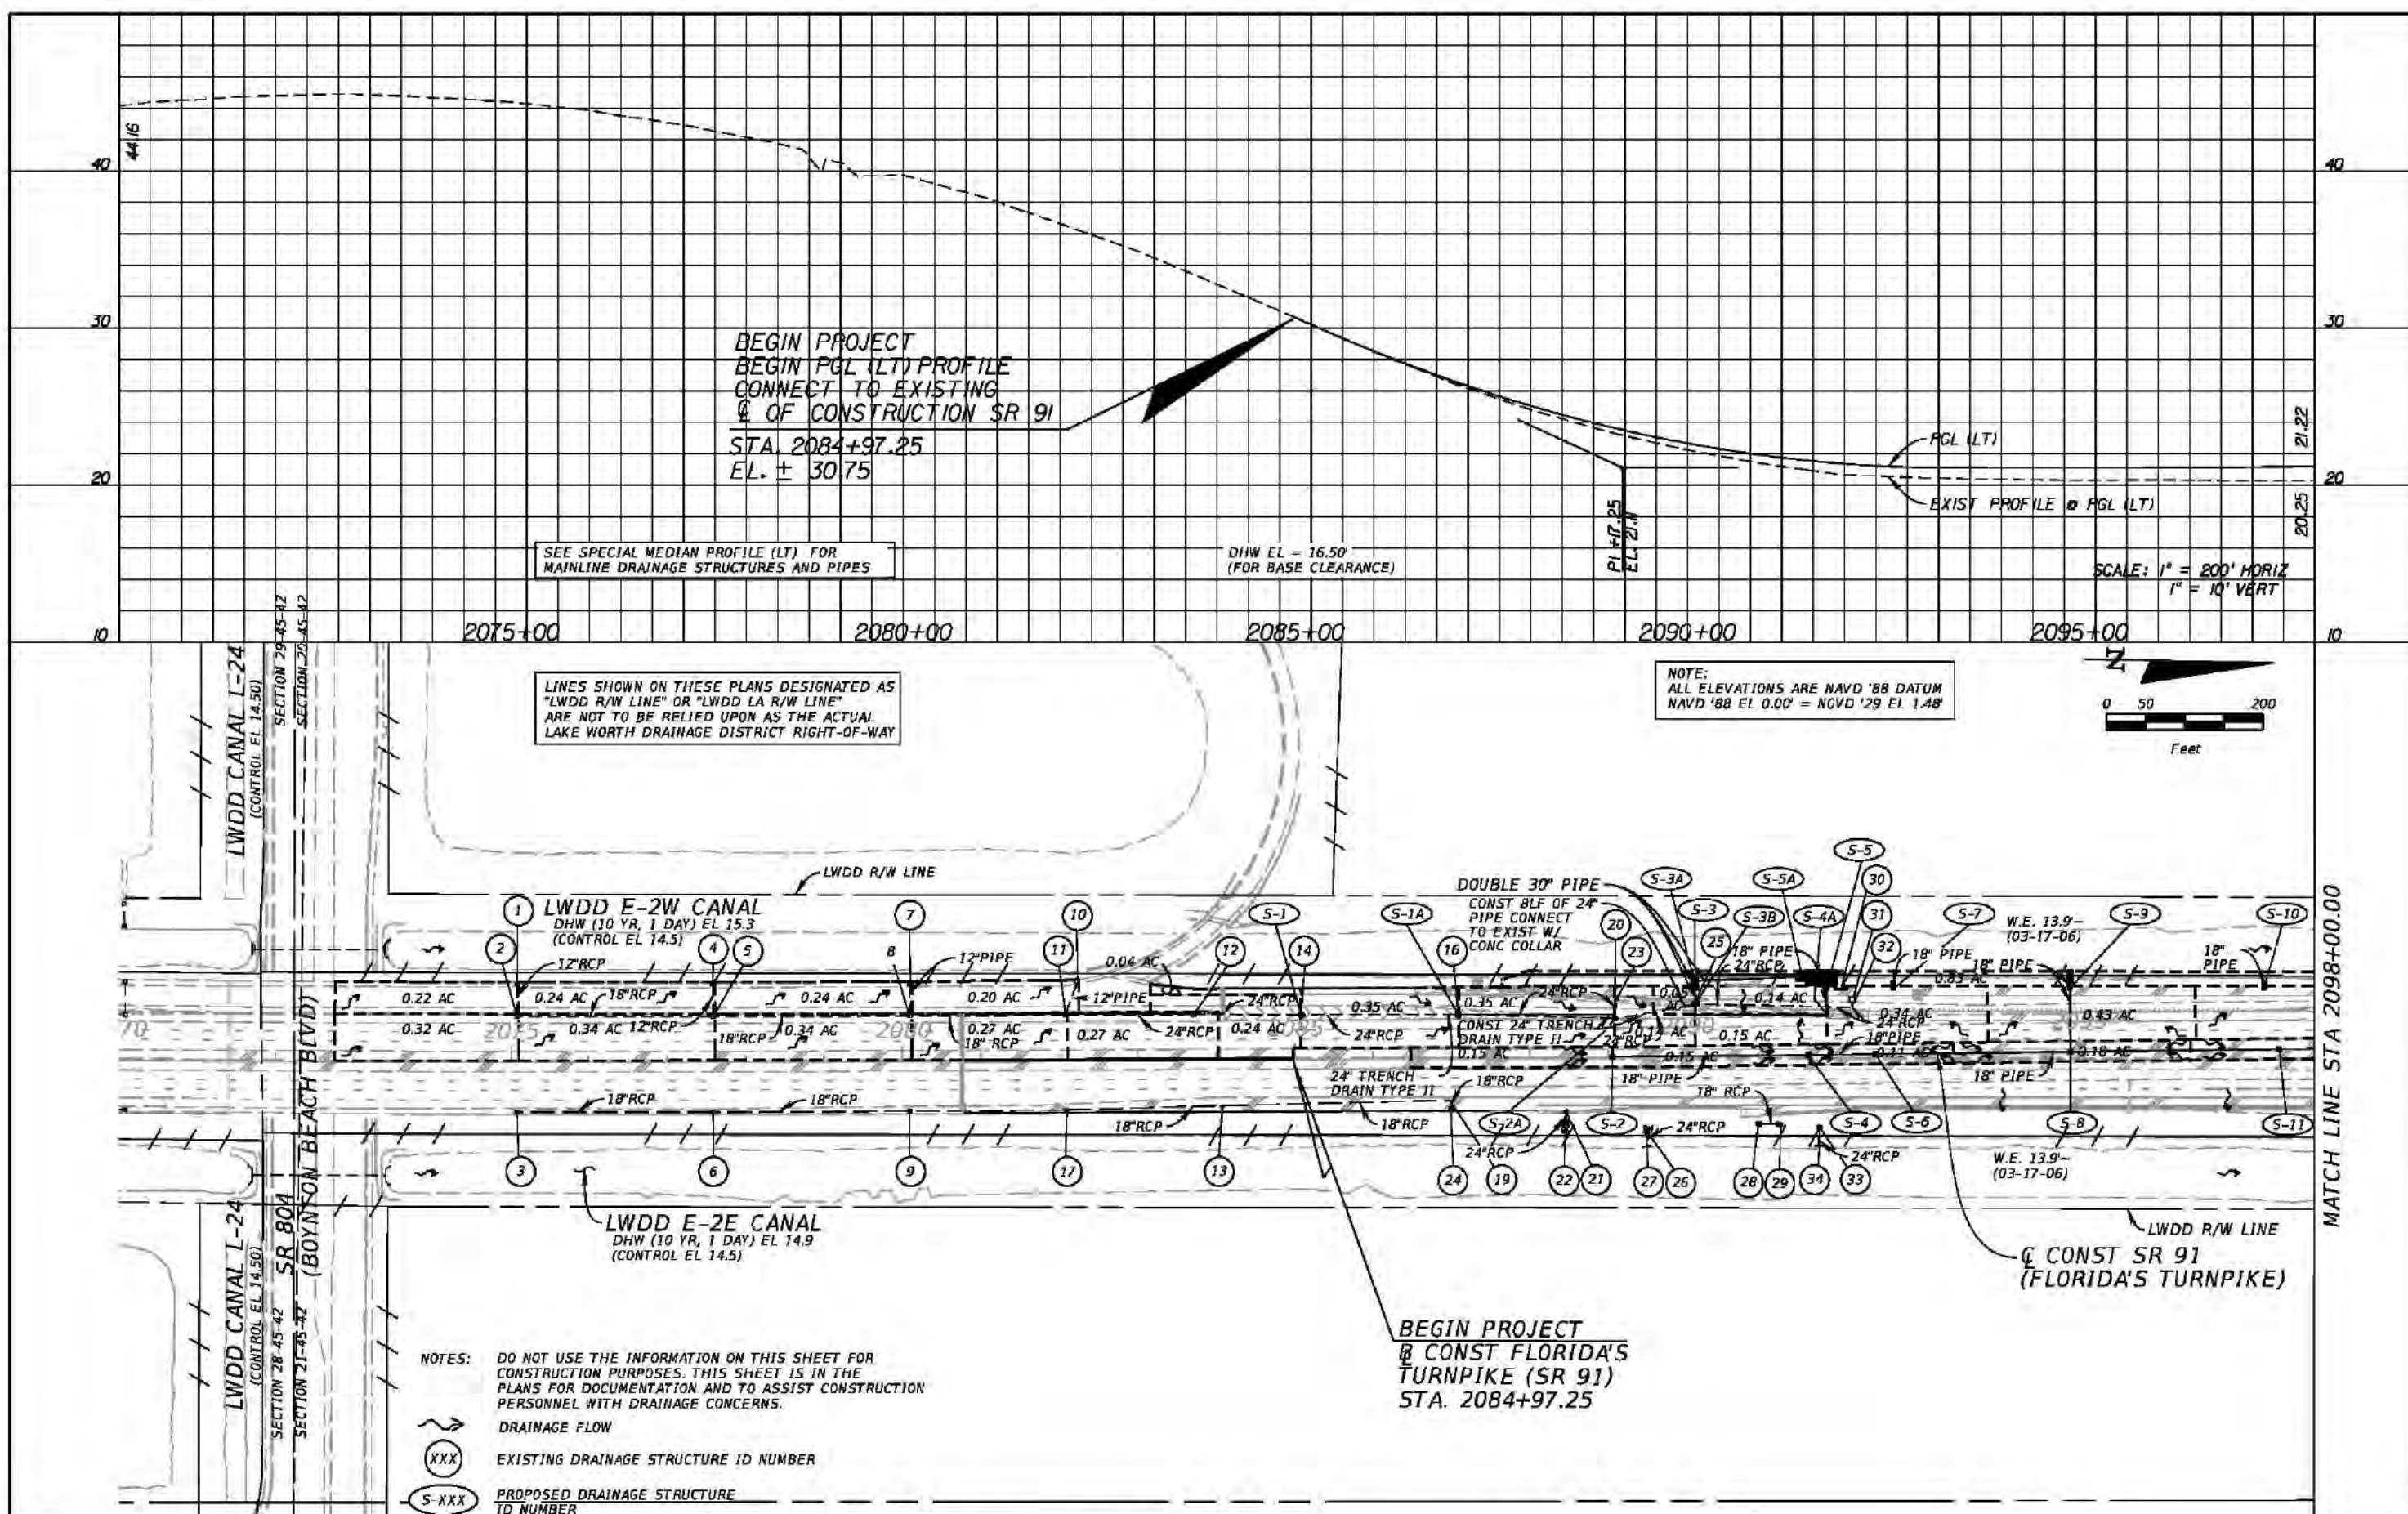



REVISIONS				Kimley-Horn and Associates, Inc. Certificate Of Authorization No. 696 Hooi Gin Ng, P.E. P.E. License No. 58123 1920 Wekiva Way, Suite 200 West Palm Beach, Florida 33411	STATE OF FLORIDA DEPARTMENT OF TRANSPORTATION			DRAINAGE MAP	SHEET NO. 2
DATE	DESCRIPTION	DATE	DESCRIPTION		ROAD NO.	COUNTY	FINANCIAL PROJECT ID		
					91	PALM BEACH	406144-1-52-01		

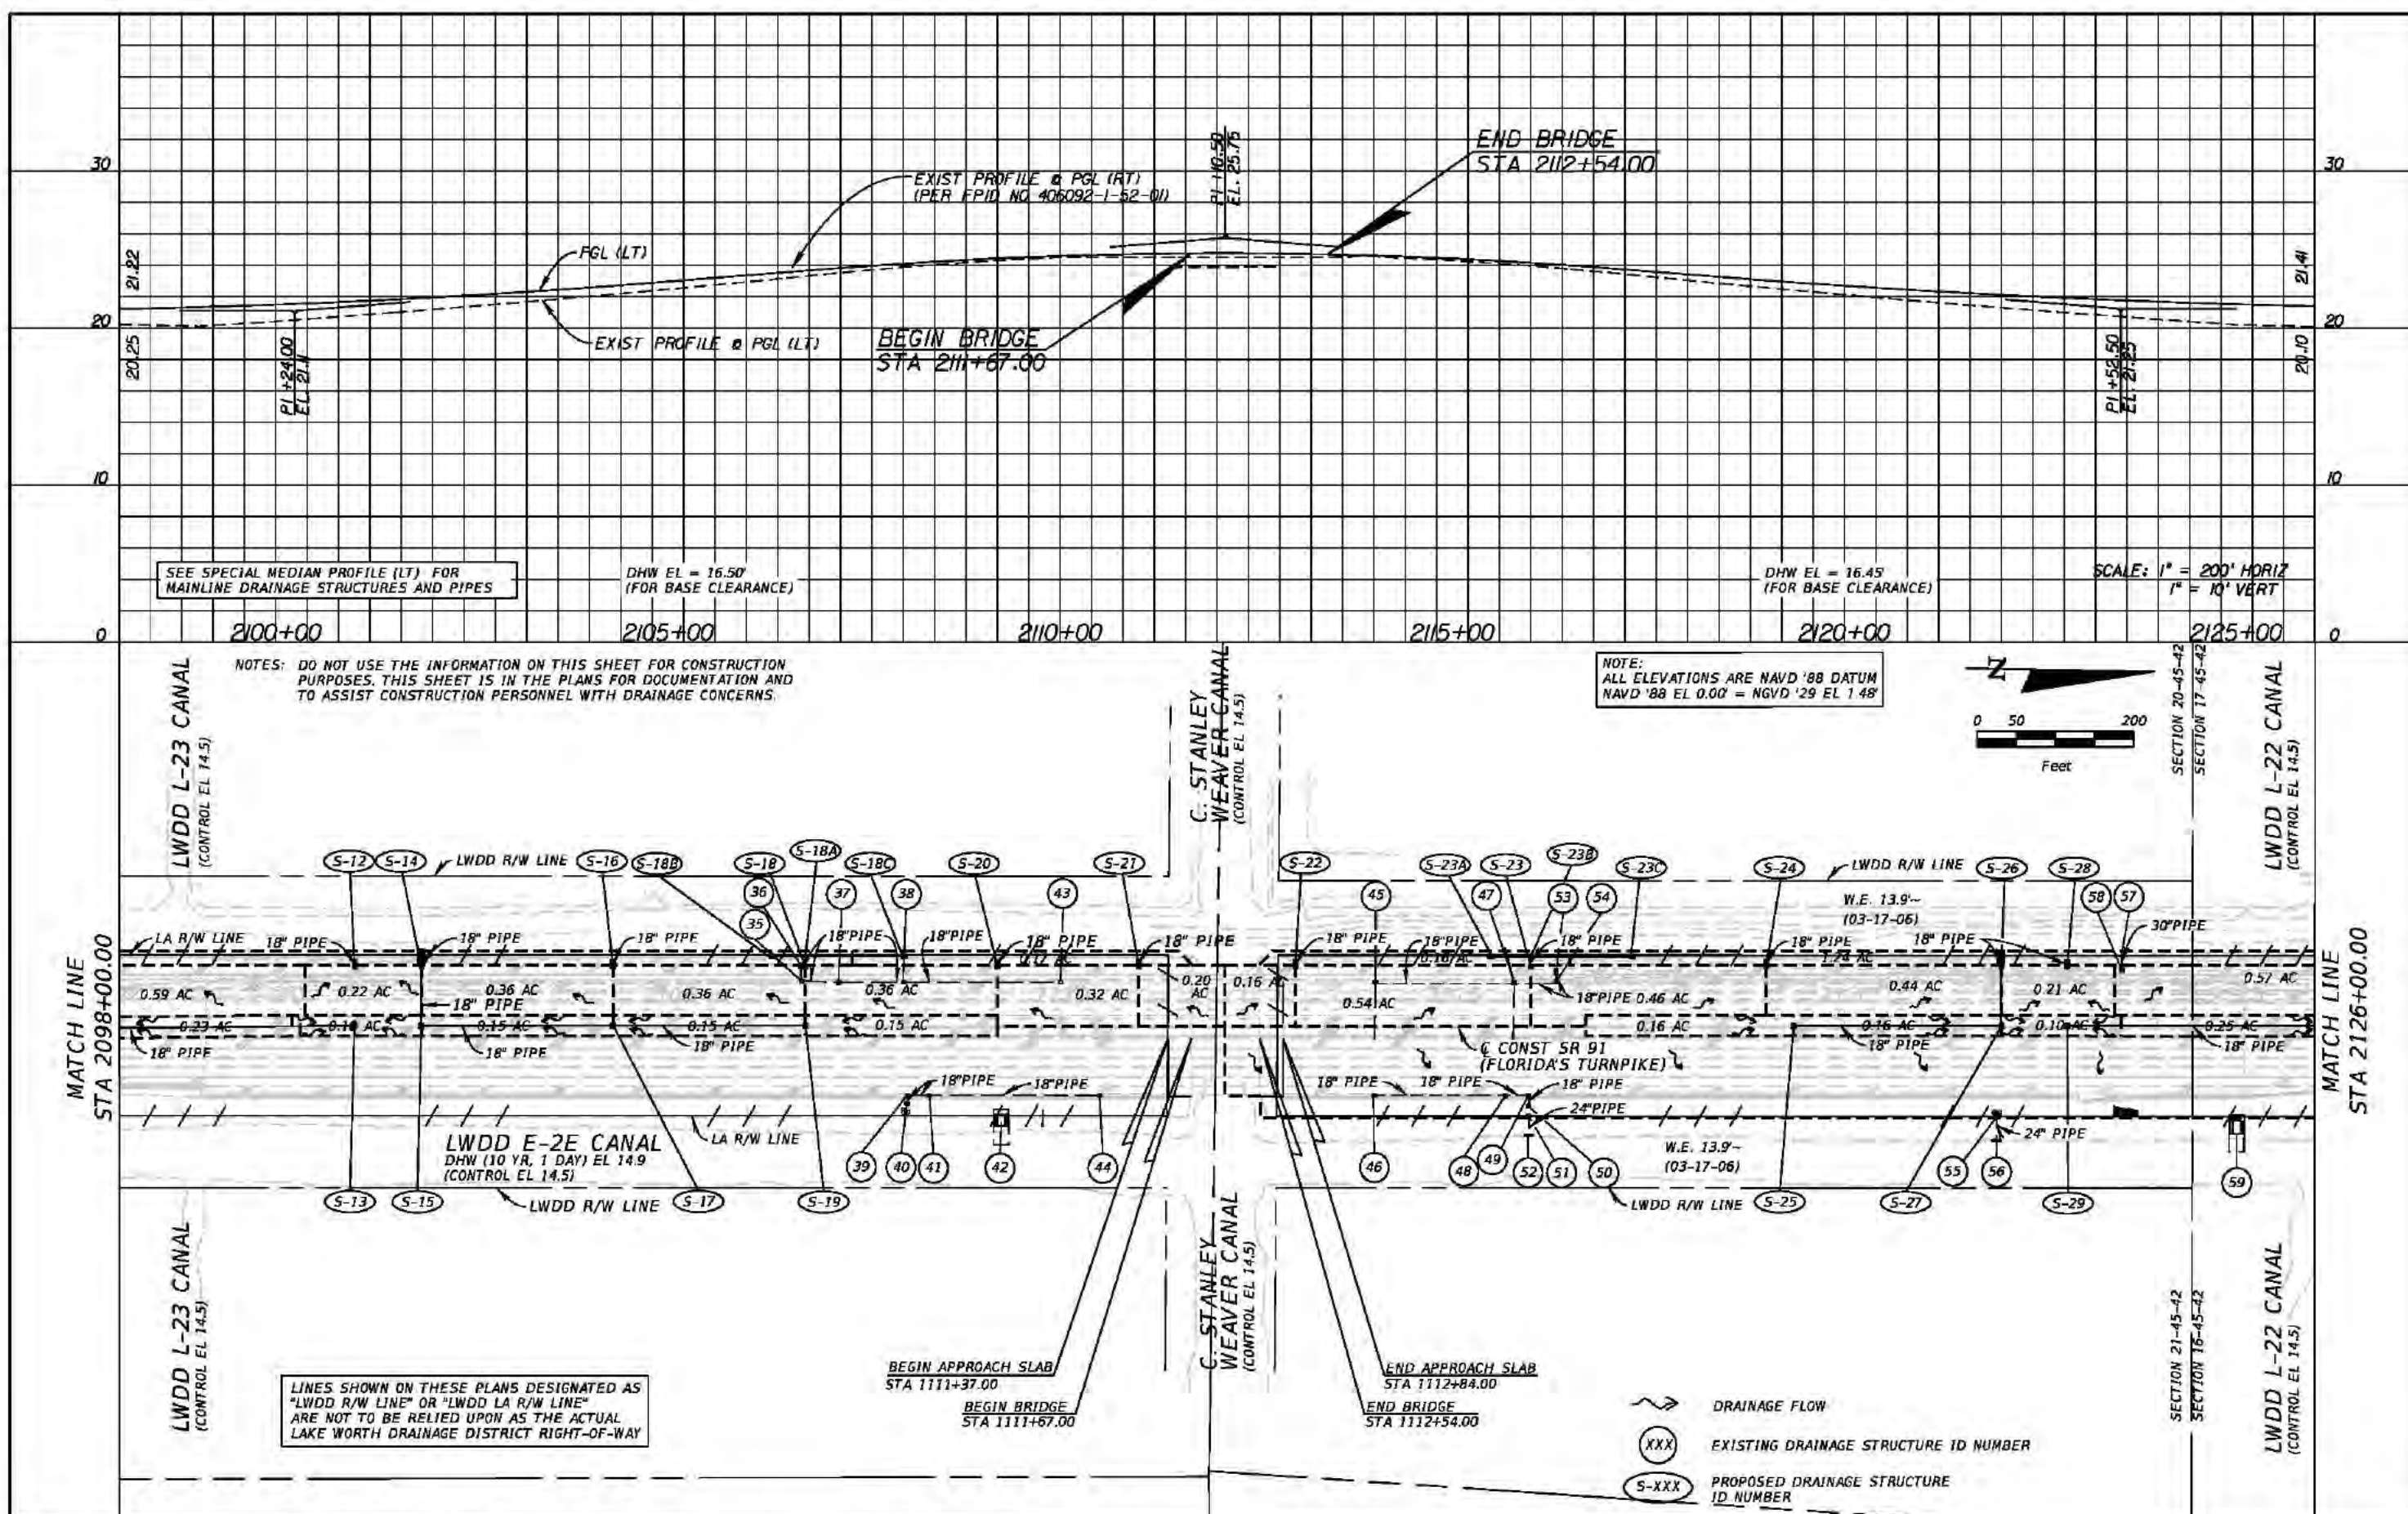


REVISIONS				Kimley-Horn and Associates, Inc. Certificate Of Authorization No. 696 Hooi Gin Ng, P.E. P.E. License No. 58123 1920 Wekiva Way, Suite 200 West Palm Beach, Florida 33411	STATE OF FLORIDA DEPARTMENT OF TRANSPORTATION			DRAINAGE MAP	SHEET NO.
DATE	DESCRIPTION	DATE	DESCRIPTION		ROAD NO.	COUNTY	FINANCIAL PROJECT ID		
					91	PALM BEACH	406144-1-52-01		3

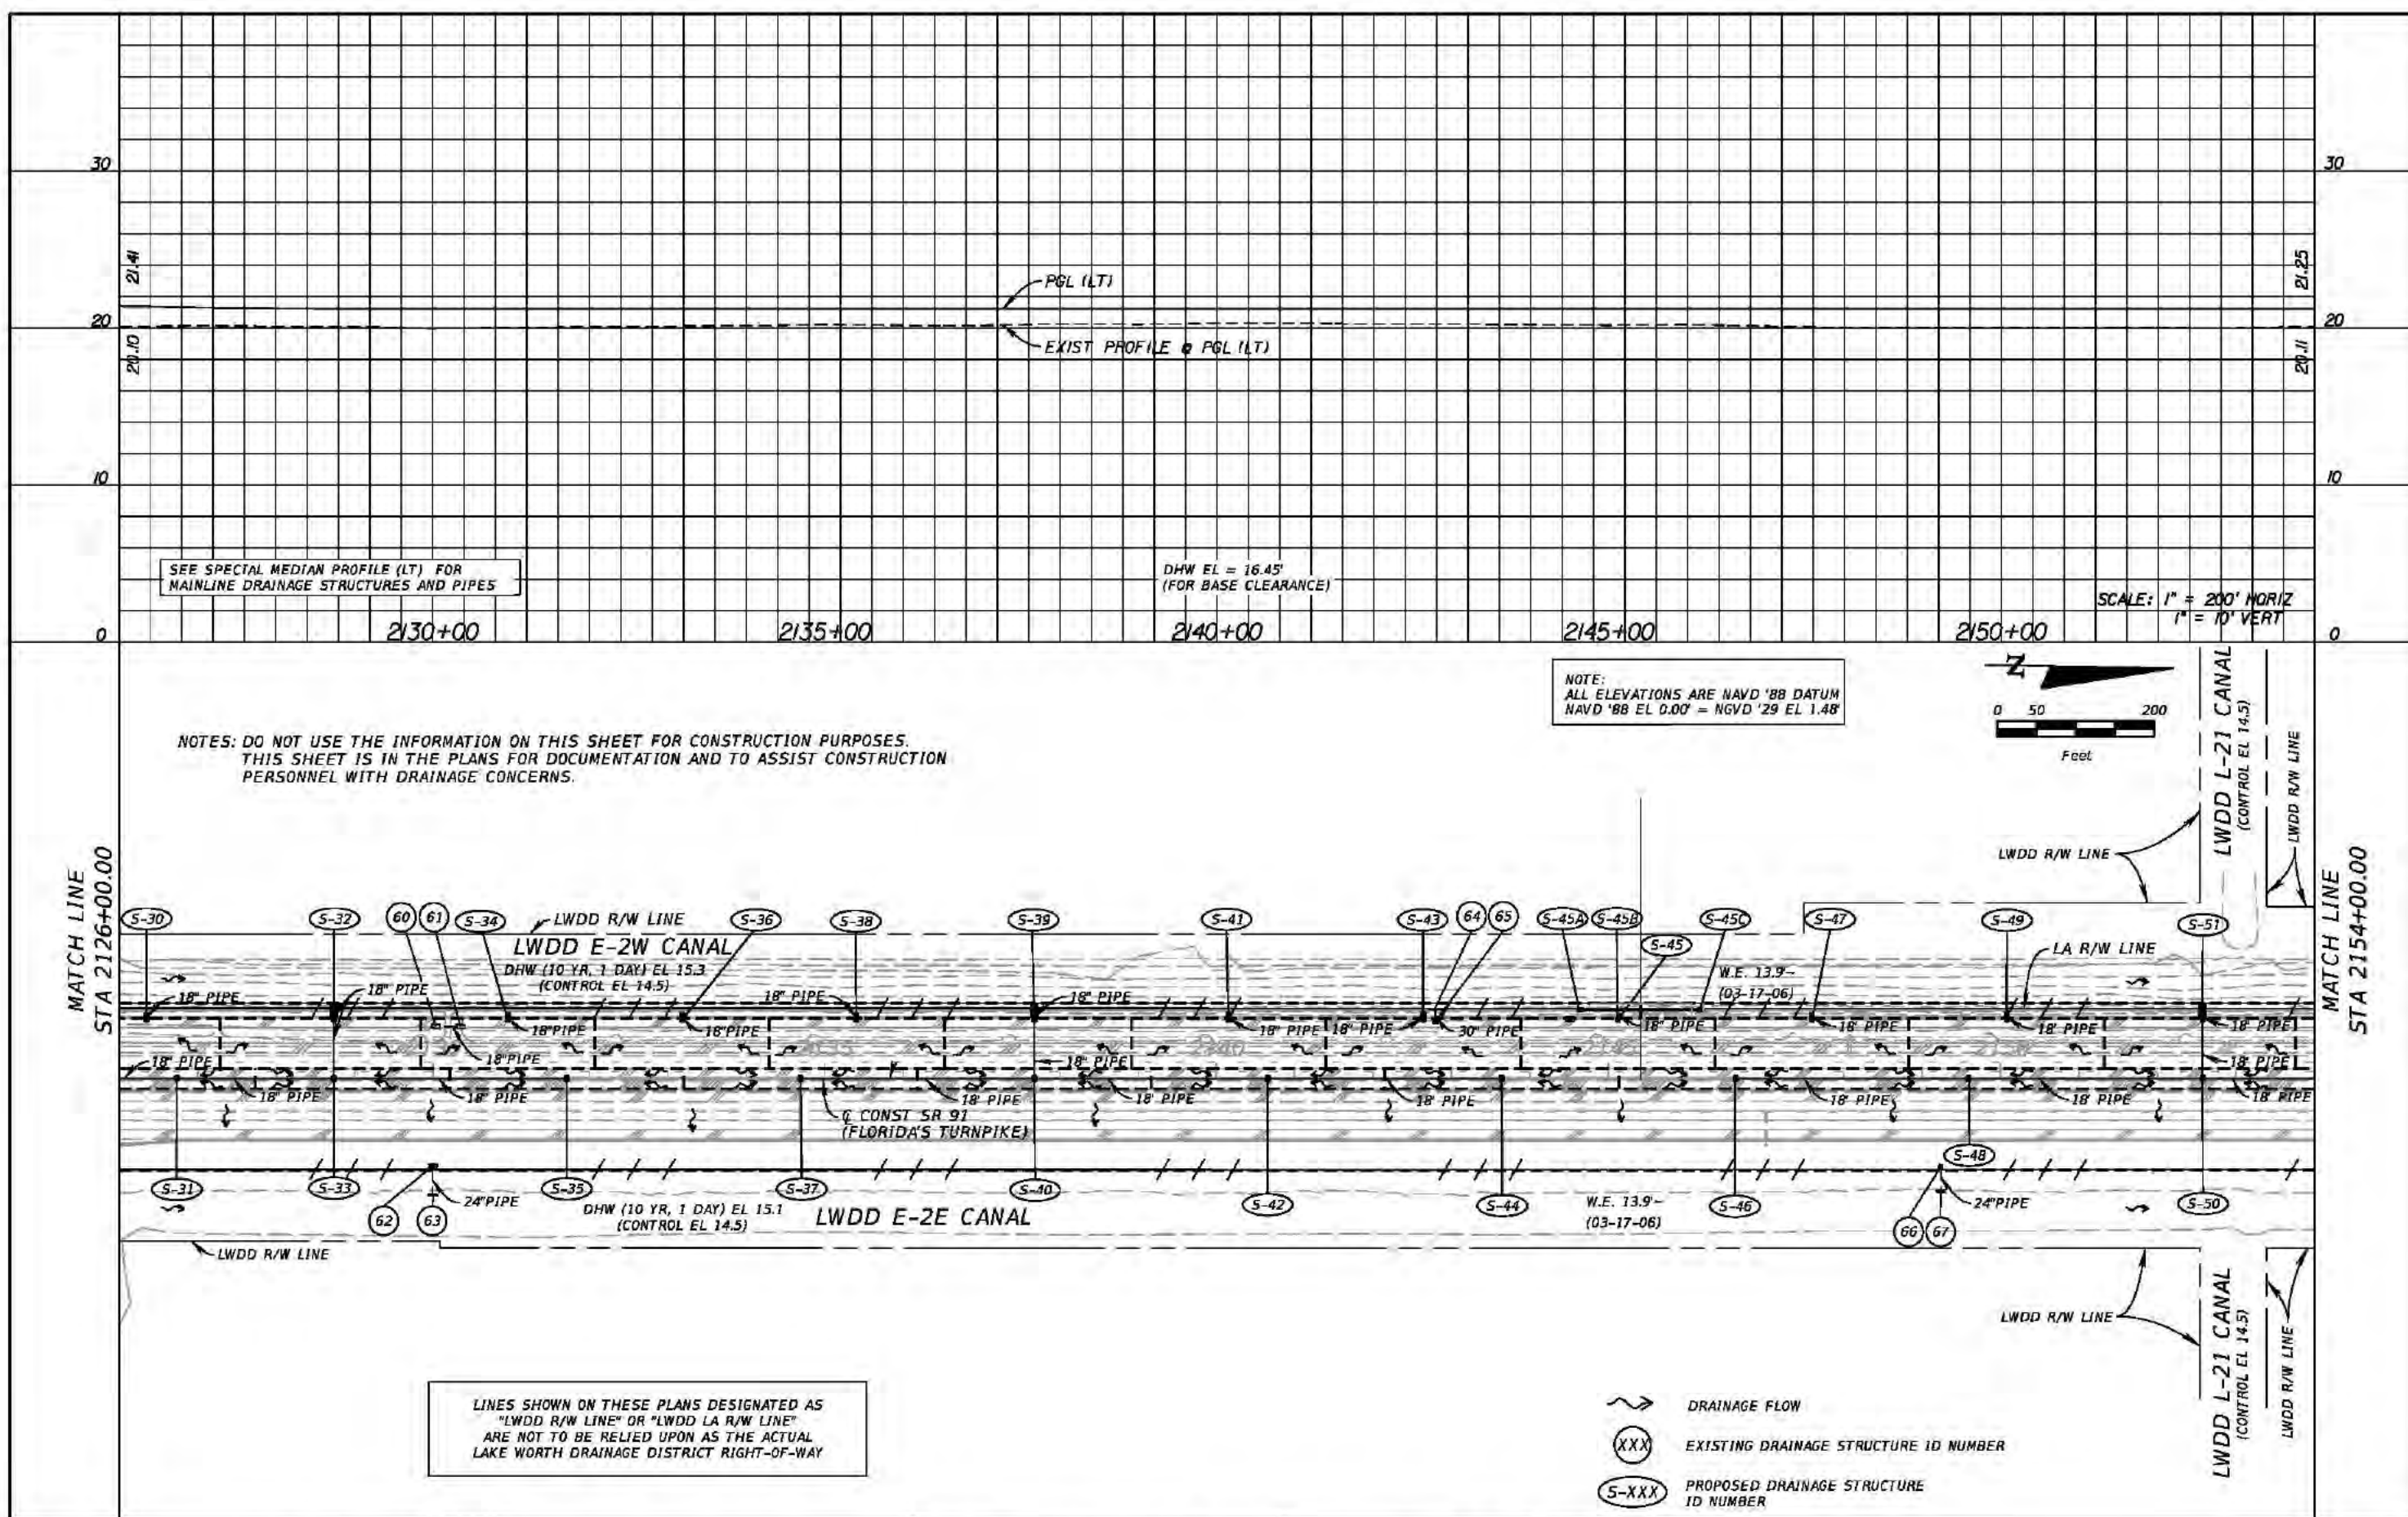

REVISIONS				Kimley-Horn and Associates, Inc. Certificate Of Authorization No. 696 Hooi Gin Ng, P.E. P.E. License No. 58123 1920 Wekiva Way, Suite 200 West Palm Beach, Florida 33411	STATE OF FLORIDA DEPARTMENT OF TRANSPORTATION			DRAINAGE MAP	SHEET NO.
DATE	DESCRIPTION	DATE	DESCRIPTION		ROAD NO.	COUNTY	FINANCIAL PROJECT ID		
					91	PALM BEACH	406144-1-52-01		
									4

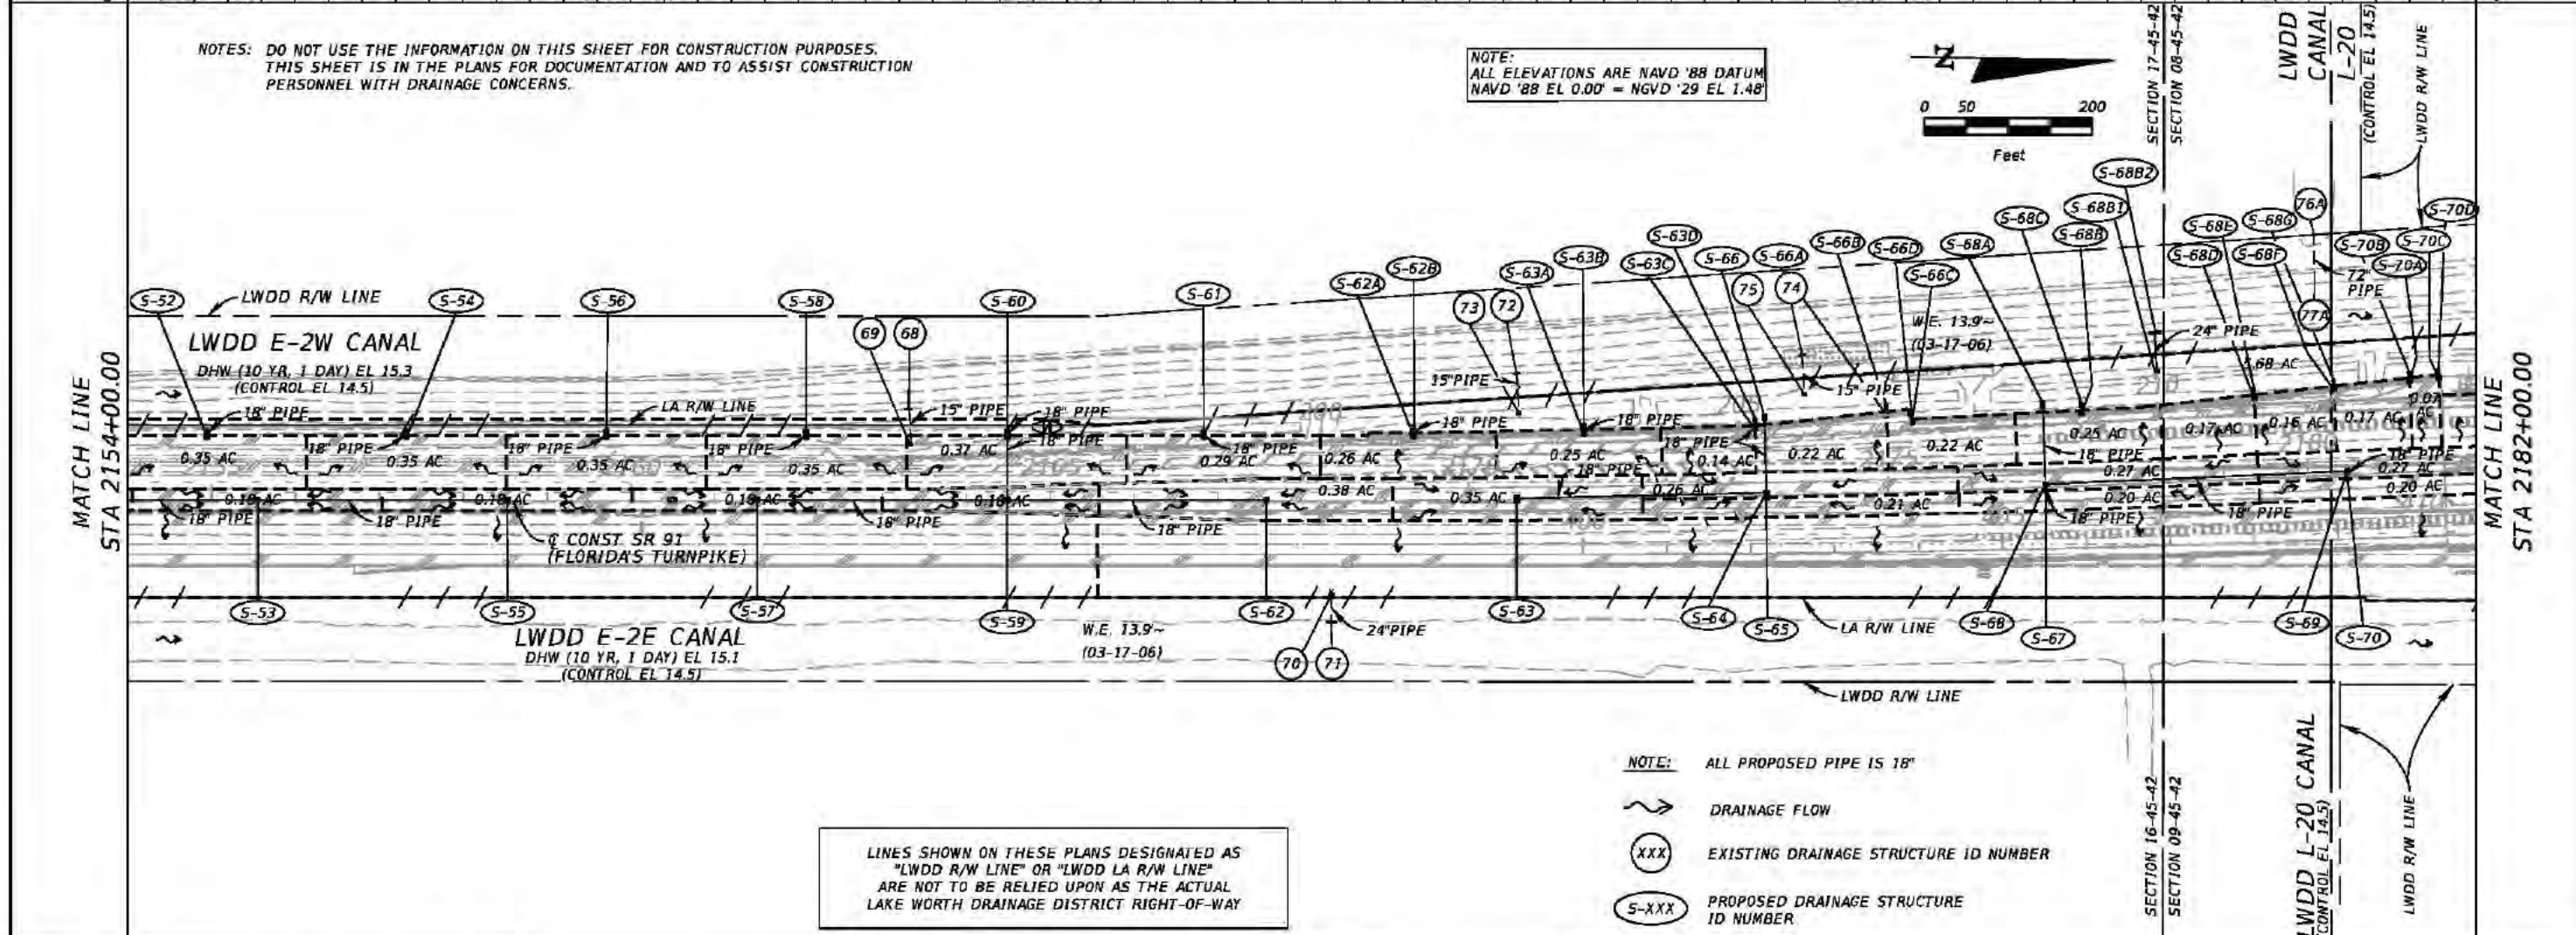
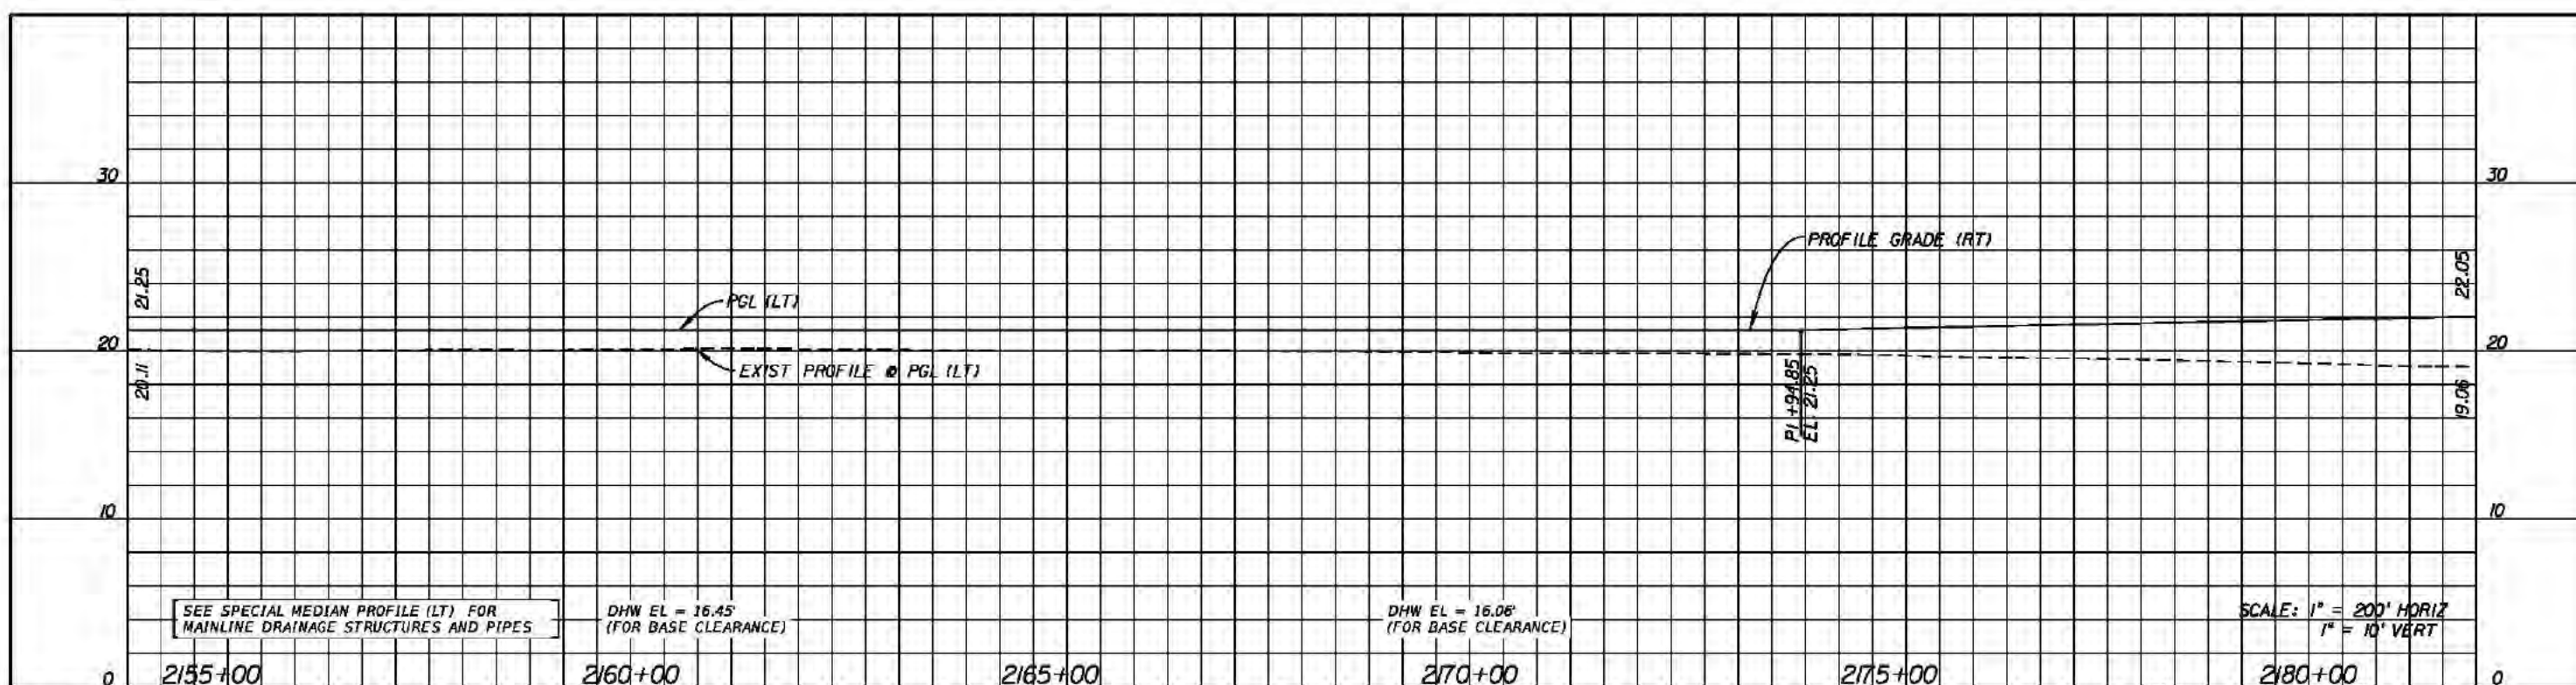


REVISIONS				Kimley-Horn and Associates, Inc. Certificate Of Authorization No. 696 Hooi Gin Ng, P.E. P.E. License No. 58123 1920 Wekiva Way, Suite 200 West Palm Beach, Florida 33411	STATE OF FLORIDA DEPARTMENT OF TRANSPORTATION			DRAINAGE MAP SHEET NO. 5
DATE	DESCRIPTION	DATE	DESCRIPTION		ROAD NO.	COUNTY	FINANCIAL PROJECT ID	
					91	PALM BEACH	406144-1-52-01	

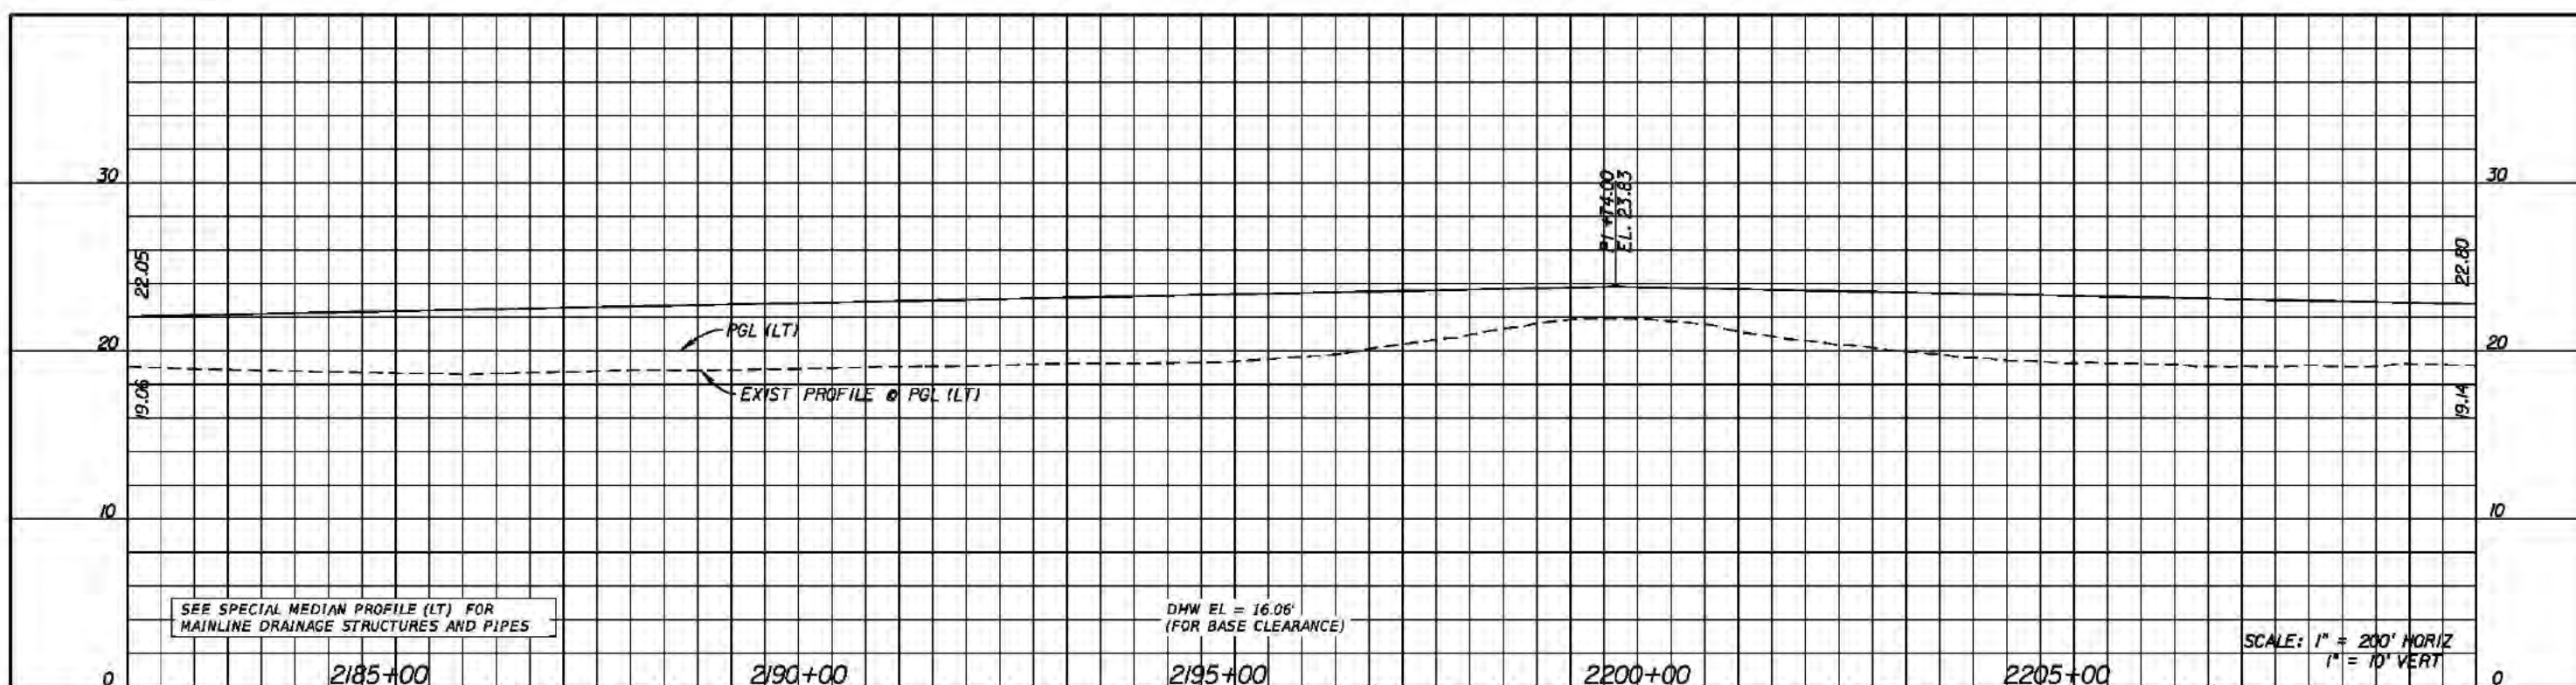


NOTES: DO NOT USE THE INFORMATION ON THIS SHEET FOR CONSTRUCTION PURPOSES. THIS SHEET IS IN THE PLANS FOR DOCUMENTATION AND TO ASSIST CONSTRUCTION PERSONNEL WITH DRAINAGE CONCERNS.

NOTE: ALL ELEVATIONS ARE NAVD '88 DATUM
NAVD '88 EL 0.00' = NGVD '29 EL 1.48'

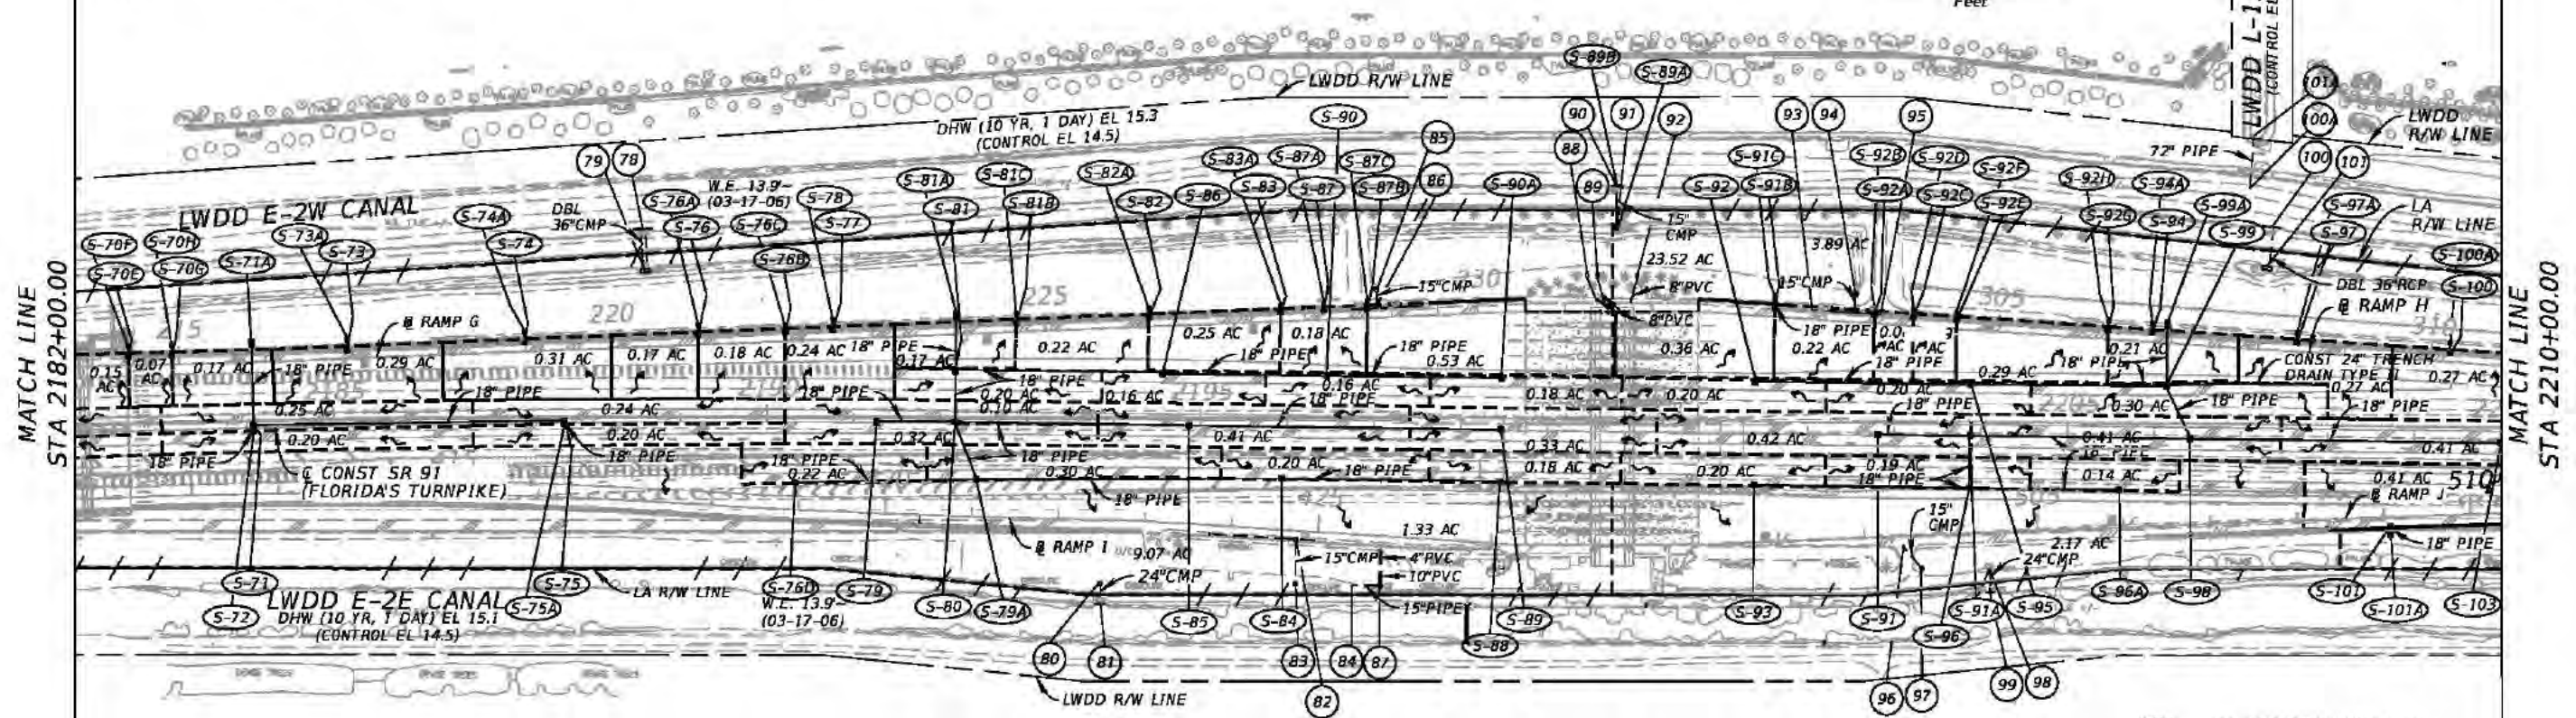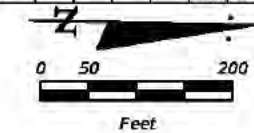



NOTE: ALL PROPOSED PIPE IS 18"
 DRAINAGE FLOW
 EXISTING DRAINAGE STRUCTURE ID NUMBER
 PROPOSED DRAINAGE STRUCTURE ID NUMBER

REVISIONS				Kimley-Horn and Associates, Inc. Certificate Of Authorization No. 696 Hooi Gin Ng, P.E. P.E. License No. 58123 1920 Wekiva Way, Suite 200 West Palm Beach, Florida 33411	STATE OF FLORIDA DEPARTMENT OF TRANSPORTATION			DRAINAGE MAP SHEET NO. 6
DATE	DESCRIPTION	DATE	DESCRIPTION		ROAD NO.	COUNTY	FINANCIAL PROJECT ID	
					91	PALM BEACH	406144-1-52-01	


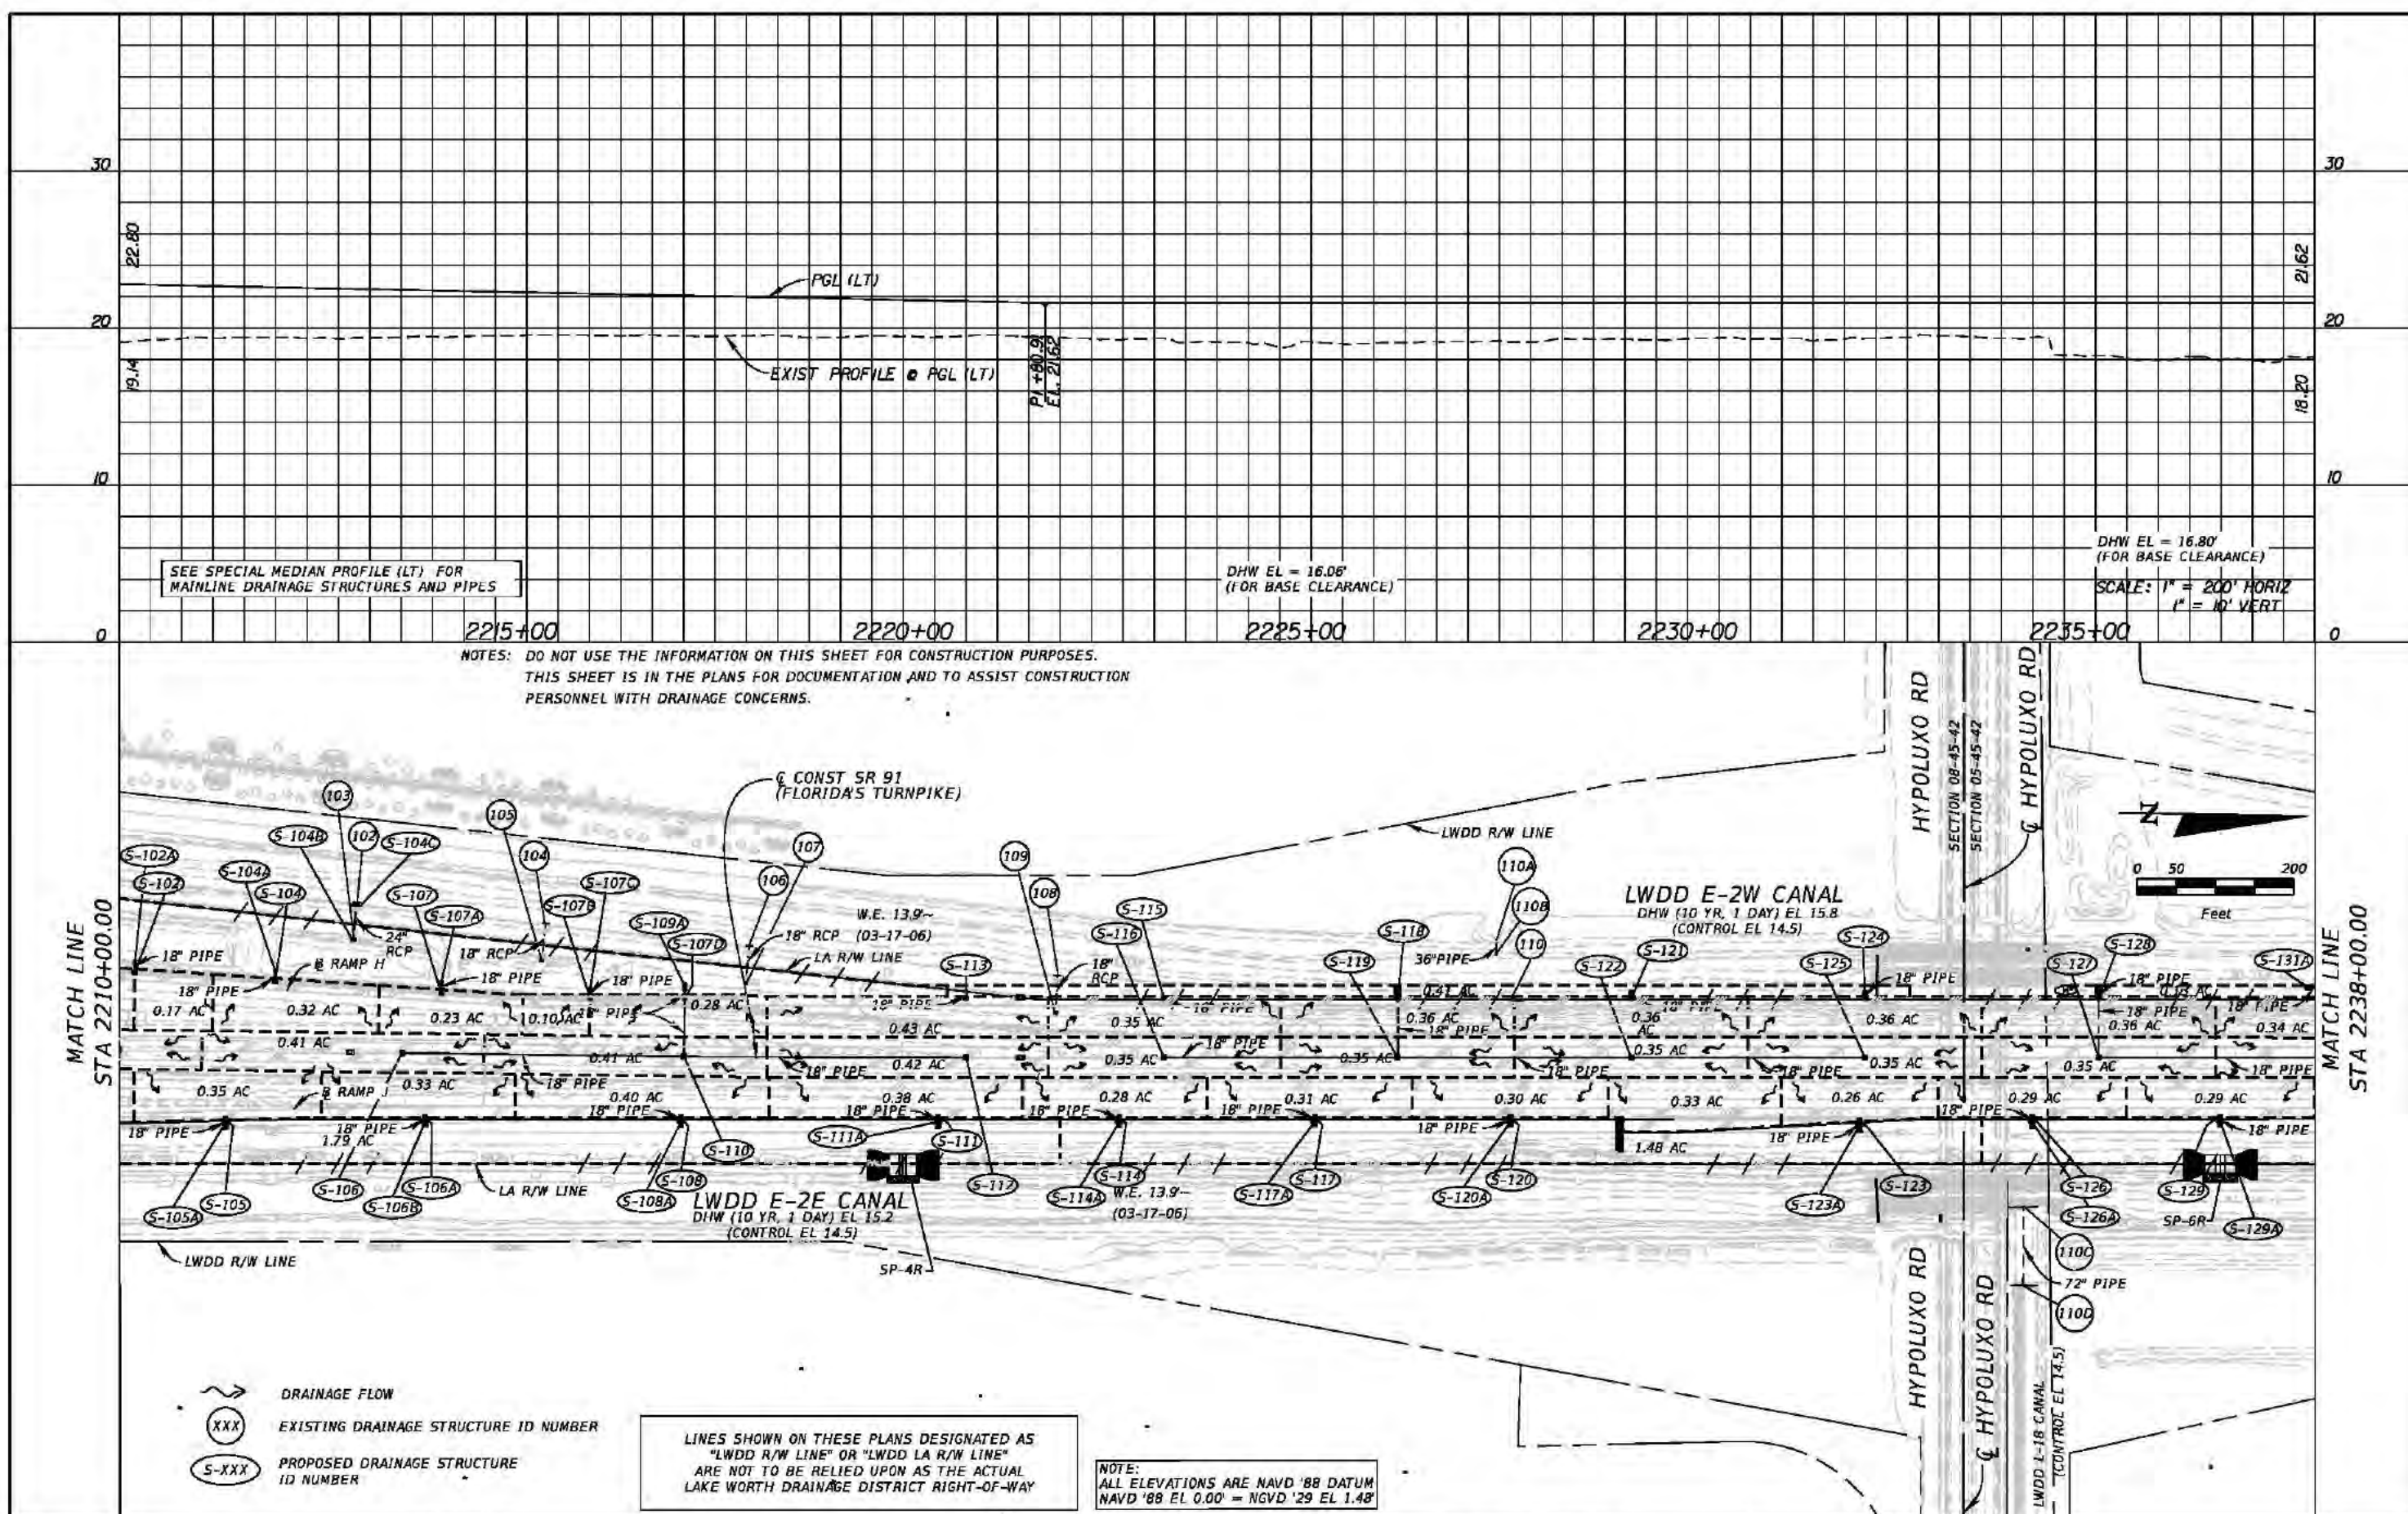


REVISIONS				Kimley-Horn and Associates, Inc. Certificate Of Authorization No. 696 Hooi Gin Ng, P.E. P.E. License No. 58123 1920 Wekiva Way, Suite 200 West Palm Beach, Florida 33411	STATE OF FLORIDA DEPARTMENT OF TRANSPORTATION			SHEET NO. 7
DATE	DESCRIPTION	DATE	DESCRIPTION		ROAD NO.	COUNTY	FINANCIAL PROJECT ID	
					91	PALM BEACH	406144-1-52-01	


DRAINAGE MAP

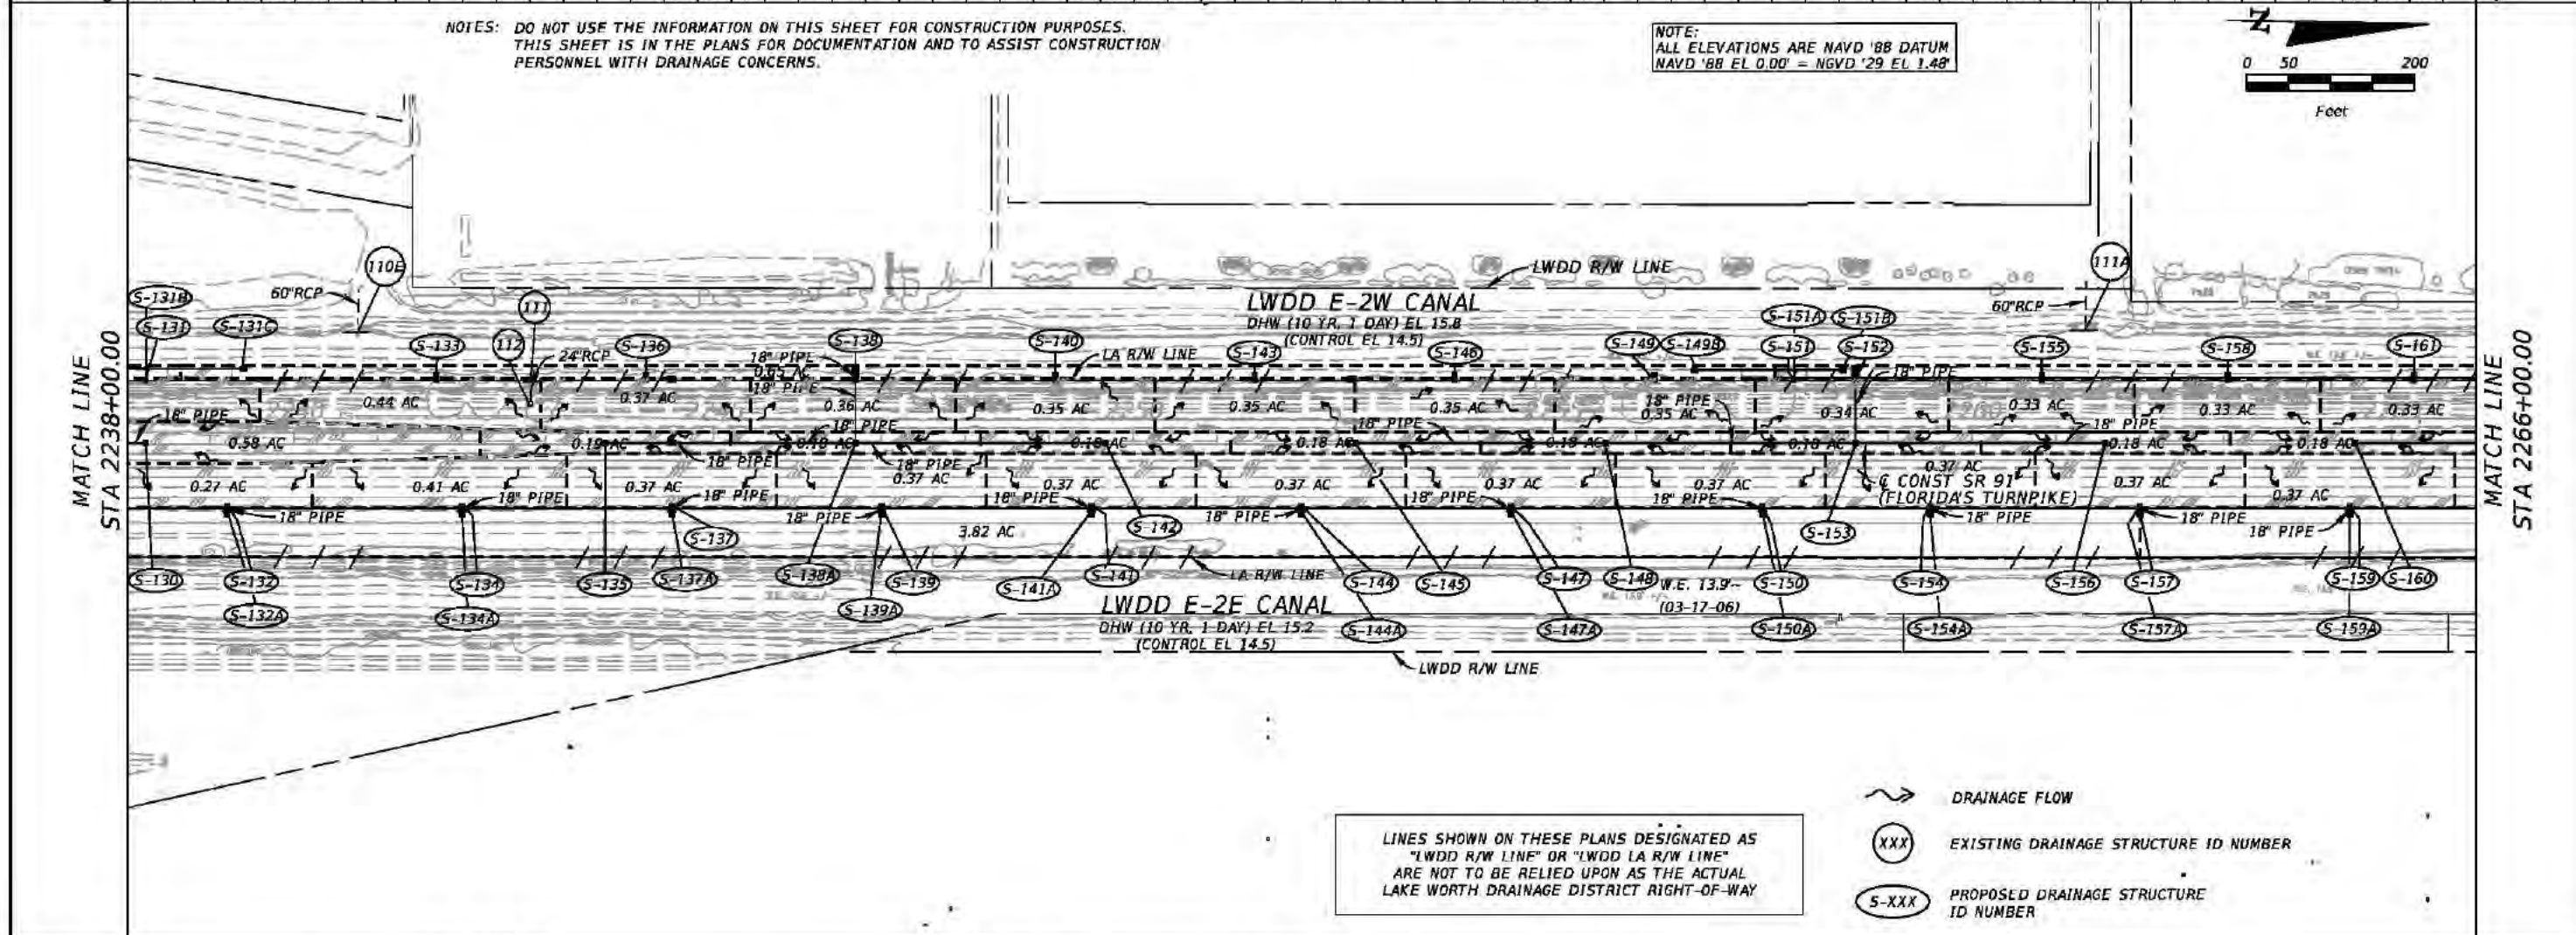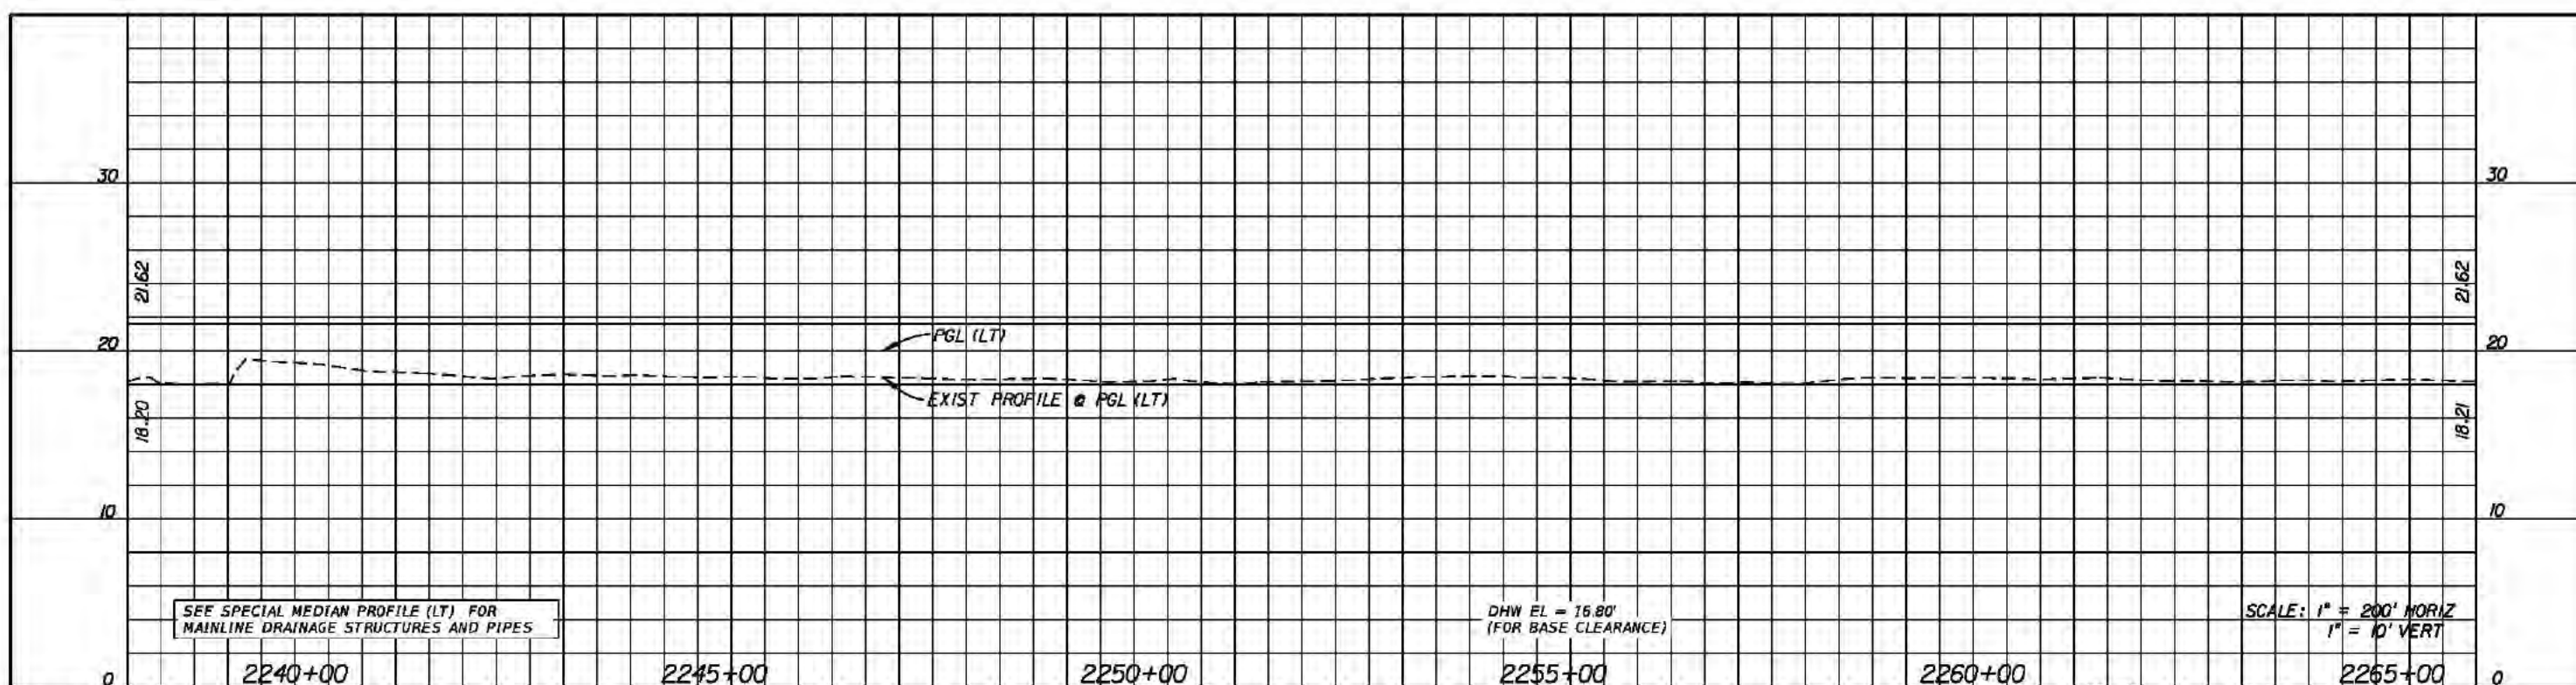


REVISIONS				Kimley-Horn and Associates, Inc. Certificate Of Authorization No. 696 Hooi Gin Ng, P.E. P.E. License No. 58123 1920 Wekiva Way, Suite 200 West Palm Beach, Florida 33411	STATE OF FLORIDA DEPARTMENT OF TRANSPORTATION			DRAINAGE MAP	SHEET NO.
DATE	DESCRIPTION	DATE	DESCRIPTION		ROAD NO.	COUNTY	FINANCIAL PROJECT ID		
					91	PALM BEACH	406144-1-52-01		8

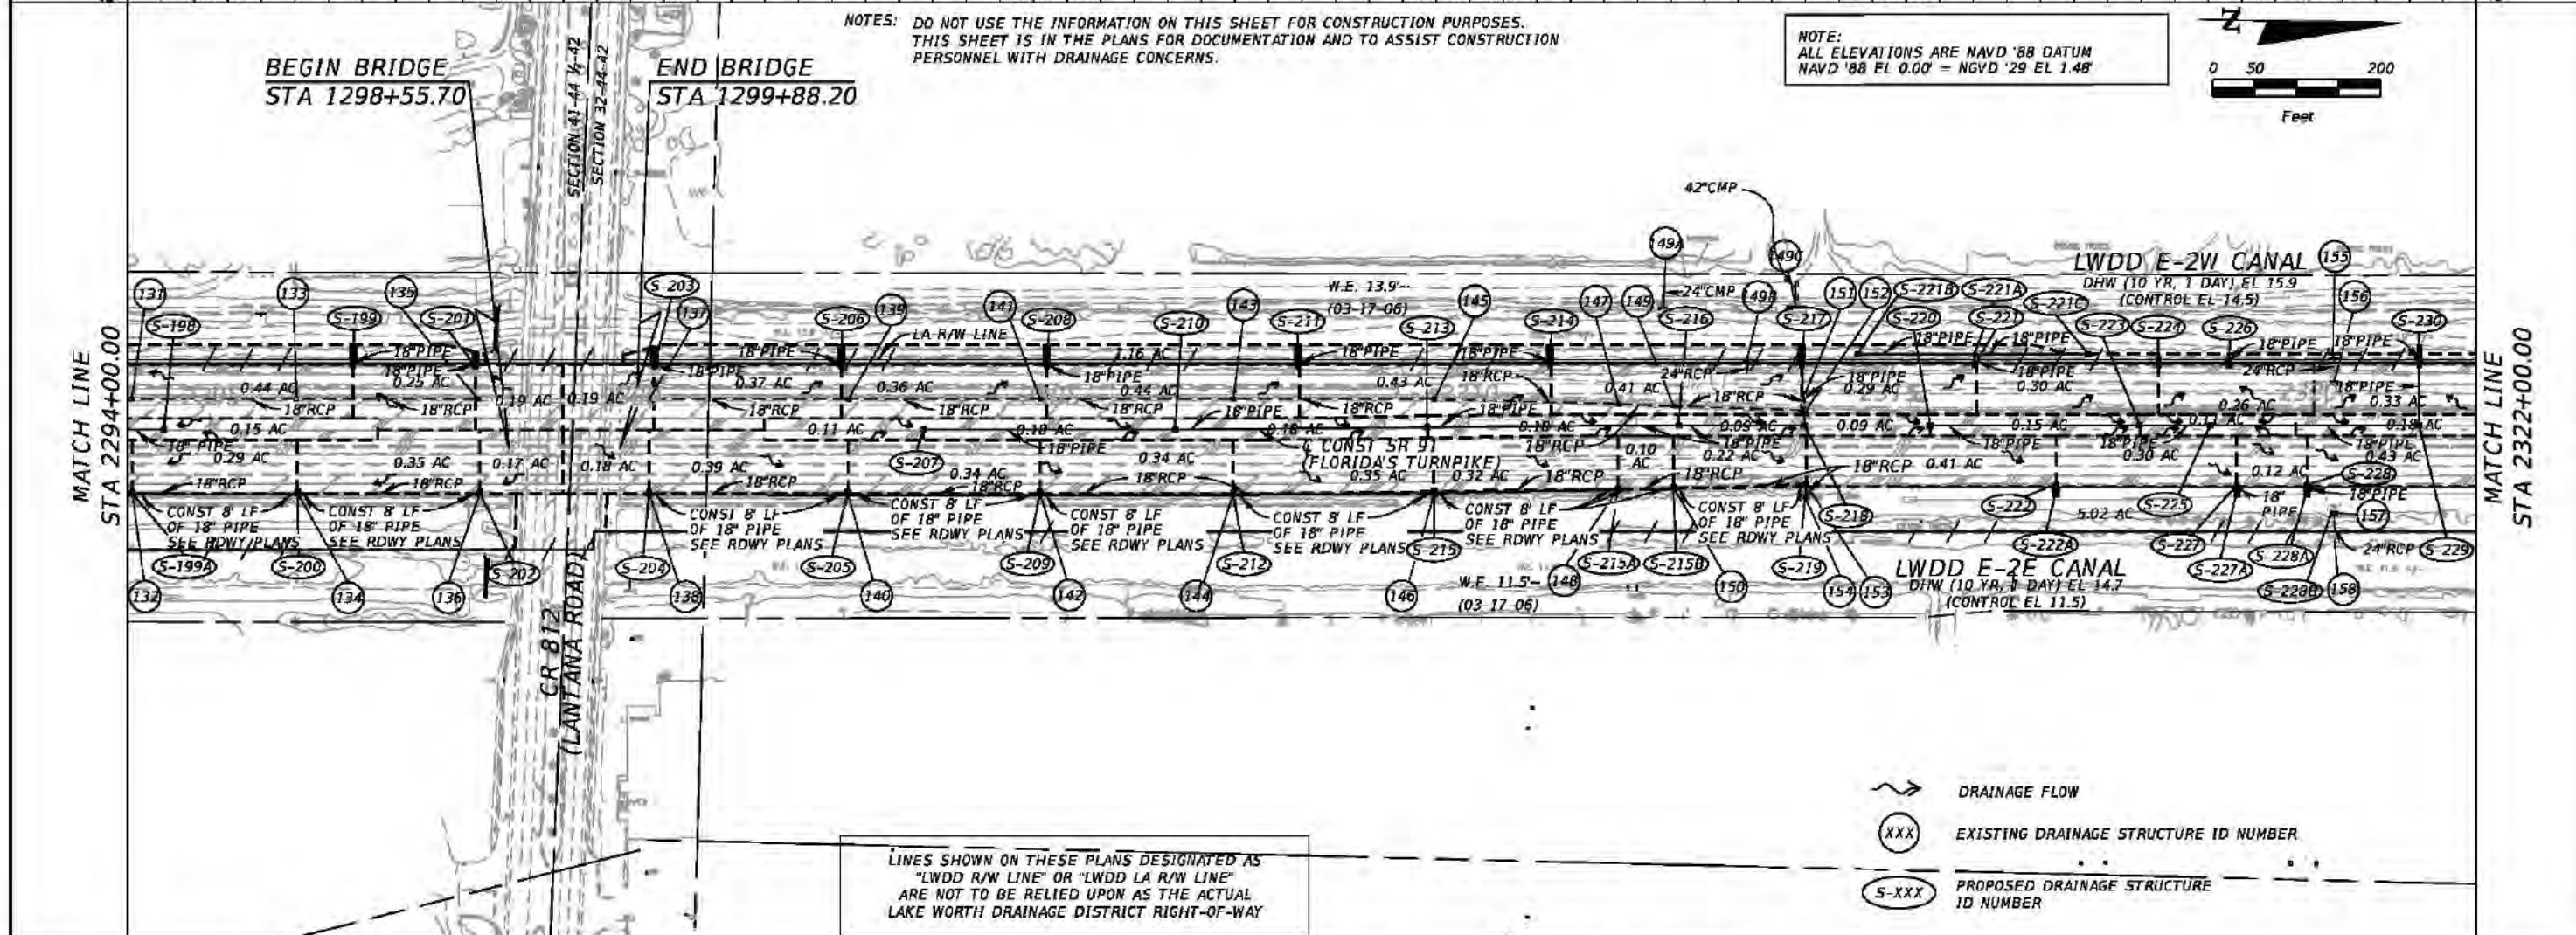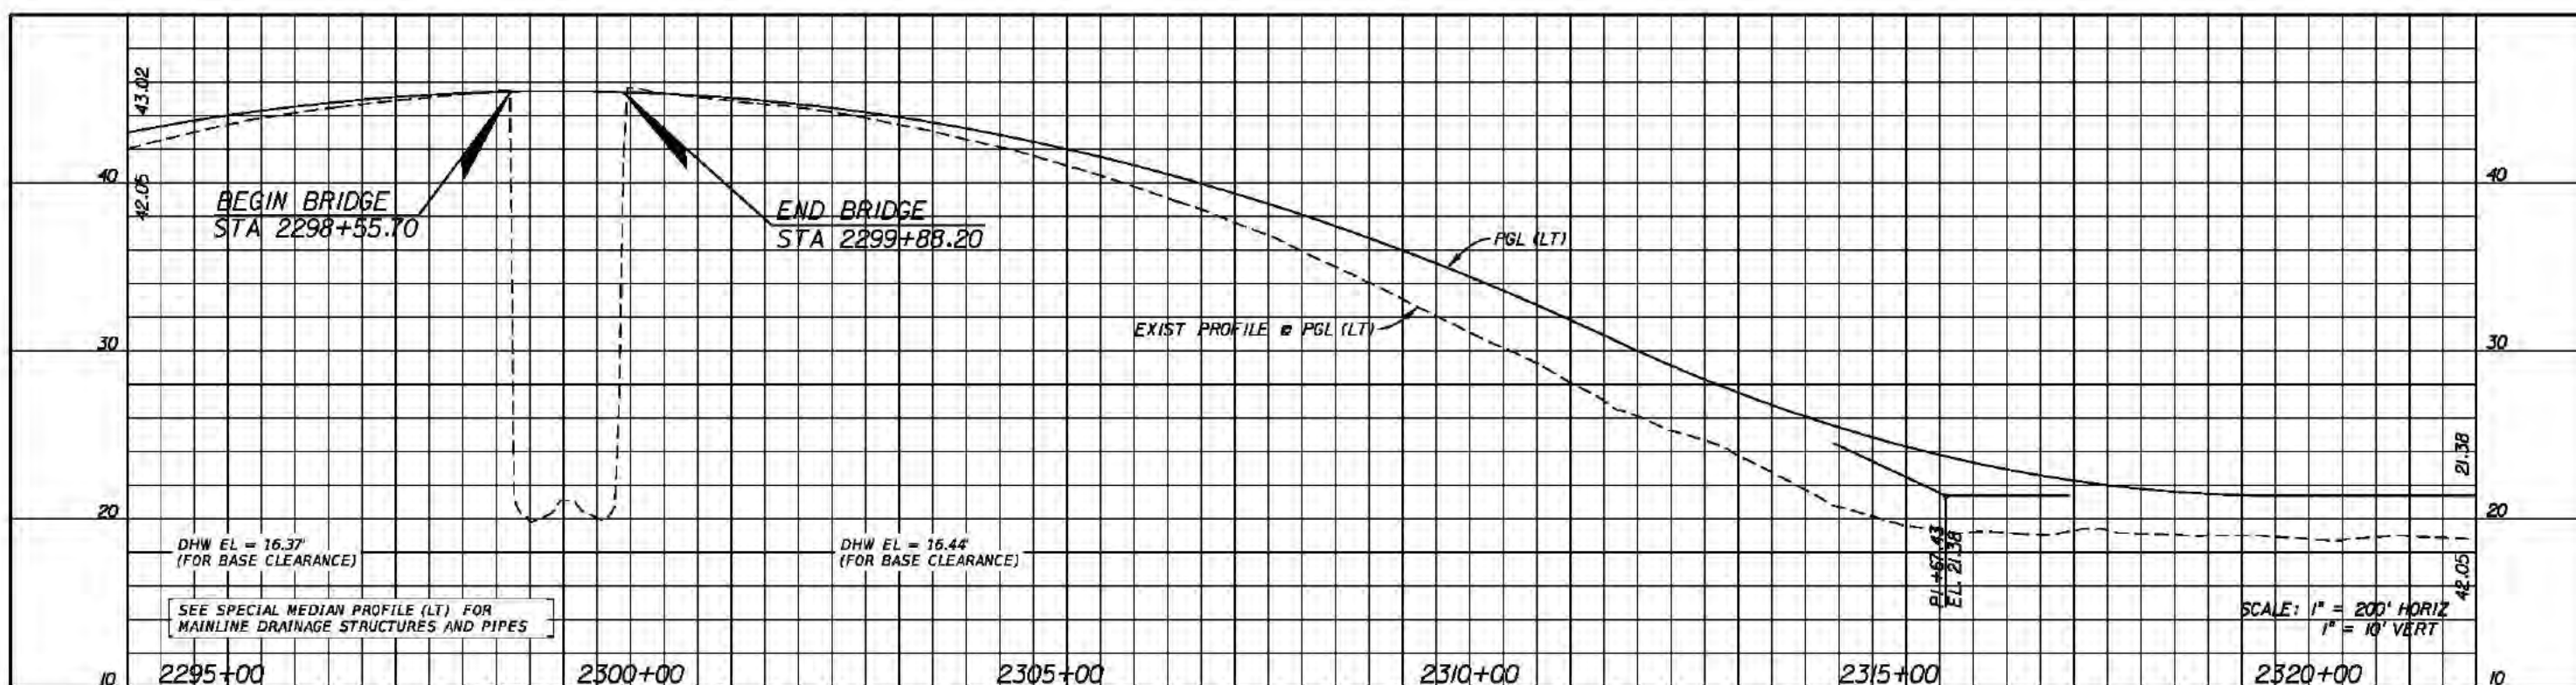

REVISIONS				Kimley-Horn and Associates, Inc. Certificate of Authorization No. 696 Hooi Gin Ng, P.E. P.E. License No. 58123 1920 Wekiva Way, Suite 200 West Palm Beach, Florida 33411	STATE OF FLORIDA DEPARTMENT OF TRANSPORTATION			DRAINAGE MAP SHEET NO. 10
DATE	DESCRIPTION	DATE	DESCRIPTION		ROAD NO.	COUNTY	FINANCIAL PROJECT ID	
					91	PALM BEACH	406144-1-52-01	

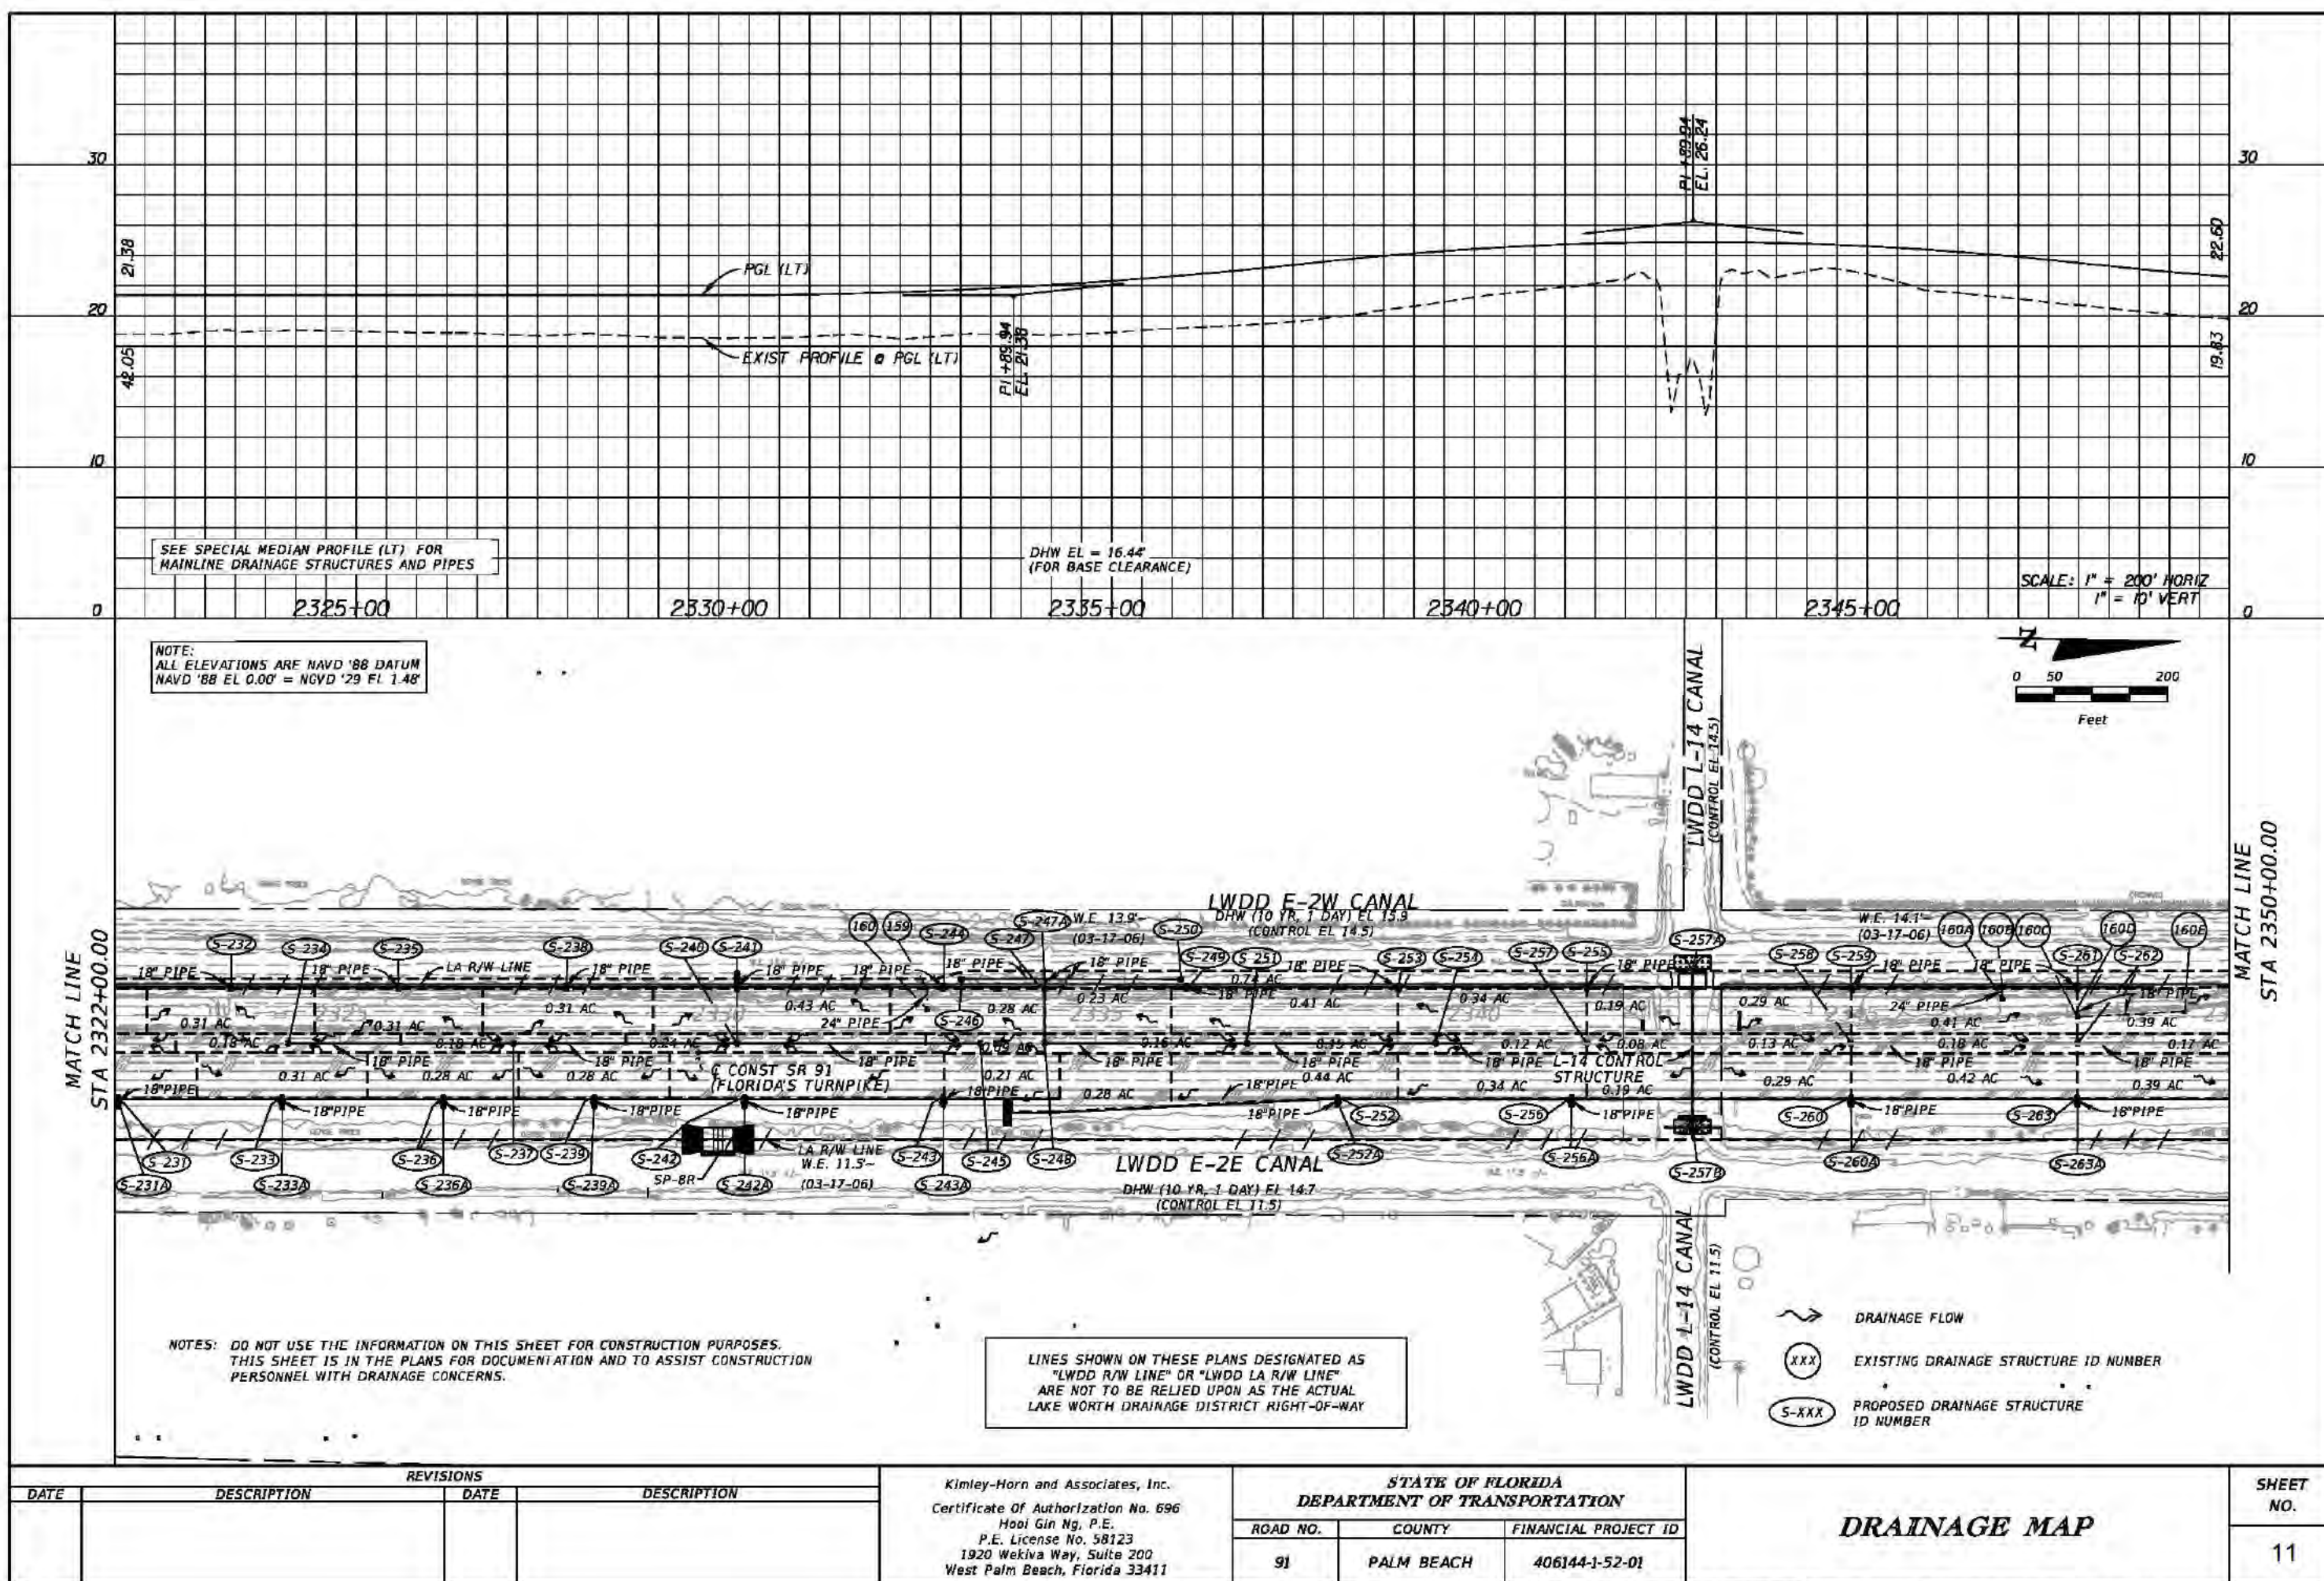

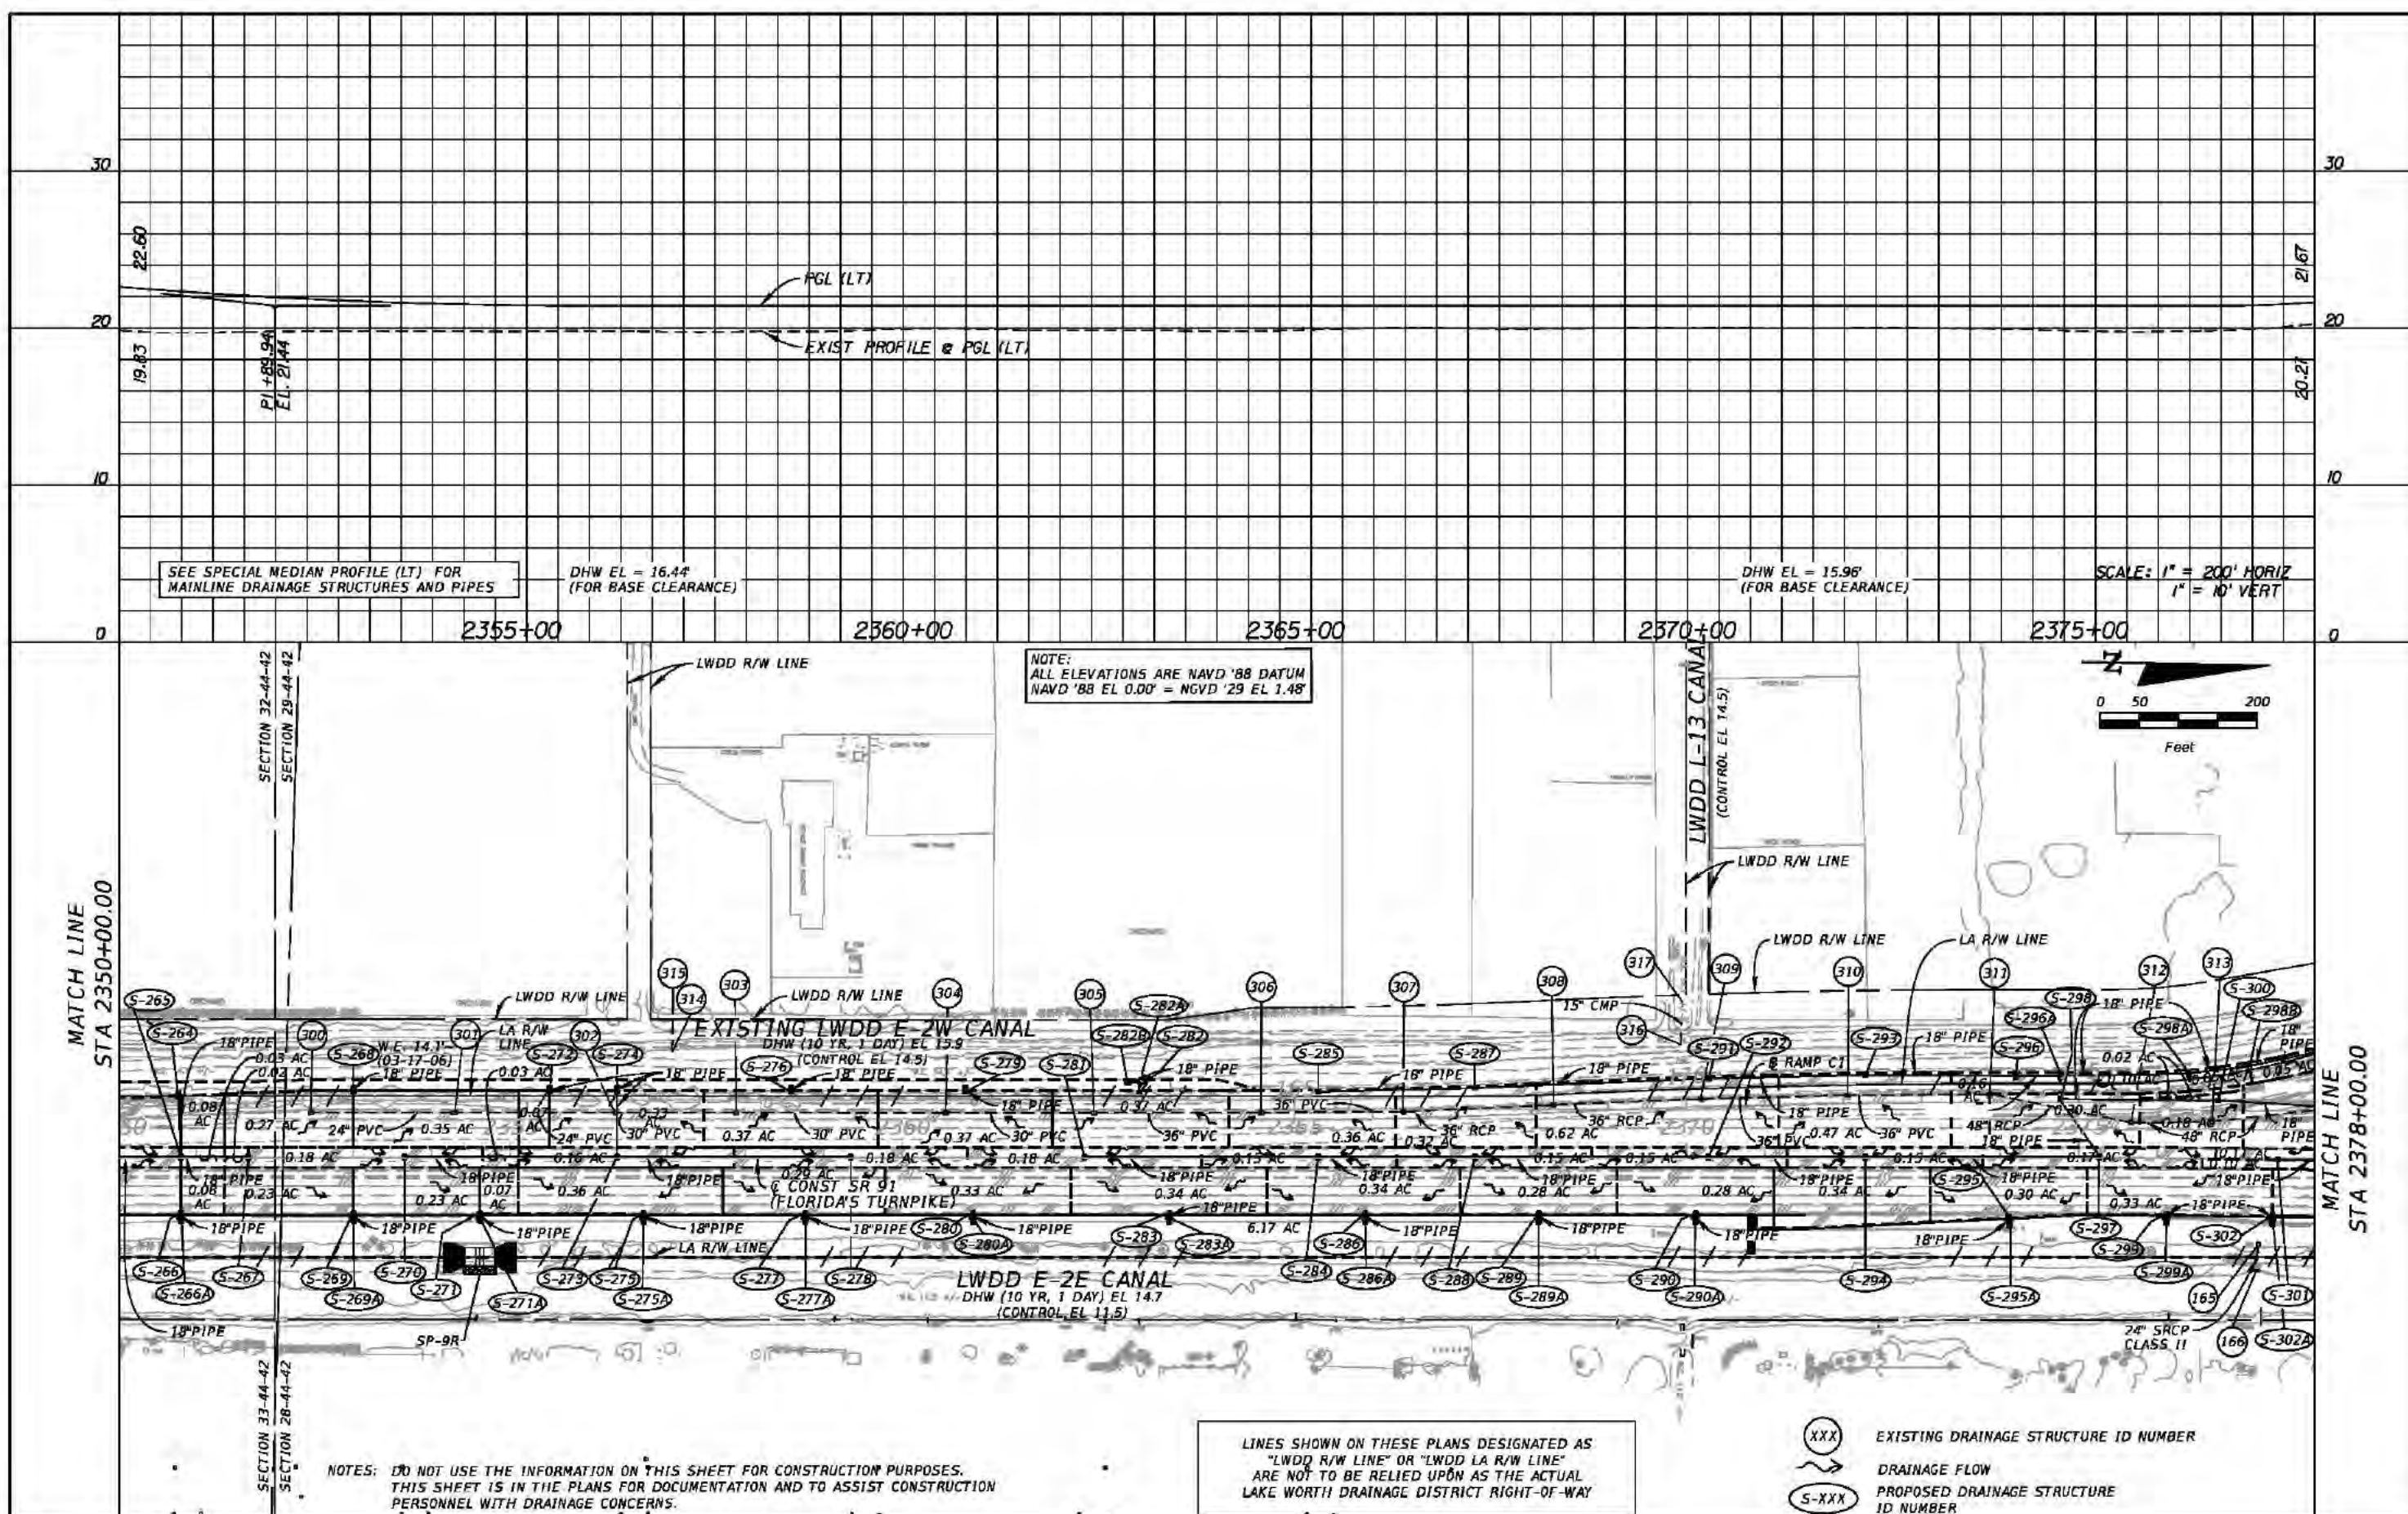


REVISIONS				Kimley-Horn and Associates, Inc. Certificate of Authorization No. 696 Hooi Gin Ng, P.E. P.E. License No. 58123 1920 Wekiva Way, Suite 200 West Palm Beach, Florida 33411	STATE OF FLORIDA DEPARTMENT OF TRANSPORTATION			DRAINAGE MAP	SHEET NO.
DATE	DESCRIPTION	DATE	DESCRIPTION		ROAD NO.	COUNTY	FINANCIAL PROJECT ID		
					91	PALM BEACH	406144-1-52-01		
									12

MATCH LINE
STA 2378+00.00


NOTES:
DO NOT USE THE INFORMATION ON THIS SHEET
FOR CONSTRUCTION PURPOSES. THIS SHEET IS
IN THE PLANS FOR DOCUMENTATION AND TO
ASSIST CONSTRUCTION PERSONNEL WITH
DRAINAGE CONCERNS.

NOTE:
ALL ELEVATIONS ARE NAVD '88 DATUM
NAVD '88 EL 0.00' = NGVD '29 EL 1.48'

MATCH LINE STA 101+00.00

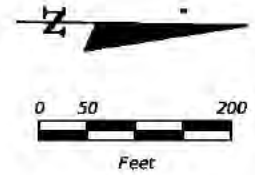

MATCH LINE
STA 2406+00.00

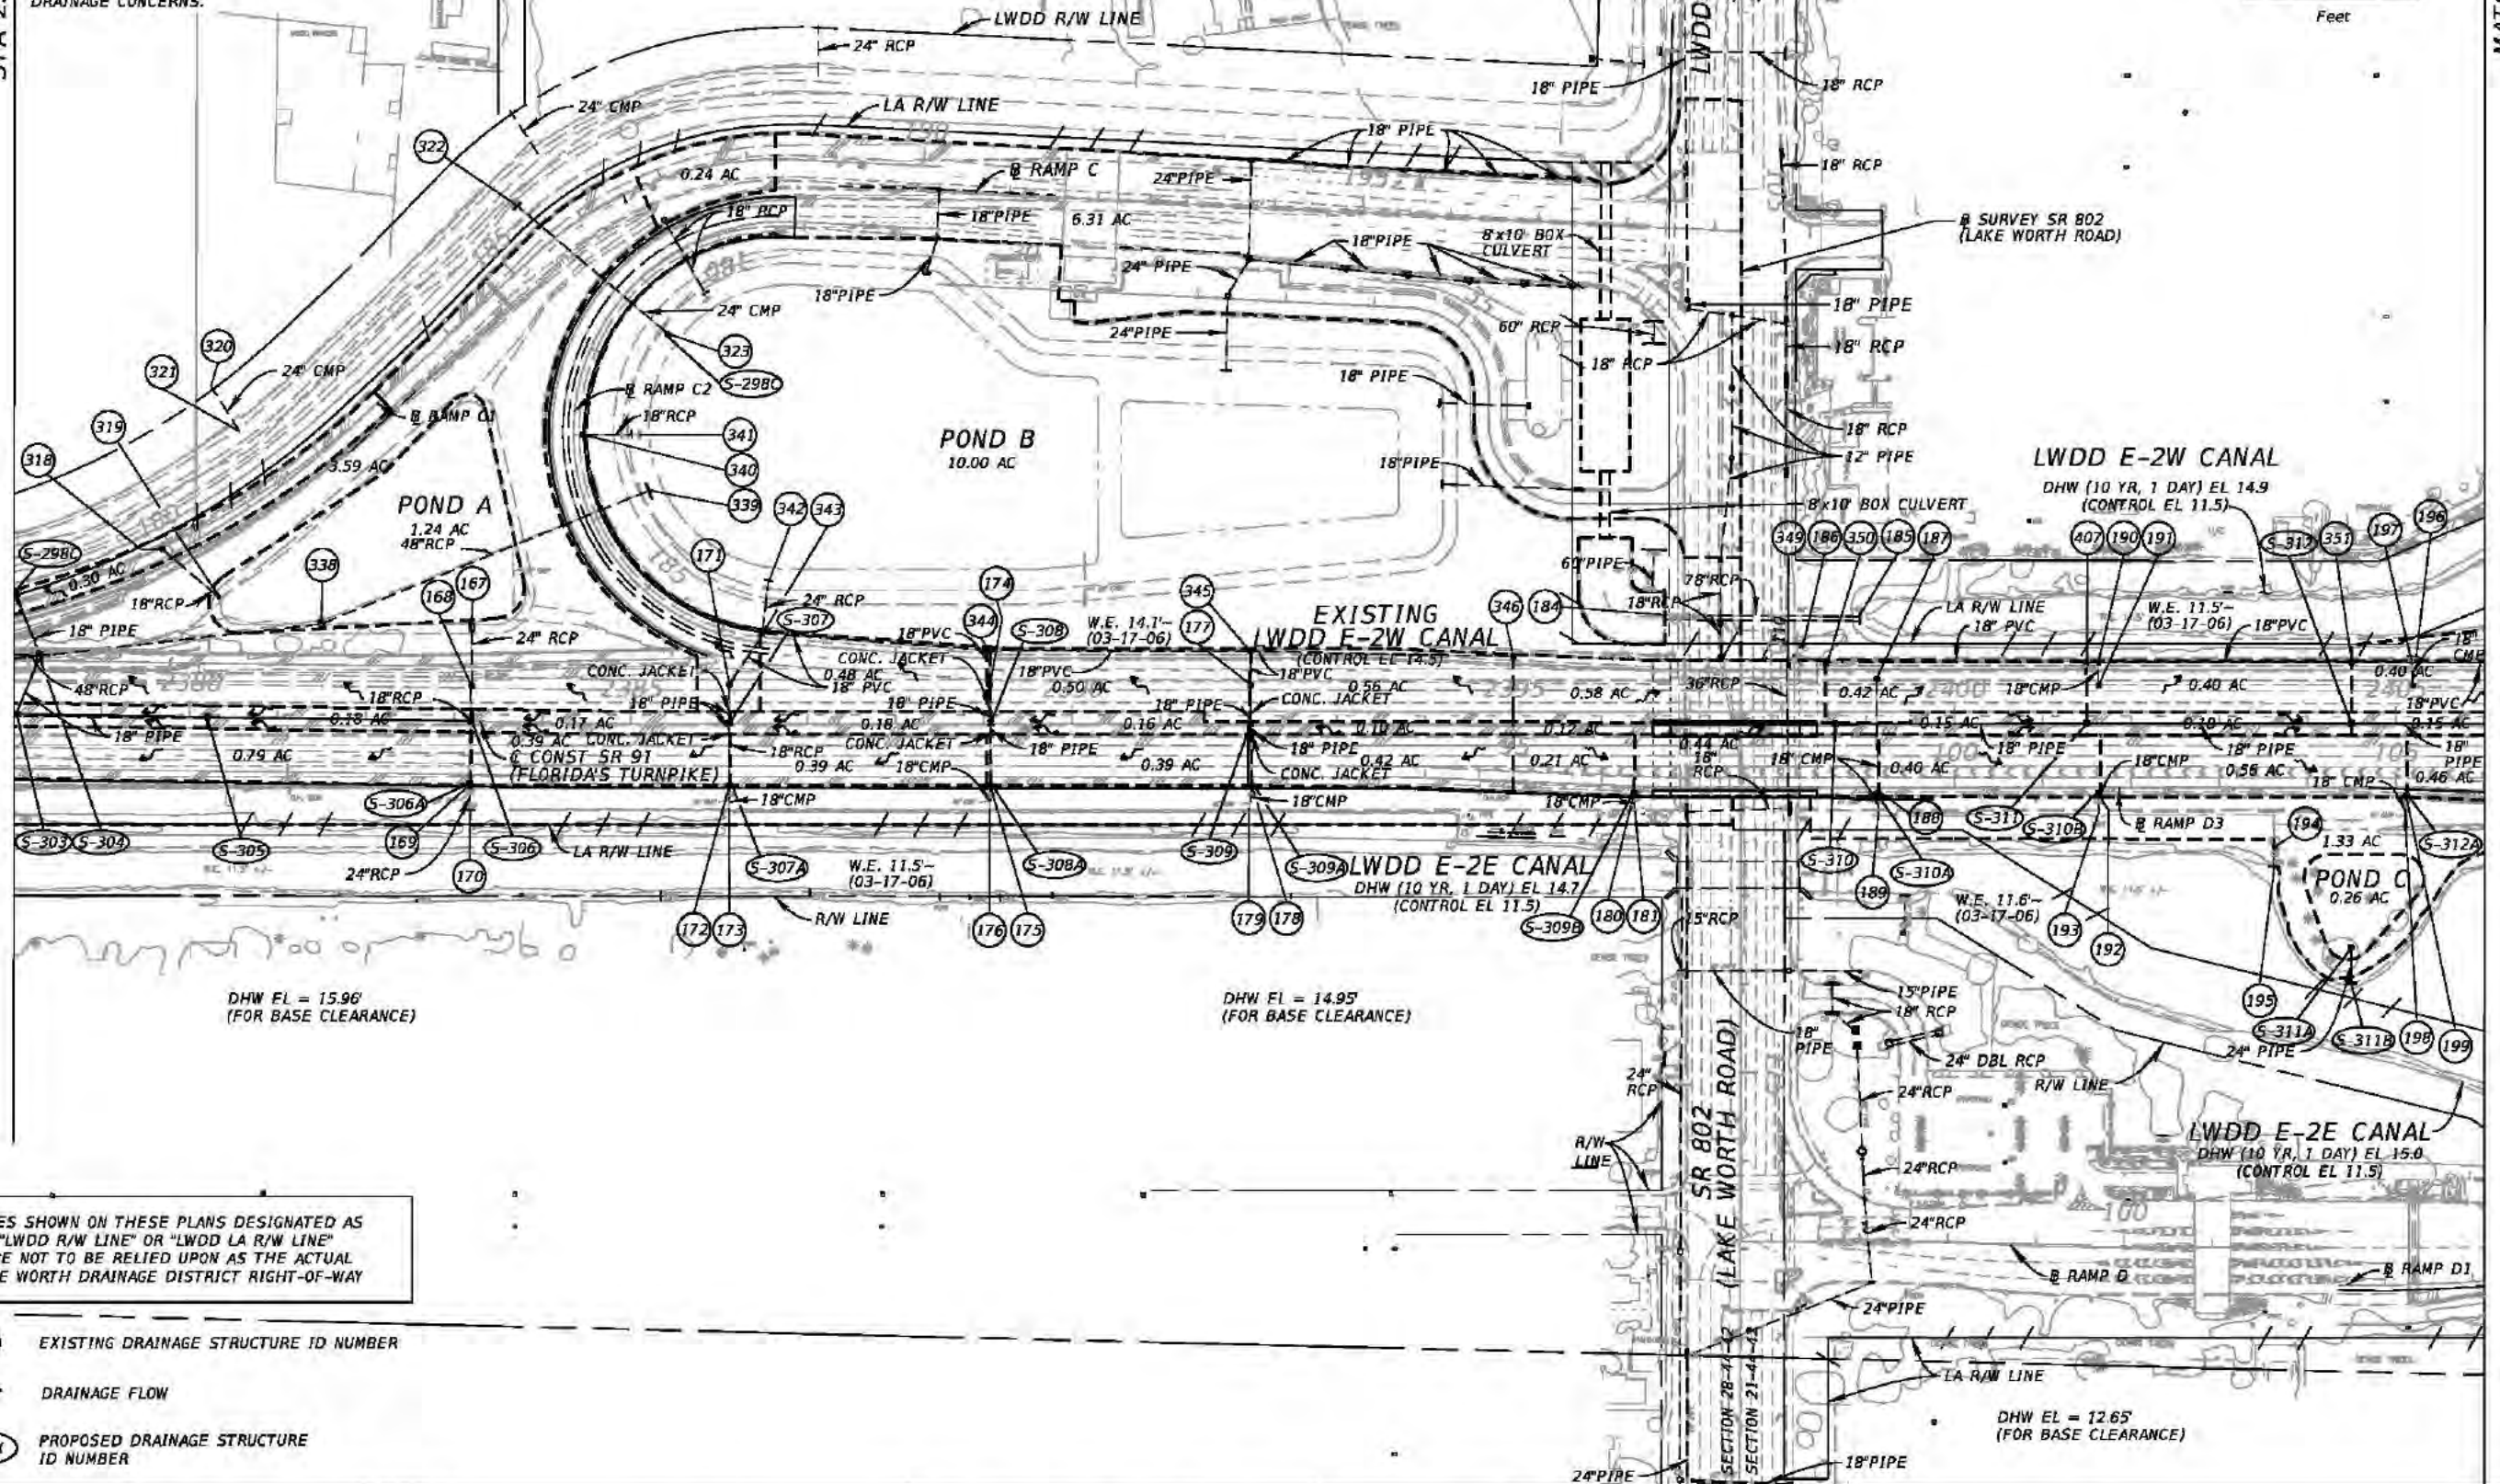

LINES SHOWN ON THESE PLANS DESIGNATED AS
"LWDD R/W LINE" OR "LWDD LA R/W LINE"
ARE NOT TO BE RELIED UPON AS THE ACTUAL
LAKE WORTH DRAINAGE DISTRICT RIGHT-OF-WAY

- (XXX) EXISTING DRAINAGE STRUCTURE ID NUMBER
- ~ DRAINAGE FLOW
- (S-XXX) PROPOSED DRAINAGE STRUCTURE ID NUMBER

REVISIONS				Kimley-Horn and Associates, Inc. Certificate Of Authorization No. 696 Hool Gin Ng, P.E. P.E. License No. 58123 1920 Wekiva Way, Suite 200 West Palm Beach, Florida 33411	STATE OF FLORIDA DEPARTMENT OF TRANSPORTATION			DRAINAGE MAP	SHEET NO. 13
DATE	DESCRIPTION	DATE	DESCRIPTION		ROAD NO.	COUNTY	FINANCIAL PROJECT ID		
					91	PALM BEACH	406144-1-52-01		


MATCH LINE
STA 2406+00.00

NOTES: DO NOT USE THE INFORMATION ON THIS SHEET FOR CONSTRUCTION PURPOSES.
THIS SHEET IS IN THE PLANS FOR DOCUMENTATION AND TO ASSIST CONSTRUCTION
PERSONNEL WITH DRAINAGE CONCERNS.

NOTE:
ALL ELEVATIONS ARE NAVD '88 DATUM
NAVD '88 EL 0.00' = NGVD '29 EL 1.48'



MATCH LINE
STA 2434+00.00

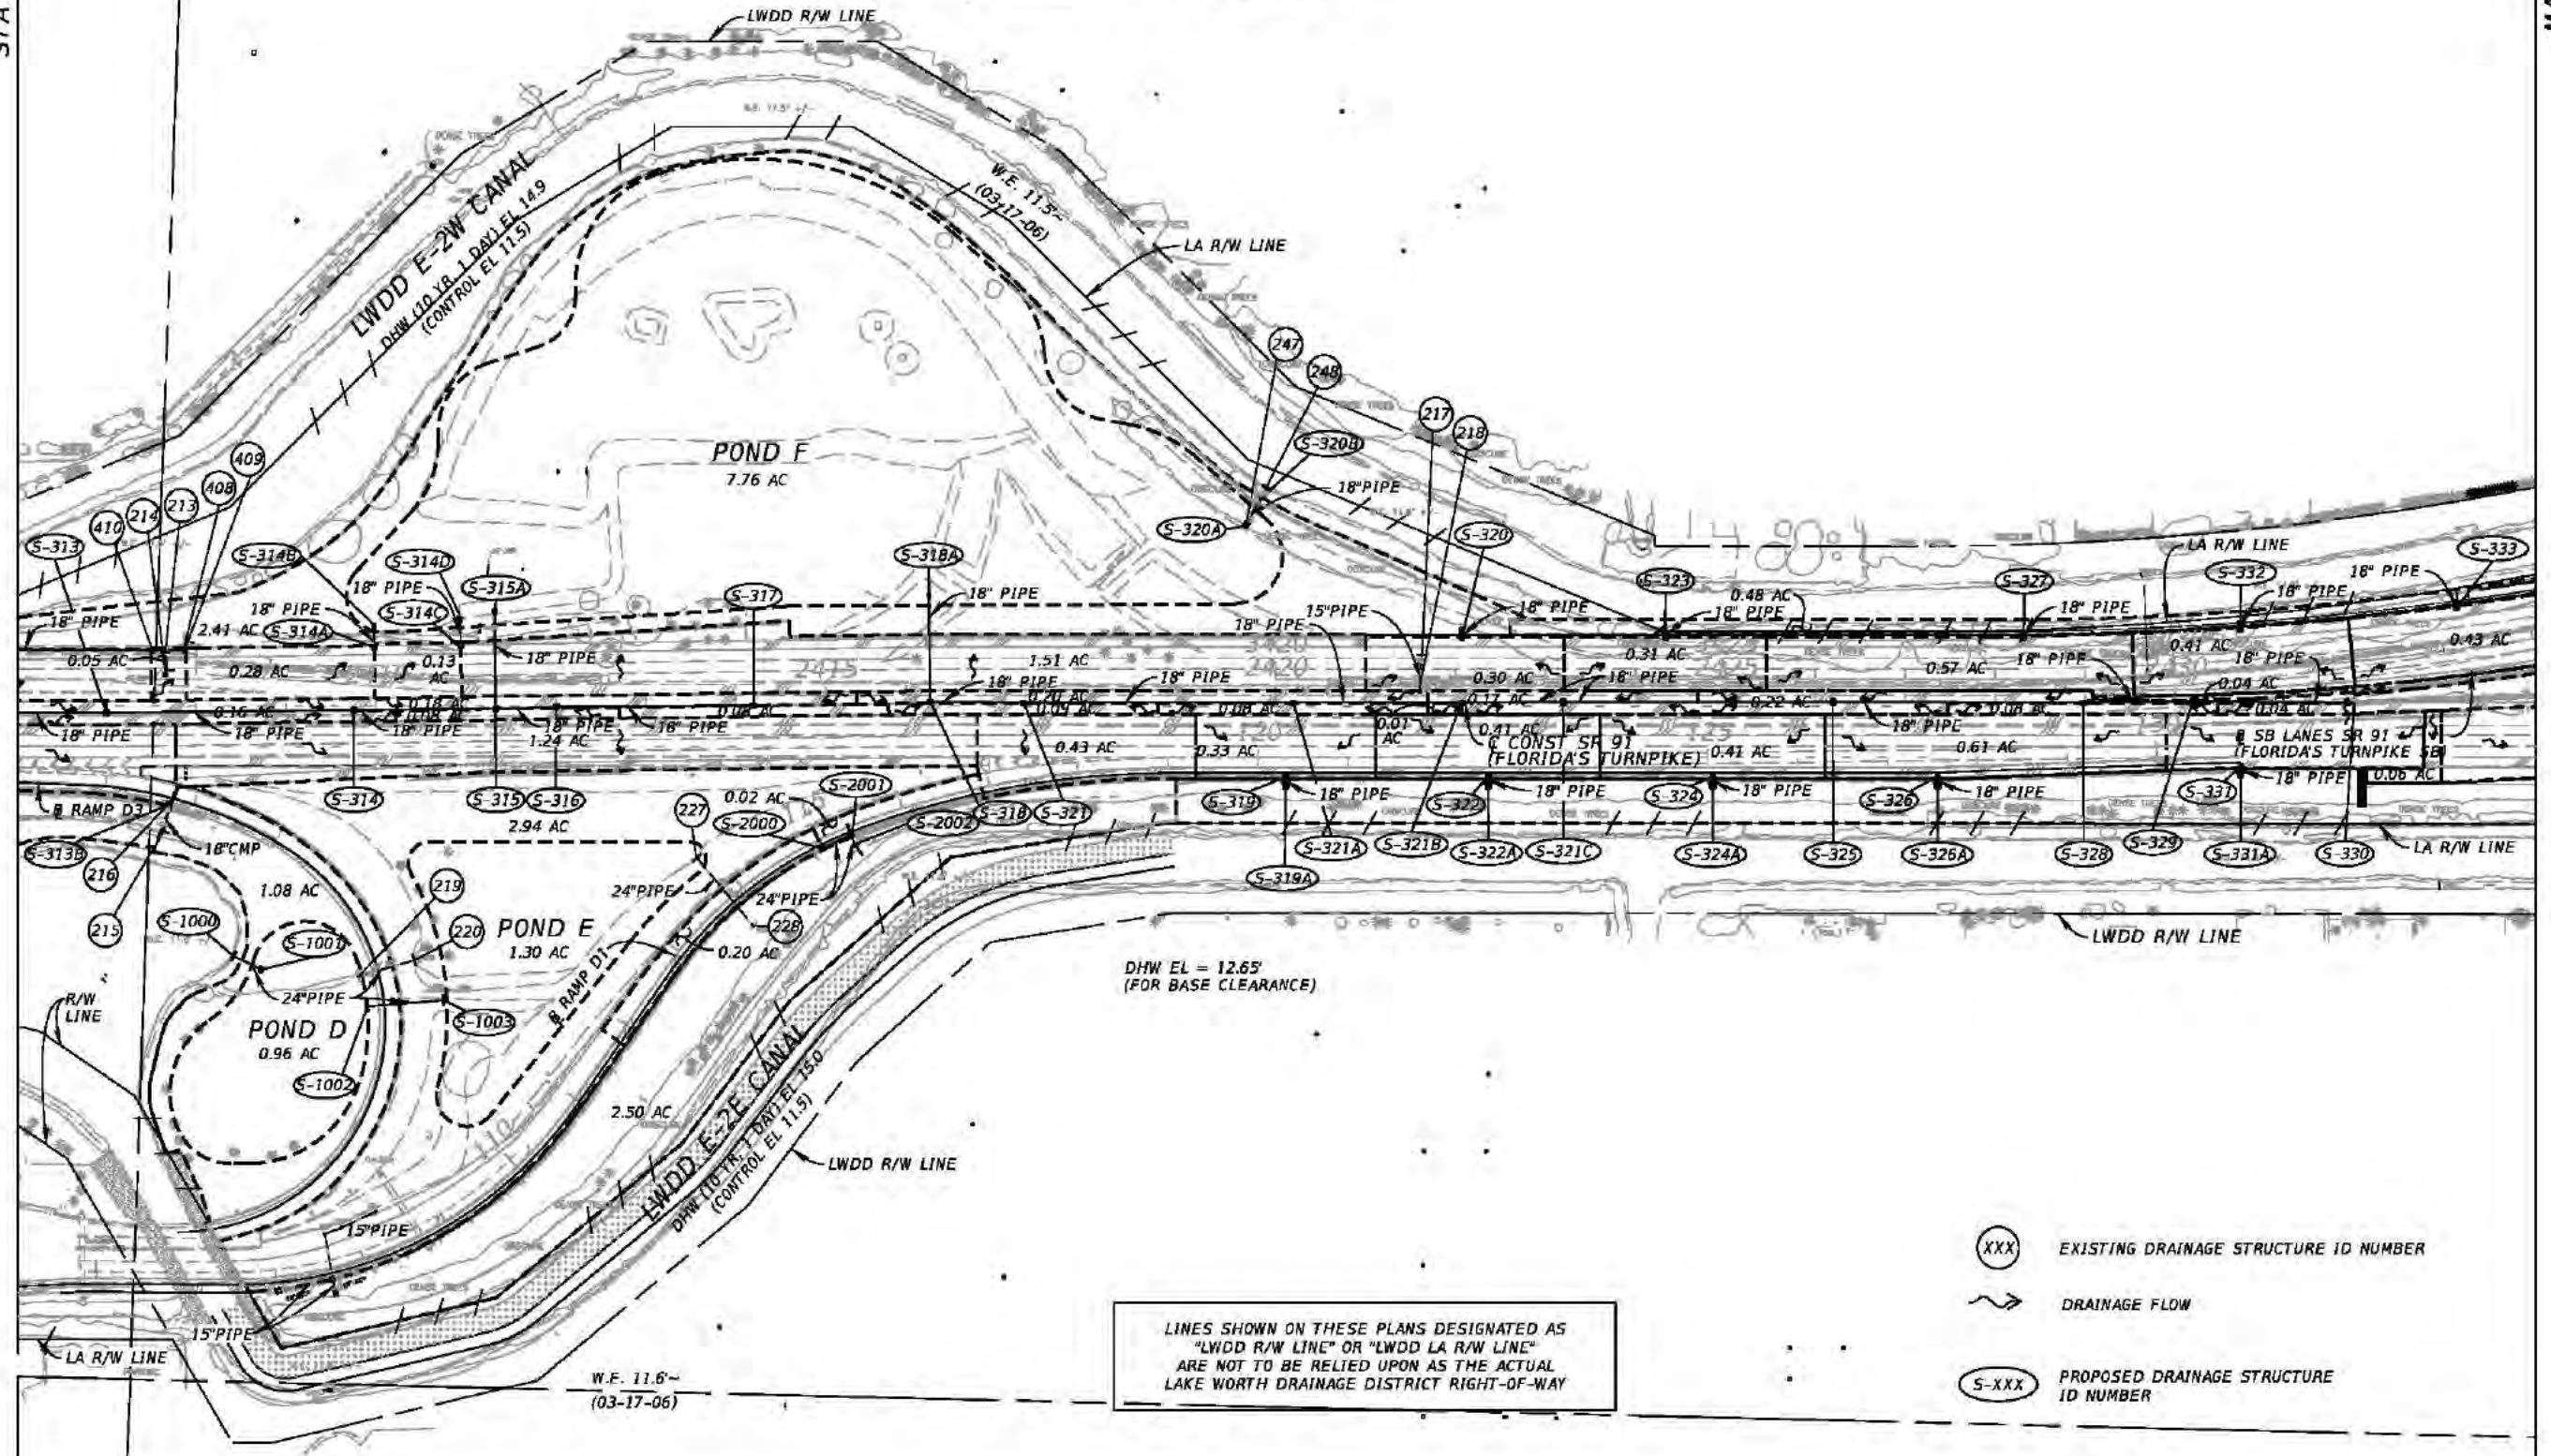


LINES SHOWN ON THESE PLANS DESIGNATED AS
"LWDD R/W LINE" OR "LWDD LA R/W LINE"
ARE NOT TO BE RELIED UPON AS THE ACTUAL
LAKE WORTH DRAINAGE DISTRICT RIGHT-OF-WAY

- XXX EXISTING DRAINAGE STRUCTURE ID NUMBER
- ~ DRAINAGE FLOW
- S-XXX PROPOSED DRAINAGE STRUCTURE ID NUMBER

REVISIONS				Kimley-Horn and Associates, Inc. Certificate Of Authorization No. 696 Hooi Gin Ng, P.E. P.E. License No. 58123 1920 Wekiva Way, Suite 200 West Palm Beach, Florida 33411	STATE OF FLORIDA DEPARTMENT OF TRANSPORTATION			DRAINAGE MAP	SHEET NO. 14
DATE	DESCRIPTION	DATE	DESCRIPTION		ROAD NO.	COUNTY	FINANCIAL PROJECT ID		
					91	PALM BEACH	406144-1-52-01		

sara.lopez 2/3/2017 3:41:08 PM K:\WPB_Design\040195061_TPK_BB_to_LW\40614415201_Realign\drainage\dr_maps\drmapr13.dgn

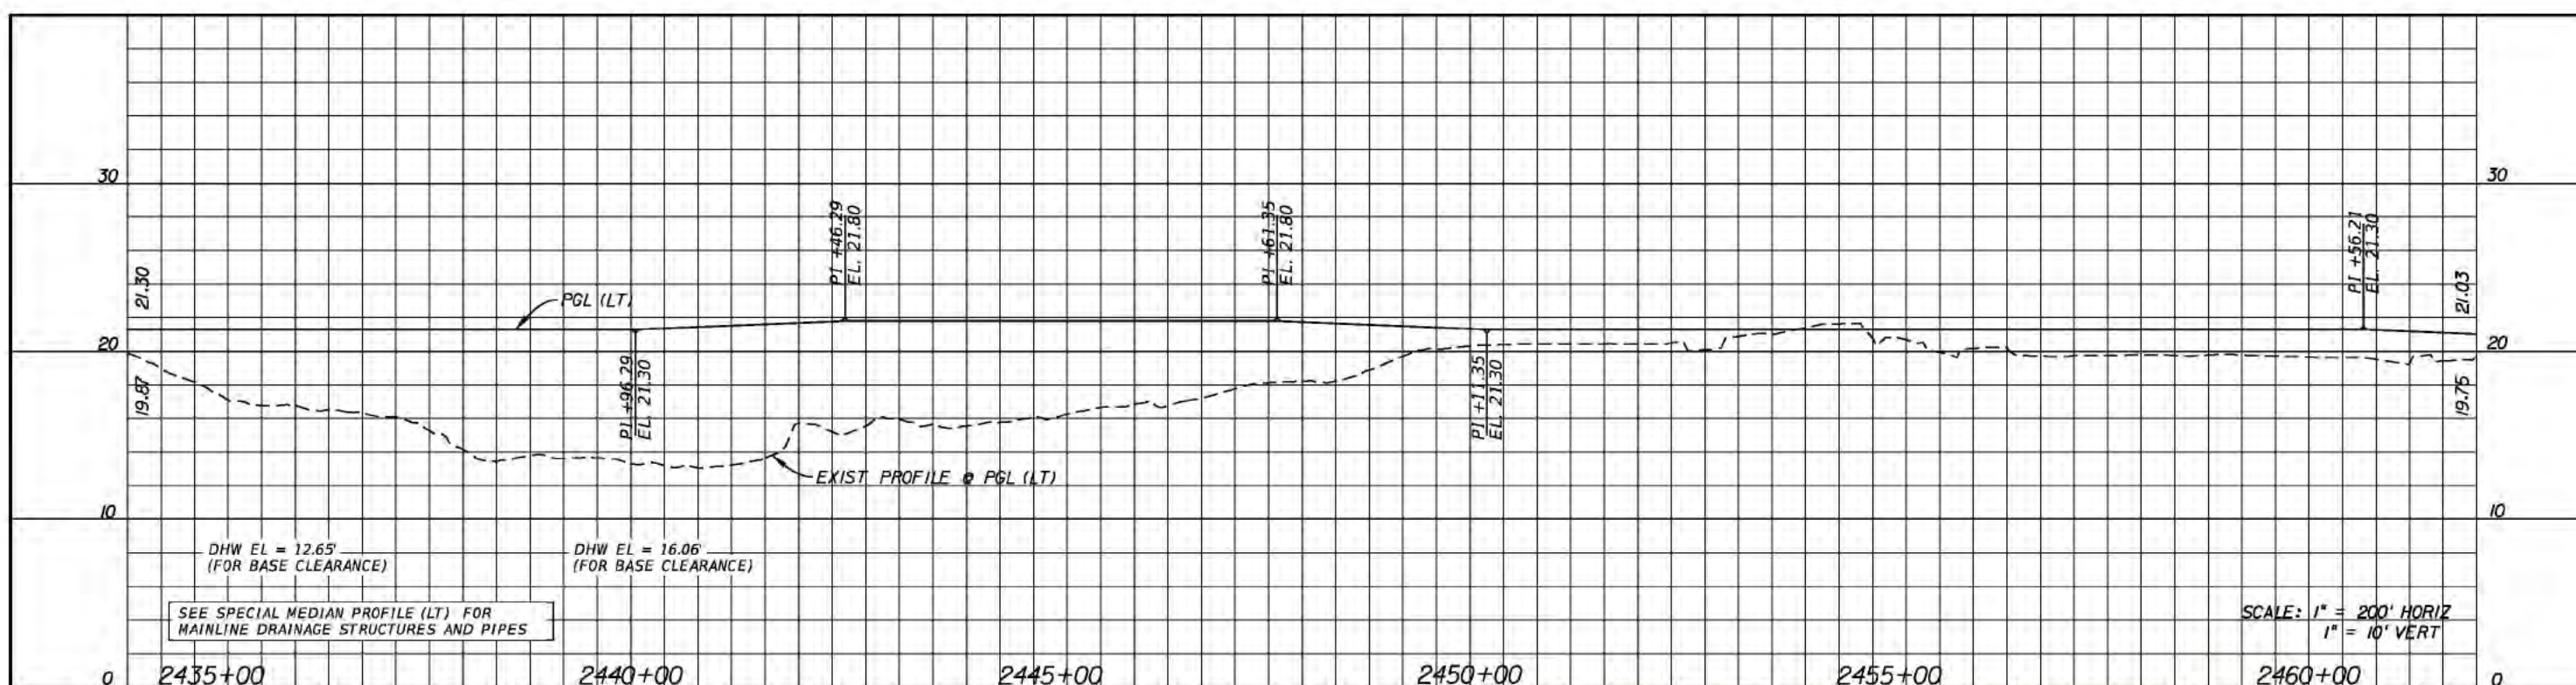


NOTES: DO NOT USE THE INFORMATION ON THIS SHEET FOR CONSTRUCTION PURPOSES. THIS SHEET IS IN THE PLANS FOR DOCUMENTATION AND TO ASSIST CONSTRUCTION PERSONNEL WITH DRAINAGE CONCERNS.

NOTE: ALL ELEVATIONS ARE NAVD '88 DATUM
NAVD '88 EL 0.00' = NGVD '29 EL 1.48'

LINES SHOWN ON THESE PLANS DESIGNATED AS "LWDD R/W LINE" OR "LWDD LA R/W LINE" ARE NOT TO BE RELIED UPON AS THE ACTUAL LAKE WORTH DRAINAGE DISTRICT RIGHT-OF-WAY

- XXX EXISTING DRAINAGE STRUCTURE ID NUMBER
- DRAINAGE FLOW
- S-XXX PROPOSED DRAINAGE STRUCTURE ID NUMBER

MATCH LINE
STA 2434+00.00

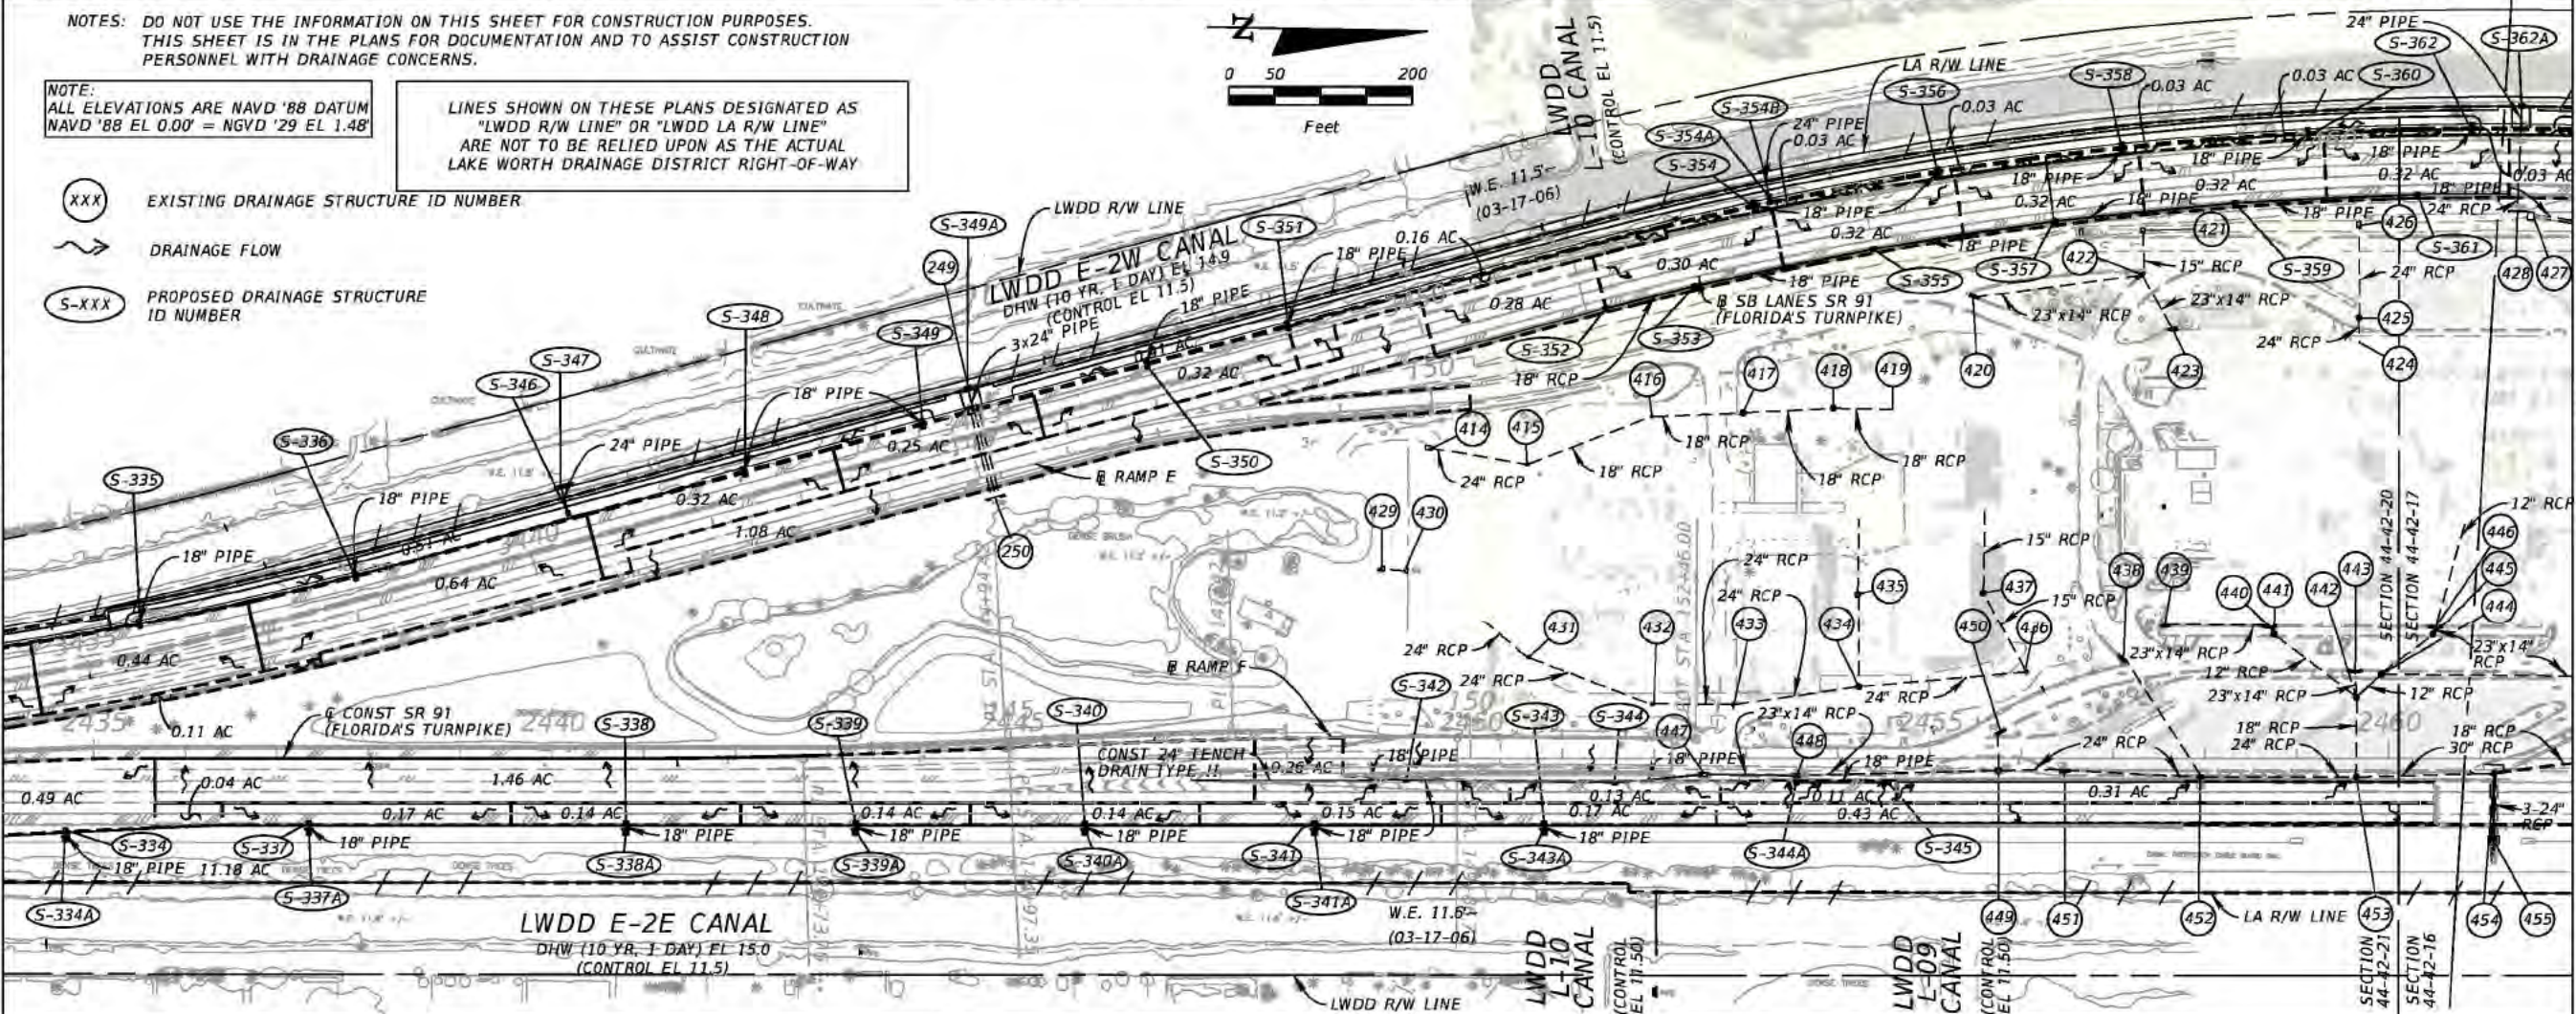

MATCH LINE
STA 2462+00.00

REVISIONS				Kimley-Horn and Associates, Inc. Certificate Of Authorization No. 696 Hooi Gin Ng, P.E. P.E. License No. 58123 1920 Wekiva Way, Suite 200 West Palm Beach, Florida 33411	STATE OF FLORIDA DEPARTMENT OF TRANSPORTATION			DRAINAGE MAP SHEET NO. 15
DATE	DESCRIPTION	DATE	DESCRIPTION		ROAD NO.	COUNTY	FINANCIAL PROJECT ID	
					91	PALM BEACH	406144-1-52-01	

- 1 INLET -
GRATE EL = 42.08
E FL = 37.88 (12" RCP)
- 2 INLET -
GRATE EL = 43.14
W FL = 37.74 (18" RCP)
N FL = 37.74 (18" RCP)
- 3 INLET -
GRATE EL = 42.98
N FL = 38.83 (18" RCP)
- 4 INLET -
GRATE EL = 40.42
E FL = 36.42 (12" RCP)
- 5 INLET -
GRATE EL = 41.37
W FL = 36.10 (18" RCP)
N FL = 36.10 (18" RCP)
S FL = 36.10 (18" RCP)
- 6 INLET -
GRATE EL = 41.48
N FL = 37.33 (18" PIP)
S FL = 37.40 (18" RCP)
- 7 INLET -
GRATE EL = 37.53
E FL = 33.58 (12" RCP)
- 8 INLET -
GRATE EL = 38.62
W FL = 33.22 (18" RCP)
N FL = 33.22 (18" RCP)
S FL = 33.22 (18" RCP)
- 9 INLET -
GRATE EL = 38.71
N FL = 34.76 (18" RCP)
S FL = 34.76 (18" RCP)
- 10 INLET -
GRATE EL = 33.41
E FL = 29.51 (12" RCP)
- 11 INLET -
GRATE EL = 35.51
W FL = 29.16 (24" RCP)
N FL = 28.96 (24" RCP)
S FL = 28.96 (24" RCP)
- 12 INLET -
GRATE EL = 32.38
N FL = 27.73 (24" RCP)
S FL = 27.73 (24" RCP)
- 13 MH -
TOP EL = 31.90
N FL = 27.50 (18" RCP)
S FL = 27.53 (18" RCP)

- 14 INLET -
GRATE EL = 29.73
N FL = 24.73 (24" RCP)
S FL = 24.73 (24" RCP)
- 17 BWI -
GRATE EL = 35.33
N FL = 31.48 (18" RCP)
S FL = 31.53 (18" RCP)
- 18 JB -
TOP EL = 22.30 (UNDER PAVT)
N FL = 17.36 (18" RCP)
S FL = 17.46 (18" RCP)
- 19 JB -
TOP EL = 21.00 (UNDER PAVT)
S FL = 17.30 (18" RCP)
E FL = 17.30 (18" RCP)
- 20 INLET -
GRATE EL = 22.68
W FL = 17.78 (24" RCP)
S FL = 17.78 (24" RCP)
- 21 GUTTER INLET -
GRATE EL = 22.12
W FL = 17.20 (18" RCP)
E FL = 17.20 (24" RCP)
S FL = 17.20 (24" RCP)
- 22 MES -
W FL = 17.00 (24" RCP)
- 23 INLET -
GRATE EL = 22.69
E FL = 18.41 (24" RCP)
- 24 BWI -
GRATE EL = 25.10
N FL = 20.30 (24" RCP)
- 25 INLET -
GRATE EL = 20.85
S FL = 13.77 (24" RCP)
N FL = 13.75 (18" RCP)
- 26 DBI -
GRATE EL = 18.70
SLOT EL = 18.20
V-NOTCH EL = 16.00
E FL = 14.00 (24" RCP)

- 27 EW -
W FL = 13.88 (24" RCP)
- 28 MES -
N FL = 17.00 (18" RCP)
- 29 MES -
S FL = 17.00 (18" RCP)
- 30 EW WEIR -
NOTCH FL = 15.24
- 31 INLET -
GRATE EL = 15.91
E FL = 12.33 (18" PIPE)
- 32 MH -
TOP EL 19.05
S FL = 14.62 (18" RCP)
E FL = 13.13 (24" RCP)
- 33 DBI -
GRATE EL = 18.70
SLOT EL = 18.20
E FL = 14.00 (24" RCP)
- 34 EW -
W FL = 13.88 (24" RCP)
- 35 U TYPE EW W/BAFFLES -
E FL = 13.88 (18" PIPE)
- 36 GUTTER INLET -
GRATE EL = 21.71
W FL = 17.40 (18" PIPE)
N FL = 17.40 (18" PIPE)
- 37 BWI -
GRATE EL = 22.18
S FL = 17.50 (18" PIPE)
N FL = 17.50 (18" PIPE)
- 38 BWI -
GRATE EL = 22.58
S FL = 17.90 (18" PIPE)
N FL = 17.90 (18" PIPE)
- 39 GUTTER INLET -
GRATE EL = 22.34
E FL = 18.10 (18" PIPE)
N FL = 18.10 (18" PIPE)
- 40 MES -
W FL = 18.00 (18" PIPE)
- 41 GUTTER INLET -
GRATE EL = 22.45
N FL = 18.20 (18" PIPE)
S FL = 18.20 (18" PIPE)

- 42 OVERFLOW WEIR
SPILLWAY EL = 19.30
- 43 BWI -
GRATE EL = 23.20
S FL = 18.90 (18" PIPE)
- 44 GUTTER INLET -
GRATE EL = 23.04
S FL = 18.90 (18" PIPE)
- 45 BWI -
GRATE EL = 23.24
N FL = 18.90 (18" PIPE)
- 46 GUTTER INLET -
GRATE EL = 22.99
N FL = 18.90 (18" PIPE)
- 47 BWI -
GRATE EL = 22.70
N FL = 17.90 (18" PIPE)
S FL = 17.90 (18" PIPE)
- 48 GUTTER INLET -
GRATE EL = 22.53
N FL = 18.30 (18" PIPE)
S FL = 18.30 (18" PIPE)
- 49 GUTTER INLET -
GRATE EL = 22.42
E FL = 18.10 (18" PIPE)
S FL = 18.10 (18" PIPE)
- 50 MES -
E FL = 8.00 (18" PIPE)
- 51 DBI -
GRATE EL = 20.20
SLOT EL = 19.70
V-NOTCH EL 18.00
E FL = 14.00 (24" PIPE)
- 52 EW -
W FL = 13.88 (24" PIPE)
- 53 U-TYPE EW W/BAFFLES -
W FL = 17.33 (18" PIPE)
- 54 GUTTER INLET -
GRATE EL = 22.21
W FL = 17.50 (18" PIPE)
S FL = 17.50 (18" PIPE)
- 55 DBI -
GRATE EL = 19.20
SLOT EL = 18.70
V-NOTCH EL = 17.00
E FL = 14.00 (24" PIPE)

- 56 EW -
W FL = 13.88 (24" PIPE)
- 57 EW -
W FL = 10.89 ± (30" PIPE)
- 58 DBI -
GRATE EL = 17.50
SLOT EL = 17.00
W FL = 10.89 (30" PIPE)
- 59 OVERFLOW WEIR
SPILLWAY EL = 19.30
- 60 MES -
S FL = 16.00 (18" PIPE)
- 61 MES -
N FL = 16.00 (18" PIPE)
- 62 DBI -
GRATE EL = 18.75
SLOT EL = 18.25
V-NOTCH EL = 16.00
E FL = 14.00 (24" PIPE)
- 63 EW -
W FL = 13.88 (24" PIPE)
- 64 DBI -
GRATE EL 17.50
SLOT EL = 17.00
V-NOTCH EL = 15.00
W FL = 10.94 (24" PIPE)
- 65 EW -
W FL = 11.35 ± (24" PIPE)
- 66 DBI -
GRATE EL = 18.75
SLOT EL = 18.25
E FL = 14.00 (24" PIPE)
- 67 EW -
W FL = 13.88 (24" PIPE)
- 68 DBI -
GRATE EL = 18.45
NOTCH EL = 16.62
W FL = 14.04 (18" PIPE)
- 69 EW -
6" PVC FL 15.02
W FL = 13.42 (18" PIPE)
- 70 DBI -
GRATE EL 18.75
SLOT EL = 18.25
E FL = 14.00 (24" PIPE)

- 71 EW -
W FL = 13.88 (24" PIPE)
- 72 DBI -
GRATE EL = 17.95
NOTCH EL = 16.25
W FL = 13.53 (15" PIPE)
- 73 EW -
6" PVC FL = 14.45
E FL = 13.20 (15" PIPE)
- 74 EW -
E FL 13.27 (15" PIPE)
- 75 DBI
GRATE EL = 17.46
WEIR EL = 16.04
ORIFICE EL = 14.52
W FL = 13.52 (15" PIPE)
- 76 EW -
E FL 13.82 (24" PIPE)
- 76A OUTFALL
72" CMP (E)
INV. ELEV. = 10.08'
- 77 DBI
GRATE EL = 16.98
WEIR EL = 15.93
ORIFICE EL = 14.52
W FL = 13.92 (24" PIPE)
- 77A OUTFALL
72" CMP (W)
INV. ELEV. = 9.88'
- 78 EW -
W FL = 12.76 (DBL 36" CMP)
- 79 DBI -
GRATE EL = 16.64
WEIR EL = 15.85
ORIFICE EL = 14.52
W FL = 12.82 (DBL 36" PIPE)
- 80 DBI - EW
GRATE EL = 17.42
FL = 14.39
EW FL = 13.88 (24" CMP)
- 81 EW -
W FL = 13.88 (24" CMP)
- 82 GUTTER INLET -
E FL = 18.34 (15" CMP)
- 83 MES -
W FL = 18.0 (15" CMP)

EXISTING DRAINAGE STRUCTURES
DATA SHEET

REVISIONS				Kimley-Horn and Associates, Inc. Certificate Of Authorization No. 696 Hooi Gin Ng, P.E. P.E. License No. 58123 1920 Wekiva Way, Suite 200 West Palm Beach, Florida 33411	STATE OF FLORIDA DEPARTMENT OF TRANSPORTATION			DRAINAGE MAP	SHEET NO. 17
DATE	DESCRIPTION	DATE	DESCRIPTION		ROAD NO.	COUNTY	FINANCIAL PROJECT ID		
					SR 91	PALM BEACH	406144-1-52-01		

84	MES - S FL = 18.0 (15" CMP)	97	MES S FL = 16.52 (15" CMP)	110	HW - E FL = 12.66 (36" PIPE)	123	CB - N FL = 19.22 (18" RCP) S FL = 19.20 (18" RCP)	136	CB - S FL = 39.41 (18" RCP)	150	CB - N FL = 19.59 (18" RCP) S FL = 19.67 (18" RCP)
85	MH - W FL = 15.50 (15" CMP) E FL = 15.50 (15" CMP)	98	CB - E FL = 14.66 (24" CMP)	110A	OUTFALL 36" CMP (E) INV. ELEV. = 13.55'	124	CB - N FL = 19.33 (18" RCP) S FL = 19.34 (18" RCP)	137	CB - N FL = 39.57 (18" RCP)	151	HW - E FL = 16.87 (18" RCP)
86	MES - FL = 15.38 (15" CMP)	99	HW - W FL = 13.36 (24" CMP)	110B	OUTFALL 36" CMP (W) INV. ELEV. = 13.01'	125	CB - N FL = 23.11 (18" RCP) S FL = 20.89 (18" RCP)	138	CB - N FL = 39.62 (18" RCP)	152	CB - S FL = 17.59 (18" RCP) W FL = 17.53 (18" RCP)
87	CB - W FL (4", 10" PVC) S FL (15" PVC)	100	MH - E FL = 12.66 (36" RCP)	110C	STRAIGHT ENDWALL 72" RCP (E) INV. ELEV. = 10.23'	126	CB - N FL = 23.12 (18" RCP) S FL = 20.78 (18" RCP)	139	CB - N FL = 37.74 (18" RCP) S FL = 35.52 (18" RCP)	153	CB - E FL = 17.67 (18" RCP) S FL = 17.75 (18" RCP)
88	MES - E FL = 17.09 (8" PVC)	100A	OUTFALL 72" CMP (W) INV. ELEV. = 10.38'	110D	STRAIGHT ENDWALL 72" RCP (W) INV. ELEV. = 10.55'	127	CB - N FL = 27.92 (18" RCP) S FL = 26.36 (18" RCP)	140	CB - N FL = 36.18 (18" RCP) S FL = 36.16 (18" RCP)	154	HW - W FL = 17.53 (18" RCP)
89	MES - E FL = 17.19 (6" PVC)	101	CB - W FL = 12.81 (36" RCP)	110E	STRAIGHT ENDWALL 60" RCP (W) INV. ELEV. = 8.85'	128	CB - N FL = 26.45 (18" RCP) S FL = 26.57 (18" RCP)	141	CB - N FL = 33.03 (18" RCP) S FL = 33.08 (18" RCP)	155	HW - E FL = 13.96 (24" RCP)
90	HW - E FL (15" CMP)	101A	OUTFALL 72" CMP (E) INV. ELEV. = 9.70'	111	HW - E FL = 10.71 (30" PIPE)	129	CB - N FL = 30.81 (18" RCP) S FL = 30.77 (18" RCP)	142	CB - N FL = 35.18 (18" RCP) S FL = 33.23 (18" RCP)	156	CB - W FL = 14.49 (24" RCP)
91	CB - W FL (15" CMP)	102	HW - E FL = 13.09 (24" RCP)	111A	STRAIGHT ENDWALL 60" RCP (W) INV. ELEV. = 8.87'	130	CB - N FL = 31.02 (18" RCP) S FL = 30.93 (18" RCP)	143	CB - N FL = 30.03 (18" RCP) S FL = 30.13 (18" RCP)	157	CB - E FL = 15.33 (24" RCP)
92	MES - E FL = 16.96 (8" PVC)	103	CB - W FL = 13.85 (24" RCP)	112	CB - W FL = 11.57 (30" PIPE)	131	CB - N FL = 34.31 (18" RCP) S FL = 34.12 (18" RCP)	144	CB - N FL = 30.06 (18" RCP) S FL = 30.27 (18" RCP)	158	HW - W FL = 14.42 (24" RCP)
93	MH - TOP EL = 19.99 N FL EL = 17.24 (15" CMP)	104	CB - E FL = 13.16 (18" RCP)	113	HW - E FL = 10.63 (30" PIPE)	132	CB - N FL = 36.62 (18" RCP) S FL = 36.51 (18" RCP)	145	CB - N FL = 26.97 (18" RCP) S FL = 27.01 (18" RCP)	159	HW - E FL = 10.33 (24" RCP)
94	MES - S FL = 17.1 (15" CMP)	105	CB - W FL = 13.57 (18" RCP)	114	CB - W FL = 11.07 (30" PIPE)	133	CB - N FL = 36.62 (18" RCP) S FL = 36.51 (18" RCP)	146	CB - N FL = 27.04 (18" RCP) S FL = 26.99 (18" RCP)	160	CB - W FL = 11.62 (24" RCP)
95	MH - N FL = 17.24 (15" CMP)	106	HW - E FL = 12.65 (18" RCP)	115	HW - E FL = 13.92 (30" PIPE)	134	CB - N FL = 36.39 (18" RCP) S FL = 36.35 (18" RCP)	147	CB - N FL = 20.39 (18" RCP) S FL = 20.43 (18" RCP)	160A	CATCH BASIN RIM ELEV. = 16.97' 24" PVC (W) INV. ELEV. = 13.08'
96	MH - N FL = 16.90 (15" CMP)	107	CB - W FL = 13.48 (18" RCP)	116	CB - W FL = 14.54 (30" PIPE)	135	CB - S FL = 36.16 (18" RCP)	148	CB - N FL = 20.54 (18" PIPE) S FL = 20.63 (18" PIPE)	160B	STRAIGHT ENDWALL 24" PVC (E) INV. ELEV. = 13.06'
		108	HW - E FL = 12.92 (18" RCP)	117	CB - E FL = 9.91 (24" PIPE)			149	CB - N FL = 19.50 (18" RCP) S FL = 19.59 (18" RCP)	160C	CATCH BASIN RIM ELEV. = 19.65' 18" PVC (N) INV. ELEV. = 15.66' 18" RCP (W) INV. ELEV. = 15.60'
		109	CB - W FL = 14.08 (18" RCP)	118	END PIPE - W FL = 9.59 (24" PIPE)			149A	STRAIGHT ENDWALL 24" CMP (W) INV. ELEV. = 13.52'	160D	FLARED END SECTION 18" RCP (E) INV. ELEV. = 15.49'
				119	HW - E FL = 17.53 (18" PIPE)			149B	STRAIGHT ENDWALL 24" RCP (E) INV. ELEV. = 11.13' INV. BURIED, LEADS TO A BURIED CATCH BASIN	160E	CATCH BASIN RIM ELEV. = 19.24' 18" PVC (S) INV. ELEV. = 15.83'
				120	CB - W FL = 17.61 (18" PIPE) N FL = 17.63 (18" PIPE)			149C	STRAIGHT ENDWALL 42" CMP (W) INV. ELEV. = 10.67' 42" CMP (W) INV. ELEV. = 10.92'		
				121	CB - N FL = 17.41 (18" PIPE) E FL = 17.62 (18" PIPE)						
				122	HD - W FL = 17.39 (18" PIPE)						

EXISTING DRAINAGE STRUCTURES
DATA SHEET

REVISIONS				Kimley-Horn and Associates, Inc. Certificate Of Authorization No. 696 Hooi Gin Ng, P.E. P.E. License No. 58123 1920 Wekiva Way, Suite 200 West Palm Beach, Florida 33411	STATE OF FLORIDA DEPARTMENT OF TRANSPORTATION			DRAINAGE MAP	SHEET NO. 18
DATE	DESCRIPTION	DATE	DESCRIPTION		ROAD NO.	COUNTY	FINANCIAL PROJECT ID		
					SR 91	PALM BEACH	406144-1-52-01		

- (161) NOT USED
- (162) NOT USED
- (163) NOT USED
- (164) NOT USED
- (165) CB -
E FL = 6.88 (UNABLE TO OBTAIN
PIPE SIZE)
- (166) HDW -
(UNABLE TO OBTAIN FLOW
OR PIPE SIZE)
- (167) HDW -
E FL = 15.98 (24" RCP)
- (168) CB -
W FL = 14.05 (24" RCP)
E FL = 14.08 (18" RCP)
- (169) CB -
W FL = 14.14 (18" RCP)
E FL = 14.01 (24" RCP)
- (170) HDW -
W FL = 13.98 (24" RCP)
- (171) CB -
E FL = 28.25 (18" RCP)
- (172) CB -
E FL = 27.88 (18" CMP)
W FL = 27.86 (18" CMP)
- (173) PIPE END -
W FL = 13.85 (18" CMP)
- (174) CB -
E FL = 33.47 (18" RCP)
- (175) CB -
W FL = 33.34 (18" CMP)
E FL = 33.21 (18" CMP)
- (176) PIPE END -
W FL = 14.02 (18" CMP)
- (177) CB -
E FL = 36.82 (18" RCP)
- (178) CB -
W FL = 36.75 (18" CMP)
E FL = 36.48 (18" CMP)
- (179) PIPE END -
W FL = 14.08 (18" CMP)
- (180) CB -
E FL = 36.11 (18" CMP)
- (181) PIPE END -
W FL = 13.91 (18" PIPE)
- (182) CB -
S FL = 14.52 (18" CMP)
- (183) CB -
E FL = 12.43 (18" RCP)
- (184) HDW -
WATER GATE
S FL = 7.54 (78" RCP)
- (185) HDW -
N FL = 5.38 (78" RCP)
- (186) DBI -
GRATE EL = 7.77
W FL = 10.17 (18" RCP)
- (187) CB -
E FL = 35.96 (18" PIPE)
- (188) CB -
W FL = 35.43 (18" CMP)
E FL = 34.57 (18" CMP)
- (189) CMP END -
W FL = 14.22 (18" CMP)
- (190) DBI -
E FL = 14.11 (18" CMP)
- (191) CB -
W FL = 31.87 (18" CMP)
- (192) CB -
E FL = 31.67 (18" CMP)
- (193) HDW -
W FL = 14.12 (18" CMP)
- (194) CB -
(PIPE SIZE UNKNOWN)
E FL = 5.63
- (195) HDW -
E FL = 9.36 (30" RCP)
- (196) CB -
W FL = 24.41 (18" CMP)
- (197) HDW -
E FL = 14.24 (18" CMP)
- (198) CB -
E FL = 24.38 (18" CMP)
- (199) HDW -
W FL = 13.93 (18" CMP)
- (200) CB -
N FL = 9.66 (24" RCP)
E FL = 9.90 (24" RCP)
- (201) CB -
W FL = 9.60 (24" RCP)
S FL = 9.70 (24" RCP)
- (202) CB -
E FL = 9.02 (24" RCP)
W FL = 8.98 (24" RCP)
- (203) CB -
N FL = 14.73 (18" RCP)
- (204) MH -
TOP EL 18.08
S FL = 14.66 (15" RCP)
- (205) HDW -
W FL = 11.78 (60" RCP)
- (206) HDW -
E FL = 12.10 (60" RCP)
- (207) HDW -
W FL = 11.15 (60" RCP)
- (208) HDW -
W FL = 11.26 (60" RCP)
- (209) CB -
N FL = 9.24 (18" RCP)
W FL = 9.81 (18" RCP)
- (210) CB -
N FL = 13.83 (18" RCP)
- (211) HDW -
S FL = 14.81 (18" RCP)
- (211A) CB -
N FL = 14.16 (18" RCP)
GRATE EL = 16.30
EW EL = 14.34
- (212) MH -
S FL = 14.67 (18" RCP)
N FL = 14.57 (18" RCP)
- (213) HDW -
E FL = 14.18 (18" PIPE)
- (214) CB -
W FL = 19.09 (18" PIPE)
- (215) HDW -
W FL = 14.59 (18" PIPE)
- (216) CB -
E FL = 18.09 (18" PIPE)
- (217) HDW -
E FL = 15.29 (15" PIPE)
- (218) CB -
E FL = 16.20 (15" PIPE)
- (219) HDW -
N FL = 13.81 (24" PIPE)
- (220) INLET -
S FL = 14.34 (24" PIPE)
- (221) CB -
(STRUCTURE INACCESSIBLE)
BOTTOM EL = 16.61
- (222) CB -
(STRUCTURE INACCESSIBLE)
BOTTOM EL = 16.18
- (223) CB -
N FL = 15.65 (15" PIPE)
- (224) CB -
S FL = 15.56 (15" PIPE)
E FL = 15.66 (15" PIPE)
- (225) FLUME -
W FL = 15.08 (15" PIPE)
- (226) CB-
STRUCTURE INACCESSIBLE
BOTTOM EL = 16.87
- (227) HDW -
E FL = 15.77 (24" PIPE)
- (228) HDW -
W FL = 15.00 (24" PIPE)
- (229) NOT USED
- (230) NOT USED
- (231) NOT USED
- (232) NOT USED
- (233) NOT USED
- (234) NOT USED
- (235) NOT USED
- (236) NOT USED
- (237) NOT USED
- (238) NOT USED
- (239) NOT USED
- (240) NOT USED
- (241) NOT USED
- (242) NOT USED
- (243) NOT USED
- (244) NOT USED
- (245) NOT USED
- (246) NOT USED
- (247) CB -
W FL = 10.80 (18" PIPE)
- (248) HDW -
E FL = 8.55 (18" PIPE)
- (249) FLUME -
E FL = 15.15 (24" RCP)
- (250) HDW -
W FL = 14.57 (24" RCP)
- (300) CATCH BASIN
RIM ELEV. = 18.32'
24" PVC (N)
INV. ELEV. = 13.50'
- (301) CATCH BASIN
RIM ELEV. = 18.37'
24" PVC (N)
INV. ELEV. = 13.05'
24" PVC (S)
INV. ELEV. = 12.94'
- (302) CATCH BASIN
RIM ELEV. = 18.33'
30" PVC (N)
INV. ELEV. = 12.49'
24" PVC (S)
INV. ELEV. = 12.98'
- (303) CATCH BASIN
RIM ELEV. = 18.15'
30" PVC (N)
INV. ELEV. = 12.30'
30" PVC (S)
INV. ELEV. = 12.37'
- (304) CATCH BASIN
RIM ELEV. = 18.45'
30" PVC (N)
INV. ELEV. = 11.98'
30" PVC (S)
INV. ELEV. = 12.01'
- (305) CATCH BASIN
RIM ELEV. = 18.38'
36" PVC (N)
INV. ELEV. = 10.61'
30" PVC (S)
INV. ELEV. = 11.16'
- (306) CATCH BASIN
RIM ELEV. = 18.47'
36" PVC (N)
INV. ELEV. = 10.39'
36" PVC (S)
INV. ELEV. = 10.37'
- (307) MANHOLE
RIM ELEV. = 18.72'
36" RCP (N)
INV. ELEV. = 10.04'
36" PVC (S)
INV. ELEV. = 10.18'
- (308) CATCH BASIN
RIM ELEV. = 18.06'
36" RCP (N)
INV. ELEV. = 9.87'
36" RCP (S)
INV. ELEV. = 9.91'
- (309) CATCH BASIN
RIM ELEV. = 17.91'
36" RCP (N)
INV. ELEV. = 9.75'
36" RCP (S)
INV. ELEV. = 9.78'
- (310) CATCH BASIN
RIM ELEV. = 17.82'
36" RCP (N)
INV. ELEV. = 9.70'
36" RCP (S)
INV. ELEV. = 9.73'
- (311) CATCH BASIN
RIM ELEV. = 17.58'
48" RCP (N)
INV. ELEV. = 9.68'
36" RCP (S)
INV. ELEV. = 9.69'
- (312) CATCH BASIN
RIM ELEV. = 18.70'
48" RCP (N)
INV. ELEV. = 9.63'
48" RCP (SW)
INV. ELEV. = 9.63'
- (313) CATCH BASIN
RIM ELEV. = 18.67'
48" RCP (N)
INV. ELEV. = 9.26'
48" RCP (S)
INV. ELEV. = 9.77'
- (314) OUTFALL
10" PVC (W)
INV. ELEV. = 15.05'
- (315) OUTFALL
10" PVC (E)
INV. ELEV. = 15.37'
- (316) OUTFALL
72" CMP (W)
INV. ELEV. = 9.77'
- (317) OUTFALL
72" CMP (E)
INV. ELEV. = 9.58'
- (318) CATCH BASIN
RIM ELEV. = 19.87'
18" RCP (NE)
INV. ELEV. = 15.88'
- (319) FLARED END SECTION
18" RCP (SW)
INV. ELEV. = 15.48'
- (320) OUTFALL
24" CMP (NE)
INV. ELEV. = 12.55'
- (321) OUTFALL
24" CMP (SW)
INV. ELEV. = 12.41'

EXISTING DRAINAGE STRUCTURES
DATA SHEET

REVISIONS				Kimley-Horn and Associates, Inc. Certificate of Authorization No. 696 Hooi Gin Ng, P.E. P.E. License No. 58123 1920 Wekiva Way, Suite 200 West Palm Beach, Florida 33411	STATE OF FLORIDA DEPARTMENT OF TRANSPORTATION			DRAINAGE MAP	SHEET NO. 19
DATE	DESCRIPTION	DATE	DESCRIPTION		ROAD NO.	COUNTY	FINANCIAL PROJECT ID		
					SR 91	PALM BEACH	406144-1-52-01		

322	STRAIGHT ENDWALL 24" RCP (NE) INV. ELEV. = 10.75'	336	STA 193+50.00 (102.00' RT) CONST DBI TYPE G INDEX NO'S 200, 201 AND 233 GRATE EL 19.22 FL 11.40 (LT) FL 10.90 (RT)	348	MEDIAN INLET INFLOW RIM ELEV. = 18.84' MANHOLE RIM ELEV. = 19.50' 18" RCP (W) INV. ELEV. = 15.56'	365	STA 104+61.88 (45.44' LT) CONST INLET TYPE P-5 INDEX NO'S 200 AND 211 EOP EL 19.50 FL 14.80	376	NOT USED	389	STA 197+41.80 (72.5' RT) CONST INLET TYPE P-4 EOP EL 17.21 INDEX NO'S 200 AND 210 FL 13.00 (BK)
323	CATCH BASIN RIM ELEV. = 16.90' 24" RCP INV. ELEV. = 10.94'	337	STA 193+50.00 (170.40' RT) CONST STRAIGHT CONCRETE ENDWALL INDEX NO 250 FL 9.50	349	CURB INLET RIM ELEV. = 17.96' 30" RCP (NW) INV. ELEV. = 13.40' 30" RCP (E) INV. ELEV. = 13.95'	366	STA 108+05.00 (10.50' RT) CONST MANHOLE TYPE P-8 INDEX NO'S 200 AND 201 RIM EL 19.36 FL 15.00 (BK, AH) SEE NOTE II CONNECT 8" PVC PIPE TO BOTTOM OUTLET OF 12" TRENCH DRAIN COST OF 8" PVC PIPE TO BE INCLUDED WITH THE COST OF TRENCH DRAIN	377	NOT USED	390	BOX CULVERT
324	OUTFALL 24" CMP (NE) INV. ELEV. = 15.83'	338	CATCH BASIN RIM ELEV. = 15.55' 48" RCP (NW) INV. ELEV. = 8.53' 48" RCP (S) INV. ELEV. = 8.77'	350	CATCH BASIN RIM ELEV. = 41.28' 18" PVC (N) INV. ELEV. = 36.71'	367	STA 107+25.00 (10.50' RT) CONST MANHOLE TYPE P-8 INDEX NO'S 200 AND 201 RIM EL 19.22 FL 14.80 (BK, AH) SEE NOTE II CONNECT 8" PVC PIPE TO BOTTOM OUTLET OF 12" TRENCH DRAIN COST OF 8" PVC PIPE TO BE INCLUDED WITH THE COST OF TRENCH DRAIN	378	NOT USED	391	BOX CULVERT
325	OUTFALL 24" CMP (SW) INV. ELEV. = 12.79'	339	STRAIGHT ENDWALL 48" RCP (SE) INV. ELEV. = 8.40'	351	CATCH BASIN RIM ELEV. = 30.38' 18" PVC (N) INV. ELEV. = 25.89' 18" PVC (S) INV. ELEV. = 25.95'	368	STA 106+43.10 (10.47' RT) CONST MANHOLE TYPE P-8 INDEX NO'S 200 AND 201 RIM EL 18.97 FL 13.80 (AH) FL 10.00 (LT, RT) SEE NOTE II	379	NOT USED	392	BOX CULVERT
326	CATCH BASIN RIM ELEV. = 22.24' 18" RCP (NE) INV. ELEV. = 17.70'	340	CATCH BASIN RIM ELEV. = 23.29' 18" RCP (N) INV. ELEV. = 14.27'	352	NOT USED	369	STA 106+35.65 (60.07' RT) CONST MANHOLE TYPE P-8 (PARTIAL) INDEX NO'S 200 AND 201 RIM EL 18.73	380	STA 101+90.00 (52.25' LT) CONST INLET TYPE P-5 INDEX NO'S 200 AND 211 EOP EL 18.60 FL 14.50 (BK)	393	STA 198+21.28 (88.38' RT) CONST INLET TYPE P-9 EOP EL 17.91 INDEX NO'S 200 AND 214 FL 11.90 (LT, AH)
327	CATCH BASIN RIM ELEV. = 22.11' 18" RCP (SW) INV. ELEV. = 17.56' 18" RCP (NE) INV. ELEV. = 11.83'	341	STRAIGHT ENDWALL 18" RCP (S) INV. ELEV. = 11.54'	353	NOT USED	370	STA 106+25.79 (61.04' RT) CONST MANHOLE TYPE P-8 INDEX NO'S 200 AND 201 RIM EL 18.77 FL 9.70 (BK, AH) FL 11.60 (RT)	381	STA 37+71.00 (16.25' LT) @ DRIVEWAY 3 CONST INLET TYPE P-5 INDEX NO'S 200 AND 211 EOP EL 17.97 FL 13.50 (BK)	394	STA 198+21.28 (44.77' RT) CONST INLET TYPE P-9 EOP EL 18.37 INDEX NO'S 200 AND 214 FL 12.00 (RT)
328	STRAIGHT ENDWALL 18" RCP INV. ELEV. = 11.30'	342	STRAIGHT ENDWALL 24" RCP (E) INV. ELEV. = 10.06'	354	NOT USED	371	NOT USED	382	STA 36+60.00 (68.57' RT) @ DRIVEWAY 3 CONST STRAIGHT CONC ENDWALL INDEX NO 250 FL 12.30	395	STA 106+25.79 (67.17' RT) CONST INLET TYPE P-9 INDEX NO'S 200 AND 214 EOP EL 18.74 FL 11.80 (LT, RT)
329	OUTFALL 24" CMP (E) INV. ELEV. = 12.39'	343	CATCH BASIN RIM ELEV. = 30.06' 18" PVC (N) INV. ELEV. = 23.00' 18" PVC (SE) INV. ELEV. = 23.02' 24" RCP (W) INV. ELEV. = 15.87'	355	NOT USED	372	NOT USED	383	STA 36+00.00 (46.00' LT) @ DRIVEWAY 3 CONST DBI INLET TYPE D INDEX NO'S 200 AND 232 GRATE EL 15.50 FL 11.50 (BK)	396	STA 194+69.80 (50.70' LT) CONST BARRIER WALL INLET (C&G) INDEX NO'S 200, 201, 219 AND 410 GRATE EL 19.34 FL 12.40 (BK, AH)
330	OUTFALL 24" CMP (W) INV. ELEV. = 12.41'	344	CATCH BASIN RIM ELEV. = 37.05' 18" PVC (N) INV. ELEV. = 32.68' 18" PVC (E) INV. ELEV. = 32.64' 18" PVC (S) INV. ELEV. = 32.61'	356	NOT USED	373	STA 103+52.74 (170.00' RT) CONST DBI TYPE D INDEX NO'S 200, 201, 232 GRATE EL 16.26 FL 12.60 (LT)	384	STA 36+00.00 (55.00' RT) CONST STRAIGHT CONCRETE ENDWALL INDEX NO 250 FL 11.40	397	STA 195+45.00 (50.42' LT) CONST BARRIER WALL INLET (C&G) INDEX NO'S 200, 201, 219 AND 410 GRATE EL 18.46 FL 12.60 (BK, AH)
331	STA 190+19.26 (26.57' RT) @ RAMP C2 CONST MEDIAN BARRIER WALL INLET INDEX NO 217 TYPE II GRATE EL 22.48 FL 17.50 (LT)	345	CATCH BASIN RIM ELEV. = 40.40' 18" PVC (N) INV. ELEV. = 35.74' 18" PVC (E) INV. ELEV. = 35.91' 18" PVC (S) INV. ELEV. = 35.86'	357	NOT USED	374	NOT USED	385	STA 194+84.93 (65.47' RT) CONST INLET TYPE P-3 INDEX NO'S 200 AND 210 EOP EL 18.94 FL 12.20 (BK, AH)	398	STA 196+86.10 (48.87' LT) CONST BARRIER WALL INLET GRATE EL 17.41 INDEX NO'S 200, 201, AND 218 FL 12.90 (BK, AH)
332	STA 177+48.81 (10.98' LT) CONST BARRIER WALL INLET INDEX NO 219 GRATE EL 21.59 FL 12.00 (LT) FL 17.00 (RT)	346	CATCH BASIN RIM ELEV. = 41.74' 18" PVC (S) INV. ELEV. = 36.98'	358	NOT USED	375	STA 101+09.00 (64.75' RT) CONST INLET TYPE J-5 ALT B (4'X9') INDEX NO'S 200 AND 211 EOP EL 18.21 FL 10.18 (BK, AH)	386	STA 195+54.93 (68.97' RT) CONST INLET TYPE P-3 INDEX NOS 200 AND 210 EOP EL 18.38 FL 12.40 (BK, AH)	399	STA 197+41.80 (48.87' LT) CONST BARRIER WALL INLET INDEX NO 200, 201 AND 218 GRATE EL 17.23 FL 13.10 (BK)
333	STA 177+58.71 (51.09' LT) CONST STRAIGHT CONC ENDWALL INDEX NO 250 FL 11.30	347	MEDIAN INLET INFLOW RIM ELEV. = 18.87' MANHOLE RIM ELEV. = 19.54' 18" RCP (E) INV. ELEV. = 15.22' 18" RCP (W) INV. ELEV. = 15.20'	359	NOT USED			387	STA 196+24.92 (72.47' RT) CONST INLET TYPE P-3 INDEX NO'S 200 AND 210 EOP EL 17.82 FL 12.60 (BK, AH)	400	BOX CULVERT
334	STA 193+71.00 (53.42' LT) CONST BARRIER WALL INLET (C&G) INDEX NO'S 200, 201, 219 AND 410 GRATE EL 20.49 FL 12.20 (AH), FL 11.70 (RT) CONNECT TRENCH DRAIN TYPE II INDEX NO 206 DESIGN FLOW Q = 1.53 CFS			360	MEDIAN INLET 18" RCP (E) INV. ELEV. = 14.95'			388	STA 196+86.10 (72.50' RT) CONST INLET TYPE P-3 INDEX NO'S 200 AND 210 EOP EL 17.39 FL 12.80 (BK, AH)	401	STA 104+03.41 (63.40' RT) CONST MH TYPE P-8 INDEX NO 200, 201 RIM EL 19.42 FL 15.00 (RT) FL 9.67± (BK, AH)
335	STA 193+74.00 (59.92' RT) CONST INLET TYPE P-3 INDEX NO'S 200 AND 210 EOP EL 20.05 FL 11.50 (LT, RT), FL 12.00 (AH) CONNECT TRENCH DRAIN TYPE II INDEX NO 206 DESIGN FLOW Q = 1.80 CFS			361	STA 108+20.00 (51.25' LT) CONST INLET TYPE P-5 INDEX NO'S 200 AND 211 EOP EL 18.55 FL 14.45 (BK)						
				362	STA 107+21.00 (51.25' LT) CONST INLET TYPE P-6 INDEX NO'S 200 AND 211 EOP EL 18.32 FL 14.30 (BK, AH)						
				363	STA 106+21.39 (51.00' LT) CONST INLET TYPE P-9 INDEX NO'S 200 AND 214 EOP EL 18.74 FL 14.60 (BK, AH)						
				364	STA 105+06.87 (47.71' LT) CONST INLET TYPE P-5 INDEX NO'S 200 AND 211 EOP EL 19.31 FL 14.70 (BK, AH)						

EXISTING DRAINAGE STRUCTURES
DATA SHEET


REVISIONS				Kimley-Horn and Associates, Inc. Certificate Of Authorization No. 696 Hooi Gin Ng, P.E. P.E. License No. 58123 1920 Wekiva Way, Suite 200 West Palm Beach, Florida 33411	STATE OF FLORIDA DEPARTMENT OF TRANSPORTATION			DRAINAGE MAP	SHEET NO. 20
DATE	DESCRIPTION	DATE	DESCRIPTION		ROAD NO.	COUNTY	FINANCIAL PROJECT ID		
					SR 91	PALM BEACH	406144-1-52-01		

- 402 STA 104+06.00 (75.42' RT)
CONST INLET TYPE P-1
INDEX NO'S 200 AND 210
EOP EL 19.34
FL 15.20 (LT)
- 403 STA 96+75.00 (60.25' RT)
CONST INLET TYPE J-5 ALT B (4'X7')
INDEX NO'S 200 AND 211
EOP EL 18.56
FL 8.91(BK, AH)
SEE NOTE II
- 404 STA 100+26.16 (51.00' LT)
CONST INLET TYPE P-6 (PARTIAL)
EXISTING BOX TO REMAIN
INDEX NO'S 200 AND 211
EOP EL 18.10
FL 14.20 (AH)
FL 12.54± (RT)
CORE HOLE IN EAST FACE OF
EXIST STRUCTURE.
COST TO BE INCLUDED IN THE
PRICE OF THE STRUCTURE.
- 405 NOT USED
- 406 STA 100+26.16 (59' RT)
CONST INLET TYPE J-6 (PARTIAL)
INDEX NO'S 200 AND 211
EOP EL 18.10
FL 9.06± (BK)
FL 10.39± (LT)
FL 10.38± (AH)
SEE NOTE II
- 407 STA 140+50.00 (83.88' LT)
CONST BARRIER WALL INLET
INDEX NO'S 200, 201 AND 218
GRATE EL 35.72
FL 32.20 (BK, AH)
- 408 OUTFALL
18" RCP (E)
INV. ELEV. = 17.86'
- 409 CATCH BASIN
RIM ELEV. = 21.76'
18" RCP (W)
INV. ELEV. = 17.99'
18" PVC (S)
INV. ELEV. = 17.91'
- 410 CATCH BASIN
RIM ELEV. = 22.67'
18" PVC (N)
INV. ELEV. = 18.32'
18" PVC (S)
INV. ELEV. = 18.34'
- 411 NOT USED
- 412 NOT USED
- 413 NOT USED
- 414 MITERED END SECTION
24" RCP (N)
INV. ELEV. = 15.49'
- 415 CATCH BASIN
RIM ELEV. = 20.25'
18" RCP (N)
INV. ELEV. = 16.34'
24" RCP (S)
INV. ELEV. = 16.28'
- 416 CATCH BASIN
RIM ELEV. = 20.48'
18" RCP (N)
INV. ELEV. = 16.55'
18" RCP (S)
INV. ELEV. = 16.47'
- 417 MANHOLE
RIM ELEV. = 21.15'
18" RCP (N)
INV. ELEV. = 16.75'
18" RCP (S)
INV. ELEV. = 16.74'
- 418 MANHOLE
RIM ELEV. = 22.31'
18" RCP (S)
INV. ELEV. = 16.99'
18" RCP (N)
INV. ELEV. = 16.92'
- 419 APPROXIMATE
DIRECTION
TO OUTFALL
- 420 CURB INLET
RIM ELEV. = 19.54'
23" X 14" RCP (N)
INV. ELEV. = 16.66'
- 421 MITERED END SECTION
15" RCP (E)
INV. ELEV. = 16.07'
- 422 CURB INLET
RIM ELEV. = 19.61'
15" RCP (W)
INV. ELEV. = 16.70'
23"x14" ELLIPTICAL
RCP (S)
INV. ELEV. = 16.36'
23"x14" ELLIPTICAL
RCP (NE)
INV. ELEV. = 16.25'
- 423 CURB INLET
RIM ELEV. = 20.45'
23"x14" ELLIPTICAL
RCP (SW)
INV. ELEV. = 17.09'
- 424 CURB INLET
23"x14" ELLIPTICAL
RCP (W)
INV. ELEV. = 17.60'
- 425 MANHOLE
RIM ELEV. = 20.42'
24" RCP (W)
TOP OF BAFFLE
ELEV. = 18.72'
UNABLE TO OBTAIN
INV.
23"x14" ELLIPTICAL
RCP (E)
INV. ELEV. = 16.81'
- 426 MITERED END SECTION
24" RCP (E)
INV. ELEV. = 15.82'
- 427 MITERED END
SECTION
18" RCP (N)
INV. ELEV. = 14.75'
18" RCP (N)
INV. ELEV. = 14.76'
- 428 STRAIGHT ENDWALL
24" RCP (W)
INV. ELEV. = 14.70'
- 429 NO DATA AVAILABLE
- 430 NO DATA AVAILABLE
- 431 CATCH BASIN
RIM ELEV. = 20.20'
24" RCP (NE)
INV. ELEV. = 15.58'
24" RCP (SW)
INV. ELEV. = 15.56'
- 432 CATCH BASIN
RIM ELEV. = 20.03'
24" RCP (N)
INV. ELEV. = 15.78'
24" RCP (SW)
INV. ELEV. = 15.77'
- 433 CATCH BASIN
RIM ELEV. = 20.54'
24" RCP (S)
INV. ELEV. = 15.93'
24" RCP (N)
INV. ELEV. = 16.27'
- 434 MANHOLE
RIM ELEV. = 21.74'
24" RCP (S)
INV. ELEV. = 16.45'
24" RCP (N)
INV. ELEV. = 16.80'
15" RCP (W)
INV. ELEV. = 19.06'
- 435 YARD DRAIN
RIM ELEV. = 21.60'
15" RCP (E)
INV. ELEV. = 18.14'
15" HDPE (W)
INV. ELEV. = 18.66
- 436 CATCH BASIN
RIM ELEV. = 21.32'
15" RCP (SW)
INV. ELEV. = 17.86'
24" RCP (S)
INV. ELEV. = 16.95'
- 437 YARD DRAIN
RIM ELEV. = 22.31'
15" RCP (NE)
INV. ELEV. = 18.03'
15" HDPE (W)
INV. ELEV. = 18.64'
- 438 CURB INLET
RIM ELEV. = 20.62'
23"x14" ELLIPTICAL RCP (NE)
INV. ELEV. = 16.76'
- 439 CURB INLET
RIM ELEV. = 21.35'
23"x14" ELLIPTICAL RCP (N)
INV. ELEV. = 18.08'
- 440 CURB INLET
RIM ELEV. = 21.30'
23"x14" ELLIPTICAL RCP (NE)
INV. ELEV. = 18.13'
23"x14" ELLIPTICAL RCP (S)
INV. ELEV. = 17.99'
- 441 MANHOLE
RIM ELEV. = 21.74'
12" RCP (NE)
INV. ELEV. = 17.82'
23"x14" ELLIPTICAL
RCP (SW)
INV. ELEV. = 17.95'
- 442 MANHOLE
RIM ELEV. = 20.47'
19" X 30" RCP (E)
INV. ELEV. = 16.22'
12" RCP (SW)
INV. ELEV. = 17.07'
23"x14" ELLIPTICAL
RCP (W)
INV. ELEV. = 16.49'
12" RCP (NW)
INV. ELEV. = 16.42'
- 443 CURB INLET
RIM ELEV. = 20.78'
23"x14" ELLIPTICAL RCP (E)
INV. ELEV. = 17.42'
- 444 MANHOLE
RIM ELEV. = 21.38'
23"x14" ELLIPTICAL
RCP (N)
INV. ELEV. = 17.20'
12" RCP (NW)
INV. ELEV. = 17.12'
12" RCP (SE)
INV. ELEV. = 17.42'
- 445 MANHOLE
RIM ELEV. = 21.85'
12" RCP (SE)
INV. ELEV. = 18.36'
23"x14" ELLIPTICAL RCP (W)
INV. ELEV. = 18.32'
- 446 CURB INLET
RIM ELEV. = 21.35'
12" RCP (NW)
INV. ELEV. = 19.16'
23"x14" ELLIPTICAL RCP (E)
INV. ELEV. = 19.16'
- 447 CATCH BASIN
RIM ELEV. = 18.50'
23"x14" ELLIPTICAL
RCP (N)
INV. ELEV. = 15.02'
- 448 CATCH BASIN
RIM ELEV. = 18.34'
23"x14" ELLIPTICAL
RCP (S)
INV. ELEV. = 14.83'
23"x14" ELLIPTICAL
RCP (N)
INV. ELEV. = 14.82'
- 449 CATCH BASIN
RIM ELEV. = 17.88'
24" RCP (N)
INV. ELEV. = 14.40'
23"x14" ELLIPTICAL
RCP (W)
INV. ELEV. = 14.55'
23"x14" ELLIPTICAL
RCP (S)
INV. ELEV. = 14.43'
- 450 CURB INLET
RIM ELEV. = 19.67'
23"x14" ELLIPTICAL RCP (E)
INV. ELEV. = 16.08'
- 451 CURB INLET
RIM ELEV. = 18.71'
24" RCP (N)
INV. ELEV. = 14.46'
24" RCP (S)
INV. ELEV. = 14.40'
- 452 CATCH BASIN
RIM ELEV. = 18.75'
24" RCP (N)
INV. ELEV. = 14.42'
24" RCP (S)
INV. ELEV. = 14.46'
23" X 14" ELLIP. RCP
(SW)
INV. ELEV. = 14.95'
- 453 MANHOLE
RIM ELEV. = 19.14'
30" RCP (N)
INV. ELEV. = 14.34'
18" RCP (W)
INV. ELEV. = 14.32'
24" RCP (S)
INV. ELEV. = 14.32'
- 454 MANHOLE
RIM ELEV. = 18.44'
18" RCP (N)
INV. ELEV. = 13.80'
18" RCP (N)
INV. ELEV. = 14.05'
24" RCP (E)
INV. ELEV. = 14.04'
24" RCP (E)
INV. ELEV. = 14.00'
24" RCP (E)
INV. ELEV. = 14.30'
30" RCP (S)
INV. ELEV. = 14.05'
- 455 NO DATA AVAILABLE
- 456 CATCH BASIN
RIM ELEV. = 16.70'
18" RCP (S)
INV. ELEV. = 14.36'
18" RCP (S)
INV. ELEV. = 14.41'
- 457 CATCH BASIN
RIM ELEV. = 20.36'
23" X 14" ELLIPTICAL
RCP (S)
INV. ELEV. = 17.36'
- 458 CATCH BASIN
RIM ELEV. = 20.91'
23" X 14" ELLIP. RCP (N)
INV. ELEV. = 17.85'
- 459 MITERED END
SECTION
18" RCP (SW)
INV. ELEV. = 15.80'
- 460 CATCH BASIN
RIM ELEV. = 20.66'
23" X 14" ELLIP. RCP (NW)
INV. ELEV. = 17.68'
23" X 14" ELLIP. RCP (S)
INV. ELEV. = 17.64'
18" RCP (NE)
INV. ELEV. = 15.98'
- 461 MITERED END
SECTION
12" CMP (W)
INV. ELEV. = 15.58'
- 462 CATCH BASIN
23"x14" ELLIPTICAL RCP (SE)
INV. ELEV. = 17.48'
- 463 CATCH BASIN
18" RCP (NW)
INV. ELEV. = 16.65'
- 464 MANHOLE
RIM ELEV. = 20.85'
18" RCP (SE)
INV. ELEV. = 16.45'
18" RCP (NW)
UNABLE TO OBTAIN
INV.
TOP OF BAFFLE
ELEV. = 18.73'
- 465 MITERED END SECTION
15" RCP (E)
INV. ELEV. = 16.42'
- 466 MITERED END SECTION
18" RCP (SE)
INV. ELEV. = 16.01'
- 467 CATCH BASIN
RIM ELEV. = 17.36'
18" RCP (S)
INV. ELEV. = 15.08'
18" RCP (S)
INV. ELEV. = 15.08'

EXISTING DRAINAGE STRUCTURES
DATA SHEET

REVISIONS				Kimley-Horn and Associates, Inc. Certificate Of Authorization No. 696 Hoor Gin Ng, P.E. P.E. License No. 58123 1920 Wekiva Way, Suite 200 West Palm Beach, Florida 33411	STATE OF FLORIDA DEPARTMENT OF TRANSPORTATION			SHEET NO. 21
DATE	DESCRIPTION	DATE	DESCRIPTION		ROAD NO.	COUNTY	FINANCIAL PROJECT ID	
					SR 91	PALM BEACH	406144-1-52-01	

DRAINAGE MAP

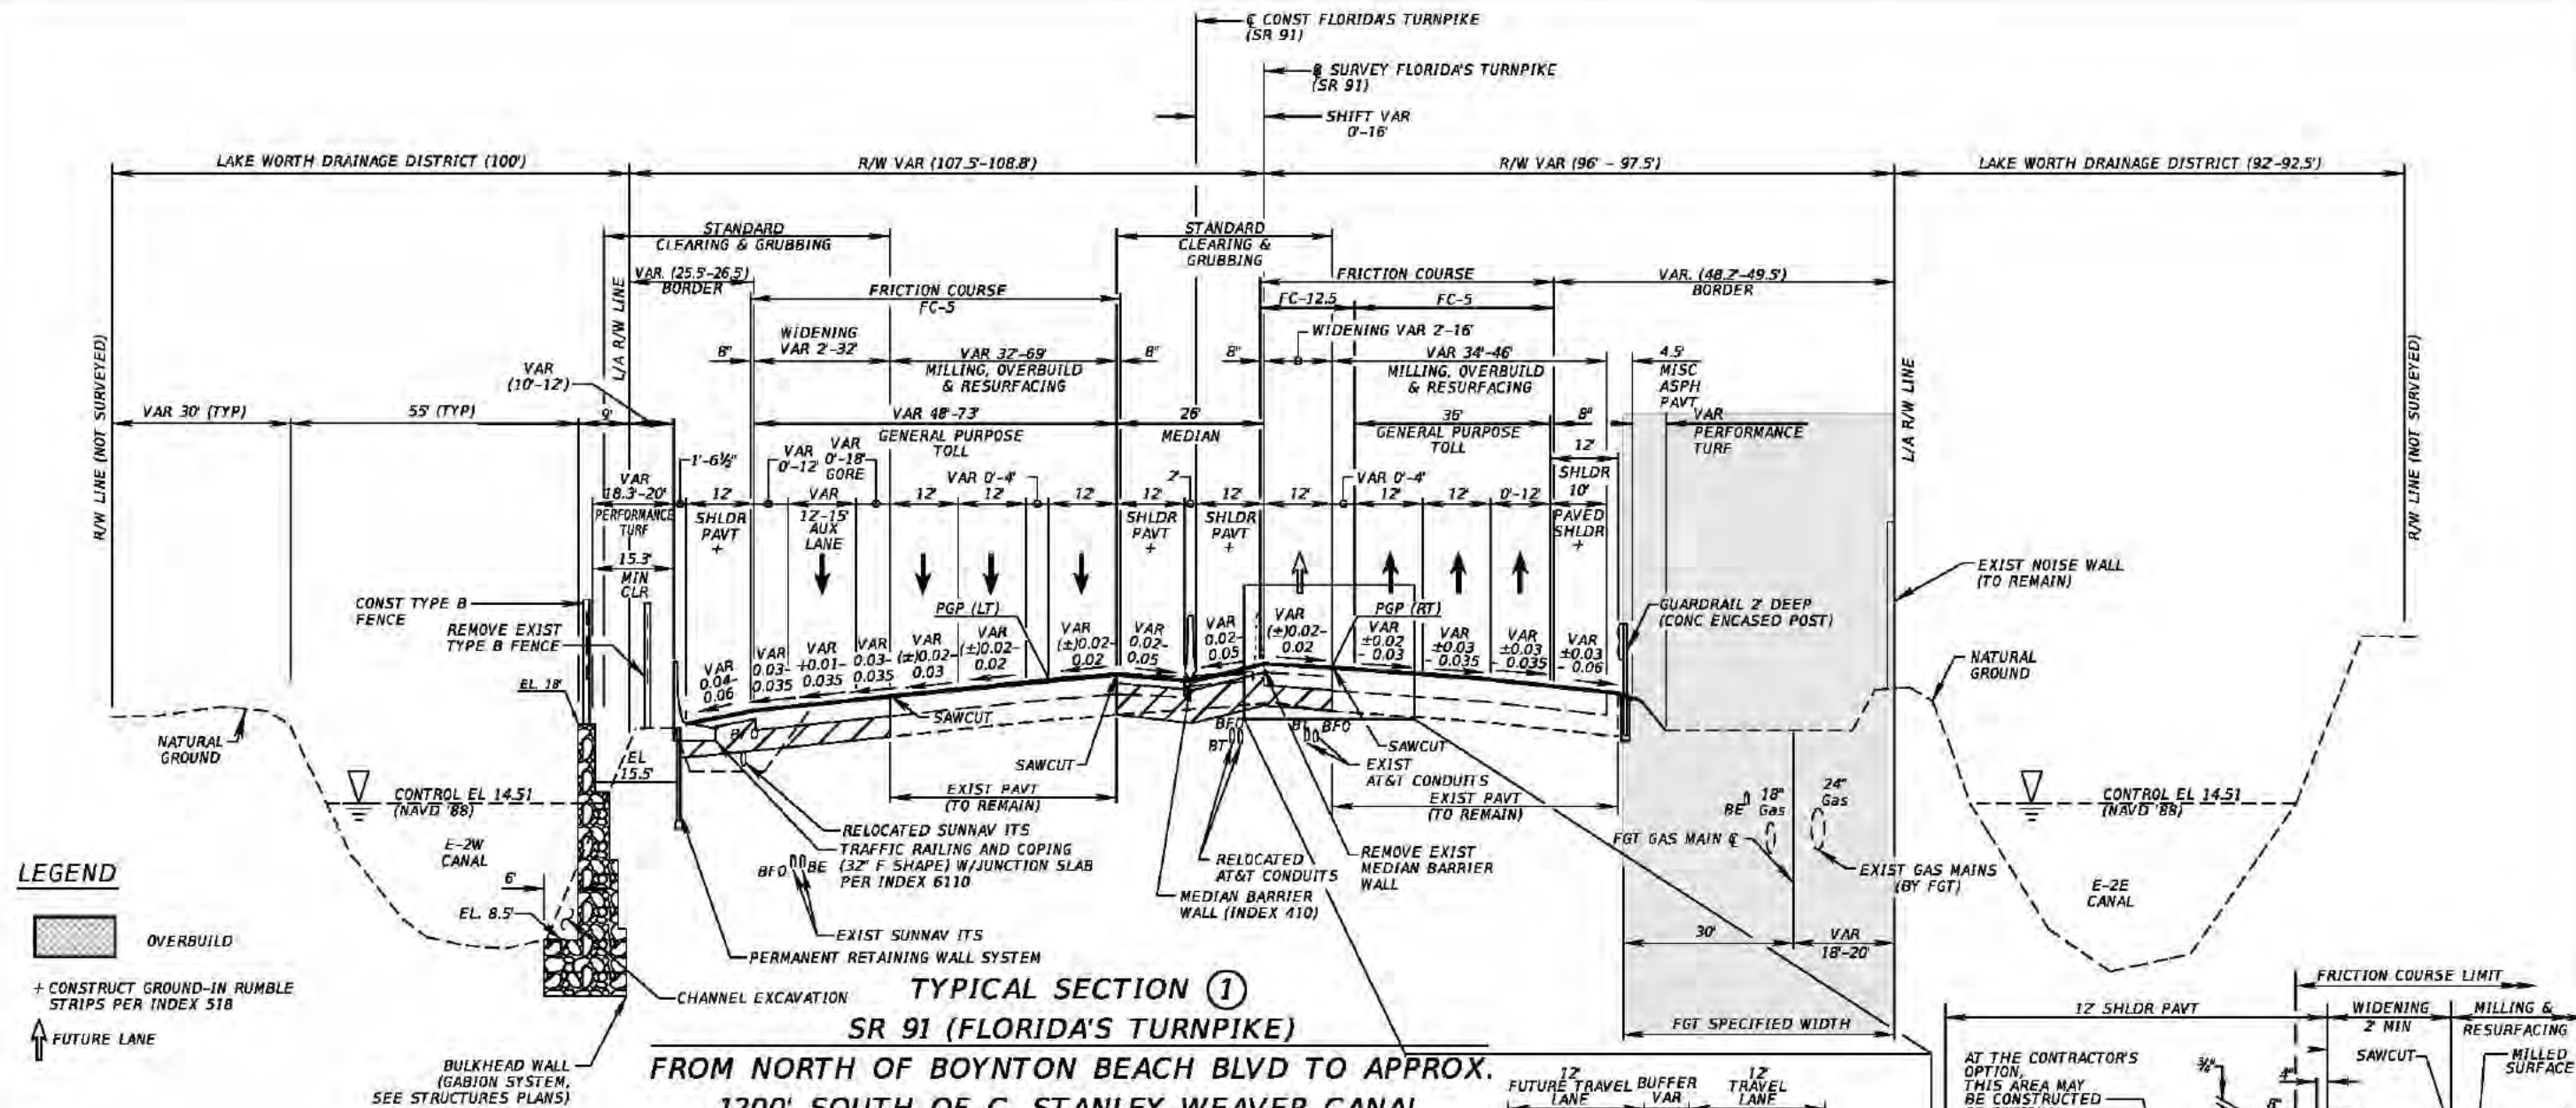

- LEGEND**
- OVERBUILD
 - + CONSTRUCT GROUND-IN RUMBLE STRIPS PER INDEX 518
 - FUTURE LANE

TRAFFIC DATA

CURRENT YEAR = 2015 AADT = 73,700
 ESTIMATED OPENING YEAR = 2020 AADT = 80,100
 ESTIMATED DESIGN YEAR = 2040 AADT = 126,400
 K = 9.5% D = 56.6% T = 11.3% (24 HOUR)
 DESIGN HOUR T = 6.0%
 TRUCK DDHV = 408
 DESIGN SPEED = 70 MPH
 POSTED SPEED = 65 MPH

TYPICAL SECTION NOTES:

1. ACTUAL WIDTH OF BASE WIDENING MAY VARY DUE TO ACTUAL EXISTING PAVEMENT WIDTH. CONTRACTOR MAY ELECT TO PLACE UNIFORM WIDTH BASE WIDENING STRIP AT NO ADDITIONAL COST TO THE DEPARTMENT.
2. 1:6 FOR FILLS TO 5'
 1:6 TO EDGE OF CLEAR ZONE & 1:4 FOR FILLS 5' TO 10'
 1:6 TO EDGE OF CLEAR ZONE & 1:3 FOR FILLS 10' TO 20'
 1:2 WITH GUARDRAIL FOR FILLS OVER 20' AND MUST INCLUDE SHOULDER GUTTER
 SLOPES STEEPER THAN 1:4 MUST INCLUDE SHOULDER GUTTER FOR ALL FILL HEIGHTS

TYPICAL SECTION ① SR 91 (FLORIDA'S TURNPIKE) FROM NORTH OF BOYNTON BEACH BLVD TO APPROX. 1200' SOUTH OF C. STANLEY WEAVER CANAL STA 2084+97.25 TO STA 2099+10.00

WIDENING & NEW CONSTRUCTION

OPTIONAL BASE GROUP 12 WITH
 TYPE SP STRUCTURAL COURSE (TRAFFIC D) (3")
 TYPE SP STRUCTURAL COURSE (TRAFFIC D) (2") (PG 76-22)
 AND FRICTION COURSE FC-5 (3/4") (PG 76-22)

MILLING, OVERBUILD & RESURFACING


TYPE SP STRUCTURAL COURSE (TRAFFIC D) (2")
 AND FRICTION COURSE FC-5 (TRAFFIC D) (3/4") (PG 76-22)

WIDENING & NEW CONSTRUCTION (FUTURE EXPRESS LANE)


OPTIONAL BASE GROUP 12 WITH
 TYPE SP STRUCTURAL COURSE (TRAFFIC D) (3")
 TYPE SP STRUCTURAL COURSE (TRAFFIC D) (1 1/2") (PG 76-22)
 AND FRICTION COURSE FC-12.5 (1 1/2") (PG 76-22)

MILLING, OVERBUILD & RESURFACING (INSIDE SHOULDER PAVEMENT)

TYPE SP STRUCTURAL COURSE (TRAFFIC B) (1") (PG 76-22)

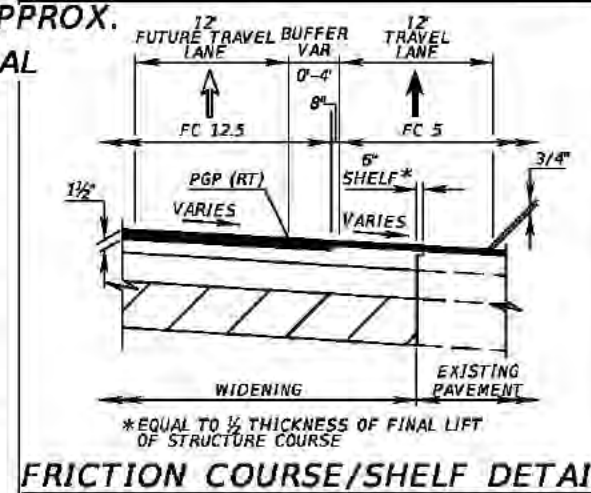

FRICTION COURSE/SHELF DETAIL

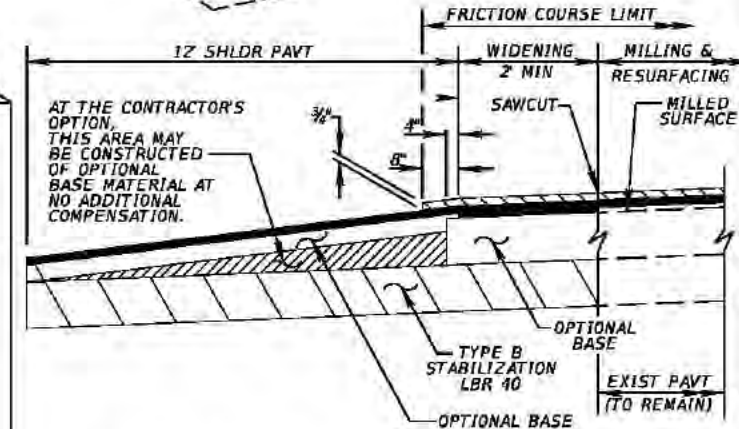

SHOULDER PAVEMENT DETAIL

MILLING, OVERBUILD & RESURFACING (OUTSIDE SHOULDER PAVEMENT)

TYPE SP STRUCTURAL COURSE (TRAFFIC B) (1 1/2") (PG 76-22)

WIDENING (SHOULDER PAVEMENT)

OPTIONAL BASE GROUP 4 WITH
 TYPE SP STRUCTURAL COURSE (TRAFFIC B) (2") (PG 76-22)


REVISIONS			
DATE	DESCRIPTION	DATE	DESCRIPTION

Kimley-Horn and Associates, Inc.
 Certificate Of Authorization No. 696
 Hool Gin Ng, P.E.
 P.E. License No. 58123
 1920 Wekiva Way, Suite 200
 West Palm Beach, Florida 33411

STATE OF FLORIDA DEPARTMENT OF TRANSPORTATION		
ROAD NO.	COUNTY	FINANCIAL PROJECT ID
91	PALM BEACH	406144-1-52-01

TYPICAL SECTION


SHEET
NO.
22

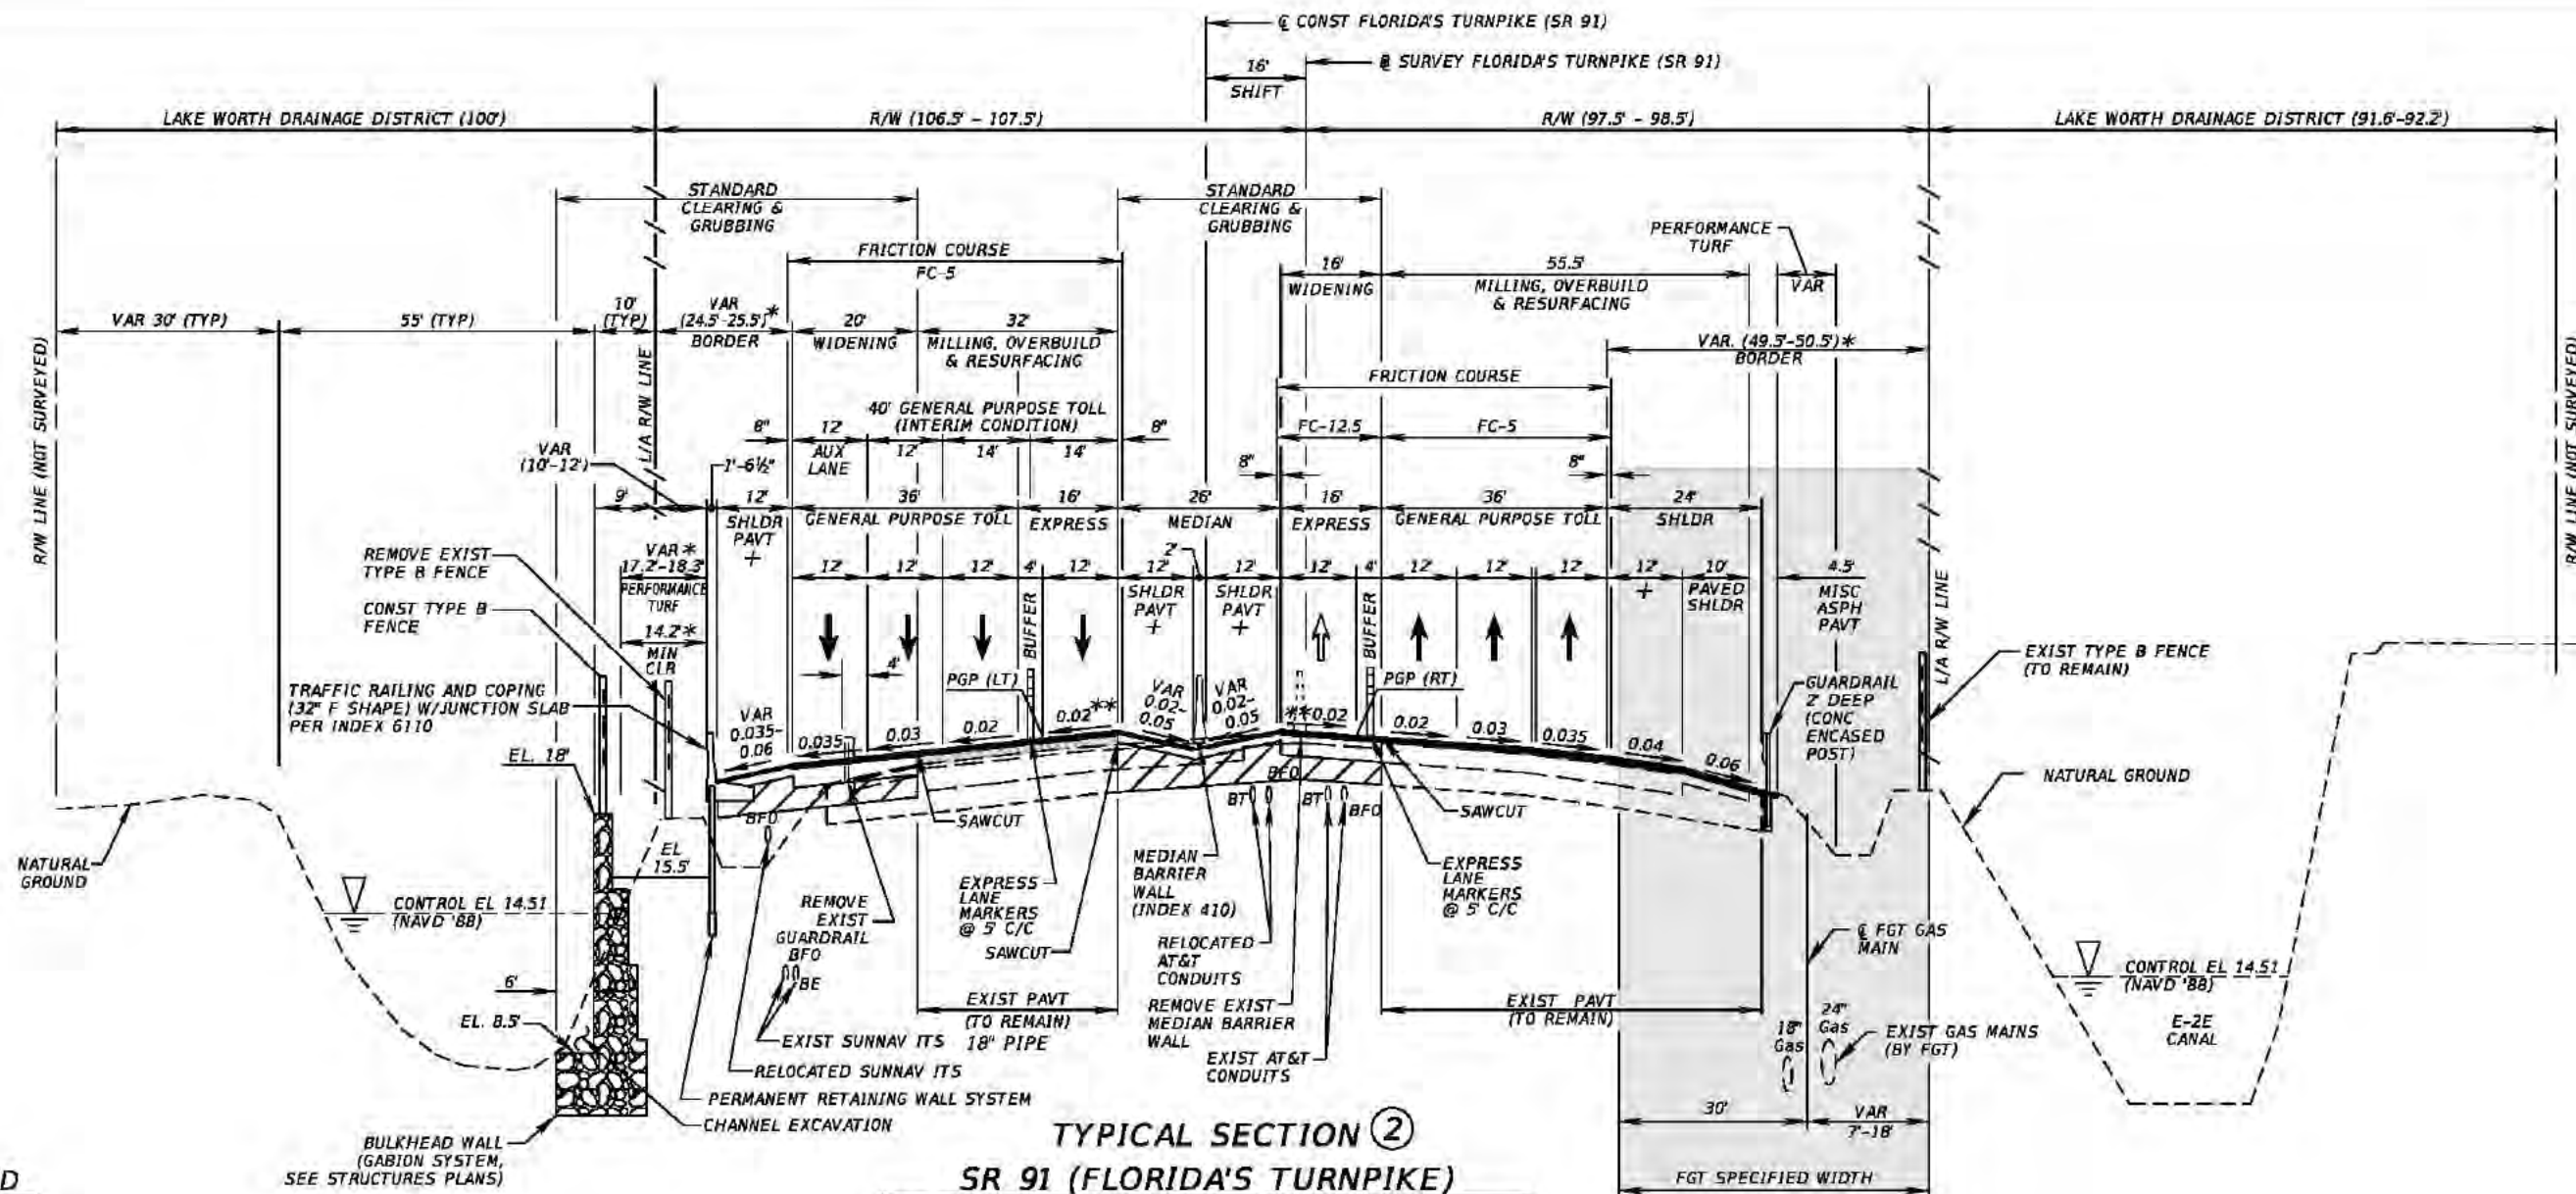

TYPICAL SECTION ②
SR 91 (FLORIDA'S TURNPIKE)
EXISTING 8-LANE ULTIMATE SECTION
APPROXIMATELY 1200' NORTH AND
SOUTH OF C. STANLEY WEAVER
CANAL CROSSING
STA 2099+10.00 TO STA 2111+67.11
STA 2112+54.11 TO STA 2125+10.60

REVISIONS				Kimley-Horn and Associates, Inc. Certificate Of Authorization No. 696 Hool Gin Ng, P.E. P.E. License No. 58123 1920 Wekiva Way, Suite 200 West Palm Beach, Florida 33411	STATE OF FLORIDA DEPARTMENT OF TRANSPORTATION			SHEET NO. 23
DATE	DESCRIPTION	DATE	DESCRIPTION		ROAD NO.	COUNTY	FINANCIAL PROJECT ID	
					91	PALM BEACH	406144-1-52-01	

TYPICAL SECTION

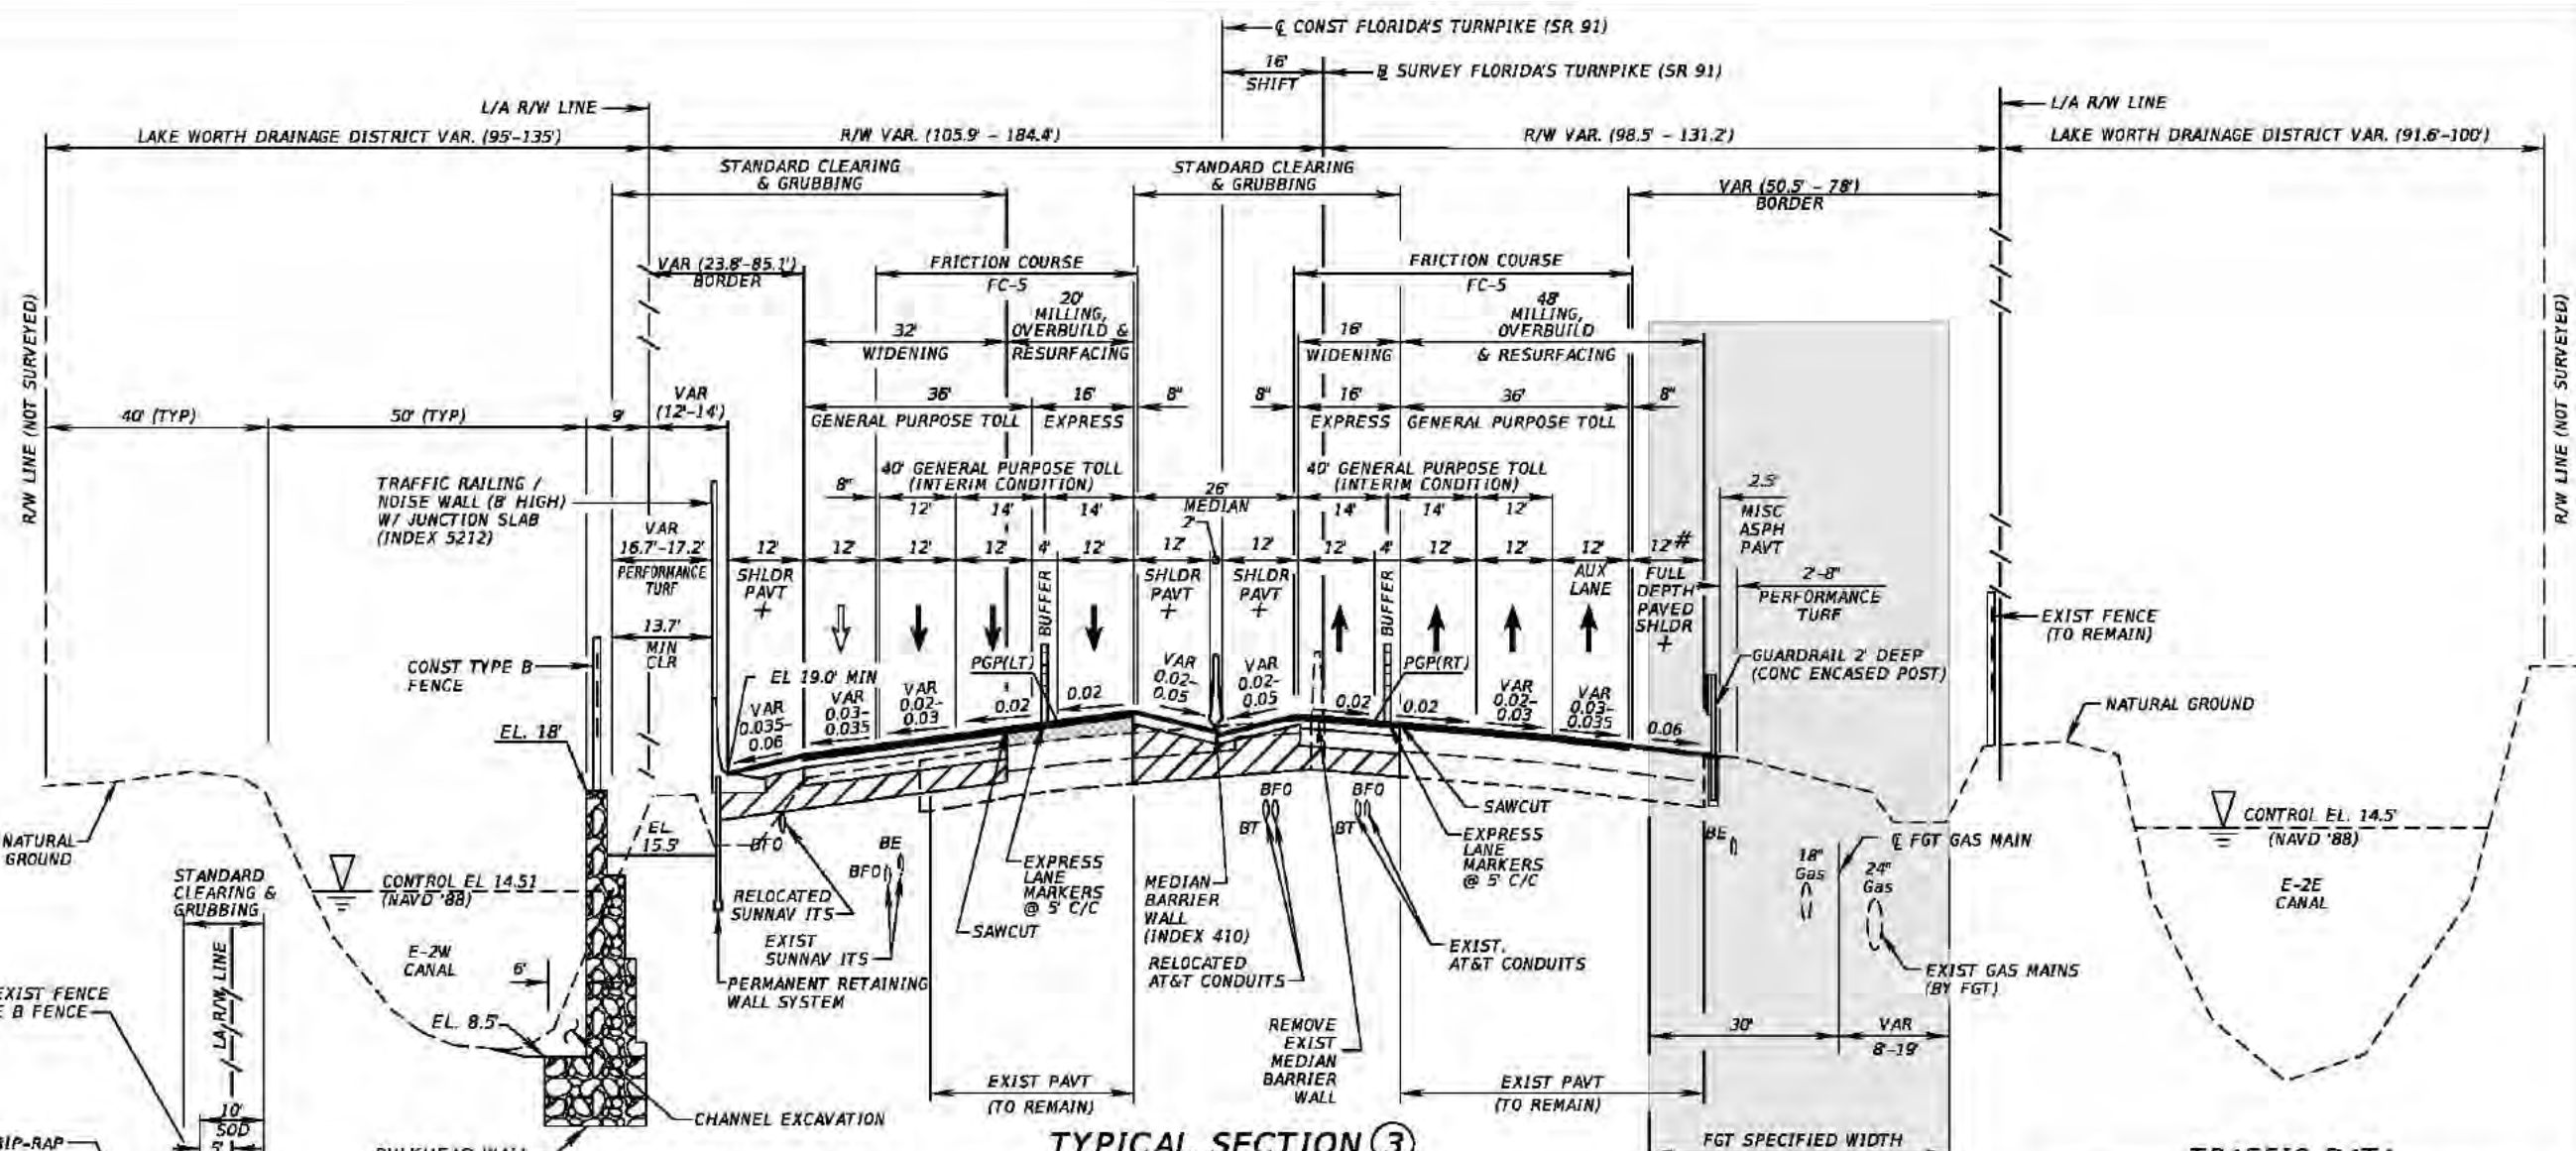

TYPICAL SECTION ③

SR 91 (FLORIDA'S TURNPIKE)

FROM 1200' NORTH OF C. STANLEY WEAVER CANAL
TO LANTANA TOLL PLAZA
STA 2125+10.60 TO STA 2168+79.75

WIDENING & NEW CONSTRUCTION

OPTIONAL BASE GROUP 12 WITH
TYPE SP STRUCTURAL COURSE (TRAFFIC D) (3")
TYPE SP STRUCTURAL COURSE (TRAFFIC D) (2") (PG 76-22)
AND FRICTION COURSE FC-5 (3/4") (PG 76-22)

MILLING, OVERBUILD & RESURFACING

TYPE SP STRUCTURAL COURSE (TRAFFIC D) (2")
AND FRICTION COURSE FC-5 (3/4") (PG 76-22)

MILLING, OVERBUILD & RESURFACING (OUTSIDE SHOULDER PAVEMENT)

TYPE SP STRUCTURAL COURSE (TRAFFIC B) (1 1/2") (PG 76-22)

WIDENING (SHOULDER PAVEMENT)

OPTIONAL BASE GROUP 4 WITH
TYPE SP STRUCTURAL COURSE (TRAFFIC B) (2") (PG 76-22)

TRAFFIC DATA

CURRENT YEAR = 2015 AADT = 73,700
ESTIMATED OPENING YEAR = 2020 AADT = 80,100
ESTIMATED DESIGN YEAR = 2040 AADT = 126,400
K = 9.5% D = 56.6% T = 11.3% (24 HOUR)
DESIGN HOUR T = 6.0%
TRUCK DDHV = 408
DESIGN SPEED = 70 MPH
POSTED SPEED = 65 MPH

LEGEND

- OVERBUILD
- FUTURE LANE
- + CONSTRUCT GROUND-IN RUMBLE STRIPS PER INDEX 518
- # EXISTING PAVEMENT WITHIN FGT SPECIFIED WIDTH TO REMAIN TO MAINTAIN STATUS QUO. POTENTIAL FOR FUTURE LANE

HALF TYPICAL SECTION ③A

LOCALIZED CANAL BANK AND SLOPE RESTORATION
(SEE PLANS FOR LIMITS)


REVISIONS			
DATE	DESCRIPTION	DATE	DESCRIPTION

Kimley-Horn and Associates, Inc.
Certificate of Authorization No. 696
Hool Gin Ng, P.E.
P.E. License No. 58123
1920 Wekiva Way, Suite 200
West Palm Beach, Florida 33411

STATE OF FLORIDA DEPARTMENT OF TRANSPORTATION		
ROAD NO.	COUNTY	FINANCIAL PROJECT ID
91	PALM BEACH	406144-1-52-01

TYPICAL SECTION

SHEET NO.
24

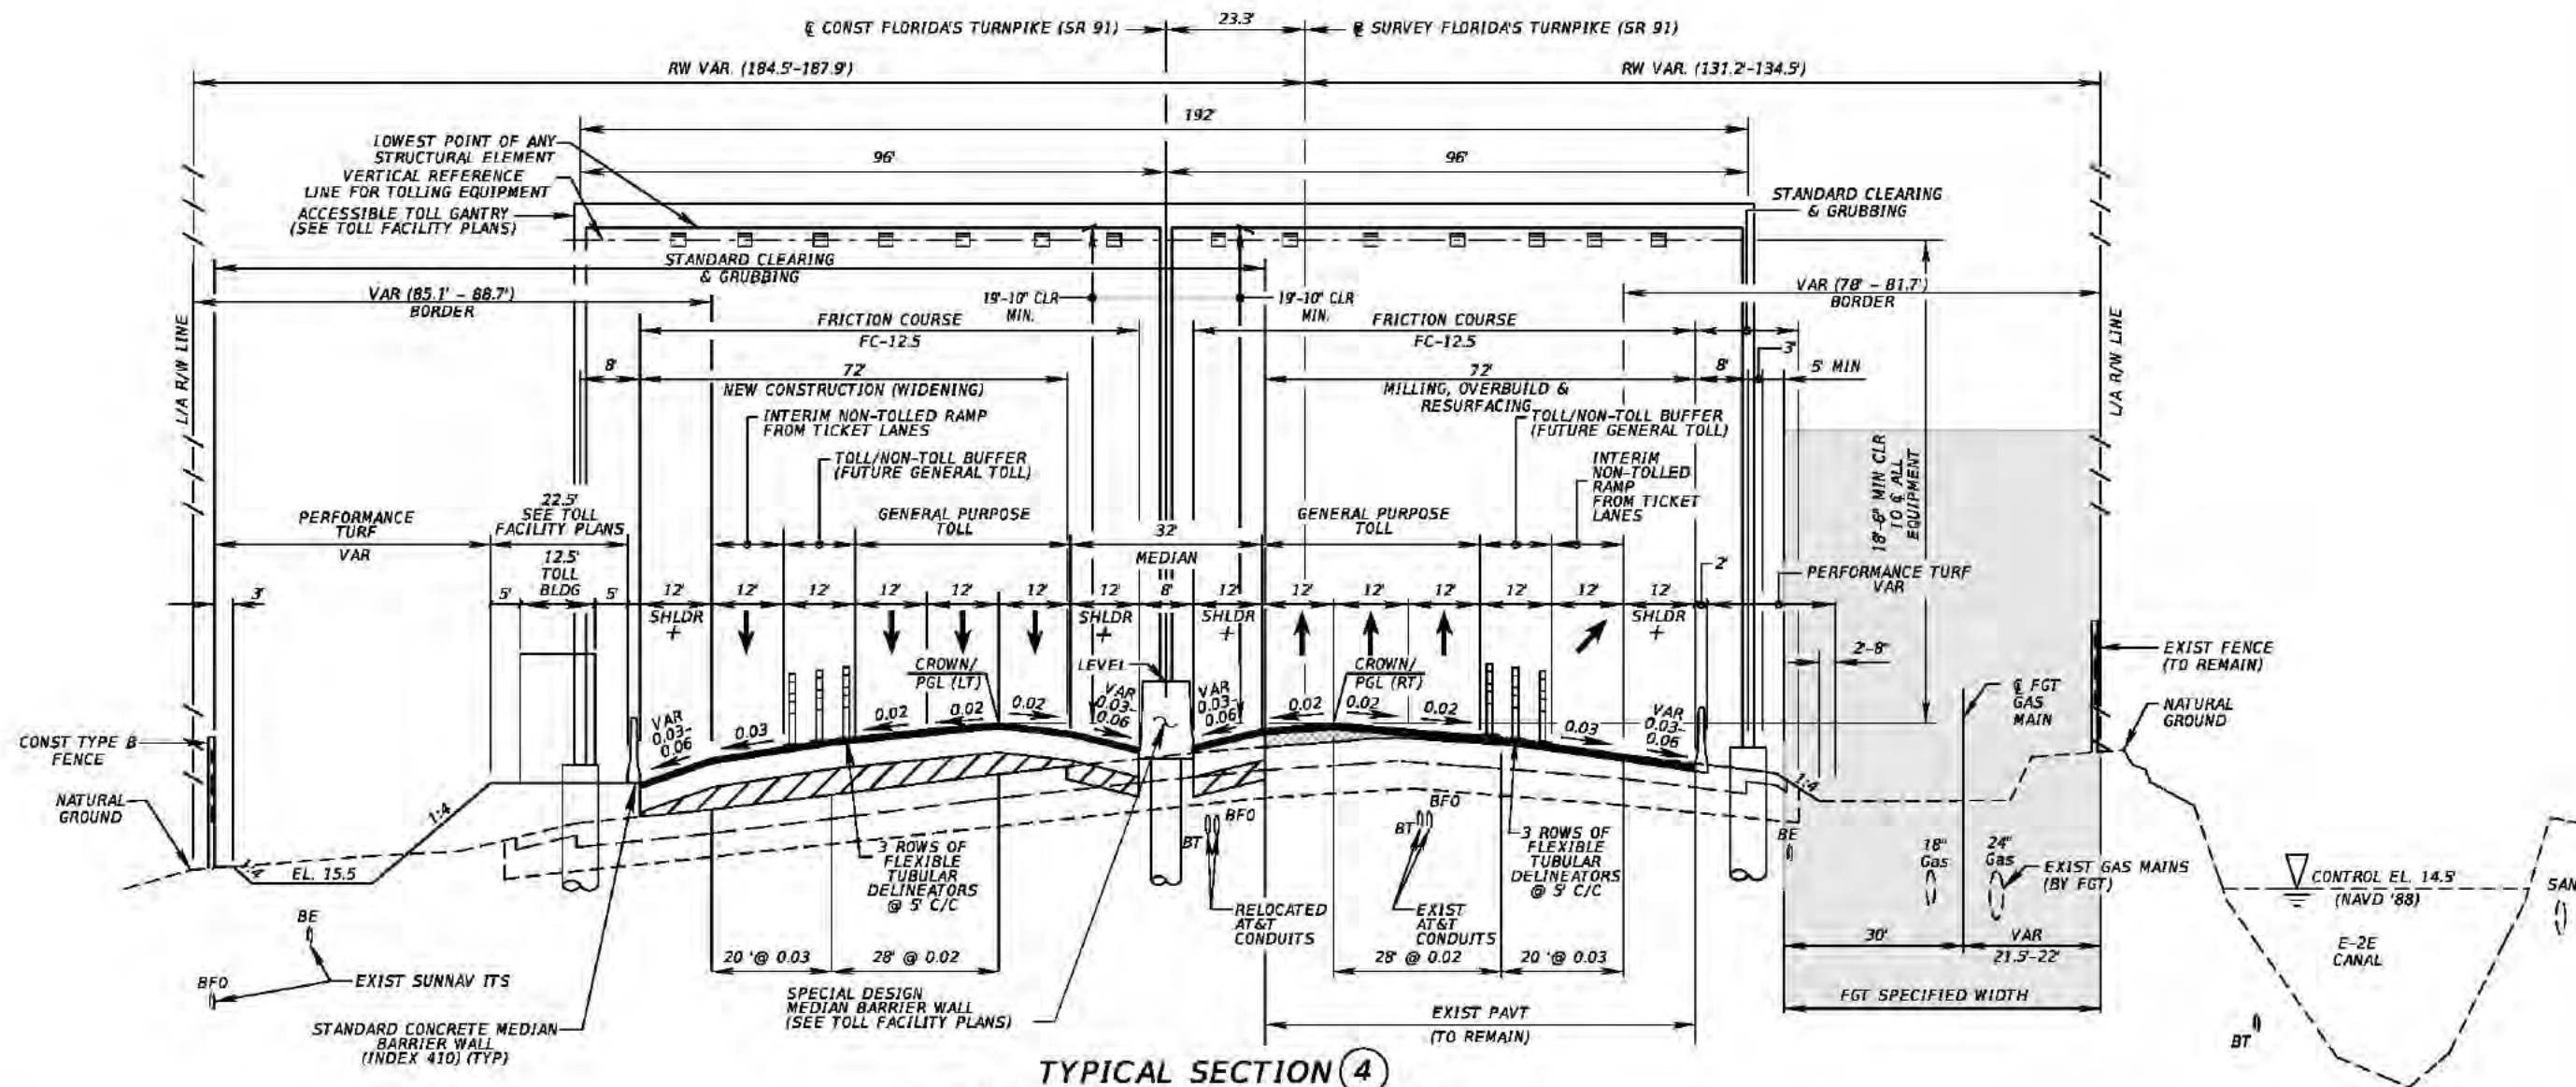

LEGEND



+ CONSTRUCT GROUND-IN RUMBLE STRIPS PER INDEX 518


TRAFFIC DATA

CURRENT YEAR = 2015 AADT = 73,700
ESTIMATED OPENING YEAR = 2020 AADT = 80,100
ESTIMATED DESIGN YEAR = 2040 AADT = 126,400
K = 9.5% D = 56.6% T = 11.3% (24 HOUR)
DESIGN HOUR T = 6.0%
TRUCK DDHV = 408
DESIGN SPEED = 70 MPH
POSTED SPEED = 65 MPH

TYPICAL SECTION (4) SR 91 (FLORIDA'S TURNPIKE) @ AET TOLL GANTRY SOUTH OF LANTANA TOLL PLAZA STA 2181+62.76 TO STA 2182+62.76 WIDENING & NEW CONSTRUCTION

OPTIONAL BASE GROUP 11 WITH
TYPE SP STRUCTURAL COURSE (TRAFFIC D) (4")
TYPE SP STRUCTURAL COURSE (TRAFFIC D) (1 1/2") (PG 76-22)
AND FRICTION COURSE FC-12.5 (1 1/2") (PG 76-22)
MILLING, OVERBUILD & RESURFACING
TYPE SP STRUCTURAL COURSE (TRAFFIC D) (2") (PG 76-22)
AND FRICTION COURSE FC-5 (3/4")
MILLING, OVERBUILD & RESURFACING
(SHOULDER PAVEMENT)
TYPE SP STRUCTURAL COURSE (TRAFFIC B) (1 1/2") (PG 76-22)

REVISIONS				Kimley-Horn and Associates, Inc. Certificate Of Authorization No. 696 Hool Gin Ng, P.E. P.E. License No. 58123 1920 Wekiva Way, Suite 200 West Palm Beach, Florida 33411	STATE OF FLORIDA DEPARTMENT OF TRANSPORTATION			TYPICAL SECTION SHEET NO. 25
DATE	DESCRIPTION	DATE	DESCRIPTION		ROAD NO.	COUNTY	FINANCIAL PROJECT ID	
					91	PALM BEACH	406144-1-52-01	

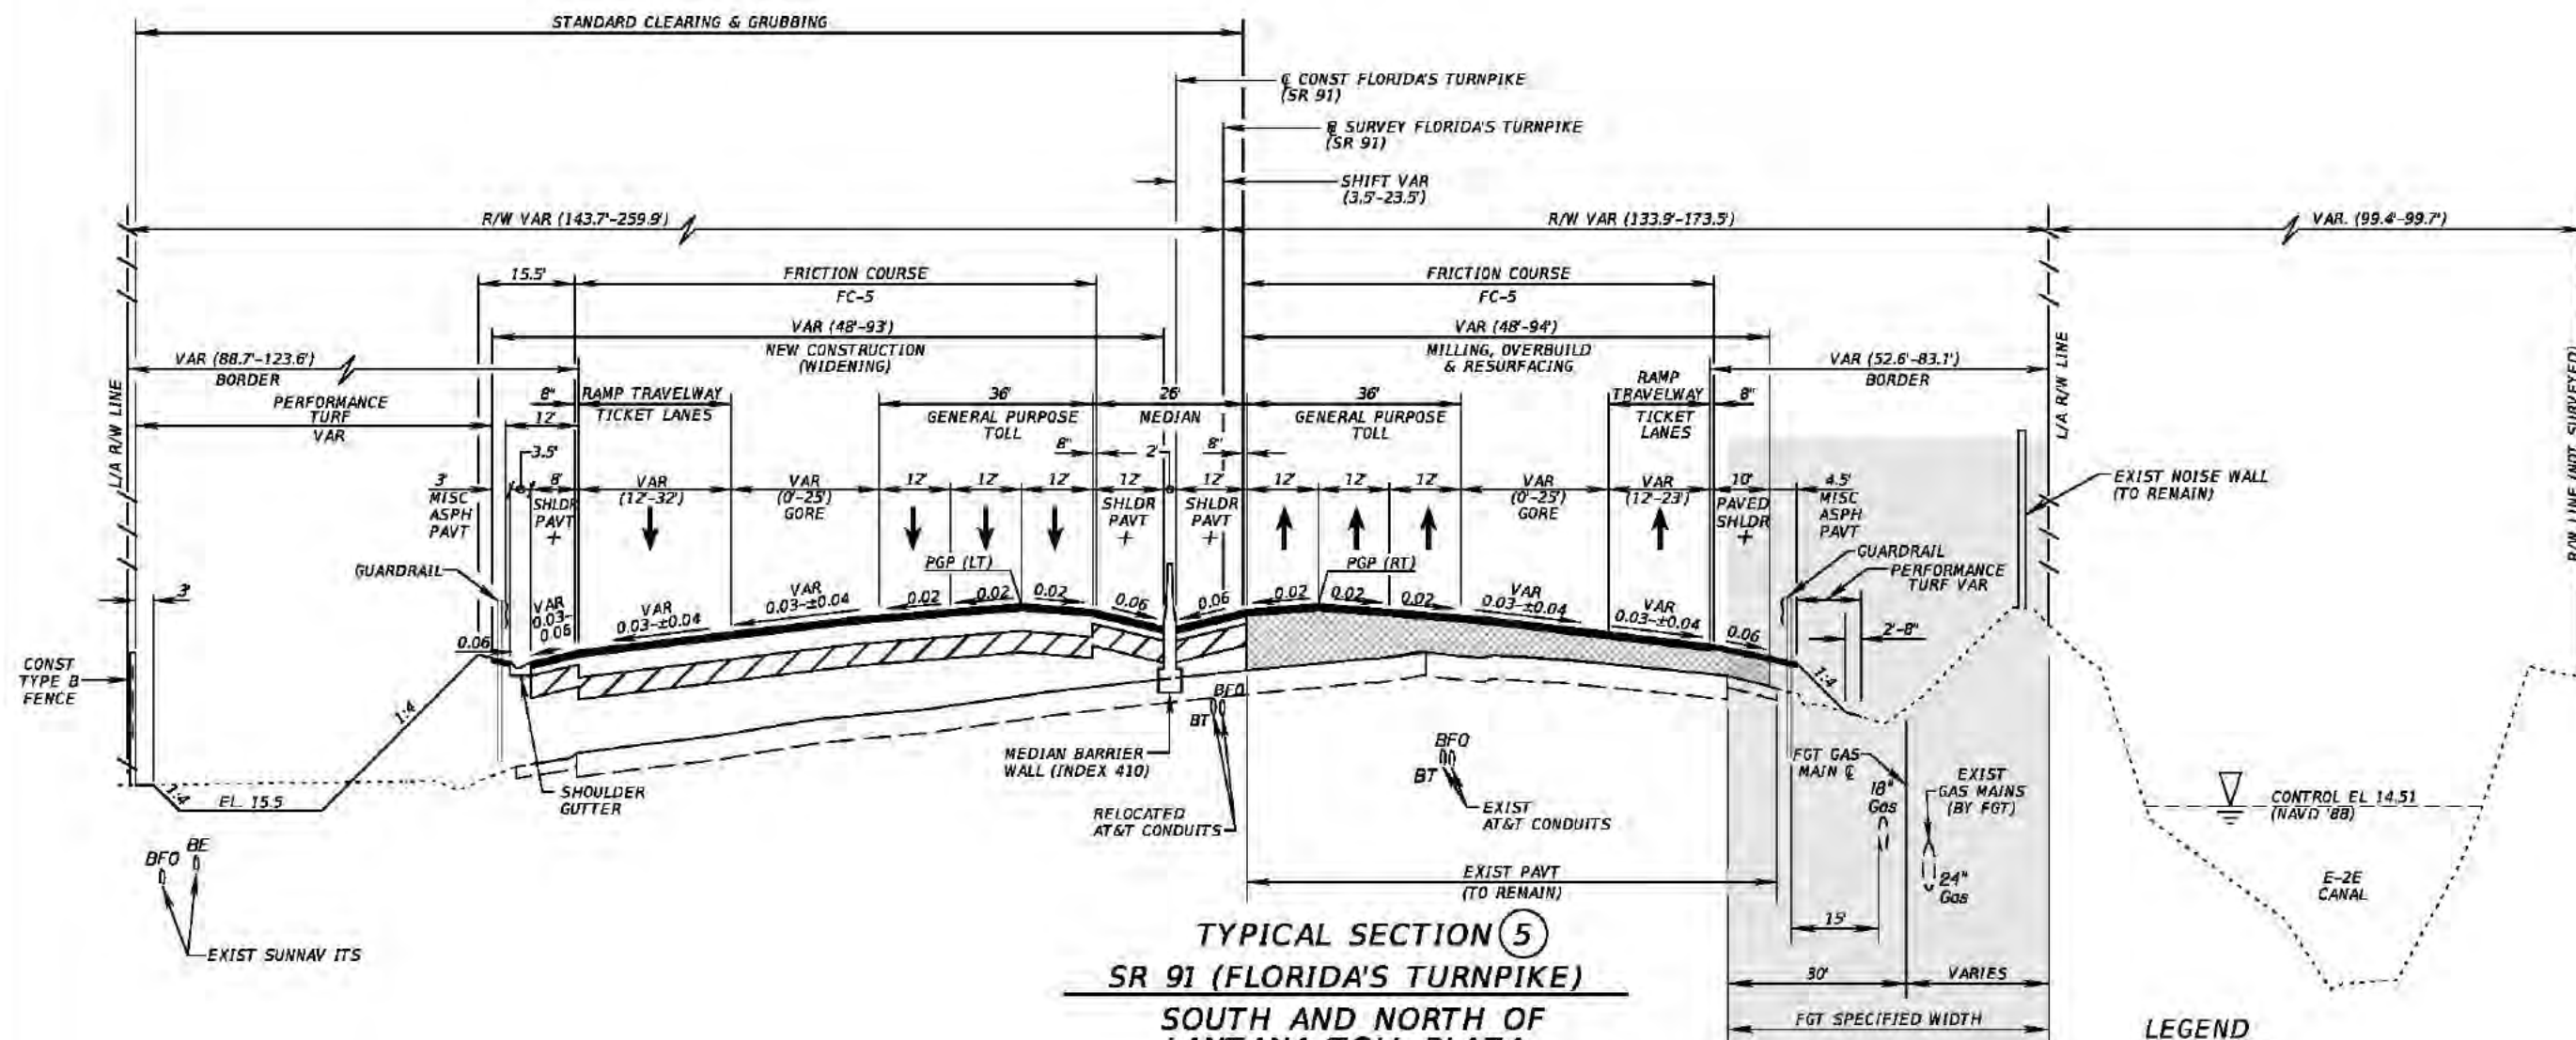

TYPICAL SECTION 5
SR 91 (FLORIDA'S TURNPIKE)
SOUTH AND NORTH OF
LANTANA TOLL PLAZA
STA 2168+79.76 TO STA 2181+62.76
STA 2182+62.76 TO STA 2191+46.20
STA 2206+30.00 TO STA 2215+04.49

LEGEND

- OVERBUILD
 + CONSTRUCT GROUND-IN RUMBLE STRIPS PER INDEX 518

TRAFFIC DATA

CURRENT YEAR = 2015 AADT = 73,700
 ESTIMATED OPENING YEAR = 2020 AADT = 80,100
 ESTIMATED DESIGN YEAR = 2040 AADT = 126,400
 K = 9.5% D = 56.6% T = 11.3% (24 HOUR)
 DESIGN HOUR T = 6.0%
 TRUCK DDHV = 408
 DESIGN SPEED = 70 MPH
 POSTED SPEED = 65 MPH

WIDENING & NEW CONSTRUCTION

OPTIONAL BASE GROUP 12 WITH
 TYPE SP STRUCTURAL COURSE (TRAFFIC D) (3")
 TYPE SP STRUCTURAL COURSE (TRAFFIC D) (2") (PG 76-22)
 AND FRICTION COURSE FC-5 (3/4") (PG 76-22)

MILLING, OVERBUILD & RESURFACING

TYPE SP STRUCTURAL COURSE (TRAFFIC D) (2")
 AND FRICTION COURSE FC-5 (TRAFFIC D) (3/4") (PG 76-22)

WIDENING (SHOULDER PAVEMENT)

OPTIONAL BASE GROUP 4 WITH
 TYPE SP STRUCTURAL COURSE (TRAFFIC B) (2") (PG 76-22)

WIDENING & NEW CONSTRUCTION [TICKET LANES]

OPTIONAL BASE GROUP 11 WITH
 TYPE SP STRUCTURAL COURSE (TRAFFIC D) (2")
 TYPE SP STRUCTURAL COURSE (TRAFFIC D) (2") (PG 76-22)
 AND FRICTION COURSE FC-5 (3/4") (PG 76-22)

MILLING, OVERBUILD & RESURFACING [TICKET LANES]

TYPE SP STRUCTURAL COURSE (TRAFFIC D) (2") (PG 76-22)
 AND FRICTION COURSE FC-5 (3/4") (PG 76-22)

SHOULDER PAVEMENT [TICKET LANES]

OPTIONAL BASE GROUP 3 WITH
 TYPE SP STRUCTURAL COURSE (TRAFFIC B) (2") (PG 76-22)

MILLING, OVERBUILD & RESURFACING
[TICKET LANES] (SHOULDER PAVEMENT)
 TYPE SP STRUCTURAL COURSE (TRAFFIC B) (1 1/2") (PG 76-22)


REVISIONS			
DATE	DESCRIPTION	DATE	DESCRIPTION

Kimley-Horn and Associates, Inc.
 Certificate Of Authorization No. 696
 Hoel Gin Ng, P.E.
 P.E. License No. 58123
 1920 Wekiva Way, Suite 200
 West Palm Beach, Florida 33411

STATE OF FLORIDA DEPARTMENT OF TRANSPORTATION		
ROAD NO.	COUNTY	FINANCIAL PROJECT ID
91	PALM BEACH	406144-1-52-01

TYPICAL SECTION

SHEET
NO.
26

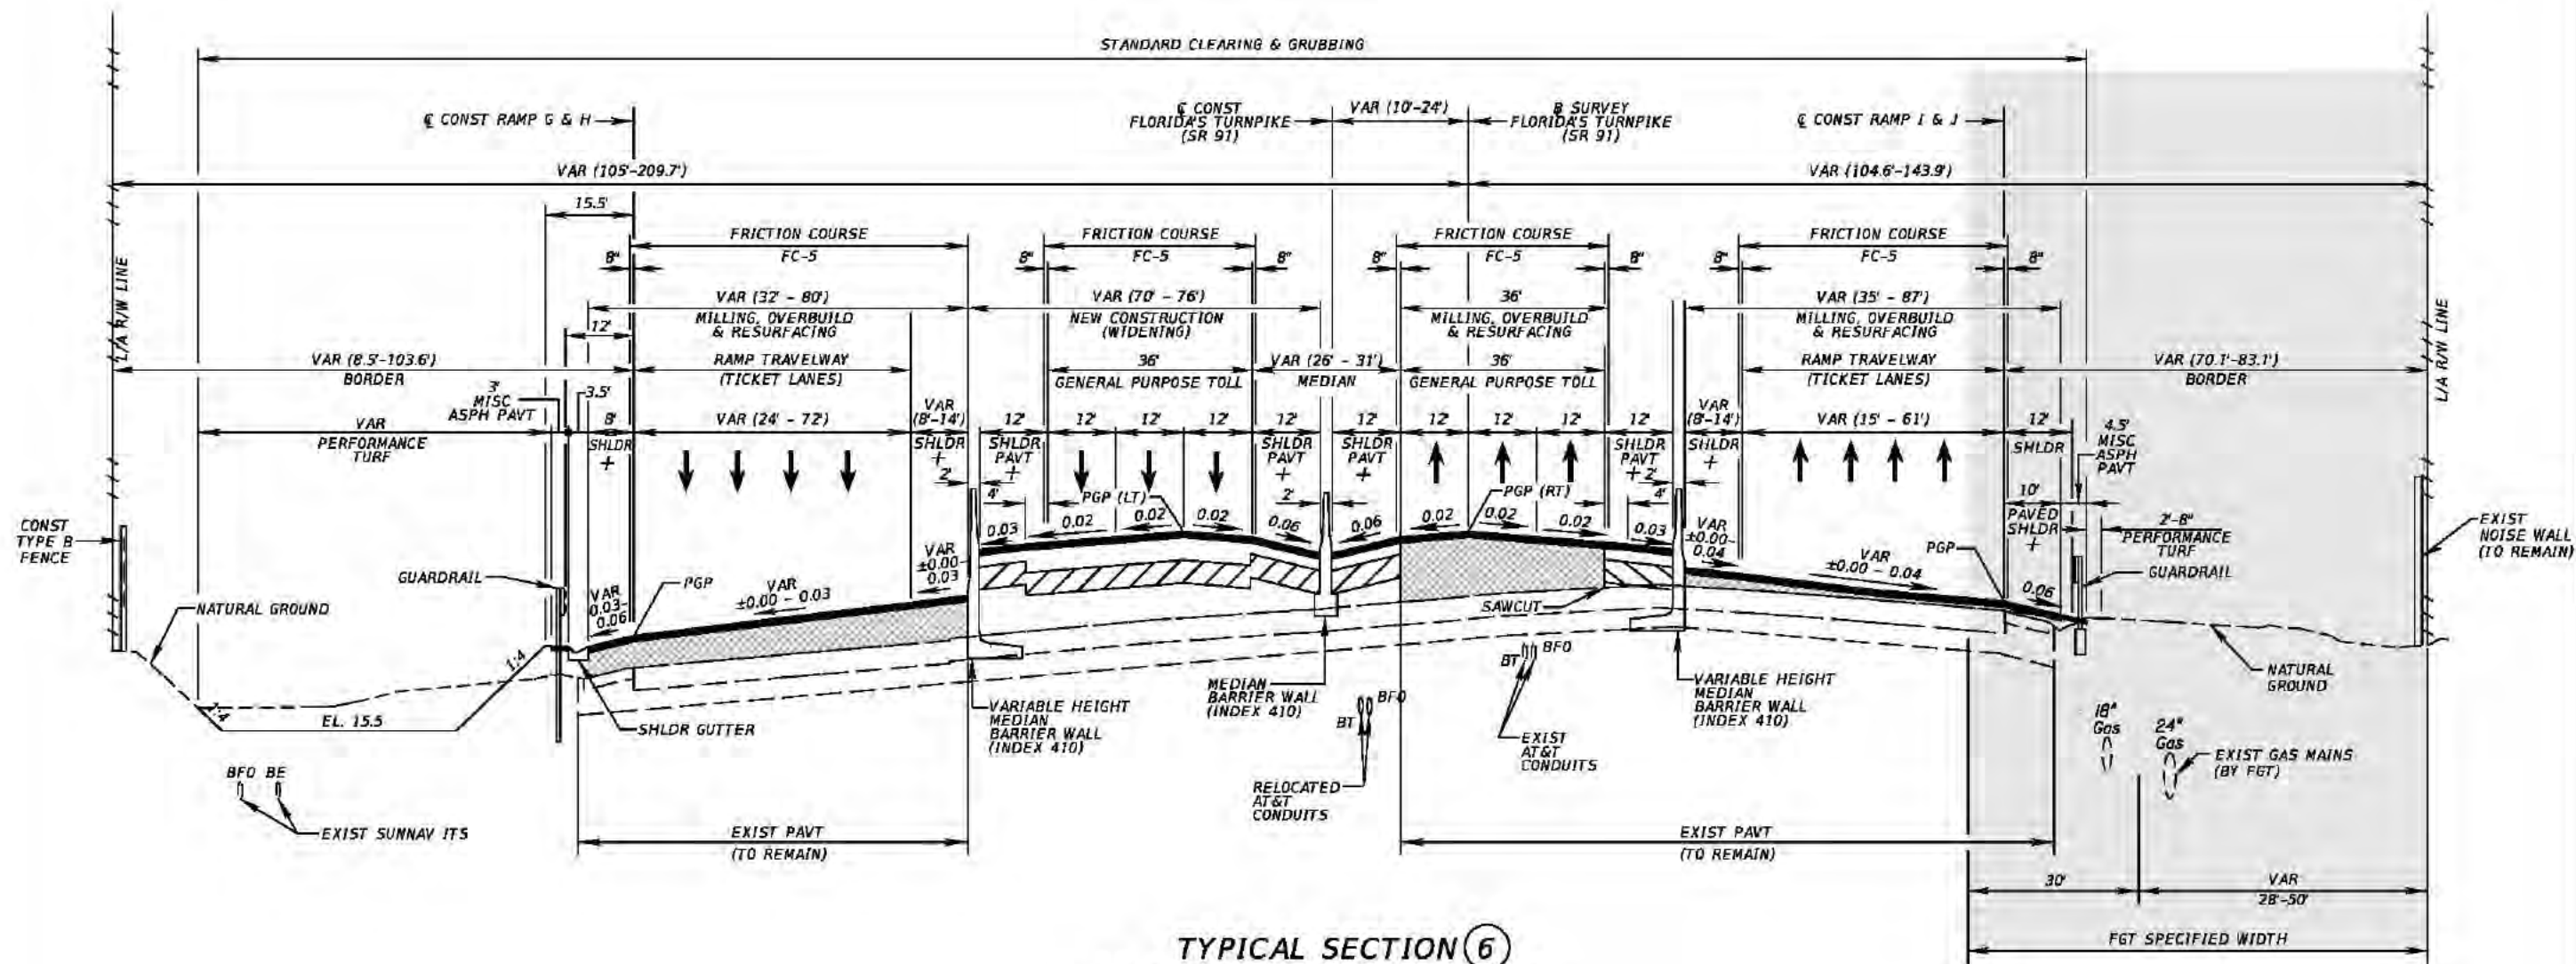

TYPICAL SECTION ⑥
SR 91 (FLORIDA'S TURNPIKE)
SOUTH AND NORTH OF
LANTANA TOLL PLAZA
STA 2191+46.20 TO STA 2198+74.50
STA 2200+73.85 TO STA 2206+30.00

LEGEND

OVERBUILD
 + CONSTRUCT GROUND-IN RUMBLE STRIPS PER INDEX 518

TRAFFIC DATA

CURRENT YEAR = 2015 AADT = 73,700
 ESTIMATED OPENING YEAR = 2020 AADT = 80,100
 ESTIMATED DESIGN YEAR = 2040 AADT = 126,400
 K = 9.5% D = 56.6% T = 11.3% (24 HOUR)
 DESIGN HOUR T = 6.0%
 TRUCK DDHV = 408
 DESIGN SPEED = 70 MPH
 POSTED SPEED = 65 MPH

WIDENING & NEW CONSTRUCTION

OPTIONAL BASE GROUP 11 WITH
 TYPE SP STRUCTURAL COURSE (TRAFFIC D) (2")
 TYPE SP STRUCTURAL COURSE (TRAFFIC D) (2") (PG 76-22)
 AND FRICTION COURSE FC-5 (3/4") (PG 76-22)

MILLING, OVERBUILD & RESURFACING

TYPE SP STRUCTURAL COURSE (TRAFFIC D) (2") (PG 76-22)
 AND FRICTION COURSE FC-5 (3/4") (PG 76-22)

SHOULDER PAVEMENT


OPTION BASE GROUP 3 WITH
 TYPE SP STRUCTURAL COURSE (TRAFFIC B) (2") (PG 76-22)

**MILLING, OVERBUILD & RESURFACING
 (SHOULDER PAVEMENT)**

TYPE SP STRUCTURAL COURSE (TRAFFIC B) (1 1/2") (PG 76-22)

REVISIONS				Kimley-Horn and Associates, Inc. Certificate of Authorization No. 696 Hool Gin Ng, P.E. P.E. License No. 58123 1920 Wekiva Way, Suite 200 West Palm Beach, Florida 33411	STATE OF FLORIDA DEPARTMENT OF TRANSPORTATION			SHEET NO. 27
DATE	DESCRIPTION	DATE	DESCRIPTION		ROAD NO.	COUNTY	FINANCIAL PROJECT ID	
					91	PALM BEACH	406144-1-52-01	

TYPICAL SECTION

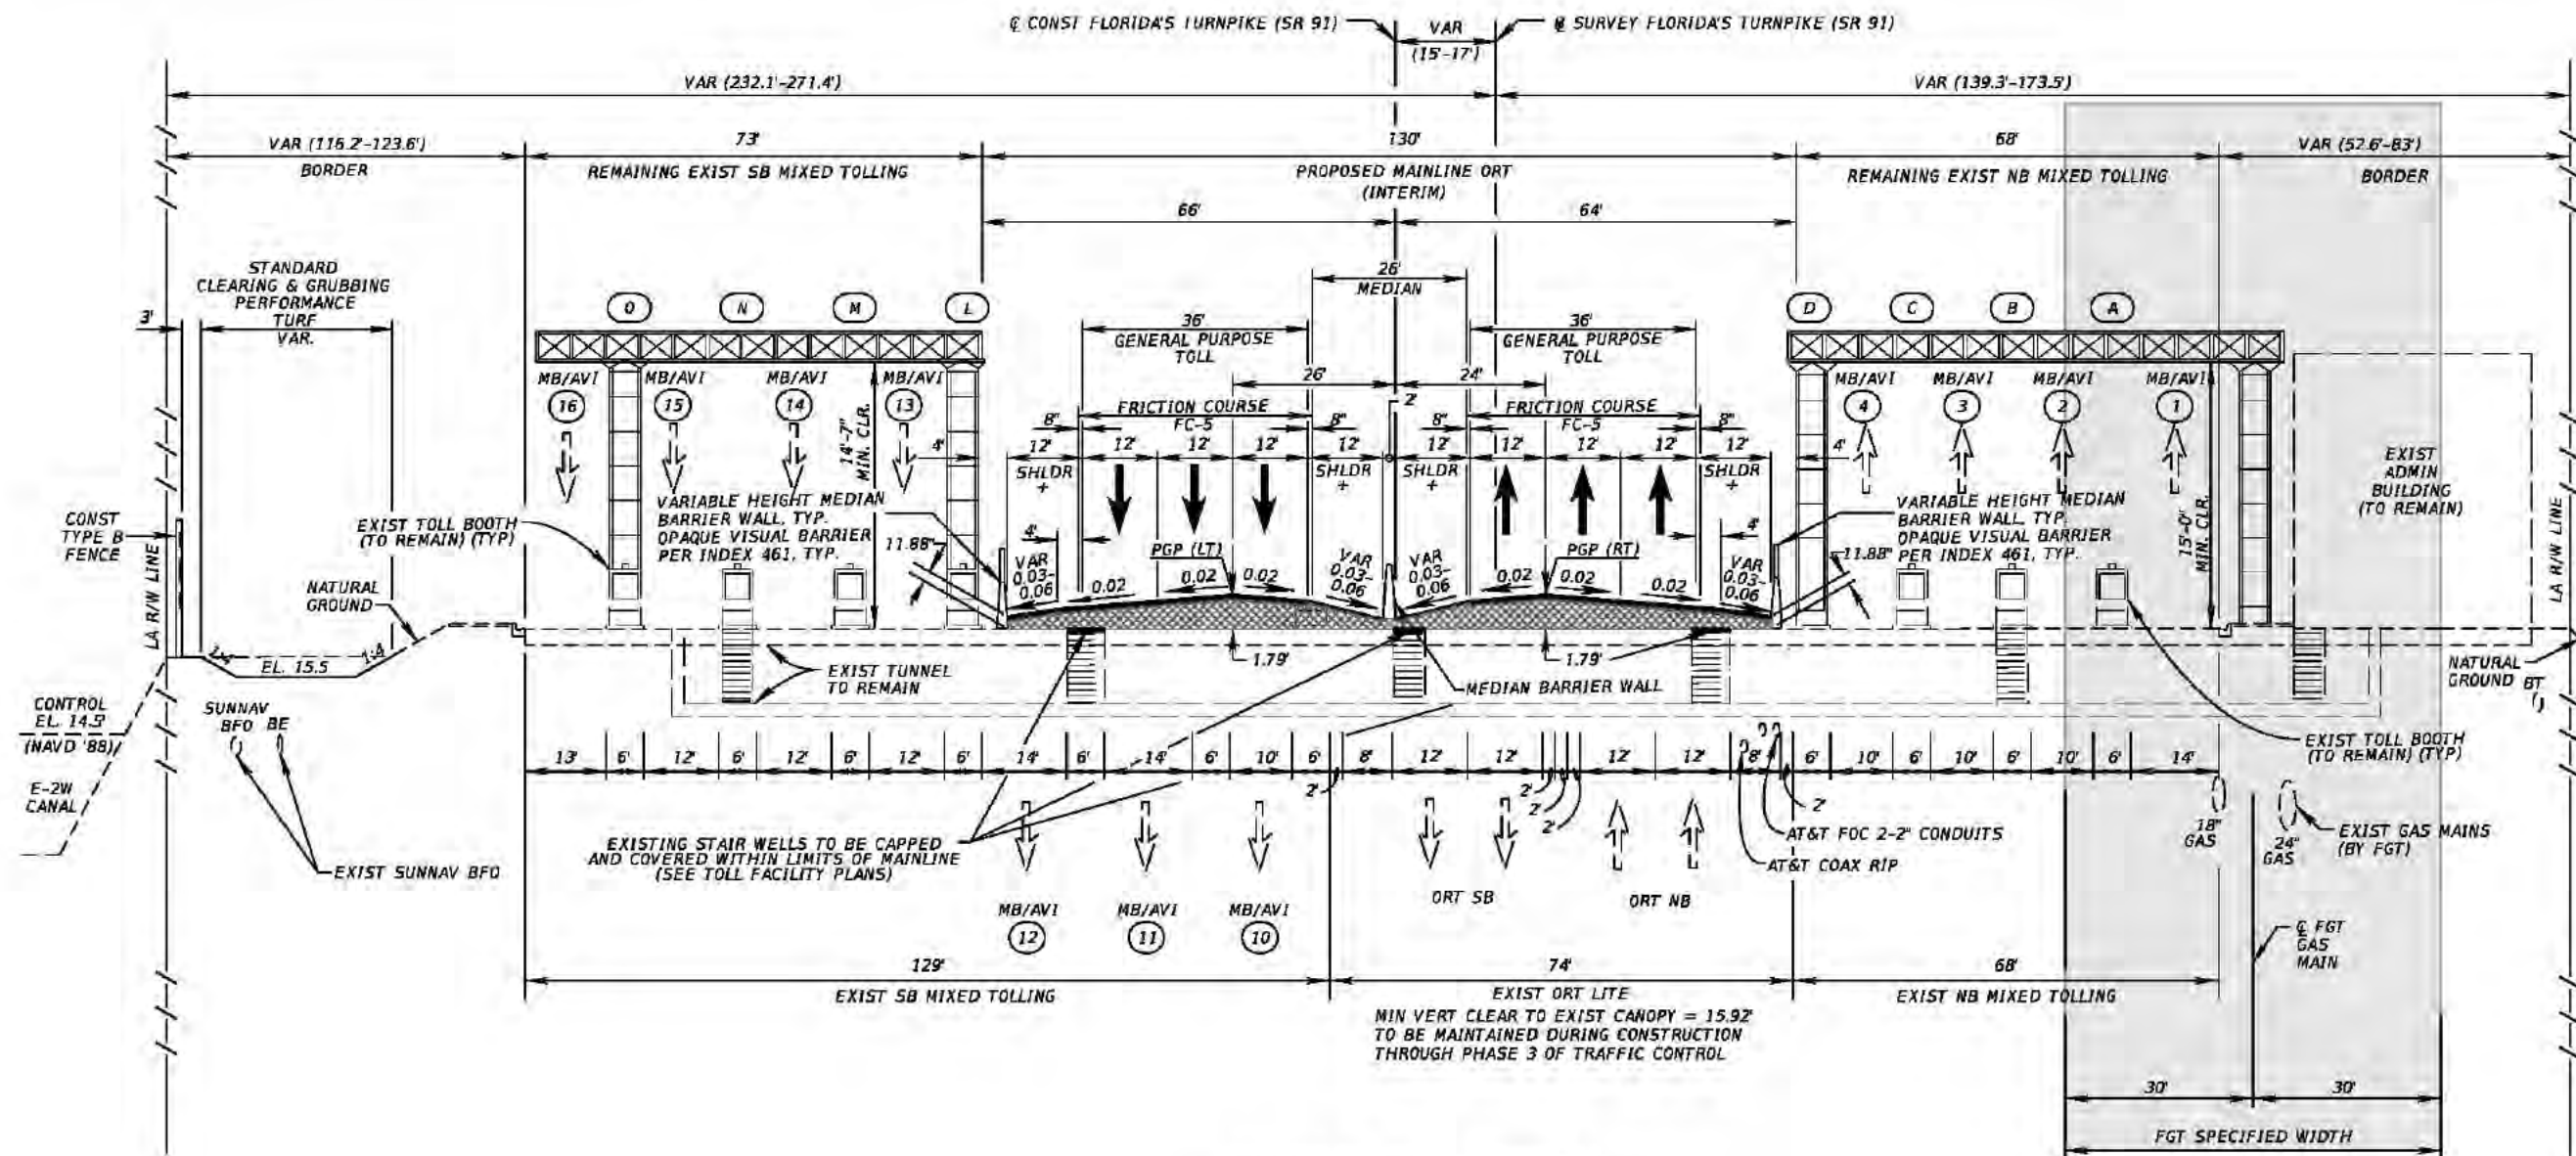

TYPICAL SECTION ⑦
SR 91 (FLORIDA'S TURNPIKE)
@ LANTANA TOLL PLAZA
STA 2198+74.50 TO STA 2200+73.85

TRAFFIC DATA

CURRENT YEAR = 2015 AADT = 73,700
 ESTIMATED OPENING YEAR = 2020 AADT = 80,100
 ESTIMATED DESIGN YEAR = 2040 AADT = 126,400
 K = 9.5% D = 56.6% T = 11.3% (24 HOUR)
 DESIGN HOUR T = 6.0%
 TRUCK DDHV = 408
 DESIGN SPEED = 70 MPH
 POSTED SPEED = 65 MPH

LEGEND




OVERBUILD

NOTE:
 SEE TOLL FACILITY PLANS
 FOR ADDITIONAL INFORMATION.

+CONSTRUCT GROUND-IN RUMBLE STRIPS PER INDEX 518

REVISIONS				Kimley-Horn and Associates, Inc. Certificate Of Authorization No. 696 Hool Gin Ng, P.E. P.E. License No. 58123 1920 Wekiva Way, Suite 200 West Palm Beach, Florida 33411	STATE OF FLORIDA DEPARTMENT OF TRANSPORTATION			TYPICAL SECTION	SHEET NO.
DATE	DESCRIPTION	DATE	DESCRIPTION		ROAD NO.	COUNTY	FINANCIAL PROJECT ID		28
					91	PALM BEACH	406144-1-52-01		

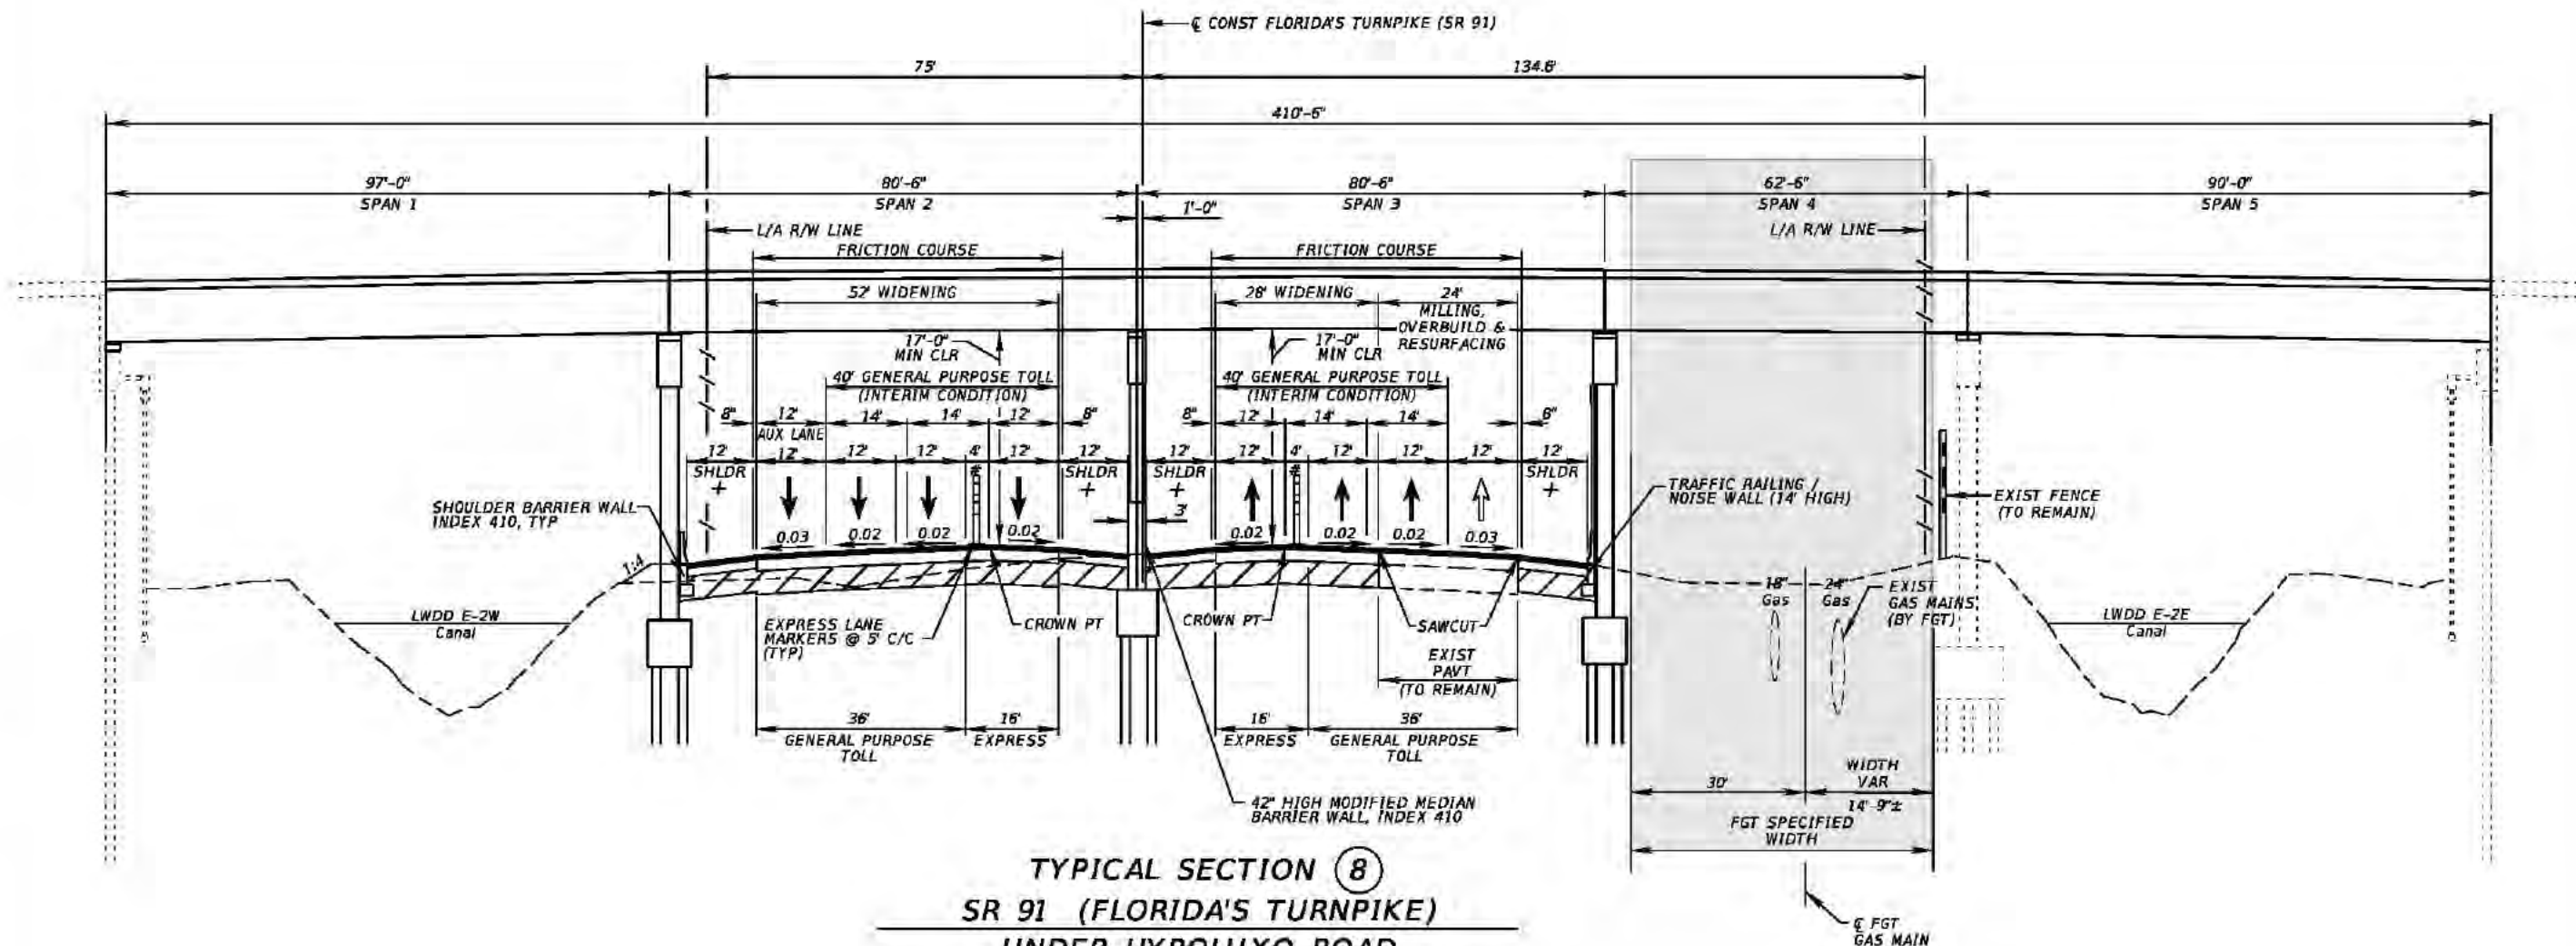

TYPICAL SECTION (8)
SR 91 (FLORIDA'S TURNPIKE)
UNDER HYPOLUXO ROAD
BRIDGE NO. 934367
STA 2233+24.00 TO STA 2234+07.00

TRAFFIC DATA

CURRENT YEAR = 2015 AADT = 73,700
 ESTIMATED OPENING YEAR = 2020 AADT = 80,100
 ESTIMATED DESIGN YEAR = 2040 AADT = 126,400
 K = 9.5% D = 56.6% T = 11.3% (24 HOUR)
 DESIGN HOUR T = 6.0%
 TRUCK DDHV = 408
 DESIGN SPEED = 70 MPH
 POSTED SPEED = 70 MPH

WIDENING & NEW CONSTRUCTION

OPTIONAL BASE GROUP 12 WITH
 TYPE SP STRUCTURAL COURSE (TRAFFIC D) (3"),
 TYPE SP STRUCTURAL COURSE (TRAFFIC D) (2") (PG 76-22)
 AND FRICTION COURSE FC-5 (3/4") (PG 76-22)

MILLING, OVERBUILD & RESURFACING

TYPE SP STRUCTURAL COURSE (TRAFFIC D) (2")
 AND FRICTION COURSE FC-5 (TRAFFIC D) (3/4") (PG 76-22)

**WIDENING & NEW CONSTRUCTION
 (FUTURE EXPRESS LANE)**

OPTIONAL BASE GROUP 11 WITH
 TYPE SP STRUCTURAL COURSE (TRAFFIC D) (3"),
 TYPE SP STRUCTURAL COURSE (TRAFFIC D) (1 1/2") (PG 76-22)
 AND FRICTION COURSE FC-5 (1 1/2") (PG 76-22)

**MILLING, OVERBUILD & RESURFACING
 (INSIDE SHOULDER PAVEMENT)**

TYPE SP STRUCTURAL COURSE (TRAFFIC B) (1") (PG 76-22)

**MILLING, OVERBUILD & RESURFACING
 (OUTSIDE SHOULDER PAVEMENT)**

TYPE SP STRUCTURAL COURSE (TRAFFIC B) (1 1/2") (PG 76-22)


WIDENING (SHOULDER PAVEMENT)

OPTIONAL BASE GROUP 4 WITH
 TYPE SP STRUCTURAL COURSE (TRAFFIC B) (2") (PG 76-22)

LEGEND

- ↑ FUTURE LANE
- + CONSTRUCT GROUND-IN RUMBLE STRIPS PER INDEX 518
- # EXPRESS LANE BUFFER

REVISIONS				Kimley-Horn and Associates, Inc. Certificate Of Authorization No. 696 Hool Gin Ng, P.E. P.E. License No. 58123 1920 Wekiva Way, Suite 200 West Palm Beach, Florida 33411	STATE OF FLORIDA DEPARTMENT OF TRANSPORTATION			TYPICAL SECTION SHEET NO. 29
DATE	DESCRIPTION	DATE	DESCRIPTION		ROAD NO.	COUNTY	FINANCIAL PROJECT ID	
					91	PALM BEACH	406144-1-52-01	

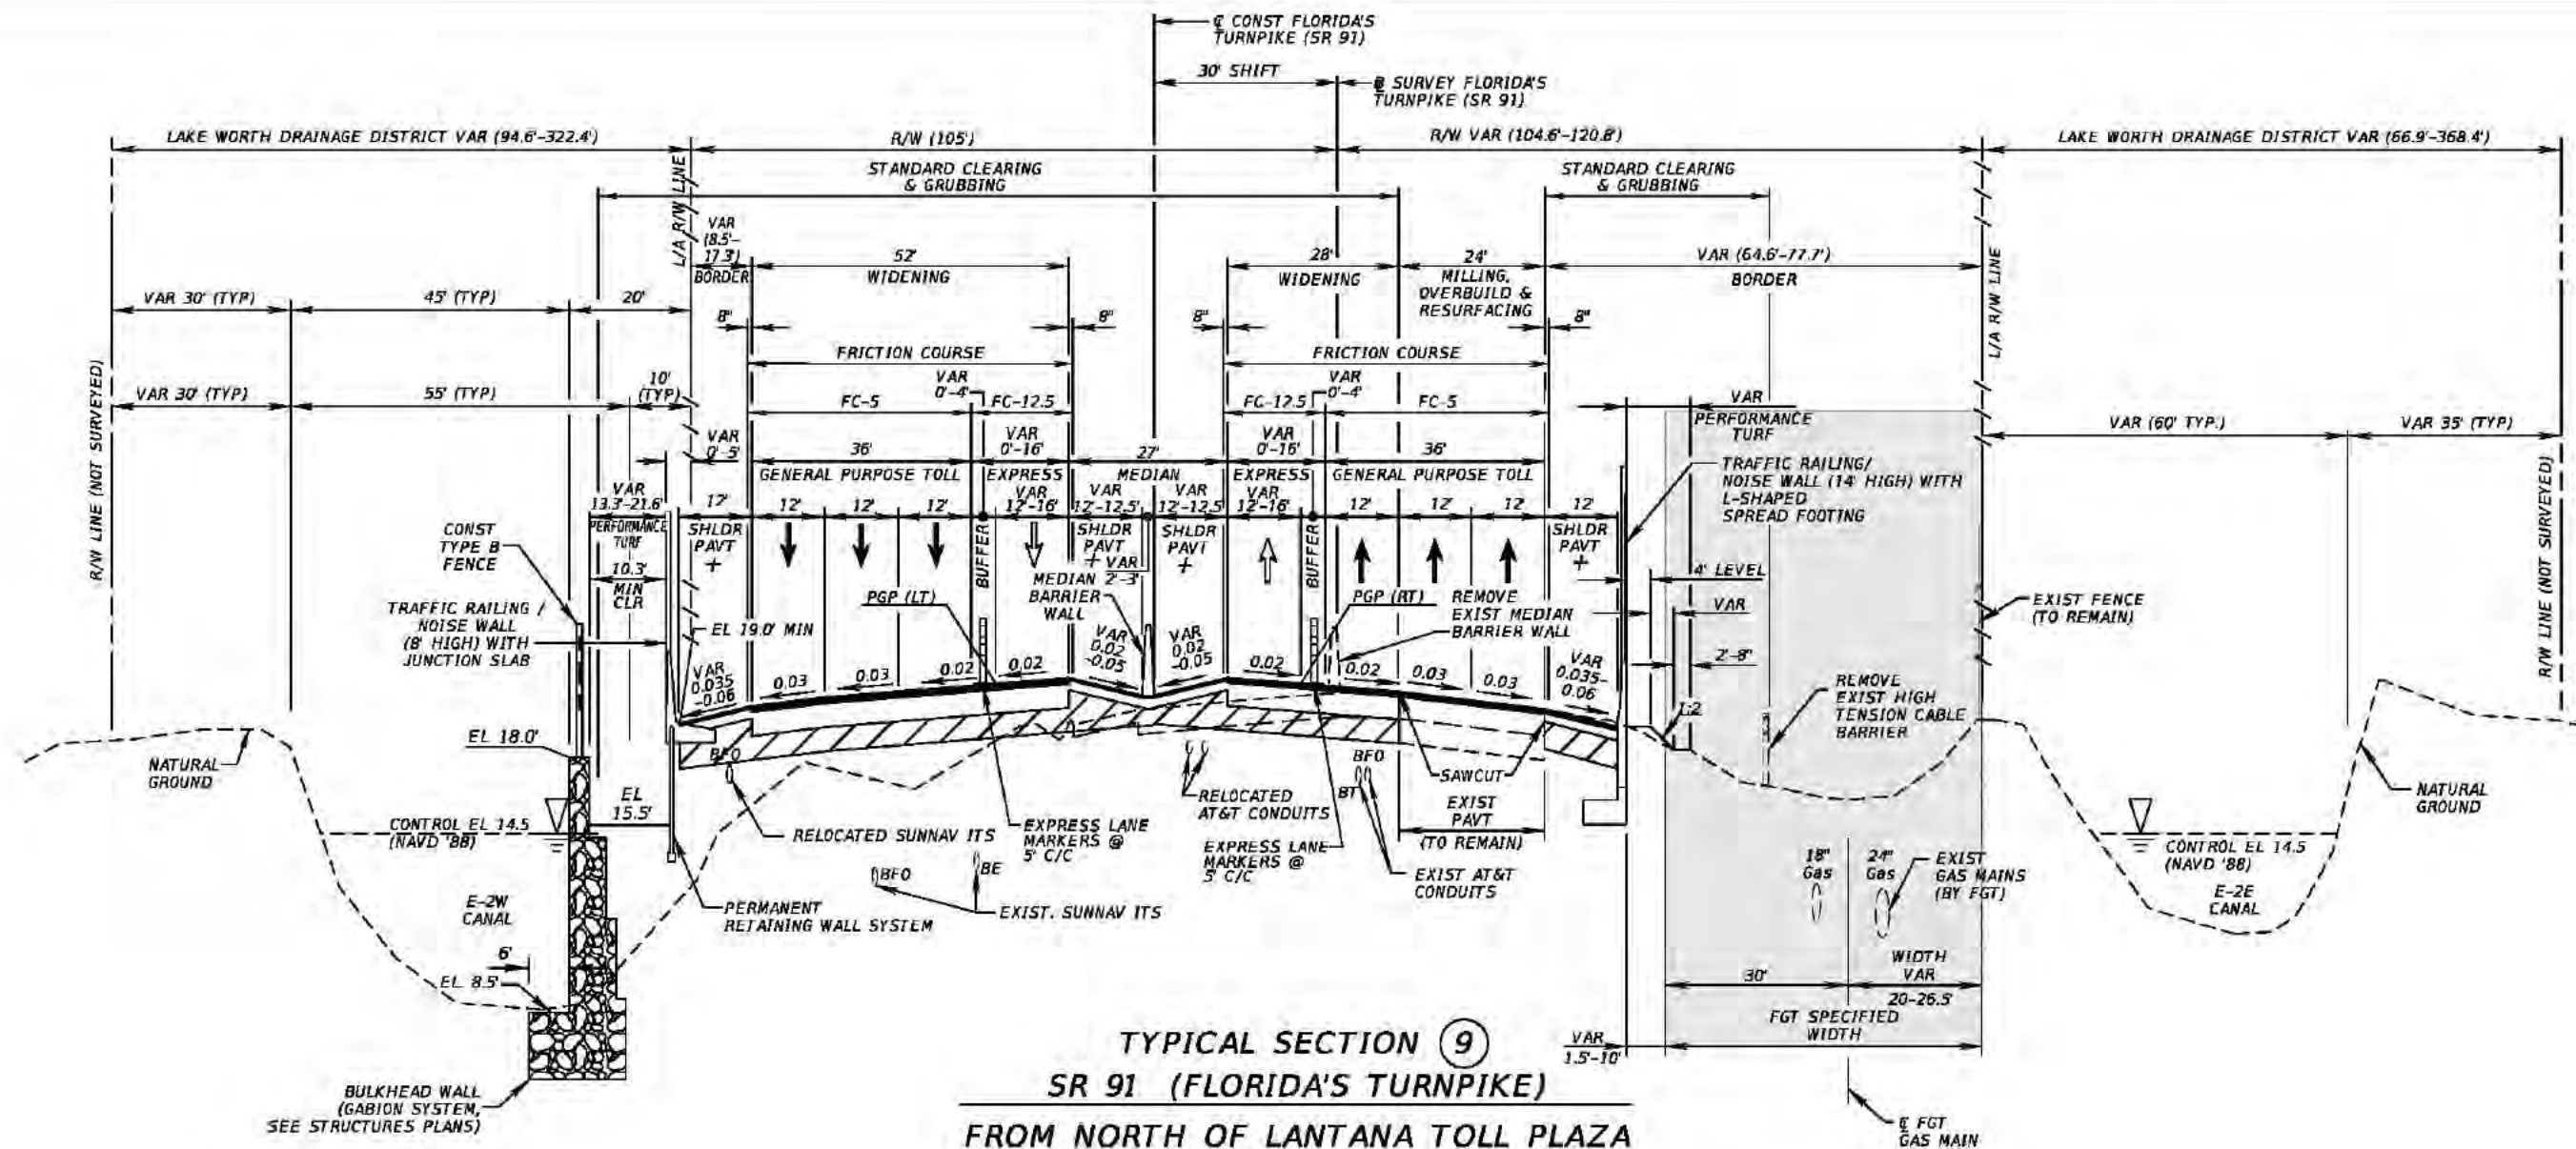

TRAFFIC DATA

CURRENT YEAR = 2015 AADT = 73,700
 ESTIMATED OPENING YEAR = 2020 AADT = 80,100
 ESTIMATED DESIGN YEAR = 2040 AADT = 126,400
 K = 9.5% D = 56.6% T = 11.3% (24 HOUR)
 DESIGN HOUR T = 6.0%
 TRUCK DDHV = 408
 DESIGN SPEED = 70 MPH
 POSTED SPEED = 70 MPH

WIDENING & NEW CONSTRUCTION

OPTIONAL BASE GROUP 12 WITH
 TYPE SP STRUCTURAL COURSE (TRAFFIC D) (3")
 TYPE SP STRUCTURAL COURSE (TRAFFIC D) (2") (PG 76-22)
 AND FRICTION COURSE FC-5 (3/4") (PG 76-22)

MILLING, OVERBUILD & RESURFACING

TYPE SP STRUCTURAL COURSE (TRAFFIC D) (2")
 AND FRICTION COURSE FC-5 (TRAFFIC D) (3/4") (PG 76-22)

WIDENING & NEW CONSTRUCTION (FUTURE EXPRESS LANE)

OPTIONAL BASE GROUP 12 WITH
 TYPE SP STRUCTURAL COURSE (TRAFFIC D) (3")
 TYPE SP STRUCTURAL COURSE (TRAFFIC D) (1 1/2") (PG 76-22)
 AND FRICTION COURSE FC-12.5 (1 1/2") (PG 76-22)

MILLING, OVERBUILD & RESURFACING (INSIDE SHOULDER PAVEMENT)

TYPE SP STRUCTURAL COURSE (TRAFFIC B) (1") (PG 76-22)

MILLING, OVERBUILD & RESURFACING (OUTSIDE SHOULDER PAVEMENT)

TYPE SP STRUCTURAL COURSE (TRAFFIC B) (1 1/2") (PG 76-22)

WIDENING (SHOULDER PAVEMENT)

OPTIONAL BASE GROUP 4 WITH
 TYPE SP STRUCTURAL COURSE (TRAFFIC B) (2") (PG 76-22)

LEGEND

↑ FUTURE LANE

+ CONSTRUCT GROUND-IN RUMBLE STRIPS PER INDEX 318


REVISIONS			
DATE	DESCRIPTION	DATE	DESCRIPTION

Kimley-Horn and Associates, Inc.
 Certificate Of Authorization No. 696
 Hoor Gin Ng, P.E.
 P.E. License No. 58123
 1920 Wekiva Way, Suite 200
 West Palm Beach, Florida 33411

STATE OF FLORIDA DEPARTMENT OF TRANSPORTATION		
ROAD NO.	COUNTY	FINANCIAL PROJECT ID
91	PALM BEACH	406144-1-52-01

TYPICAL SECTION

SHEET
NO.
30

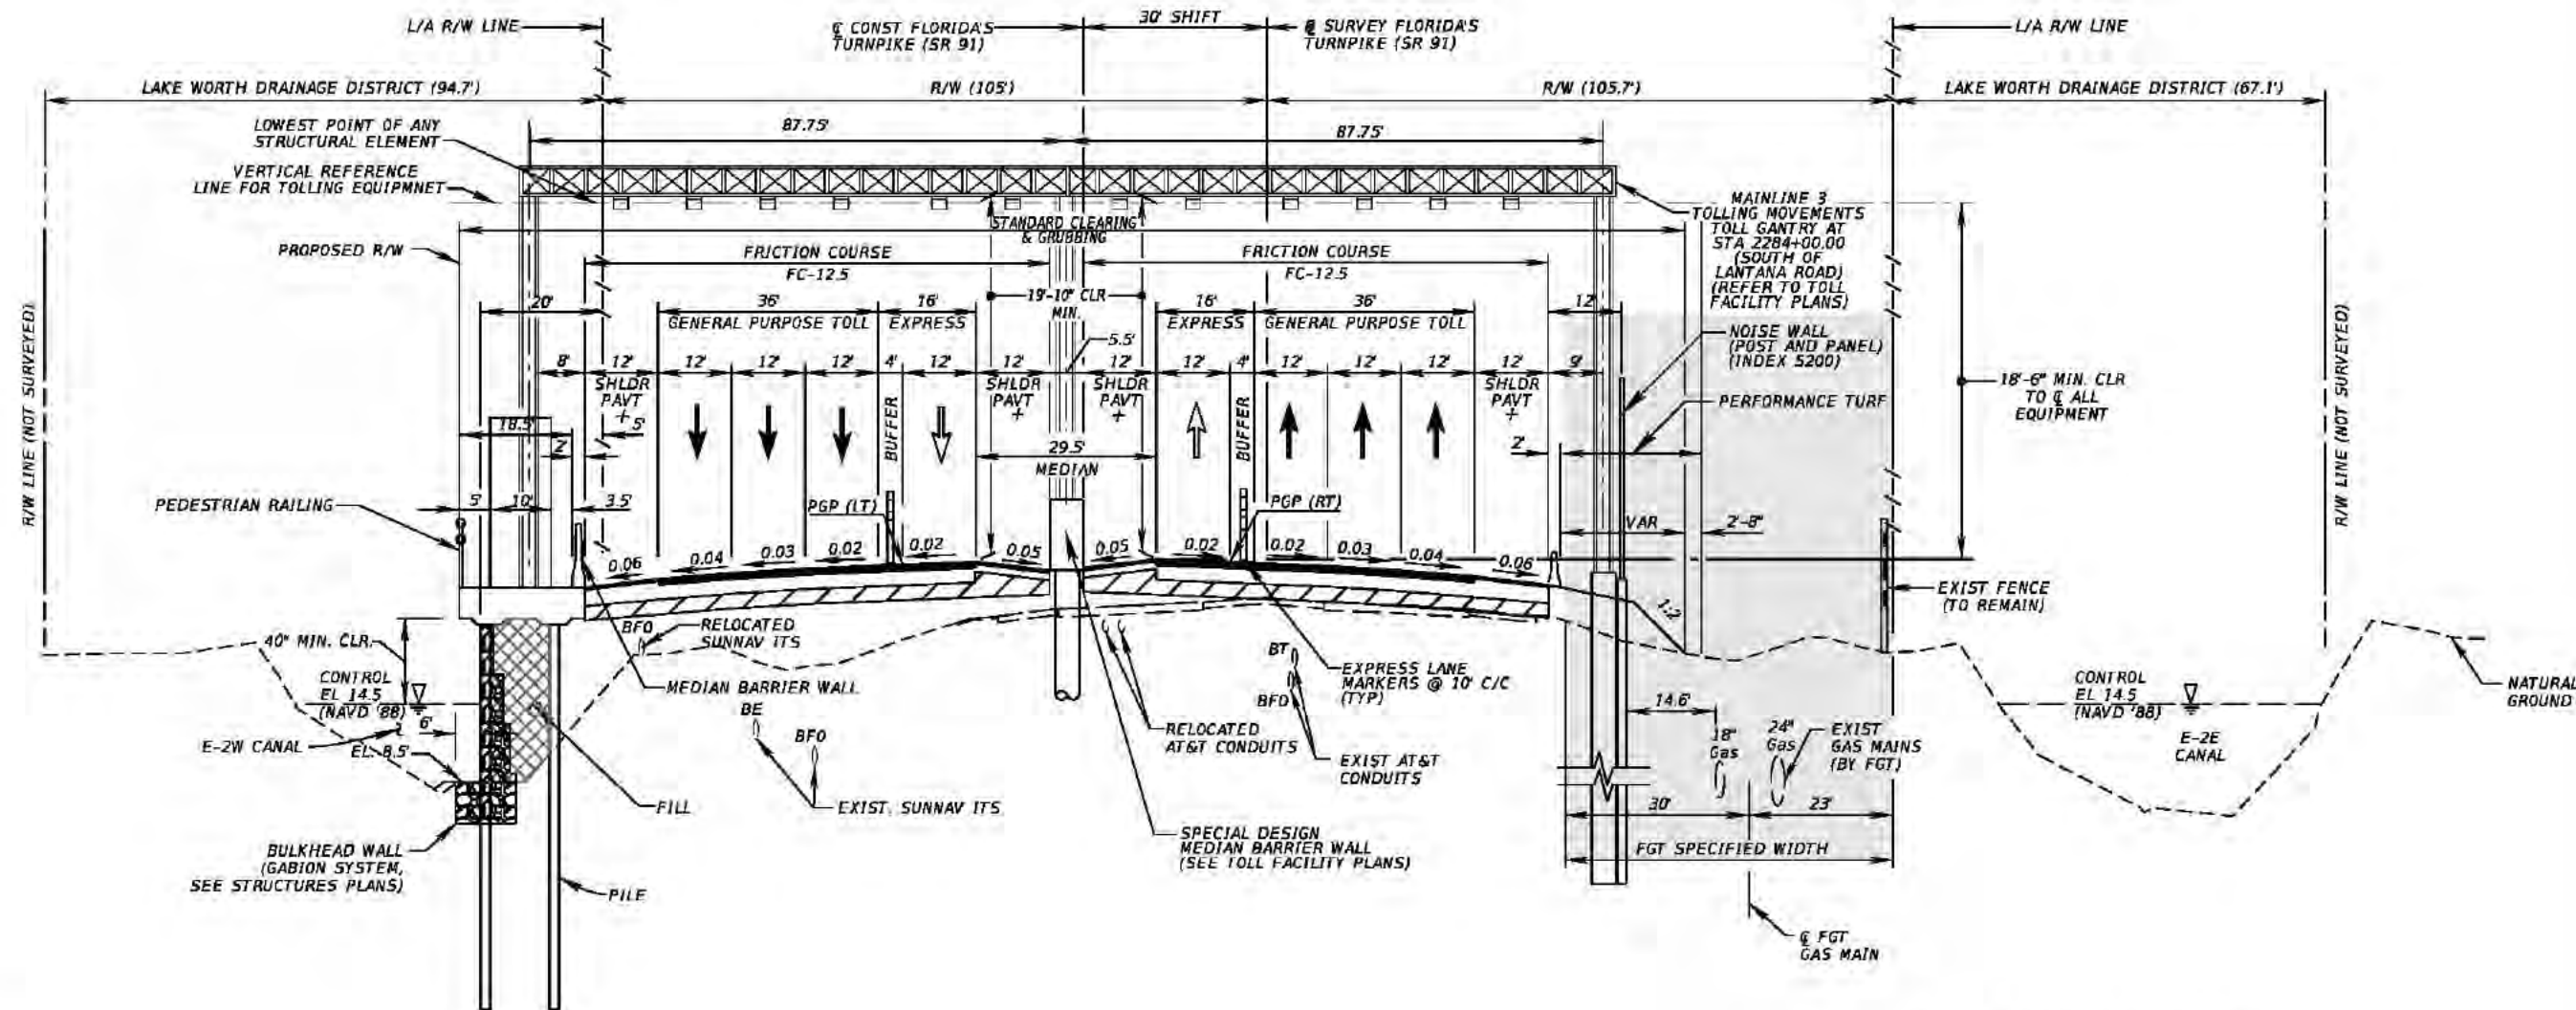

LEGEND



CONSTRUCT GROUND-IN RUMBLE STRIPS PER INDEX 518

NOTE:
TOLL GANTRY STRUCTURE FOUNDATIONS SHALL BE
DESIGNED TO ALLOW FOR EXCAVATION DOWN TO TWO
FEET BELOW THE BOTTOM OF THE LOWEST GAS MAIN
ADJACENT TO OR WITHIN FGT SPECIFIED WIDTH.

TRAFFIC DATA

CURRENT YEAR = 2015 AADT = 73,700
ESTIMATED OPENING YEAR = 2020 AADT = 80,100
ESTIMATED DESIGN YEAR = 2040 AADT = 126,400
K = 9.5% D = 55.6% T = 11.3% (24 HOUR)
DESIGN HOUR T = 6.0%
TRUCK DDHV = 408
DESIGN SPEED = 70 MPH
POSTED SPEED = 70 MPH

TYPICAL SECTION 9B SR 91 (FLORIDA'S TURNPIKE)

TOLL GANTRY
(SOUTH OF LANTANA ROAD)
STA 2283+66.30 TO STA 2284+66.30

NEW CONSTRUCTION


12" STABILIZATION, OBG 11 (7" TYPE B 12.5) WITH
TYPE SP STRUCTURAL COURSE (TRAFFIC D) (4") PG 76-22
AND FC-12.5 (1½") PG 76-22

SHOULDER PAVEMENT

12" STABILIZATION, OBG 11 (7" TYPE B 12.5) WITH
TYPE SP STRUCTURAL COURSE (TRAFFIC D) (4") PG 76-22
AND FC-12.5 (1½") PG 76-22

8-LANE ULTIMATE

REVISIONS				Kimley-Horn and Associates, Inc. Certificate Of Authorization No. 696 Hool Gin Ng, P.E. P.E. License No. 58123 1920 Wekiva Way, Suite 200 West Palm Beach, Florida 33411	STATE OF FLORIDA DEPARTMENT OF TRANSPORTATION			TYPICAL SECTION	SHEET NO.
DATE	DESCRIPTION	DATE	DESCRIPTION		ROAD NO.	COUNTY	FINANCIAL PROJECT ID		
					91	PALM BEACH	406144-1-52-01		31

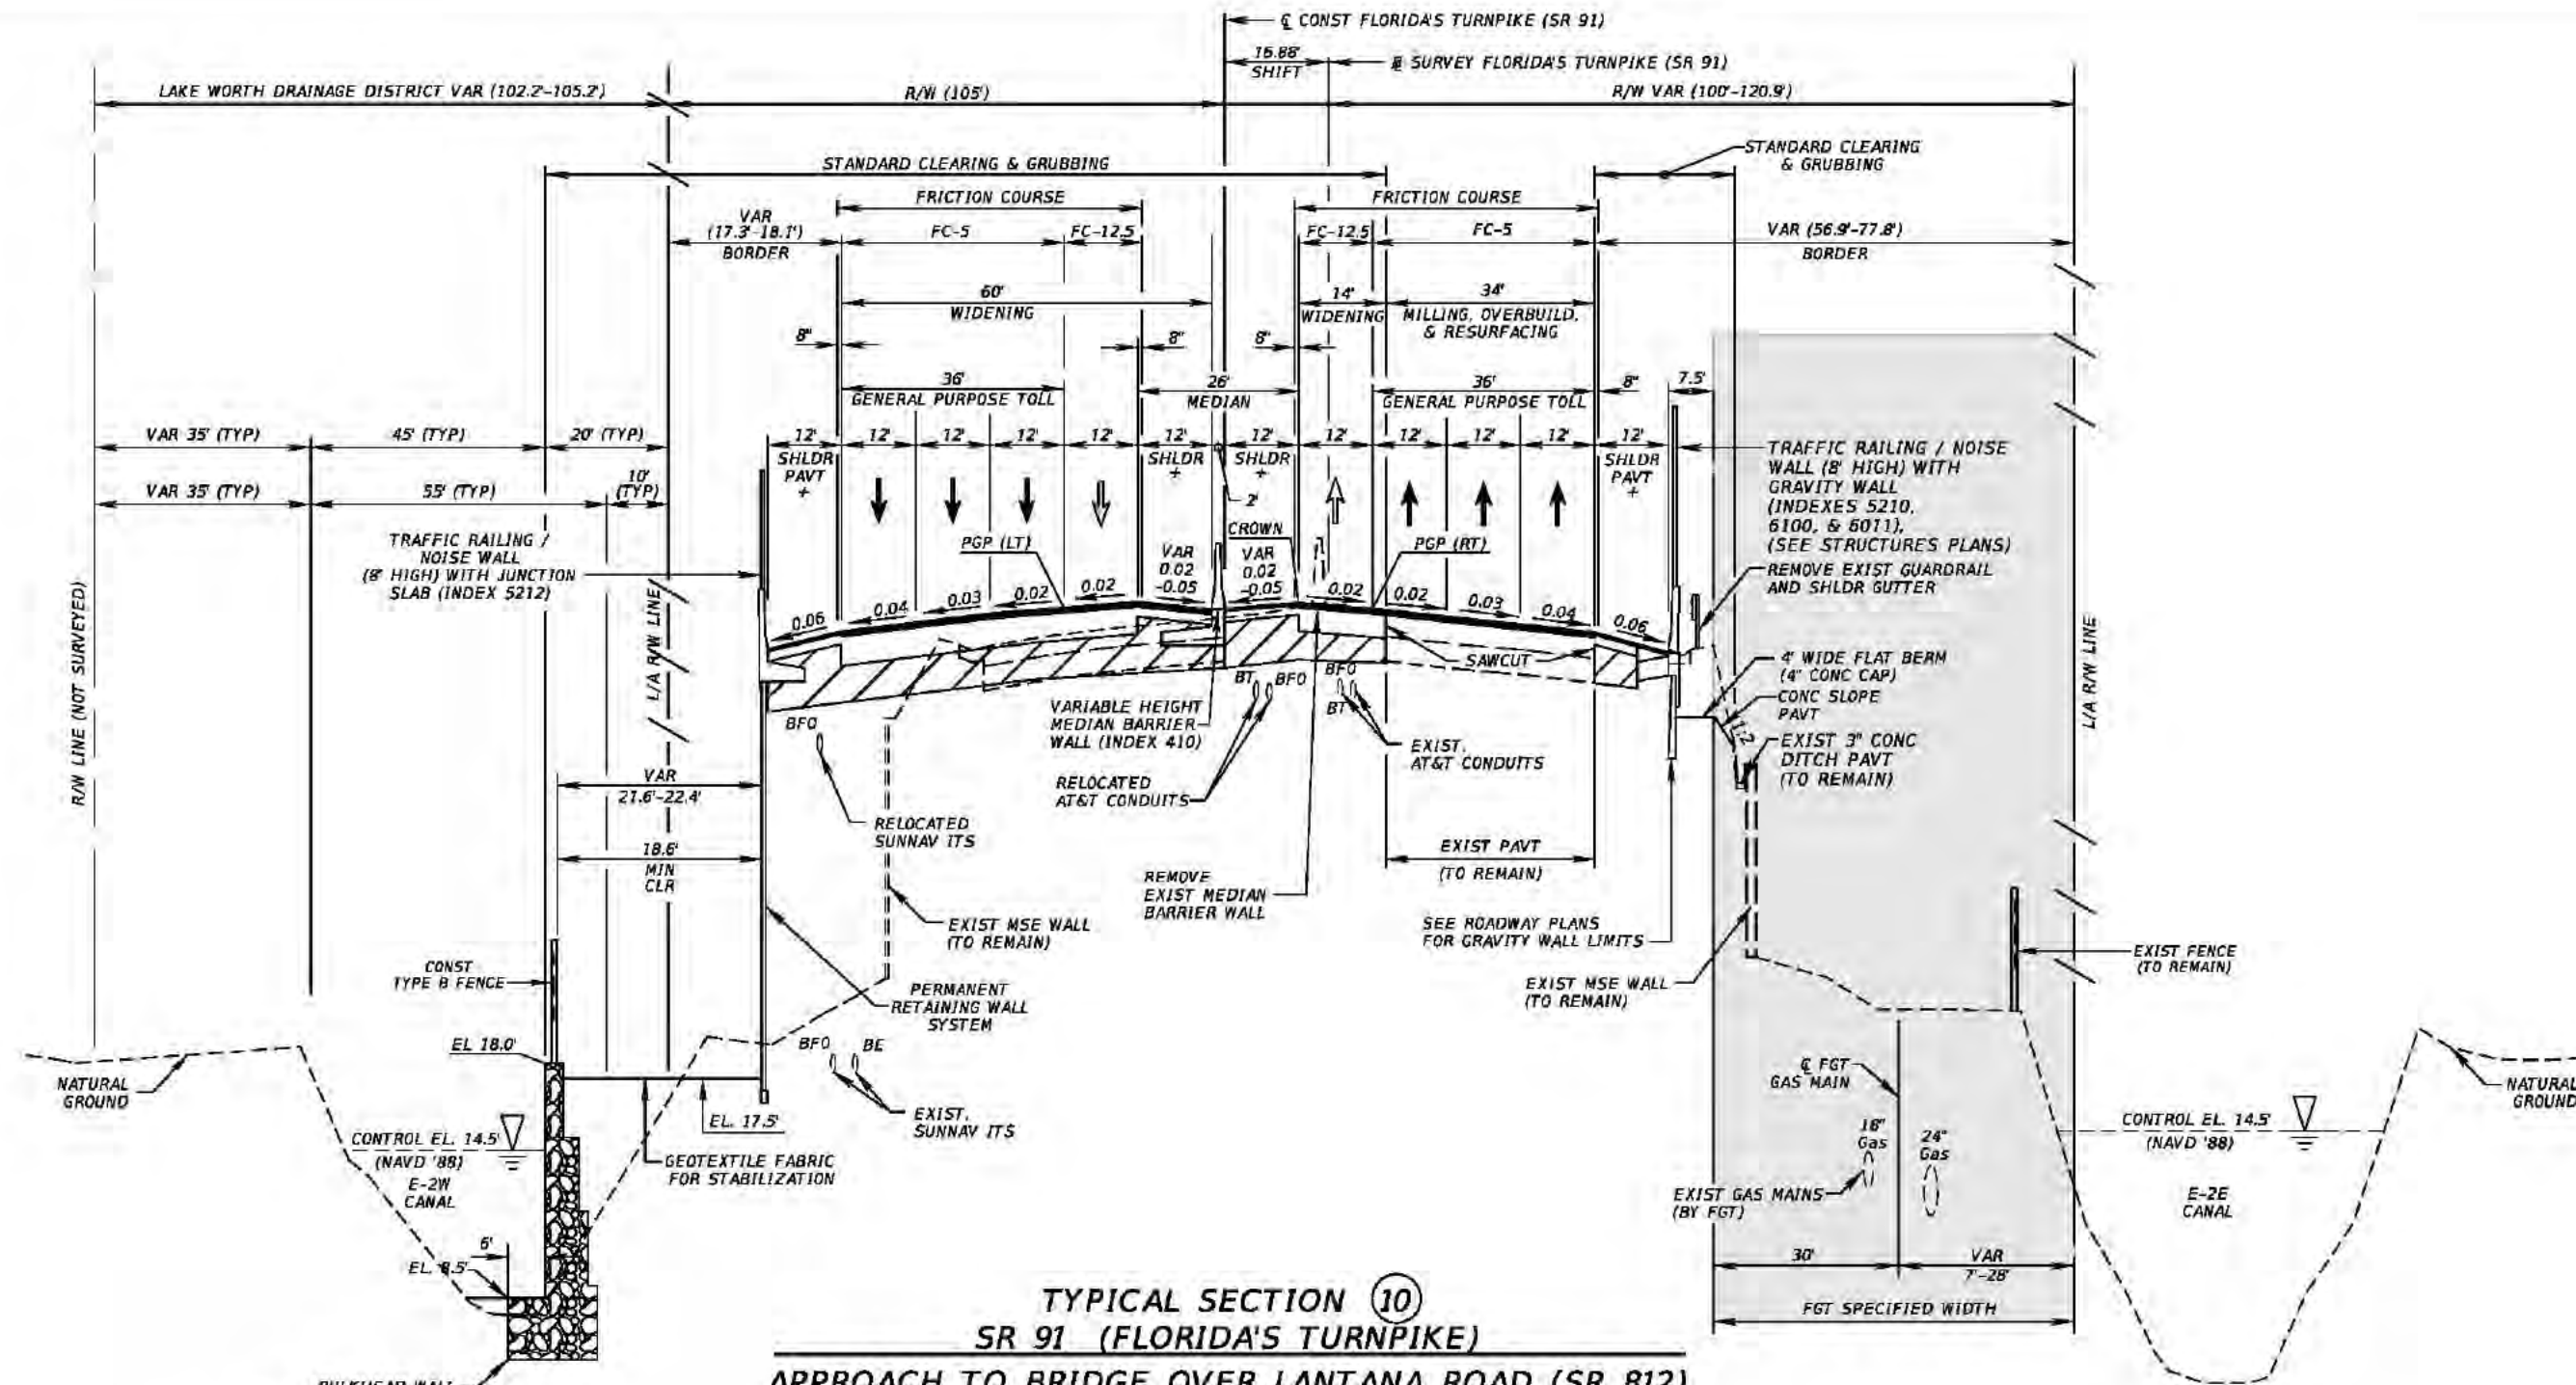

TYPICAL SECTION 10
SR 91 (FLORIDA'S TURNPIKE)
APPROACH TO BRIDGE OVER LANTANA ROAD (SR 812)
STA 2290+00.00 TO STA 2298+55.82
STA 2299+88.32 TO STA 2309+20.00

TRAFFIC DATA

CURRENT YEAR = 2015 AADT = 73,700
 ESTIMATED OPENING YEAR = 2020 AADT = 80,100
 ESTIMATED DESIGN YEAR = 2040 AADT = 126,400
 K = 9.5% D = 56.6% T = 11.3% (24 HOUR)
 DESIGN HOUR T = 6.0%
 TRUCK DDHV = 408
 DESIGN SPEED = 70 MPH
 POSTED SPEED = 70 MPH

WIDENING & NEW CONSTRUCTION

OPTIONAL BASE GROUP 12 WITH
 TYPE SP STRUCTURAL COURSE (TRAFFIC D) (3")
 TYPE SP STRUCTURAL COURSE (TRAFFIC D) (2") (PG 76-22)
 AND FRICTION COURSE FC-5 (3/4") (PG 76-22)

MILLING, OVERBUILD & RESURFACING

TYPE SP STRUCTURAL COURSE (TRAFFIC D) (2")
 AND FRICTION COURSE FC-5 (TRAFFIC D) (3/4") (PG 76-22)

 
**MILLING, OVERBUILD & RESURFACING
 (OUTSIDE SHOULDER PAVEMENT)**

TYPE SP STRUCTURAL COURSE (TRAFFIC B) (1 1/2") (PG 76-22)

WIDENING (SHOULDER PAVEMENT)

OPTIONAL BASE GROUP 4 WITH
 TYPE SP STRUCTURAL COURSE (TRAFFIC B) (2") (PG 76-22)

LEGEND



+ CONSTRUCT GROUND-IN RUMBLE STRIPS PER INDEX 518

REVISIONS			
DATE	DESCRIPTION	DATE	DESCRIPTION


Kimley-Horn and Associates, Inc.
 Certificate of Authorization No. 696
 Hool Gin Ng, P.E.
 P.E. License No. 58123
 1920 Wekiva Way, Suite 200
 West Palm Beach, Florida 33411

**STATE OF FLORIDA
 DEPARTMENT OF TRANSPORTATION**

ROAD NO.	COUNTY	FINANCIAL PROJECT ID
91	PALM BEACH	406144-1-52-01

TYPICAL SECTION

SHEET
 NO.
 32

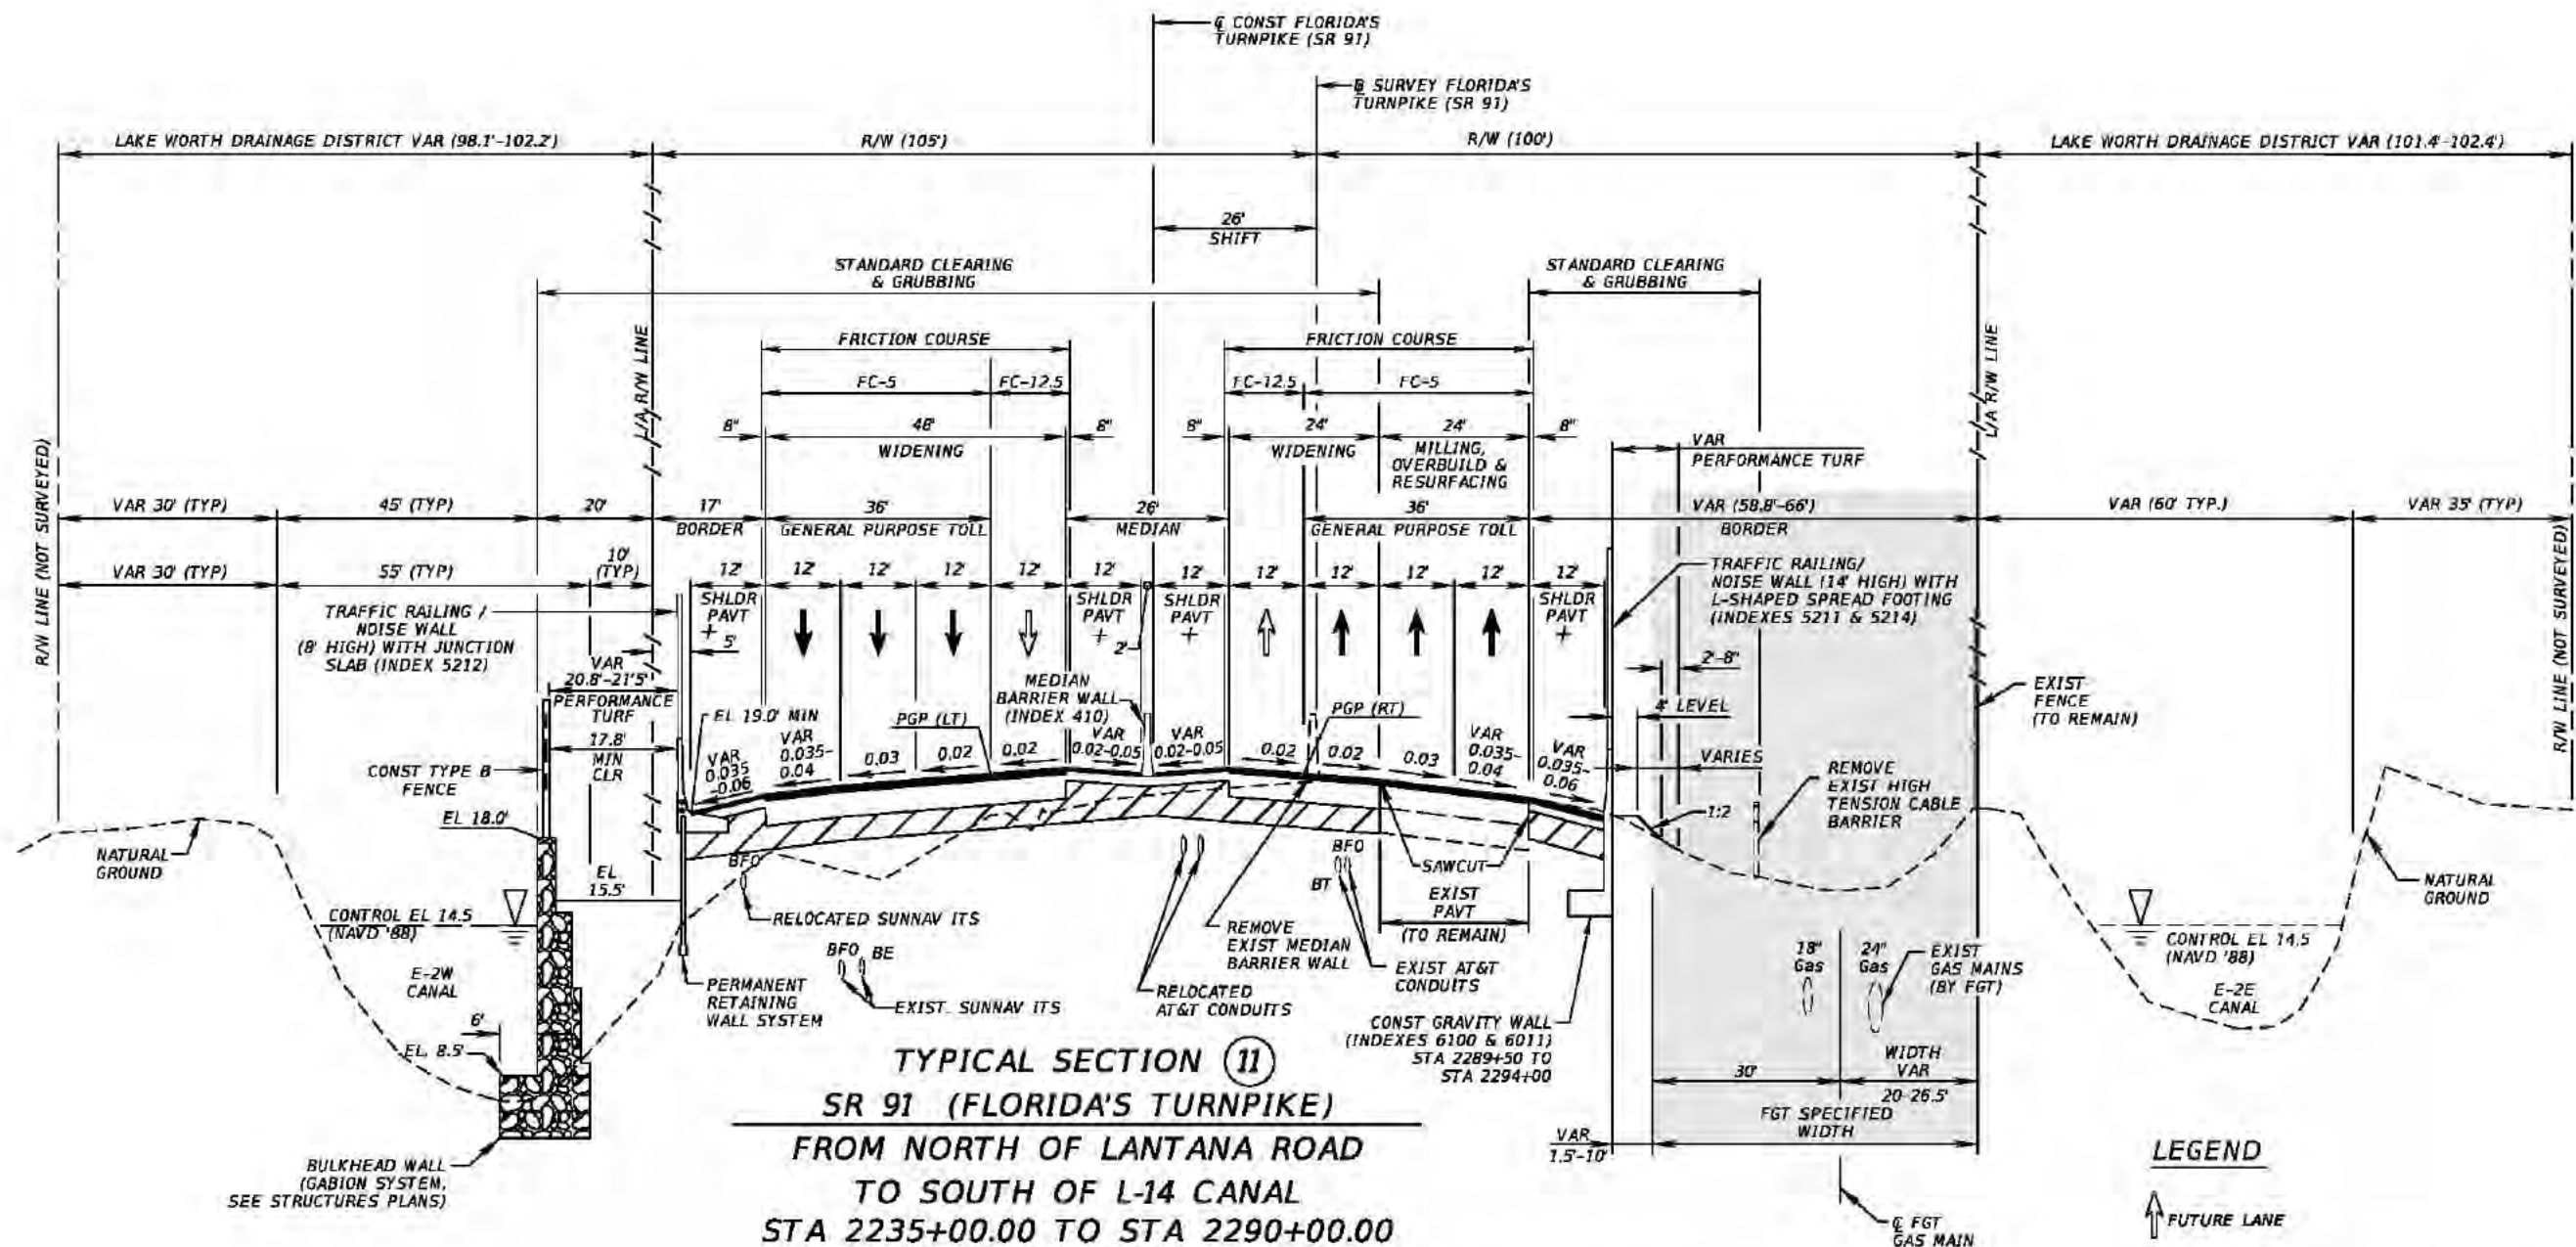

TYPICAL SECTION 11
SR 91 (FLORIDA'S TURNPIKE)
FROM NORTH OF LANTANA ROAD
TO SOUTH OF L-14 CANAL
STA 2235+00.00 TO STA 2290+00.00
STA 2309+20.00 TO STA 2349+00.00

WIDENING & NEW CONSTRUCTION
 OPTIONAL BASE GROUP 12 WITH
 TYPE SP STRUCTURAL COURSE (TRAFFIC D) (3"),
 TYPE SP STRUCTURAL COURSE (TRAFFIC D) (2") (PG 76-22)
 AND FRICTION COURSE FC-5 (3/4") (PG 76-22)

MILLING, OVERBUILD & RESURFACING
 TYPE SP STRUCTURAL COURSE (TRAFFIC D) (2")
 AND FRICTION COURSE FC-5 (TRAFFIC D) (3/4") (PG 76-22)

WIDENING & NEW CONSTRUCTION
(FUTURE EXPRESS LANE)
 OPTIONAL BASE GROUP 11 WITH
 TYPE SP STRUCTURAL COURSE (TRAFFIC D) (3"),
 TYPE SP STRUCTURAL COURSE (TRAFFIC D) (1 1/2") (PG 76-22)
 AND FRICTION COURSE FC-5 (1 1/2") (PG 76-22)

MILLING, OVERBUILD & RESURFACING
(INSIDE SHOULDER PAVEMENT)
 TYPE SP STRUCTURAL COURSE (TRAFFIC B) (1") (PG 76-22)

MILLING, OVERBUILD & RESURFACING
(OUTSIDE SHOULDER PAVEMENT)
 TYPE SP STRUCTURAL COURSE (TRAFFIC B) (1 1/2") (PG 76-22)

WIDENING (SHOULDER PAVEMENT)
 OPTIONAL BASE GROUP 4 WITH
 TYPE SP STRUCTURAL COURSE (TRAFFIC B) (2") (PG 76-22)

LEGEND

↑ FUTURE LANE


+ CONSTRUCT GROUND-IN RUMBLE STRIPS PER INDEX 518

TRAFFIC DATA

CURRENT YEAR = 2015 AADT = 73,700
 ESTIMATED OPENING YEAR = 2020 AADT = 80,100
 ESTIMATED DESIGN YEAR = 2040 AADT = 126,400
 K = 9.5% D = 56.6% T = 11.3% (24 HOUR)
 DESIGN HOUR T = 6.0%
 TRUCK DDHV = 408
 DESIGN SPEED = 70 MPH
 POSTED SPEED = 70 MPH

REVISIONS				Kimley-Horn and Associates, Inc. Certificate Of Authorization No. 696 Hool Gin Ng, P.E. P.E. License No. 58123 1920 Wekiva Way, Suite 200 West Palm Beach, Florida 33411	STATE OF FLORIDA DEPARTMENT OF TRANSPORTATION			SHEET NO. 33
DATE	DESCRIPTION	DATE	DESCRIPTION		ROAD NO.	COUNTY	FINANCIAL PROJECT ID	
					91	PALM BEACH	406144-1-52-01	

TYPICAL SECTION

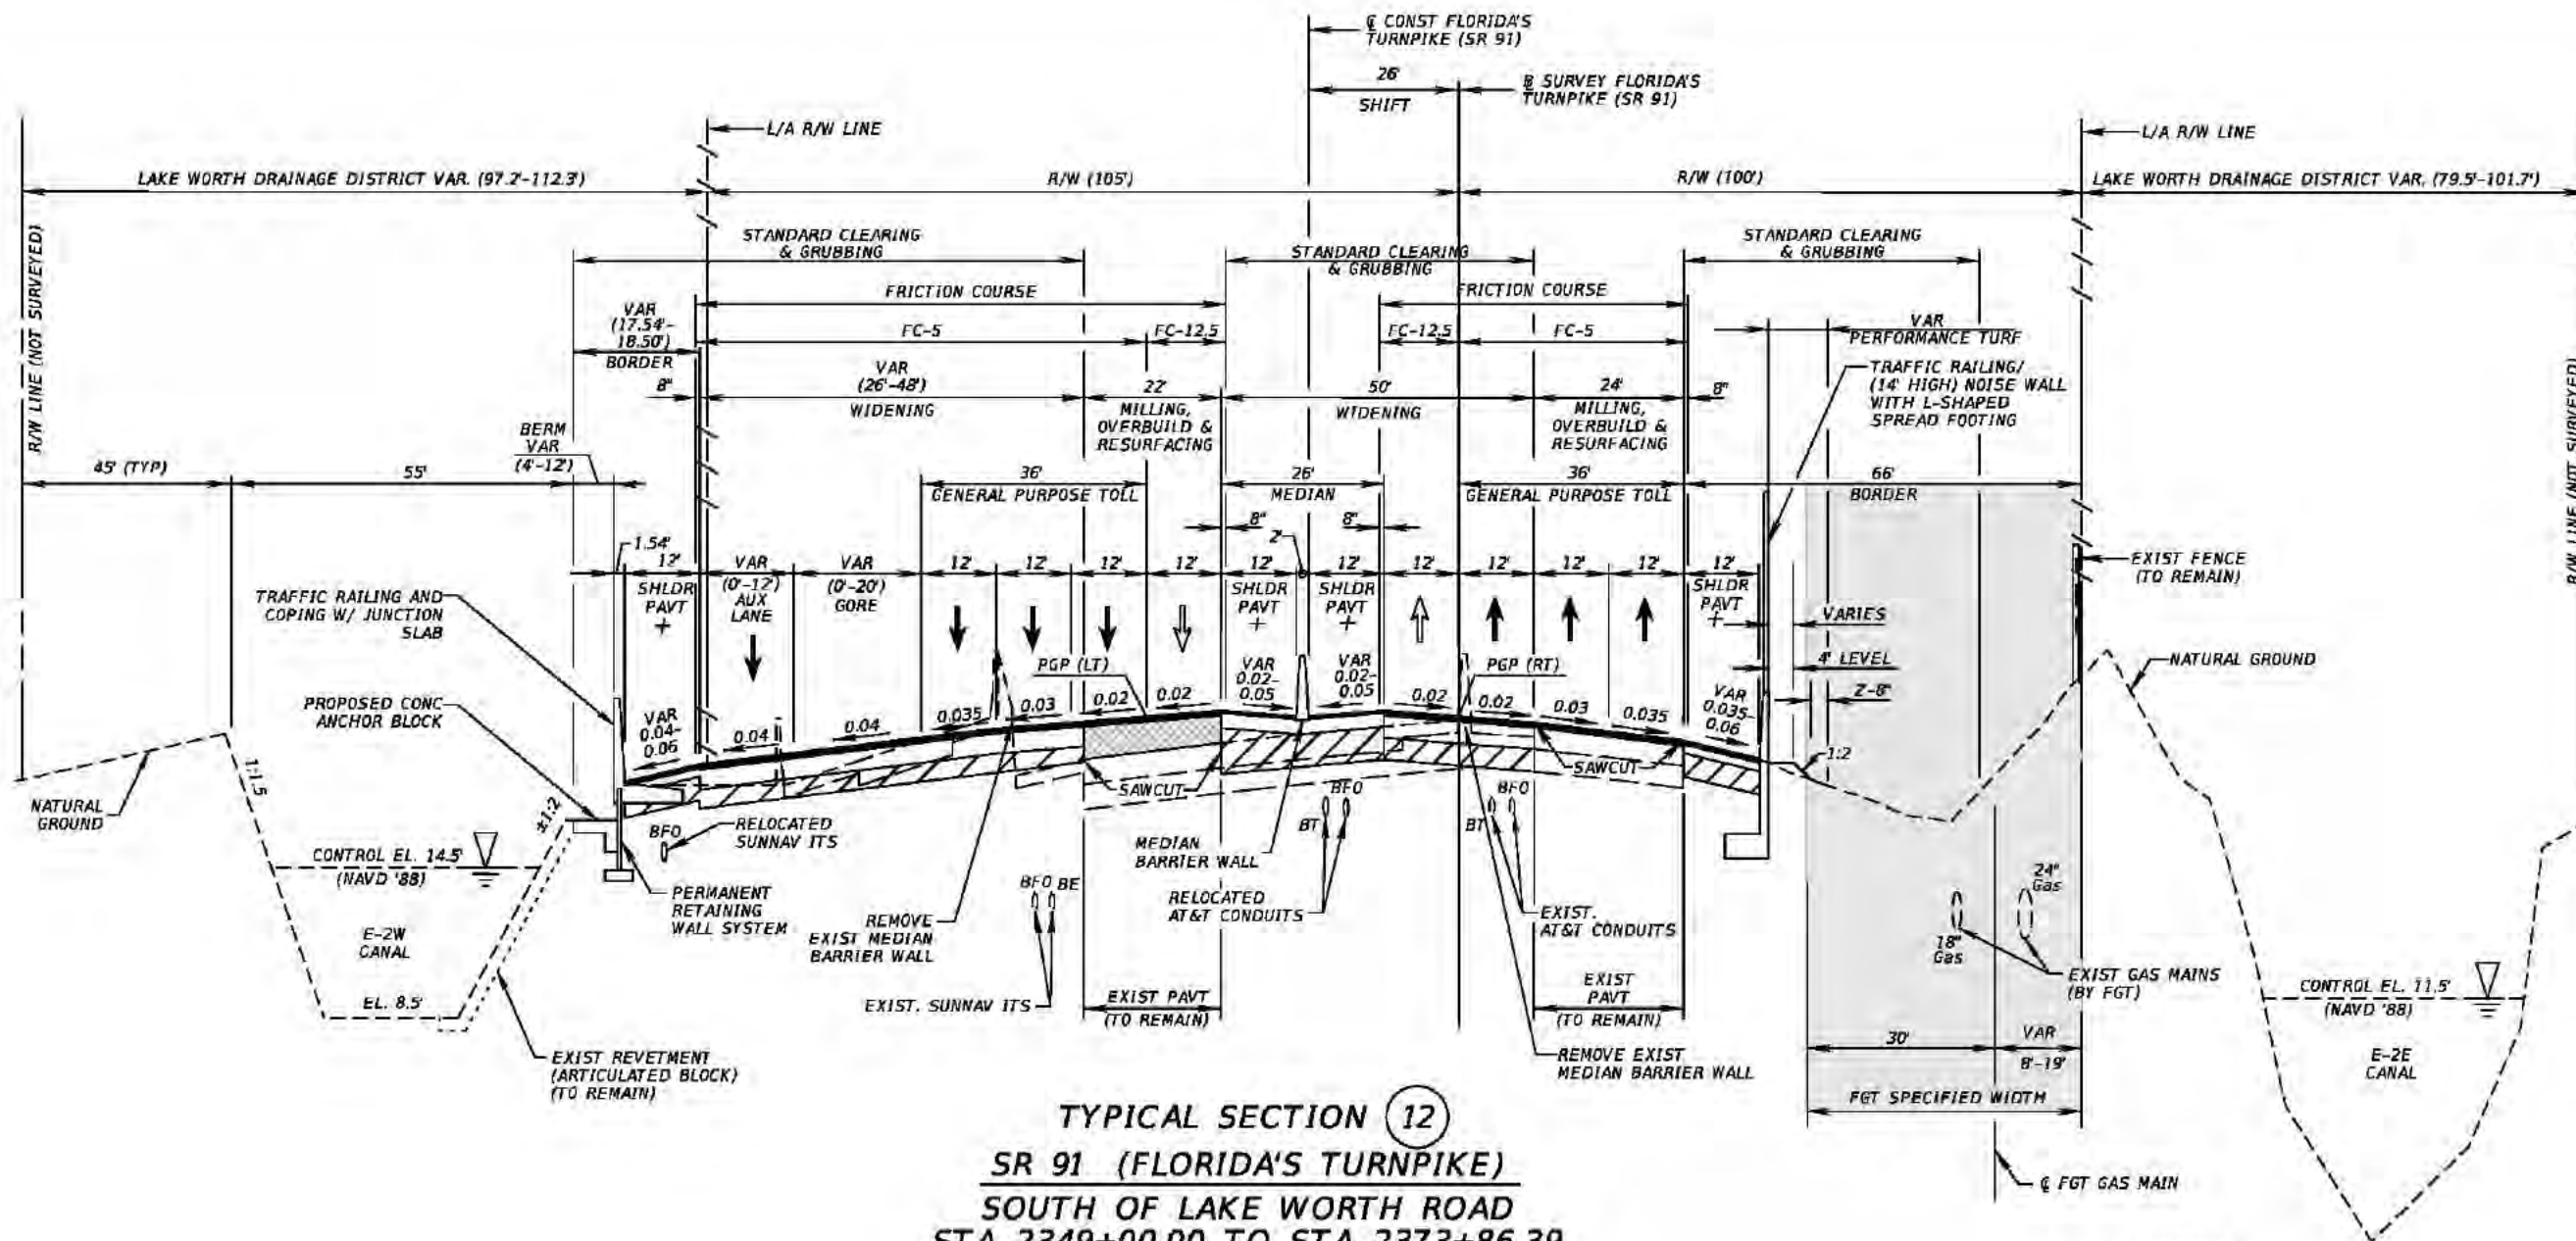

TYPICAL SECTION 12
SR 91 (FLORIDA'S TURNPIKE)
SOUTH OF LAKE WORTH ROAD
STA 2349+00.00 TO STA 2373+86.39

TRAFFIC DATA

CURRENT YEAR = 2015 AADT = 73,700
 ESTIMATED OPENING YEAR = 2020 AADT = 80,100
 ESTIMATED DESIGN YEAR = 2040 AADT = 126,400
 K = 9.5% D = 56.6% T = 11.3% (24 HOUR)
 DESIGN HOUR T = 6.0%
 TRUCK DDHV = 408
 DESIGN SPEED = 70 MPH
 POSTED SPEED = 70 MPH

WIDENING & NEW CONSTRUCTION

OPTIONAL BASE GROUP 12 WITH
 TYPE SP STRUCTURAL COURSE (TRAFFIC D) (3"),
 TYPE SP STRUCTURAL COURSE (TRAFFIC D) (2") (PG 76-22)
 AND FRICTION COURSE FC-5 (3/4") (PG 76-22)

MILLING, OVERBUILD & RESURFACING

TYPE SP STRUCTURAL COURSE (TRAFFIC D) (2")
 AND FRICTION COURSE FC-5 (3/4") (PG 76-22)

WIDENING & NEW CONSTRUCTION (FUTURE LANE)

OPTIONAL BASE GROUP 11 WITH
 TYPE SP STRUCTURAL COURSE (TRAFFIC D) (3"),
 TYPE SP STRUCTURAL COURSE (TRAFFIC D) (1 1/2") (PG 76-22)
 AND FRICTION COURSE FC-5 (1 1/2") (PG 76-22)

MILLING, OVERBUILD & RESURFACING (INSIDE SHOULDER PAVEMENT)

TYPE SP STRUCTURAL COURSE (TRAFFIC B) (1") (PG 76-22)

MILLING, OVERBUILD & RESURFACING (OUTSIDE SHOULDER PAVEMENT)

TYPE SP STRUCTURAL COURSE (TRAFFIC B) (1 1/2") (PG 76-22)

 
WIDENING (SHOULDER PAVEMENT)

OPTIONAL BASE GROUP 4 WITH
 TYPE SP STRUCTURAL COURSE (TRAFFIC B) (2") (PG 76-22)

LEGEND



OVERBUILD



FUTURE LANE

+ CONSTRUCT GROUND-IN RUMBLE STRIPS PER INDEX 518

REVISIONS			
DATE	DESCRIPTION	DATE	DESCRIPTION

Kimley-Horn and Associates, Inc.
 Certificate Of Authorization No. 696
 Hool Gin Ng, P.E.
 P.E. License No. 58123
 1920 Wekiva Way, Suite 200
 West Palm Beach, Florida 33411


STATE OF FLORIDA DEPARTMENT OF TRANSPORTATION

ROAD NO.	COUNTY	FINANCIAL PROJECT ID
91	PALM BEACH	406144-1-52-01

TYPICAL SECTION

SHEET NO.

34

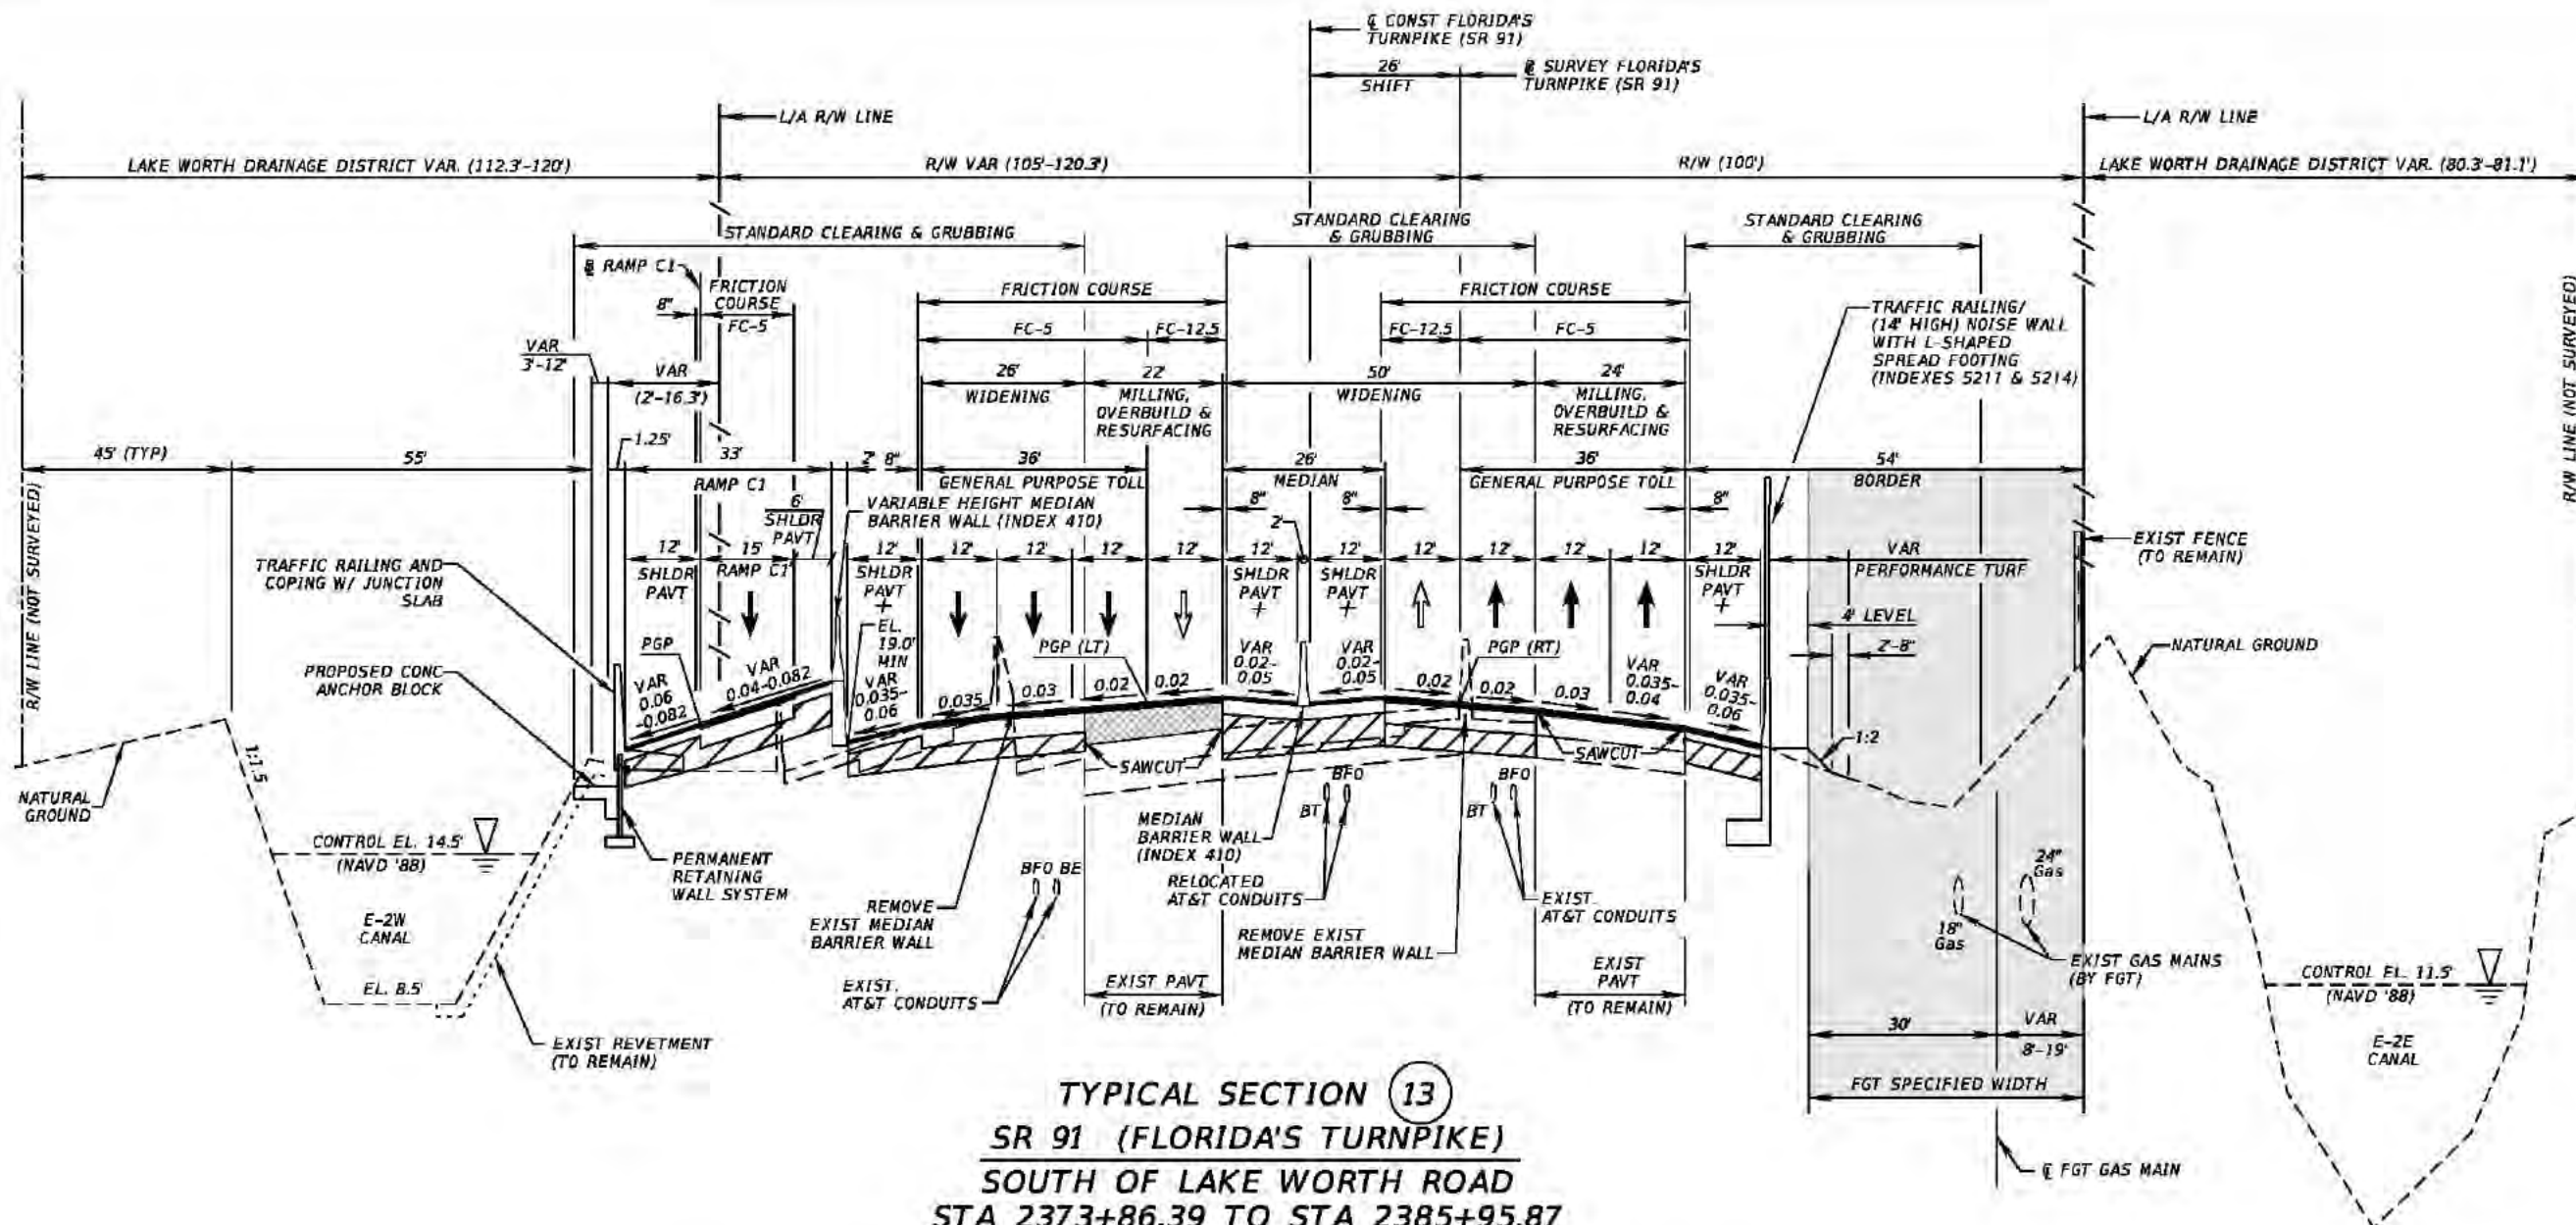

TYPICAL SECTION 13
SR 91 (FLORIDA'S TURNPIKE)
SOUTH OF LAKE WORTH ROAD
STA 2373+86.39 TO STA 2385+95.87

TRAFFIC DATA

CURRENT YEAR = 2015 AADT = 73,700
 ESTIMATED OPENING YEAR = 2020 AADT = 80,100
 ESTIMATED DESIGN YEAR = 2040 AADT = 126,400
 K = 9.5% D = 56.6% T = 11.3% (24 HOUR)
 DESIGN HOUR T = 6.0%
 TRUCK DDHV = 408
 DESIGN SPEED = 70 MPH
 POSTED SPEED = 70 MPH

WIDENING & NEW CONSTRUCTION (RAMP)

OPTIONAL BASE GROUP 9 WITH
 TYPE SP STRUCTURAL COURSE (TRAFFIC C) (2½"),
 TYPE SP STRUCTURAL COURSE (TRAFFIC C) (1½") (PG 76-22)
 AND FRICTION COURSE FC-5 (¾") (PG 76-22)

WIDENING (RAMP SHOULDER PAVEMENT)

OPTIONAL BASE GROUP 2 WITH
 TYPE SP STRUCTURAL COURSE (TRAFFIC A) (1½")

WIDENING (SHOULDER PAVEMENT)

OPTIONAL BASE GROUP 4 WITH
 TYPE SP STRUCTURAL COURSE (TRAFFIC B) (2")

WIDENING & NEW CONSTRUCTION (FUTURE LANE)

OPTIONAL BASE GROUP 12 WITH
 TYPE SP STRUCTURAL COURSE (TRAFFIC D) (3"),
 TYPE SP STRUCTURAL COURSE (TRAFFIC D) (1½") (PG 76-22)
 AND FRICTION COURSE FC-12.5 (1½") (PG 76-22)

WIDENING & NEW CONSTRUCTION

OPTIONAL BASE GROUP 12 WITH
 TYPE SP STRUCTURAL COURSE (TRAFFIC D) (3"),
 TYPE SP STRUCTURAL COURSE (TRAFFIC D) (2") (PG 76-22)
 AND FRICTION COURSE FC-5 (¾") (PG 76-22)

MILLING, OVERBUILD & RESURFACING

TYPE SP STRUCTURAL COURSE (TRAFFIC D) (2")
 AND FRICTION COURSE FC-5 (¾") (PG 76-22)

MILLING, OVERBUILD & RESURFACING (INSIDE SHOULDER PAVEMENT)

TYPE SP STRUCTURAL COURSE (TRAFFIC B) (1") (PG 76-22)

MILLING, OVERBUILD & RESURFACING (OUTSIDE SHOULDER PAVEMENT)

TYPE SP STRUCTURAL COURSE (TRAFFIC B) (1½") (PG 76-22)


LEGEND



+CONSTRUCT GROUND-IN RUMBLE STRIPS PER INDEX 518

REVISIONS				Kimley-Horn and Associates, Inc. Certificate of Authorization No. 696 Hoon Gin Ng, P.E. P.E. License No. 58123 1920 Wekiva Way, Suite 200 West Palm Beach, Florida 33411	STATE OF FLORIDA DEPARTMENT OF TRANSPORTATION			SHEET NO. 35
DATE	DESCRIPTION	DATE	DESCRIPTION		ROAD NO.	COUNTY	FINANCIAL PROJECT ID	
					91	PALM BEACH	406144-1-52-01	

TYPICAL SECTION

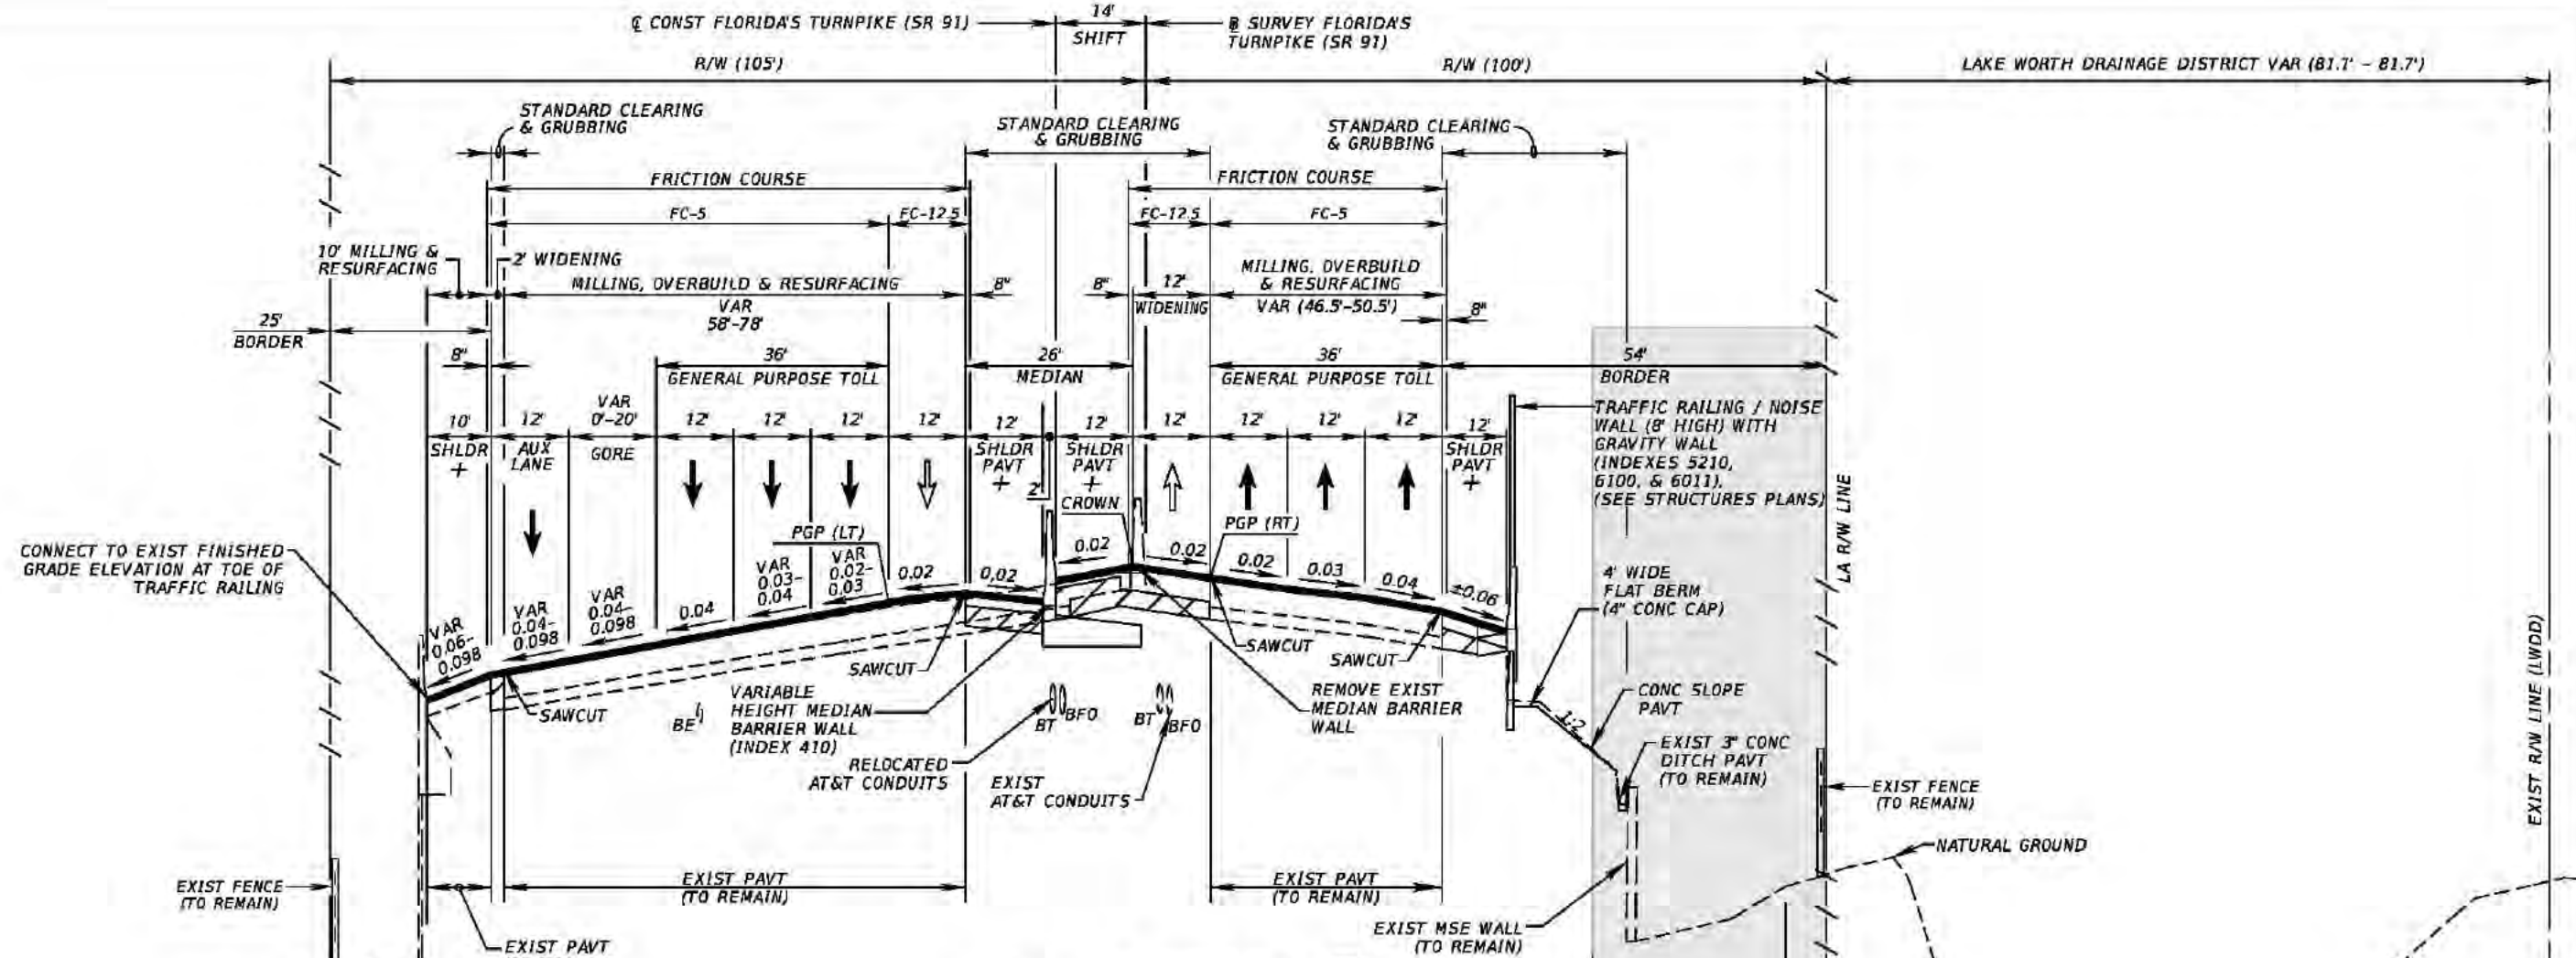

TYPICAL SECTION 14
SR 91 (FLORIDA'S TURNPIKE)
AT SOUTH APPROACH TO
SR 802 (LAKE WORTH ROAD)
BRIDGE NO. 931001
STA 2385+95.87 TO STA 2396+78.38

TRAFFIC DATA	
CURRENT YEAR	= 2015 AADT = 73,700
ESTIMATED OPENING YEAR	= 2020 AADT = 80,100
ESTIMATED DESIGN YEAR	= 2040 AADT = 126,400
K = 9.5% D = 56.6% T = 11.3% (24 HOUR)	
DESIGN HOUR T = 6.0%	
TRUCK DDHV = 408	
DESIGN SPEED = 70 MPH	
POSTED SPEED = 70 MPH	

- WIDENING & NEW CONSTRUCTION**
 OPTIONAL BASE GROUP 12 WITH
 TYPE SP STRUCTURAL COURSE (TRAFFIC D) (3")
 TYPE SP STRUCTURAL COURSE (TRAFFIC D) (2") (PG 76-22)
 AND FRICTION COURSE FC-5 (3/4") (PG 76-22)
- MILLING, OVERBUILD & RESURFACING**
 TYPE SP STRUCTURAL COURSE (TRAFFIC D) (2")
 AND FRICTION COURSE FC-5 (3/4") (PG 76-22)
- MILLING, OVERBUILD & RESURFACING**
(INSIDE SHOULDER PAVEMENT)
 TYPE SP STRUCTURAL COURSE (TRAFFIC B) (1") (PG 76-22)
- MILLING, OVERBUILD & RESURFACING**
(OUTSIDE SHOULDER PAVEMENT)
 TYPE SP STRUCTURAL COURSE (TRAFFIC B) (1 1/2") (PG 76-22)
- WIDENING (SHOULDER PAVEMENT)**
 OPTIONAL BASE GROUP 4 WITH
 TYPE SP STRUCTURAL COURSE (TRAFFIC B) (2") (PG 76-22)

- WIDENING & NEW CONSTRUCTION**
(FUTURE EXPRESS LANE)
 OPTIONAL BASE GROUP 12 WITH
 TYPE SP STRUCTURAL COURSE (TRAFFIC D) (3")
 TYPE SP STRUCTURAL COURSE (TRAFFIC D) (1 1/2") (PG 76-22)
 AND FRICTION COURSE FC-12.5 (1 1/2") (PG 76-22)

LEGEND

- OVERBUILD
- FUTURE LANE
- +CONSTRUCT GROUND-IN RUMBLE STRIPS PER INDEX 518

REVISIONS			
DATE	DESCRIPTION	DATE	DESCRIPTION


Kimley-Horn and Associates, Inc.
 Certificate of Authorization No. 696
 Hool Gin Ng, P.E.
 P.E. License No. 58123
 1920 Wekiva Way, Suite 200
 West Palm Beach, Florida 33411

STATE OF FLORIDA
DEPARTMENT OF TRANSPORTATION

ROAD NO.	COUNTY	FINANCIAL PROJECT ID
91	PALM BEACH	406144-1-52-01

TYPICAL SECTION

SHEET
NO.
36

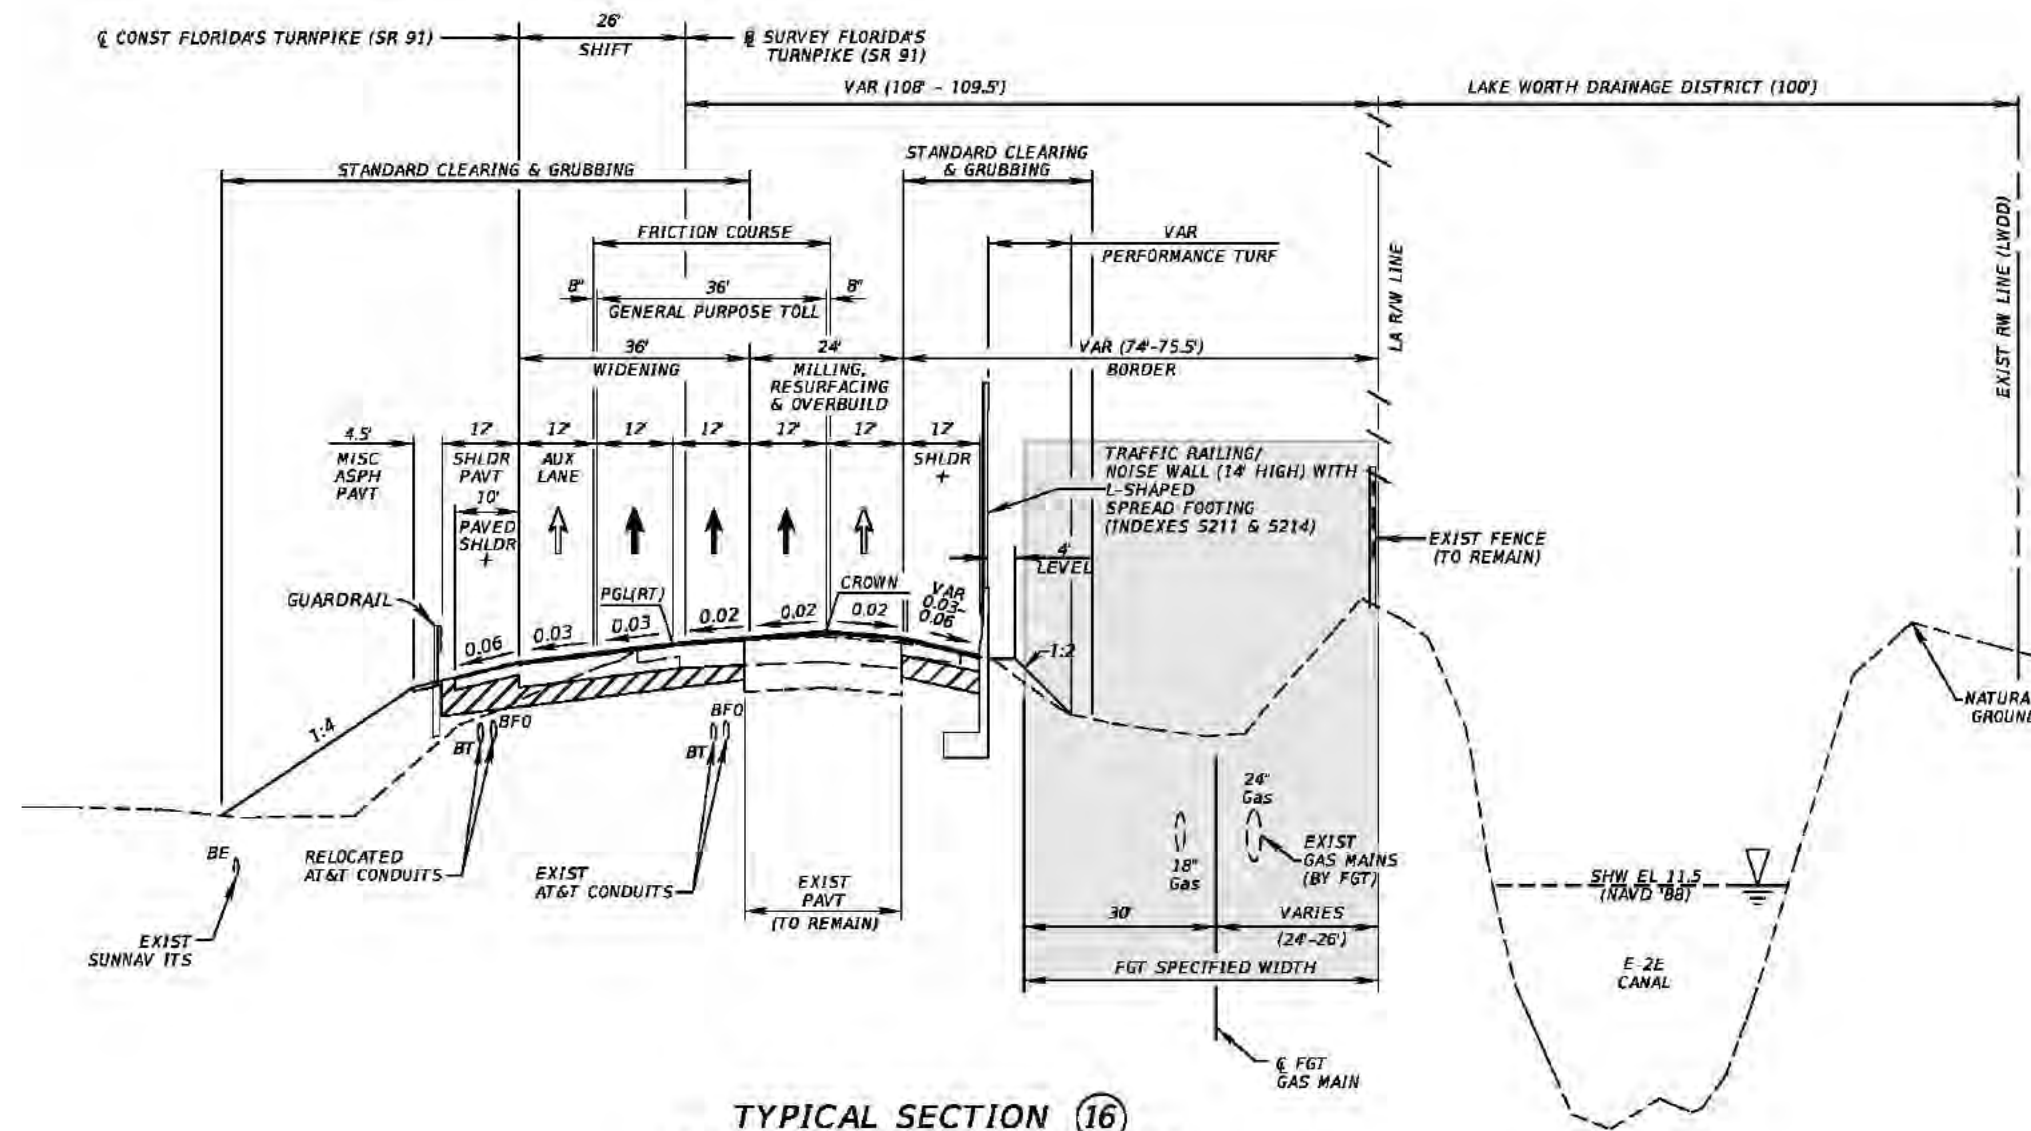

TYPICAL SECTION ①⑥
SR 91 (FLORIDA'S TURNPIKE)
AT NB APPROACH TO
WEST PALM BEACH SERVICE PLAZA
STA 2430+50.00 TO STA 2448+60.00

TRAFFIC DATA

CURRENT YEAR = 2015 AADT = 73,700
 ESTIMATED OPENING YEAR = 2020 AADT = 80,100
 ESTIMATED DESIGN YEAR = 2040 AADT = 126,400
 K = 9.5% D = 56.6% T = 11.3% (24 HOUR)
 DESIGN HOUR T = 6.0%
 TRUCK DDHV = 408
 DESIGN SPEED = 70 MPH
 POSTED SPEED = 70 MPH

WIDENING & NEW CONSTRUCTION

OPTIONAL BASE GROUP 12 WITH
 TYPE SP STRUCTURAL COURSE (TRAFFIC D) (3\"/>

MILLING, OVERBUILD & RESURFACING

TYPE SP STRUCTURAL COURSE (TRAFFIC D) (2\"/>

WIDENING (SHOULDER PAVEMENT)

OPTIONAL BASE GROUP 4 WITH
 TYPE SP STRUCTURAL COURSE (TRAFFIC B) (2\"/>

MILLING, OVERBUILD & RESURFACING
(OUTSIDE SHOULDER PAVEMENT)
 TYPE SP STRUCTURAL COURSE (TRAFFIC B) (1½\"/>


LEGEND

 USE BLACK BASE ONLY
 TO MITIGATE SUB STANDARD
 BASE CLEARANCE

 FUTURE LANE

+CONSTRUCT GROUND-IN RUMBLE STRIPS PER INDEX 518

REVISIONS				Kimley-Horn and Associates, Inc. Certificate Of Authorization No. 696 Hool Gin Ng, P.E. P.E. License No. 58123 1920 Wekiva Way, Suite 200 West Palm Beach, Florida 33411	STATE OF FLORIDA DEPARTMENT OF TRANSPORTATION			TYPICAL SECTION	SHEET NO.
DATE	DESCRIPTION	DATE	DESCRIPTION		ROAD NO.	COUNTY	FINANCIAL PROJECT ID		38
					91	PALM BEACH	406144-1-52-01		

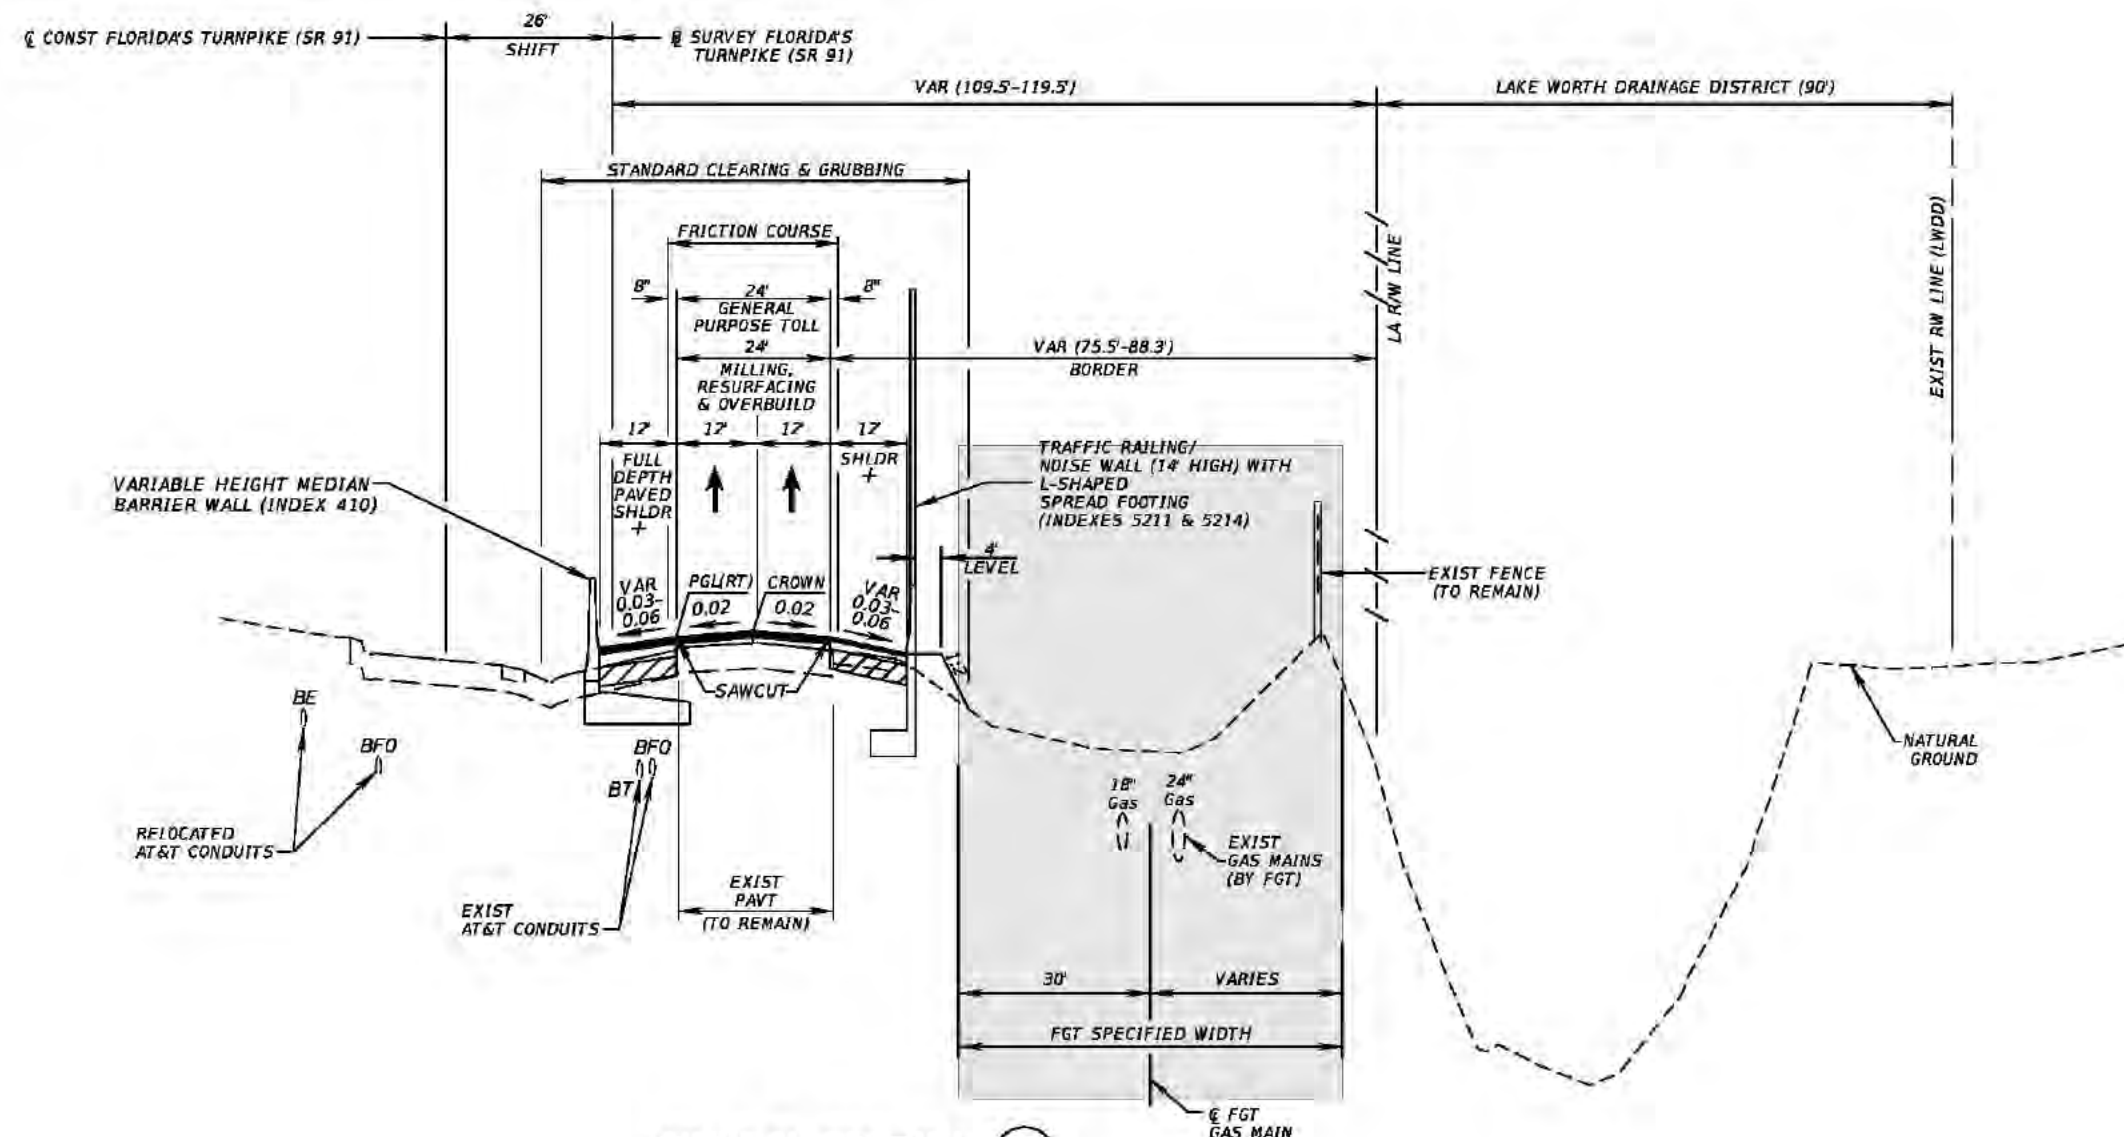

TYPICAL SECTION (17)
SR 91 (FLORIDA'S TURNPIKE)
AT NB APPROACH TO
WEST PALM BEACH SERVICE PLAZA
STA 2448+60.00 TO STA 2460+50.00

MILLING, OVERBUILD & RESURFACING

TYPE SP STRUCTURAL COURSE (TRAFFIC D) (2")
 AND FRICTION COURSE FC-5 (3/4") (PG 76-22)

MILLING, OVERBUILD & RESURFACING
(INSIDE SHOULDER PAVEMENT)

TYPE SP STRUCTURAL COURSE (TRAFFIC B) (1") (PG 76-22)

MILLING, OVERBUILD & RESURFACING
(OUTSIDE SHOULDER PAVEMENT)

TYPE SP STRUCTURAL COURSE (TRAFFIC B) (1 1/2") (PG 76-22)

TRAFFIC DATA


CURRENT YEAR = 2015 AADT = 73,700
 ESTIMATED OPENING YEAR = 2020 AADT = 80,100
 ESTIMATED DESIGN YEAR = 2040 AADT = 126,400
 K = 9.5% D = 56.6% T = 11.3% (24 HOUR)
 DESIGN HOUR T = 6.0%
 TRUCK DDHV = 408
 DESIGN SPEED = 70 MPH
 POSTED SPEED = 70 MPH


LEGEND

USE BLACK BASE ONLY
 TO MITIGATE SUB STANDARD
 BASE CLEARANCE

+ CONSTRUCT GROUND-IN RUMBLE STRIPS PER INDEX 518

REVISIONS				Kimley-Horn and Associates, Inc. Certificate Of Authorization No. 696 Hool Gin Ng, P.E. P.E. License No. 58123 1920 Wekiva Way, Suite 200 West Palm Beach, Florida 33411	STATE OF FLORIDA DEPARTMENT OF TRANSPORTATION			TYPICAL SECTION	SHEET NO.		
DATE	DESCRIPTION		DATE		DESCRIPTION		ROAD NO.		COUNTY	FINANCIAL PROJECT ID	39
							91		PALM BEACH	406144-1-52-01	

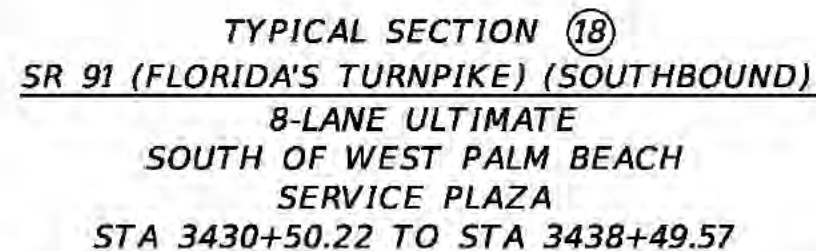

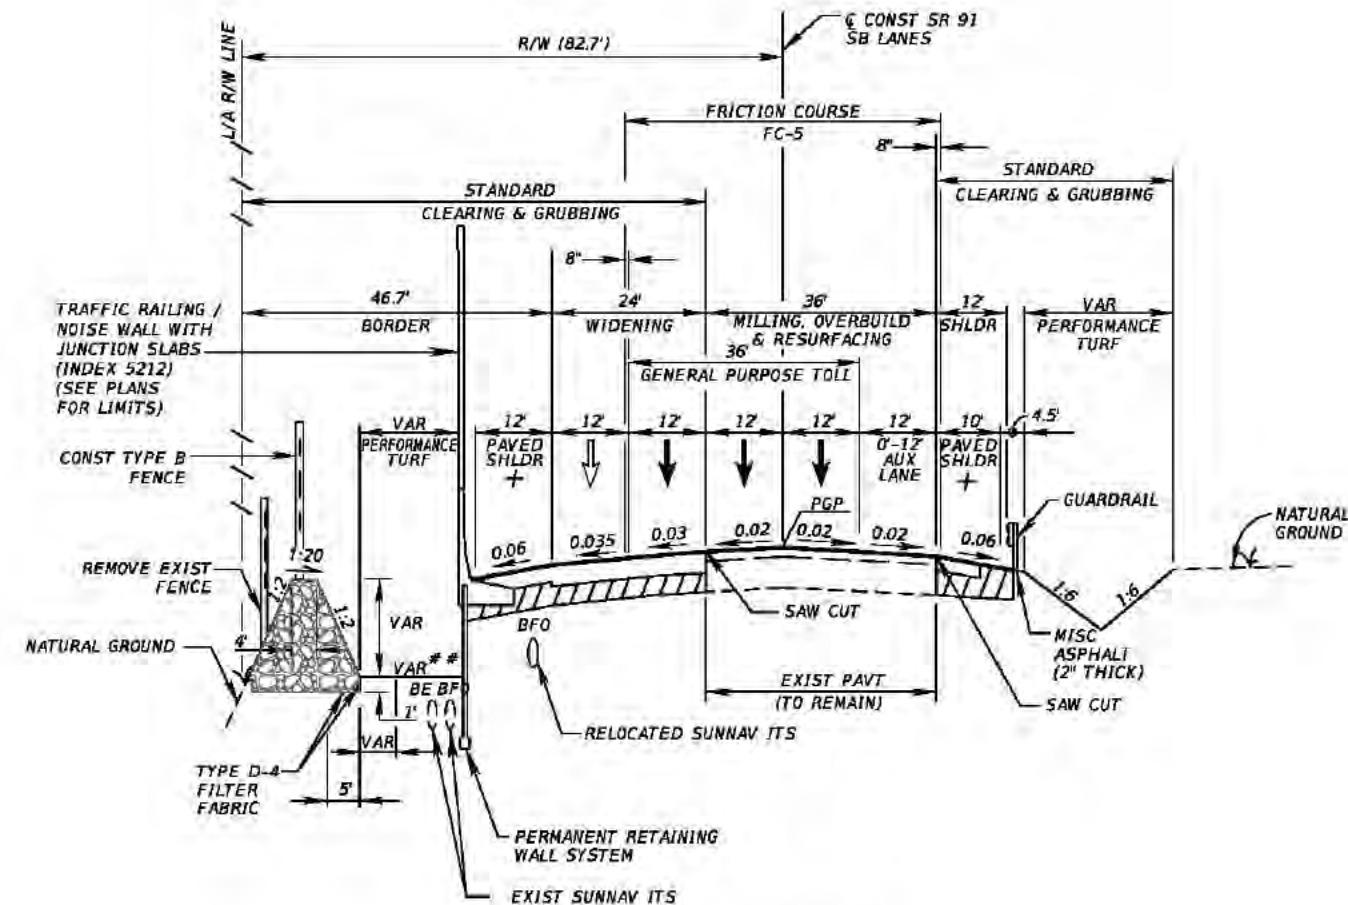

TYPICAL SECTION (19)
SR 91 (FLORIDA'S TURNPIKE) (SOUTHBOUND)
8-LANE ULTIMATE
LEAVING WEST PALM
BEACH SERVICE PLAZA
STA 3438+49.57 TO STA 3448+00.00

TRAFFIC DATA

CURRENT YEAR = 2015 AADT = 73,700
 ESTIMATED OPENING YEAR = 2020 AADT = 80,100
 ESTIMATED DESIGN YEAR = 2040 AADT = 126,400
 K = 9.5% D = 56.6% T = 11.3% (24 HOUR)
 DESIGN HOUR T = 6.0%
 TRUCK DDHV = 408
 DESIGN SPEED = 70 MPH
 POSTED SPEED = 70 MPH

WIDENING & NEW CONSTRUCTION

OPTIONAL BASE GROUP 12 WITH
 TYPE SP STRUCTURAL COURSE (TRAFFIC D) (3\"/>

MILLING, OVERBUILD & RESURFACING

TYPE SP STRUCTURAL COURSE (TRAFFIC D) (2\"/>

WIDENING (SHOULDER PAVEMENT)

OPTIONAL BASE GROUP 4 WITH
 TYPE SP STRUCTURAL COURSE (TRAFFIC B) (2\"/>

**MILLING, OVERBUILD & RESURFACING
 (INSIDE SHOULDER PAVEMENT)**

TYPE SP STRUCTURAL COURSE (TRAFFIC B) (1\"/>

LEGEND


 GRAVEL FILL (COURSE AGGREGATE, STANDARD SIZE, NO. 4 GRADED) (SEE PLAN FOR LIMITS)

 FUTURE LANE

+CONSTRUCT GROUND-IN RUMBLE STRIPS PER INDEX 518

WIDTH AND INVERT VARIES. SEE CROSS SECTIONS AND PLANS.

REVISIONS				Kimley-Horn and Associates, Inc. Certificate Of Authorization No. 696 Hool Gin Ng, P.E. P.E. License No. 58123 1920 Wekiva Way, Suite 200 West Palm Beach, Florida 33411	STATE OF FLORIDA DEPARTMENT OF TRANSPORTATION			TYPICAL SECTION	SHEET NO.
DATE	DESCRIPTION	DATE	DESCRIPTION		ROAD NO.	COUNTY	FINANCIAL PROJECT ID		41
					91	PALM BEACH	406144-1-52-01		

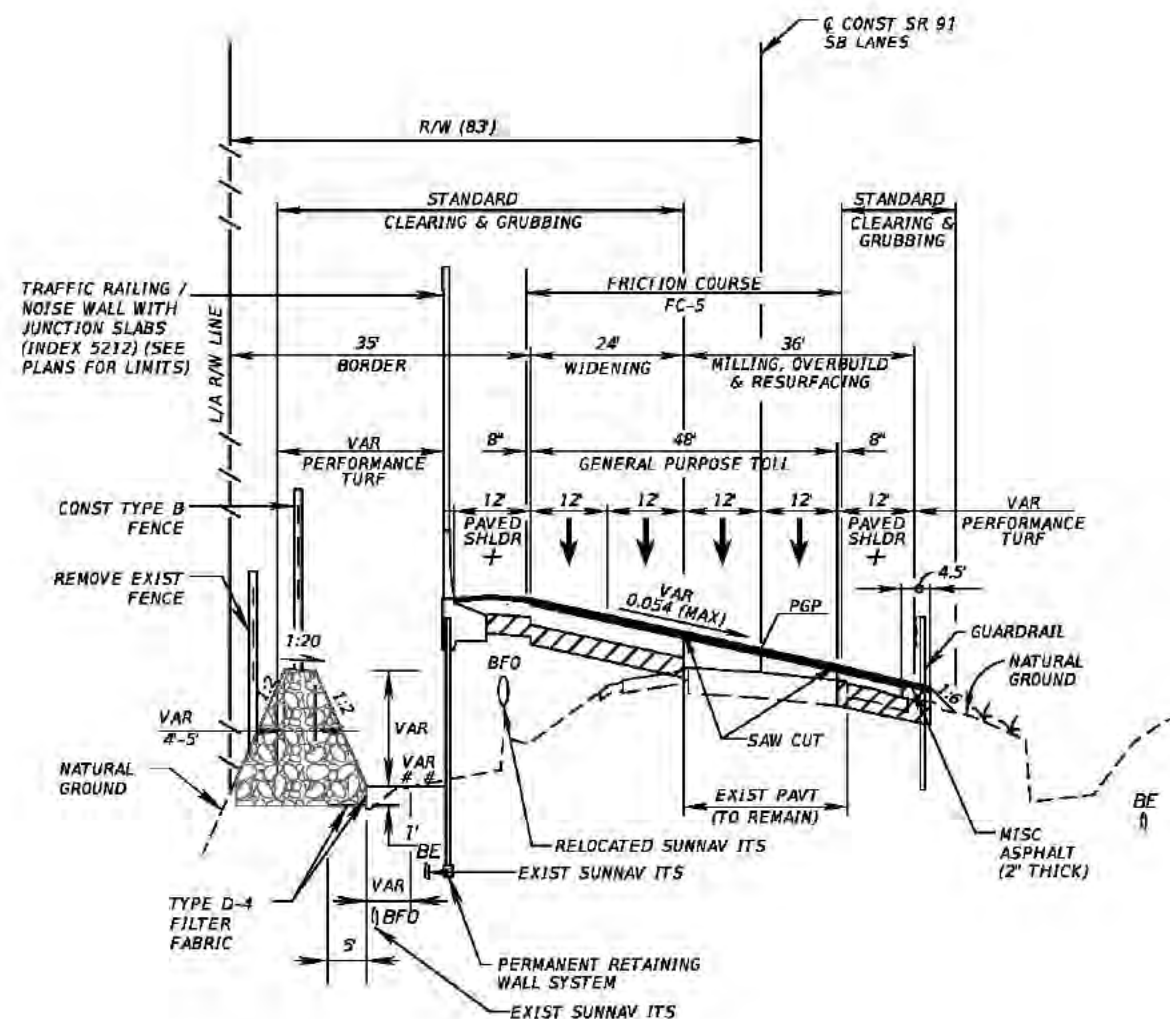

PROPOSED TYPICAL SECTION (20)
SR 91 (FLORIDA'S TURNPIKE) (SOUTHBOUND)
8-LANE ULTIMATE
NORTH OF WEST PALM BEACH
SERVICE PLAZA
STA 3448+00.00 TO STA 3477+60.00

TRAFFIC DATA

CURRENT YEAR = 2015 AADT = 73,700
ESTIMATED OPENING YEAR = 2020 AADT = 80,100
ESTIMATED DESIGN YEAR = 2040 AADT = 126,400
K = 9.5% D = 56.6% T = 11.3% (24 HOUR)
DESIGN HOUR T = 6.0%
TRUCK DDHV = 408
DESIGN SPEED = 70 MPH
POSTED SPEED = 70 MPH

WIDENING & NEW CONSTRUCTION

OPTIONAL BASE GROUP 12 WITH
TYPE SP STRUCTURAL COURSE (TRAFFIC D) (3")
TYPE SP STRUCTURAL COURSE (TRAFFIC D) (2") (PG 76-22)
AND FRICTION COURSE FC-5 (3/4") (PG 76-22)

MILLING, OVERBUILD & RESURFACING

TYPE SP STRUCTURAL COURSE (TRAFFIC D) (2")
AND FRICTION COURSE FC-5 (3/4") (PG 76-22)

WIDENING (SHOULDER PAVEMENT)

OPTIONAL BASE GROUP 4 WITH
TYPE SP STRUCTURAL COURSE (TRAFFIC B) (2") (PG 76-22)

**MILLING, OVERBUILD & RESURFACING
(INSIDE SHOULDER PAVEMENT)**

TYPE SP STRUCTURAL COURSE (TRAFFIC B) (1") (PG 76-22)

LEGEND


 GRAVEL FILL (COURSE AGGREGATE, STANDARD SIZE, NO. 4 GRADED) (SEE PLAN FOR LIMITS)

 FUTURE LANE


+ CONSTRUCT GROUND-IN RUMBLE STRIPS PER INDEX 518

WIDTH AND INVERT VARIES. SEE CROSS SECTIONS AND PLANS.

REVISIONS				Kimley-Horn and Associates, Inc. Certificate of Authorization No. 696 Hool Gin Ng, P.E. P.E. License No. 58123 1920 Wekiva Way, Suite 200 West Palm Beach, Florida 33411	STATE OF FLORIDA DEPARTMENT OF TRANSPORTATION			TYPICAL SECTION	SHEET NO.
DATE	DESCRIPTION	DATE	DESCRIPTION		ROAD NO.	COUNTY	FINANCIAL PROJECT ID		
					91	PALM BEACH	406144-1-52-01		42

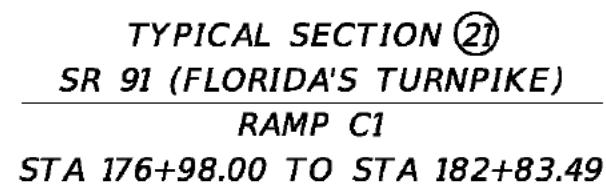

TYPE SP STRUCTURAL COURSE (TRAFFIC A) (1") (PG 76-22)

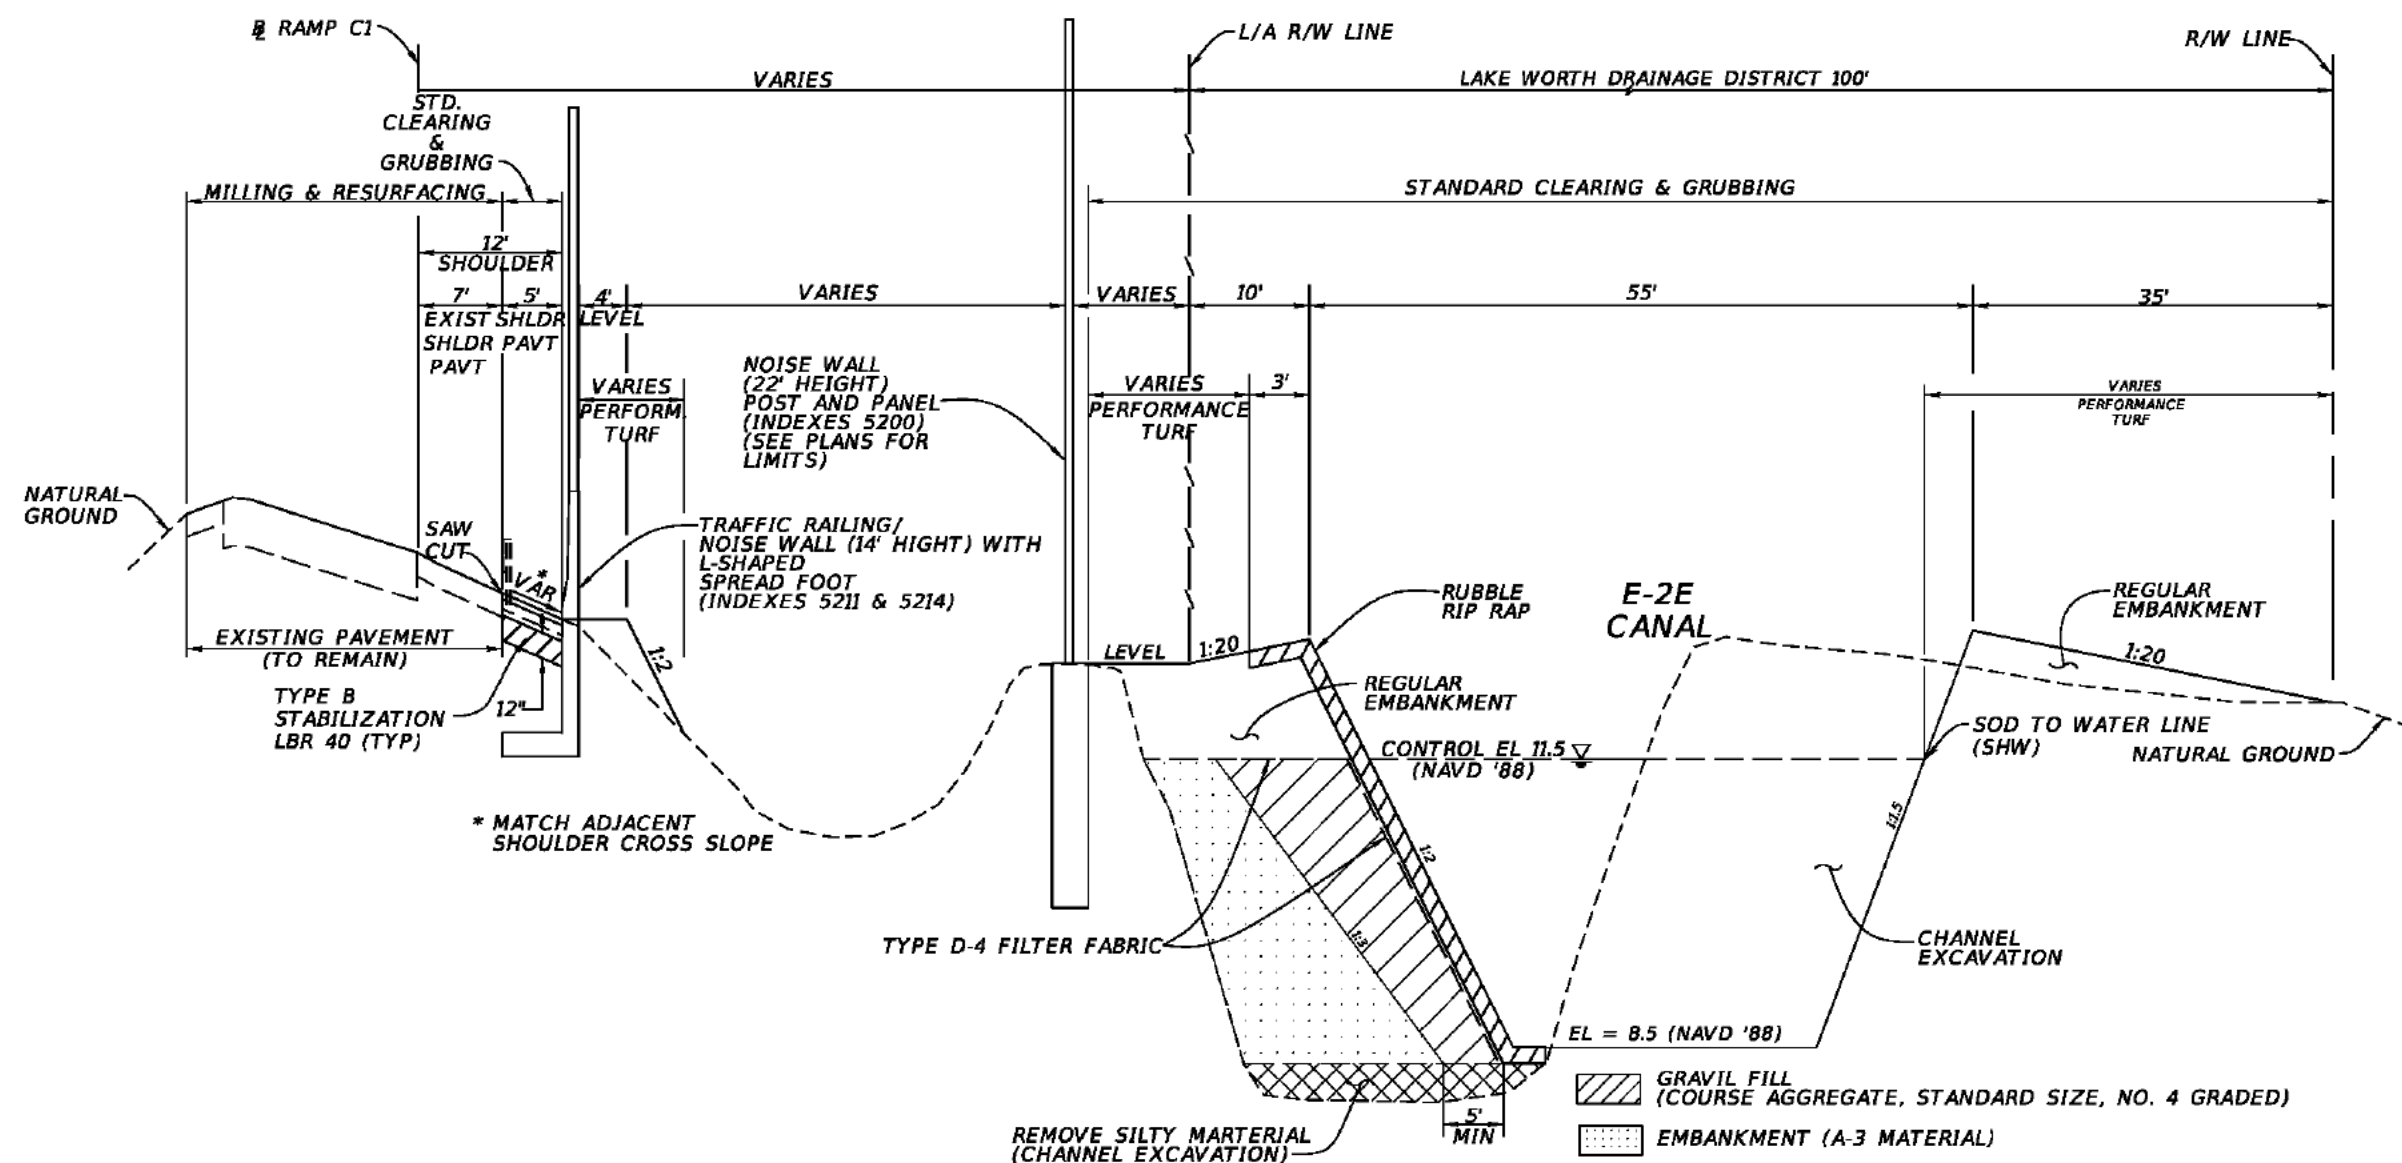

REVISIONS			
DATE	DESCRIPTION	DATE	DESCRIPTION

Kimley-Horn and Associates, Inc.
 Certificate Of Authorization No. 696
 Hool Gin Ng, P.E.
 P.E. License No. 58123
 1920 Wekiva Way, Suite 200
 West Palm Beach, Florida 33411

STATE OF FLORIDA DEPARTMENT OF TRANSPORTATION		
ROAD NO.	COUNTY	FINANCIAL PROJECT ID
91	PALM BEACH	406144-1-52-01


TYPICAL SECTION

SHEET
NO.
44

GENERAL NOTES:

- [illegible]

REVISIONS				Kimley-Horn and Associates, Inc. Certificate Of Authorization No. 696 Hooi Gin Ng, P.E. P.E. License No. 58123 1920 Wekiva Way, Suite 200 West Palm Beach, Florida 33411	STATE OF FLORIDA DEPARTMENT OF TRANSPORTATION			OPTIONAL MATERIALS TABULATION	SHEET NO.
DATE	DESCRIPTION	DATE	DESCRIPTION		ROAD NO.	COUNTY	FINANCIAL PROJECT ID		45
					91	PALM BEACH	406144-1-52-01		

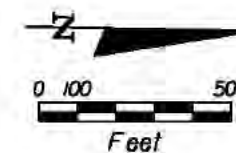

SR 804 (BOYNTON BEACH BLVD)

LWDD CANAL L-24
(CONTROL EL 14.50)
SECTION 28-45-42
SECTION 21-45-42

BEGIN PROJECT
FPID 406144-1-52-01
CONST FLORIDA'S
TURNPIKE (SR 91)
STA 2084+97.25
CONNECT TO EXISTING

PI STA. 2089+60.45
OFFSET: 2.84' (R TO C)
 $\Delta = 0^\circ 23' 23''$ (LT)

CONST
FLORIDA'S TURNPIKE
(SR 91)

LWDD L-23 CANAL
(CONTROL EL 14.5)

PI STA. 2099+65.46
OFFSET: 16.00' (R TO C)
 $\Delta = 0^\circ 45' 00''$ (RT)

BEGIN BRIDGE
STA 2111+67.11

C. STANLEY
WEAVER CANAL
(CONTROL EL 14.5)

END BRIDGE
STA 2112+54.11

CONST
FLORIDA'S TURNPIKE
(SR 91)

LWDD L-22 CANAL
(CONTROL EL 14.5)


PI STA. 2135+07.98
OFFSET: 16.00' (R TO C)
 $\Delta = 0^\circ 25' 00''$ (LT)

MATCH LINE STA 2144+00.00

LEGEND:


(01) PLAN (XX) IDENTIFICATION NUMBER
IN PLAN BORDER DESCRIPTION

REVISIONS				Kimley-Horn and Associates, Inc. Certificate Of Authorization No. 696 Hooi Gin Ng, P.E. P.E. License No. 58123 1920 Wekiva Way, Suite 200 West Palm Beach, Florida 33411	STATE OF FLORIDA DEPARTMENT OF TRANSPORTATION			PROJECT LAYOUT (01)	SHEET NO.
DATE	DESCRIPTION	DATE	DESCRIPTION		ROAD NO.	COUNTY	FINANCIAL PROJECT ID		46
					91	PALM BEACH	406144-1-52-01		

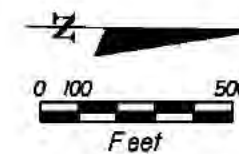

MATCH LINE STA 2144+00.00


MATCH LINE STA 2216+00.00

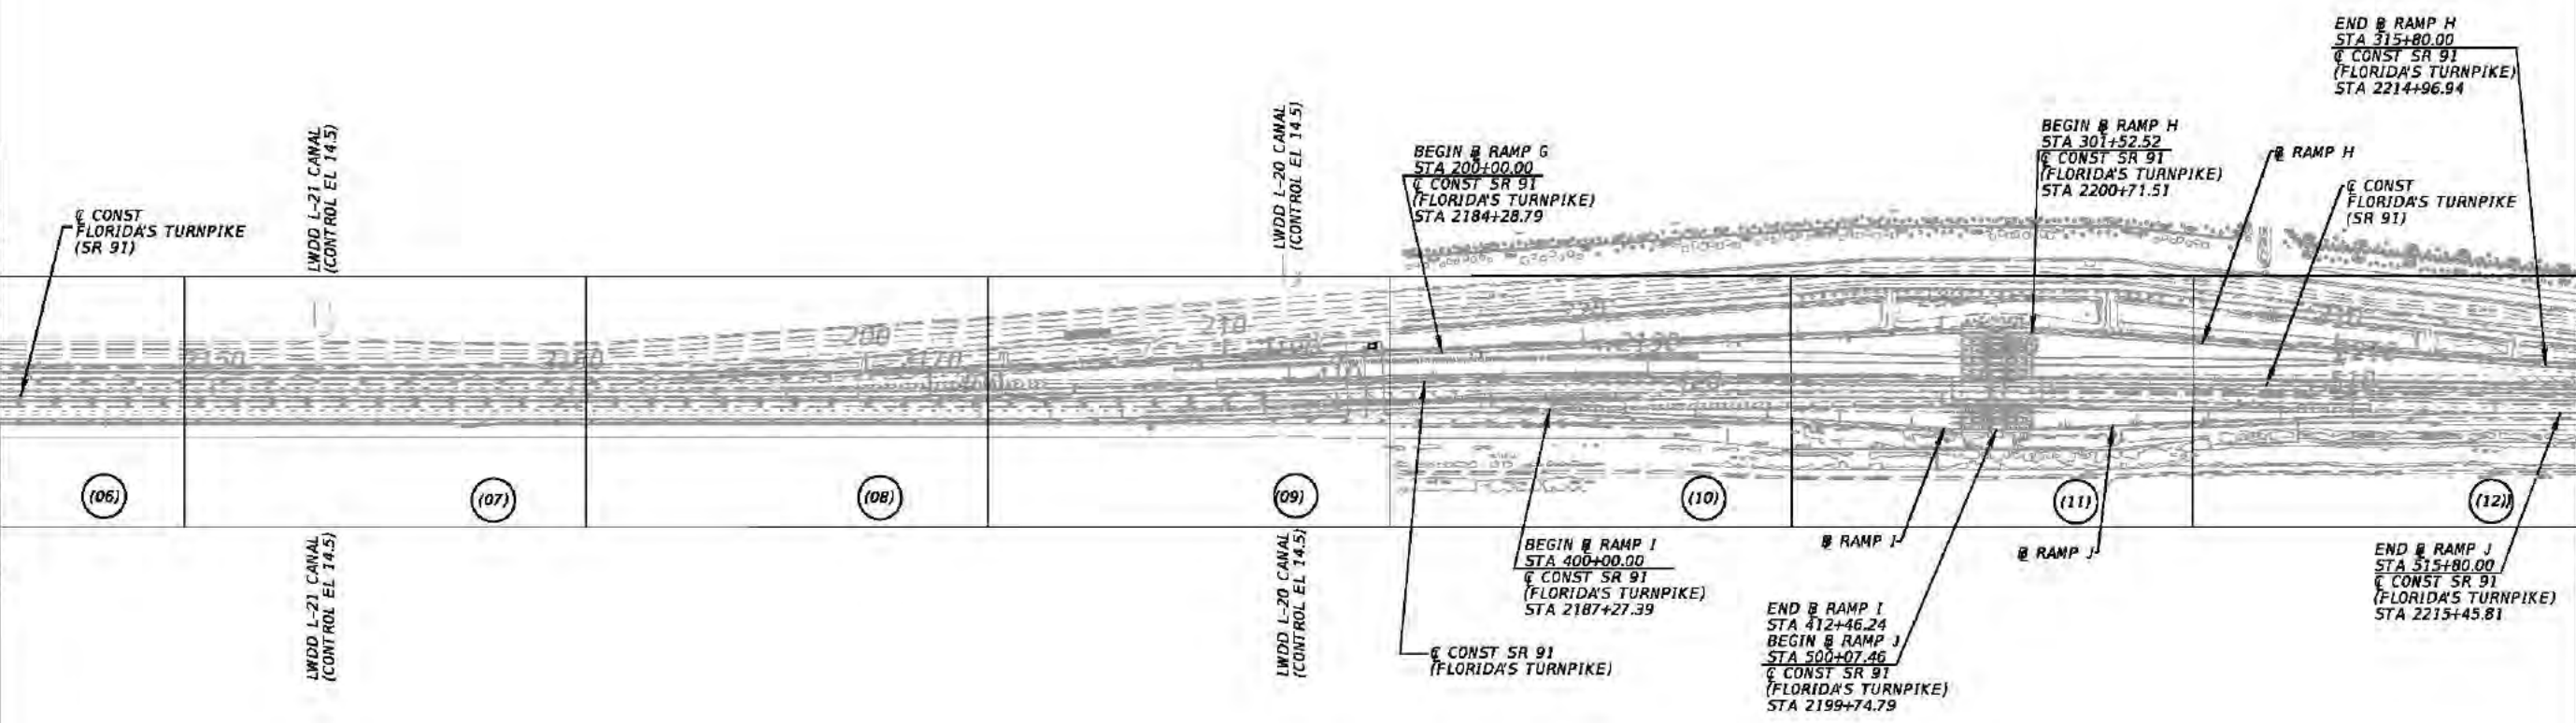

LEGEND:

(10) PLAN (XX) IDENTIFICATION NUMBER
IN PLAN BORDER DESCRIPTION

REVISIONS				Kimley-Horn and Associates, Inc. Certificate Of Authorization No. 696 Hooi Gin Ng, P.E. P.E. License No. 58123 1920 Wekiva Way, Suite 200 West Palm Beach, Florida 33411	STATE OF FLORIDA DEPARTMENT OF TRANSPORTATION			PROJECT LAYOUT (02)	SHEET NO. 47
DATE	DESCRIPTION	DATE	DESCRIPTION		ROAD NO.	COUNTY	FINANCIAL PROJECT ID		
					91	PALM BEACH	406144-1-52-01		

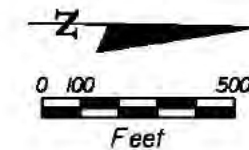

MATCH LINE STA 2216+00.00

MATCH LINE STA 2288+00.00

HYPOLUXO RD

CONST
FLORIDA'S
TURNPIKE
(SR 91)

CONST
FLORIDA'S
TURNPIKE
(SR 91)

CONST
FLORIDA'S
TURNPIKE
(SR 91)


CONST SR 91
(FLORIDA'S TURNPIKE)

LWDD L-16 CANAL
(CONTROL EL 11.50)

LEGEND:

(15) PLAN (XX) IDENTIFICATION NUMBER
IN PLAN BORDER DESCRIPTION



REVISIONS				Kimley-Horn and Associates, Inc. Certificate Of Authorization No. 696 Hooi Gin Ng, P.E. P.E. License No. 58123 1920 Wekiva Way, Suite 200 West Palm Beach, Florida 33411	STATE OF FLORIDA DEPARTMENT OF TRANSPORTATION			PROJECT LAYOUT (03)	SHEET NO.
DATE	DESCRIPTION	DATE	DESCRIPTION		ROAD NO.	COUNTY	FINANCIAL PROJECT ID		
					91	PALM BEACH	406144-1-52-01		48

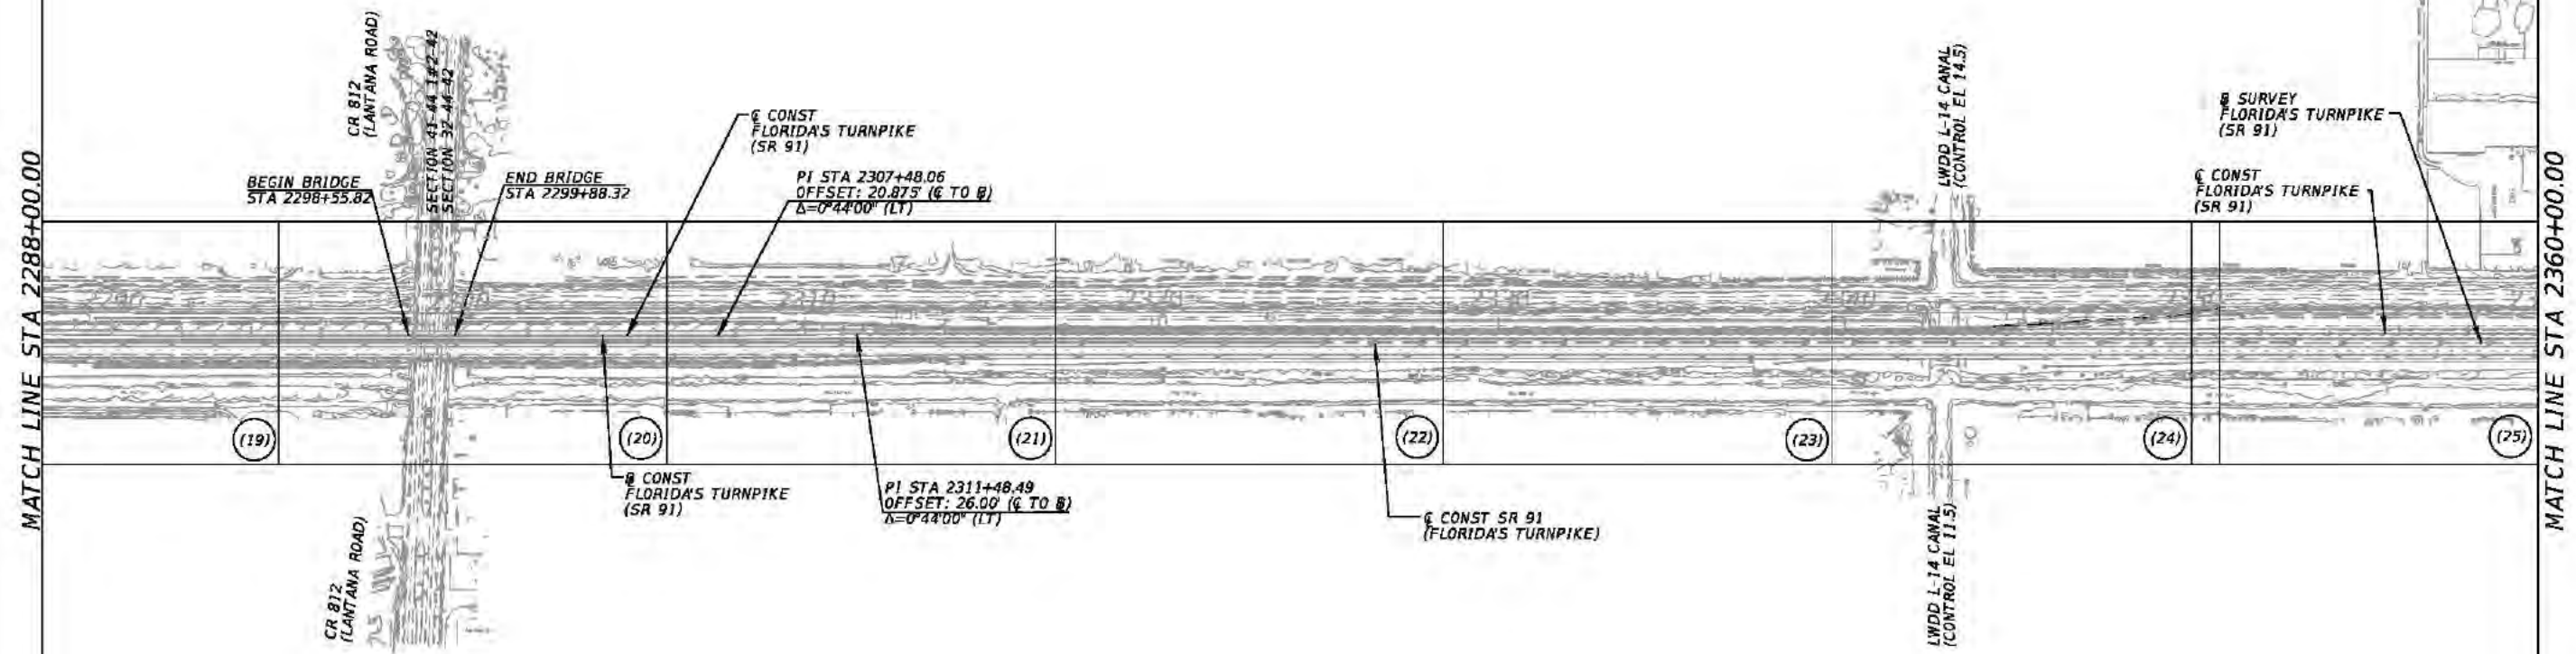


LEGEND:

(22) PLAN (XX) IDENTIFICATION NUMBER
IN PLAN BORDER DESCRIPTION


REVISIONS				Kimley-Horn and Associates, Inc. Certificate of Authorization No. 696 Hooi Gin Ng, P.E. P.E. License No. 58123 1920 Wekiva Way, Suite 200 West Palm Beach, Florida 33411	STATE OF FLORIDA DEPARTMENT OF TRANSPORTATION			PROJECT LAYOUT (04)	SHEET NO.
DATE	DESCRIPTION	DATE	DESCRIPTION		ROAD NO.	COUNTY	FINANCIAL PROJECT ID		49
					91	PALM BEACH	406144-1-52-01		

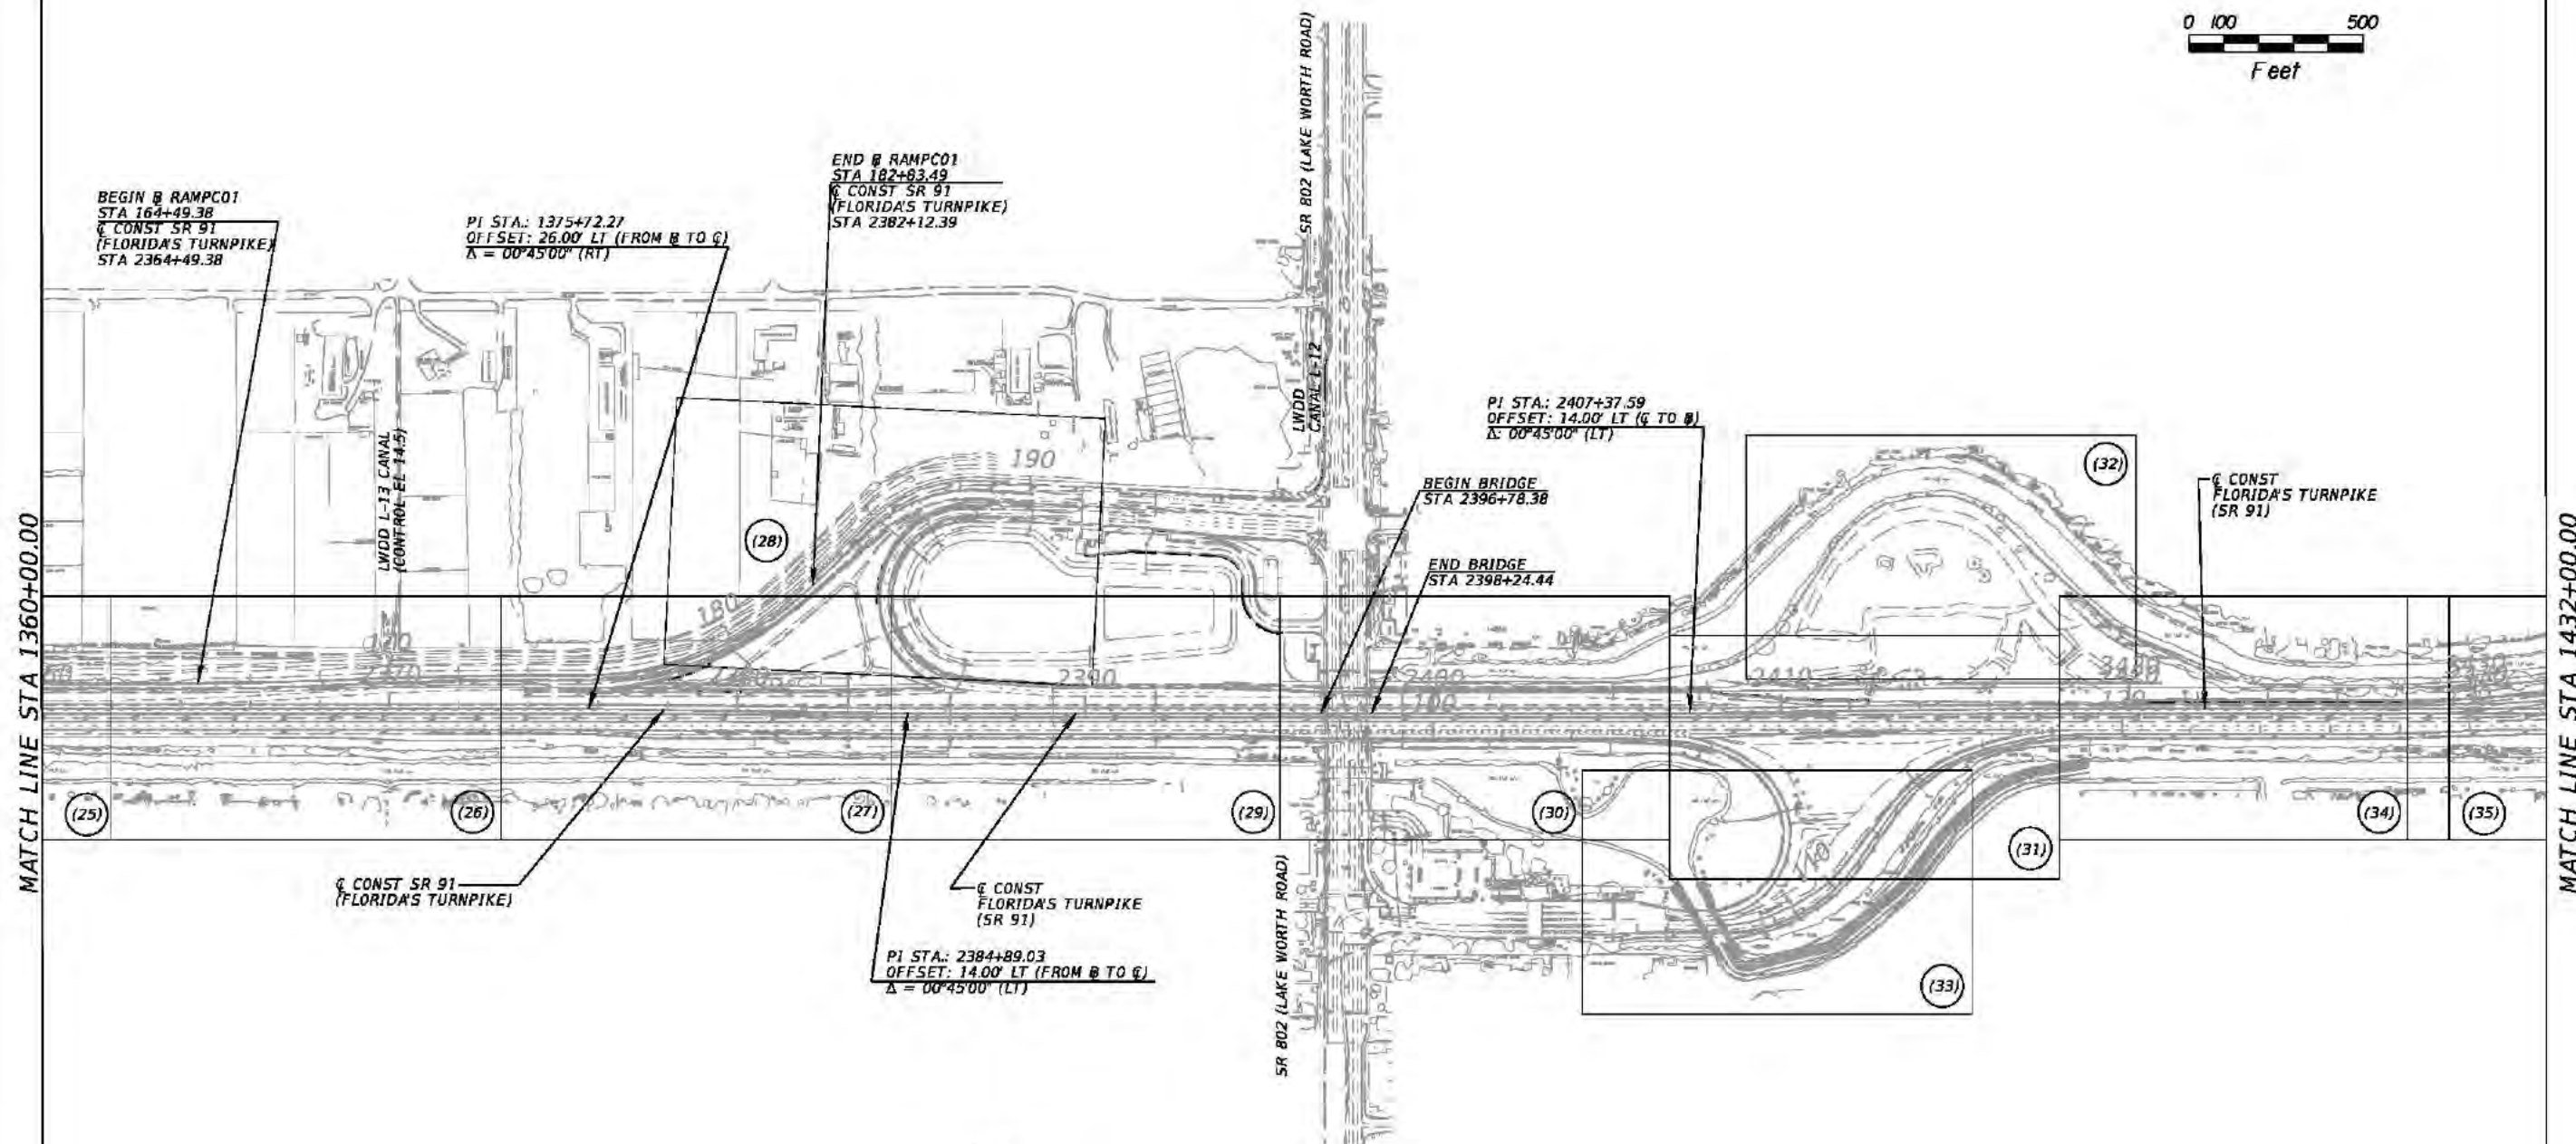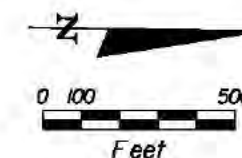

REVISIONS				Kimley-Horn and Associates, Inc. Certificate Of Authorization No. 696 Hooi Gin Ng, P.E. P.E. License No. 58123 1920 Wekiva Way, Suite 200 West Palm Beach, Florida 33411	STATE OF FLORIDA DEPARTMENT OF TRANSPORTATION			PROJECT LAYOUT (05)	SHEET NO.
DATE	DESCRIPTION	DATE	DESCRIPTION		ROAD NO.	COUNTY	FINANCIAL PROJECT ID		50
					91	PALM BEACH	406144-1-52-01		

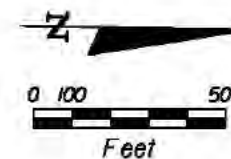

MATCH LINE STA 1432+00.00

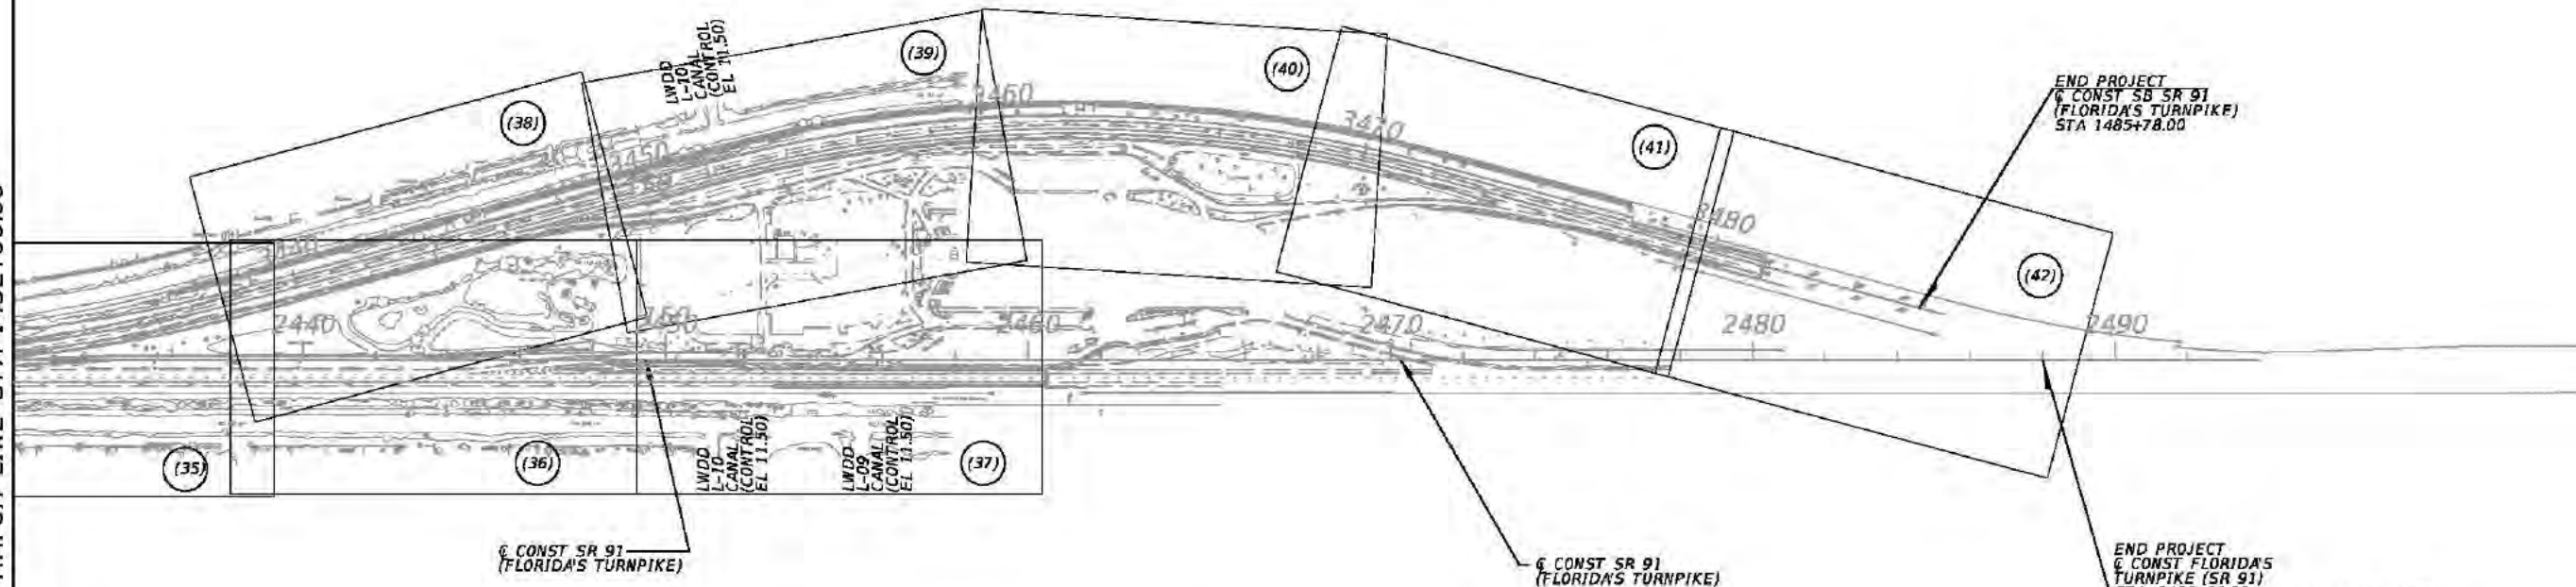

LEGEND:

(40) PLAN (XX) IDENTIFICATION NUMBER
IN PLAN BORDER DESCRIPTION

REVISIONS				Kimley-Horn and Associates, Inc. Certificate of Authorization No. 696 Hooi Gin Ng, P.E. P.E. License No. 58123 1920 Wekiva Way, Suite 200 West Palm Beach, Florida 33411	STATE OF FLORIDA DEPARTMENT OF TRANSPORTATION			PROJECT LAYOUT (06)	SHEET NO.
DATE	DESCRIPTION	DATE	DESCRIPTION		ROAD NO.	COUNTY	FINANCIAL PROJECT ID		51
					91	PALM BEACH	406144-1-52-01		

CURVE DATA													
LINE	CURVE NO.	CONTROL POINT	STATION	COORDINATES		Δ	D	T	L	R	e	DESIGN SPEED (MPH)	TIE AND REMARKS
				NORTH	EAST								
Q CONST SR 91 (FLORIDA'S TURNPIKE)	CL01-3	CC		797532.7074	857964.9143	1° 29' 19.14" (LT)	0° 05' 00.00"	893.2395	1786.3785	68754.9354	NC	70.0	
		PC	2062+13.71	797452.6691	926719.8032								
		PI	2071+06.95	798345.9080	926720.8430								
		PT	2080+00.09	799238.8724	926698.6771								
	CL01-16	CC		807631.4757	902724.3669	2° 37' 50.76" (LT)	0° 14' 26.66"	546.4912	1092.7904	23800.0000	NC	70.0	
		PC	2168+18.32	808055.2162	926520.5945								
		PI	2173+64.82	808601.6208	926510.8646								
		PT	2179+11.12	809147.0029	926476.0654								
	CL01-17	CC		810611.5881	949429.3873	3° 23' 27.15" (RT)	0° 14' 56.80"	680.7910	1361.1845	23000.0000	NC	70.0	
		PC	2179+11.12	809147.0029	926476.0654								
		PI	2185+91.91	809826.4122	926432.7142								
		PT	2192+72.30	810507.1962	926429.6243								
Q SB ROADWAY (FLORIDA'S TURNPIKE)	CLSB01-3	CC		833957.2434	922006.4856	15° 00' 00.00" (LT)	1° 25' 30.97"	529.2430	1052.4335	4020.0000	0.052	70.0	
		PC	3427+97.14	834028.1072	926025.8609								
		PI	3433+26.38	834557.2680	926016.5315								
		PT	3438+49.57	835065.9835	925870.5631								
	CLSB01-6	CC		837400.9922	929186.9022	30° 00' 00.00" (RT)	1° 29' 43.09"	1026.7059	2006.2832	3831.7187	0.054	70.0	
		PC	3451+79.35	836344.1812	925503.8031								
		PI	3462+06.05	837331.0646	925220.6315								
		PT	3471+85.63	838327.3165	925468.8393								
Q RAMP C	RAMPC01-1	CC		827545.9872	918451.9497	2° 48' 44.04" (LT)	0° 45' 00.15"	187.5091	374.9429	7639.0000	RC	55.0	
		PC	164+49.38	827680.6461	926089.7628								
		PI	166+36.89	827868.1260	926086.4574								
		PT	168+24.32	828055.2180	926073.9577								
	RAMPC01-2	CC		828819.0976	937507.4685	2° 48' 44.04" (RT)	0° 30' 00.02"	281.2759	562.4388	11459.0000	NC	55.0	
		PC	168+24.32	828055.2180	926073.9577								
		PI	171+05.60	828335.8682	926055.2073								
		PT	173+86.76	828617.1004	926050.2490								
	RAMPC01-5	CC		828777.9858	925092.2641	43° 08' 08.06" (LT)	5° 59' 58.41"	377.4903	718.9791	955.0000	0.082	45.0	
		PC	175+64.51	828794.8204	926047.1157								
		PI	179+42.00	829172.2520	926040.4614								
		PT	182+83.49	829443.1285	925777.5453								
Q RAMP E	RAMPE01-3	CC		836336.2239	927915.5400	10° 27' 28.42" (RT)	2° 29' 59.34"	209.7560	418.3466	2292.0000	0.041	35.0	
		PC	145+13.11	835704.0766	925712.4403								
		PI	147+22.87	835905.6968	925654.5883								
		PT	149+31.46	836114.4687	925634.2940								
Q RAMP F	RAMPF01-3	CC		835134.2300	917546.0400	2° 58' 50.67" (LT)	0° 40' 30.93"	220.7600	441.4200	8485.0000	RC	55.0	
		PC	140+53.00	835283.8100	926029.7300								
		PI	142+73.76	835504.5300	926025.8300								
		PT	144+94.42	835724.7600	926010.4700								
	RAMPF01-6	CC		836306.7200	934310.0900	3° 22' 12.12" (RT)	0° 41' 19.14"	244.7500	489.3700	8320.0000	NC	45.0	
		PC	144+97.35	835727.6800	926010.2700								
		PI	147+42.10	835971.8400	925993.2300								
		PT	149+86.72	836216.5800	925990.5800								
Q RAMP G	RAMPG01-1	CC		807789.9900	911456.9300	3° 09' 44.48" (LT)	0° 22' 55.10"	414.0600	827.9000	15000.0000	NC	55.0	
		PC	200+00.00	808057.0500	926454.5500								
		PI	204+14.06	808471.0400	926447.1800								
		PT	208+27.90	808884.0000	926416.9800								
	RAMPG01-2	CC		810564.9800	949403.6000	1° 56' 03.52" (RT)	0° 14' 54.94"	389.0900	778.1000	23048.0000	NC	55.0	
		PC	208+27.90	808884.0000	926416.9800								
		PI	212+16.99	809272.0500	926388.6000								
		PT	216+06.01	809660.8400	926373.3400								

REVISIONS				Kimley-Horn and Associates, Inc. Certificate Of Authorization No. 696 Hool Gin Ng, P.E. P.E. License No. 58123 1920 Wekiva Way, Suite 200 West Palm Beach, Florida 33411	STATE OF FLORIDA DEPARTMENT OF TRANSPORTATION			CURVE DATA AND COORDINATES (01)	SHEET NO.
DATE	DESCRIPTION	DATE	DESCRIPTION		ROAD NO.	COUNTY	FINANCIAL PROJECT ID		
					SR 91	PALM BEACH	406144-1-52-01		

CURVE DATA													
LINE	CURVE NO.	CONTROL POINT	STATION	COORDINATES		Δ	D	T	L	R	e	DESIGN SPEED (MPH)	TIE AND REMARKS
				NORTH	EAST								
RAMP I													
	RAMP I 01-1	CC		807964.2500	903570.5800	2° 23' 39.82" (LT)	0° 14' 56.34"	480.9100	961.6700	23012.0000	NC	55.0	
		PC	400+00.00	808373.9600	926578.9300								
		PI	404+80.91	808854.7900	926570.3700								
		PT	409+61.67	809334.8400	926541.7200								
	RAMP I 01-2	CC		810701.8600	949452.9800	0° 32' 37.30" (RT)	0° 14' 58.68"	108.9000	217.8000	22952.0000	NC	55.0	
		PC	409+61.67	809334.8400	926541.7200								
		PI	410+70.57	809443.5500	926535.2400								
		PT	411+79.47	809552.3100	926529.7800								
	RAMP I 01-3	CC		809862.8400	932722.0000	3° 48' 21.59" (RT)	0° 55' 26.85"	206.0000	411.8500	6200.0000	RC	45.0	
		PC	411+79.47	809552.3100	926529.7800								
		PI	413+85.47	809758.0500	926519.4700								
		PT	415+91.32	809964.0200	926522.8300								
	RAMP I 01-4	CC		809862.8400	932722.0000	1° 30' 27.54" (RT)	0° 55' 26.85"	81.5800	163.1400	6200.0000	RC	45.0	
		PC	415+92.05	809964.7500	926522.8400								
		PI	416+73.62	810046.3200	926524.1800								
	PT	417+55.19	810127.8200	926527.6700									
RAMP I 01-5	CC		810619.3200	915038.1800	2° 38' 21.49" (LT)	0° 29' 53.61"	264.9200	527.7400	11500.0000	NC	35.0		
	PC	417+55.19	810127.8200	926527.6700									
	PI	420+20.11	810392.4900	926538.9900									
	PT	422+84.93	810657.4100	926538.1100									
RAMP J													
	RAMP J 01-5	CC		813314.3600	949477.1200	1° 58' 19.24" (RT)	0° 14' 56.80"	395.8500	791.6200	23000.0000	NC	35.0	
		PC	507+88.46	811990.1300	926515.2700								
		PI	511+84.31	812385.3200	926492.4800								
		PT	515+80.08	812781.0600	926483.3000								
RAMP K													
	RAMP K 01-3	CC		838310.2338	926947.7769	15° 07' 05.14" (RT)	4° 5' 33.20"	185.7815	369.4047	1400.0000	0.043	35.0	
		PC	151+26.97	838185.0967	925553.3807								
		PI	153+12.75	838370.1346	925536.7749								
		PT	154+96.37	838553.0993	925569.0034								


REVISIONS				Kimley-Horn and Associates, Inc. Certificate Of Authorization No. 696 Hool Gin Ng, P.E. P.E. License No. 58123 1920 Wekiva Way, Suite 200 West Palm Beach, Florida 33411	STATE OF FLORIDA DEPARTMENT OF TRANSPORTATION			CURVE DATA AND COORDINATES (02)	SHEET NO.
DATE	DESCRIPTION	DATE	DESCRIPTION		ROAD NO.	COUNTY	FINANCIAL PROJECT ID		53
					SR 91	PALM BEACH	406144-1-52-01		

GENERAL NOTES


1. BENCH MARK DATUM IS NORTH AMERICAN VERTICAL DATUM OF 1988 (NAVD '88). ELEVATION 0.00 (NAVD '88) = ELEVATION 1.48 (NGVD '29)
2. STATIONS AND OFFSETS REFER TO THE TURNPIKE CENTERLINE OF CONSTRUCTION UNLESS OTHERWISE NOTED.
3. EXISTING DRAINAGE STRUCTURES, WITHIN CONSTRUCTION LIMITS, SHALL REMAIN UNLESS OTHERWISE NOTED.
4. WHERE A CONCRETE COLLAR/JACKET IS CALLED FOR IN THE PLANS, THE PIPE IS TO BE REMOVED TO THE NEAREST JOINT TO BEGIN THE PLACEMENT OF THE NEW PIPE; UNLESS IT WOULD REQUIRE ENCROACHMENT INTO THE ADJACENT LANE. IF A CONCRETE COLLAR/JACKET IS STILL NECESSARY, THE CONCRETE IS TO BE CURED AND INSPECTED TO ASSURE THE INTEGRITY OF THE COLLAR PRIOR TO PLACEMENT OF FILL MATERIAL. PIPE JOINTS MUST BE WRAPPED IN ACCORDANCE WITH INDEX 280. FILTER FABRICS USED TO WRAP PIPE JOINTS IN ACCORDANCE WITH SPECIFICATION 430 AND MUST BE TYPE D-3 WITH AN A.O.S. OF 70 TO 100.
5. THE LOCATION(S) OF THE UTILITIES SHOWN IN THE PLANS (INCLUDING THOSE DESIGNATED Vv,Vh, AND Vvh) ARE BASED ON LIMITED INVESTIGATIVE TECHNIQUES AND SHOULD BE CONSIDERED APPROXIMATE ONLY. THE VERIFIED LOCATIONS/ELEVATIONS APPLY ONLY AT THE POINTS SHOWN. INTERPOLATIONS BETWEEN THESE POINTS HAVE NOT BEEN VERIFIED.
6.

UTILITY OWNERS	CONTACT	TELEPHONE
AT&T (DISTRIBUTION)	CRAIG PETRIE	(407) 578-8000
COMCAST (BOCA/DELRAY)	GARTH BEDWARD	(561) 540-9263
PBC WATER UTILITIES DEPARTMENT	ANTHONY SPRINGSTEEL	(561) 804-0973
FLORIDA PUBLIC UTILITIES (FPU)	FRANTZ FENELON	(561) 493-6081
FLORIDA GAS TRANSMISSION (FGT)	DALE BUTCHER	(561) 602-3702
FPL FIBERNET, LLC	JOSEPH E. SANCHEZ	(407) 838-7171
FPL (TRANSMISSION)	DANNY HASKETT	(305) 552-2931
FPL (DISTRIBUTION)	GEORGE BECK	(561) 904-3604
HOT WIRE COMMUNICATIONS	JOHN VANVLEET	(407) 742-2003
	PHIL GALLUB	(305) 219-0286
7. IN ACCORDANCE WITH FDOT SPECIFICATIONS 8-6.4, SPECIAL EVENT DAYS FOR THIS PROJECT INCLUDE:
 - A. WORKING DAY BEFORE MARTIN LUTHER KING JR.
 - B. WORKING DAY BEFORE PRESIDENT'S DAY
 - C. BEFORE / AFTER INDEPENDENCE DAY JULY -3 & JULY -5
 - D. FRIDAY BEFORE EASTER
 - E. FRIDAY BEFORE MEMORIAL DAY
 - F. WEDNESDAY BEFORE THANKSGIVING
8. COORDINATE WITH TURNPIKE MAINTENANCE OFFICE, GIUSEPPE SCARINGI (TEL NO. 954-934-1226) FOR THE REMOVAL AND INSTALLATION OF HIGH TENSION CABLE BARRIER SYSTEM WITH SOCKETED POSTS AND END TERMINAL. THE EXISTING CABLE BARRIER SYSTEM IS A TEST LEVEL 3 (TL-3) GIBRALTAR CABLE BARRIER SYSTEMS. BARRIER WALL PER INDEX 415 AND TRAFFIC CONTROL SET UP PER INDEX 600 SERIES SHALL BE PROVIDED IN ABSENCE OF THE HIGH TENSION CABLE BARRIER SYSTEM DURING CONSTRUCTION TO PREVENT ERRANT VEHICLES FROM ENTERING ROADSIDE WATER HAZARDS.
9. COORDINATE WITH TURNPIKE MAINTENANCE ON THE DISPOSAL OF ANY DISMANTLED CABLE BARRIER SYSTEM.
10. ALL BOTTOM PROFILE ELEVATIONS AND CROSS SECTION ELEVATIONS FOR TREATMENT/ATTENUATION SWALES/DITCHES SHALL BE CONSTRUCTED TO WITHIN 0.1 FEET +/- OF THE VALUES SHOWN ON THE PLANS. ALSO, DITCH-BLOCK TOP ELEVATIONS AND/OR ANY LONGITUDINAL BERMS ADJACENT TO TREATMENT/ATTENUATION SWALES SHALL ALSO BE CONSTRUCTED WITHIN THIS EARTHWORK TOLERANCE.
11. "COORDINATE PROJECT INTERFACE AND CONSTRUCTION PHASING WITH ADJOINING PROJECTS FPID 437169-1 (PROJECT TO THE SOUTH) AND FPID 406143-1 (PROJECT TO THE NORTH)."


REVISIONS				Kimley-Horn and Associates, Inc. Certificate of Authorization No. 696 Hooi Gin Ng, P.E. P.E. License No. 58123 1920 Wekiva Way, Suite 200 West Palm Beach, Florida 33411	STATE OF FLORIDA DEPARTMENT OF TRANSPORTATION			PROJECT NOTES	SHEET NO.
DATE	DESCRIPTION	DATE	DESCRIPTION		ROAD NO.	COUNTY	FINANCIAL PROJECT ID		54
					SR 91	PALM BEACH	406144-1-52-01		

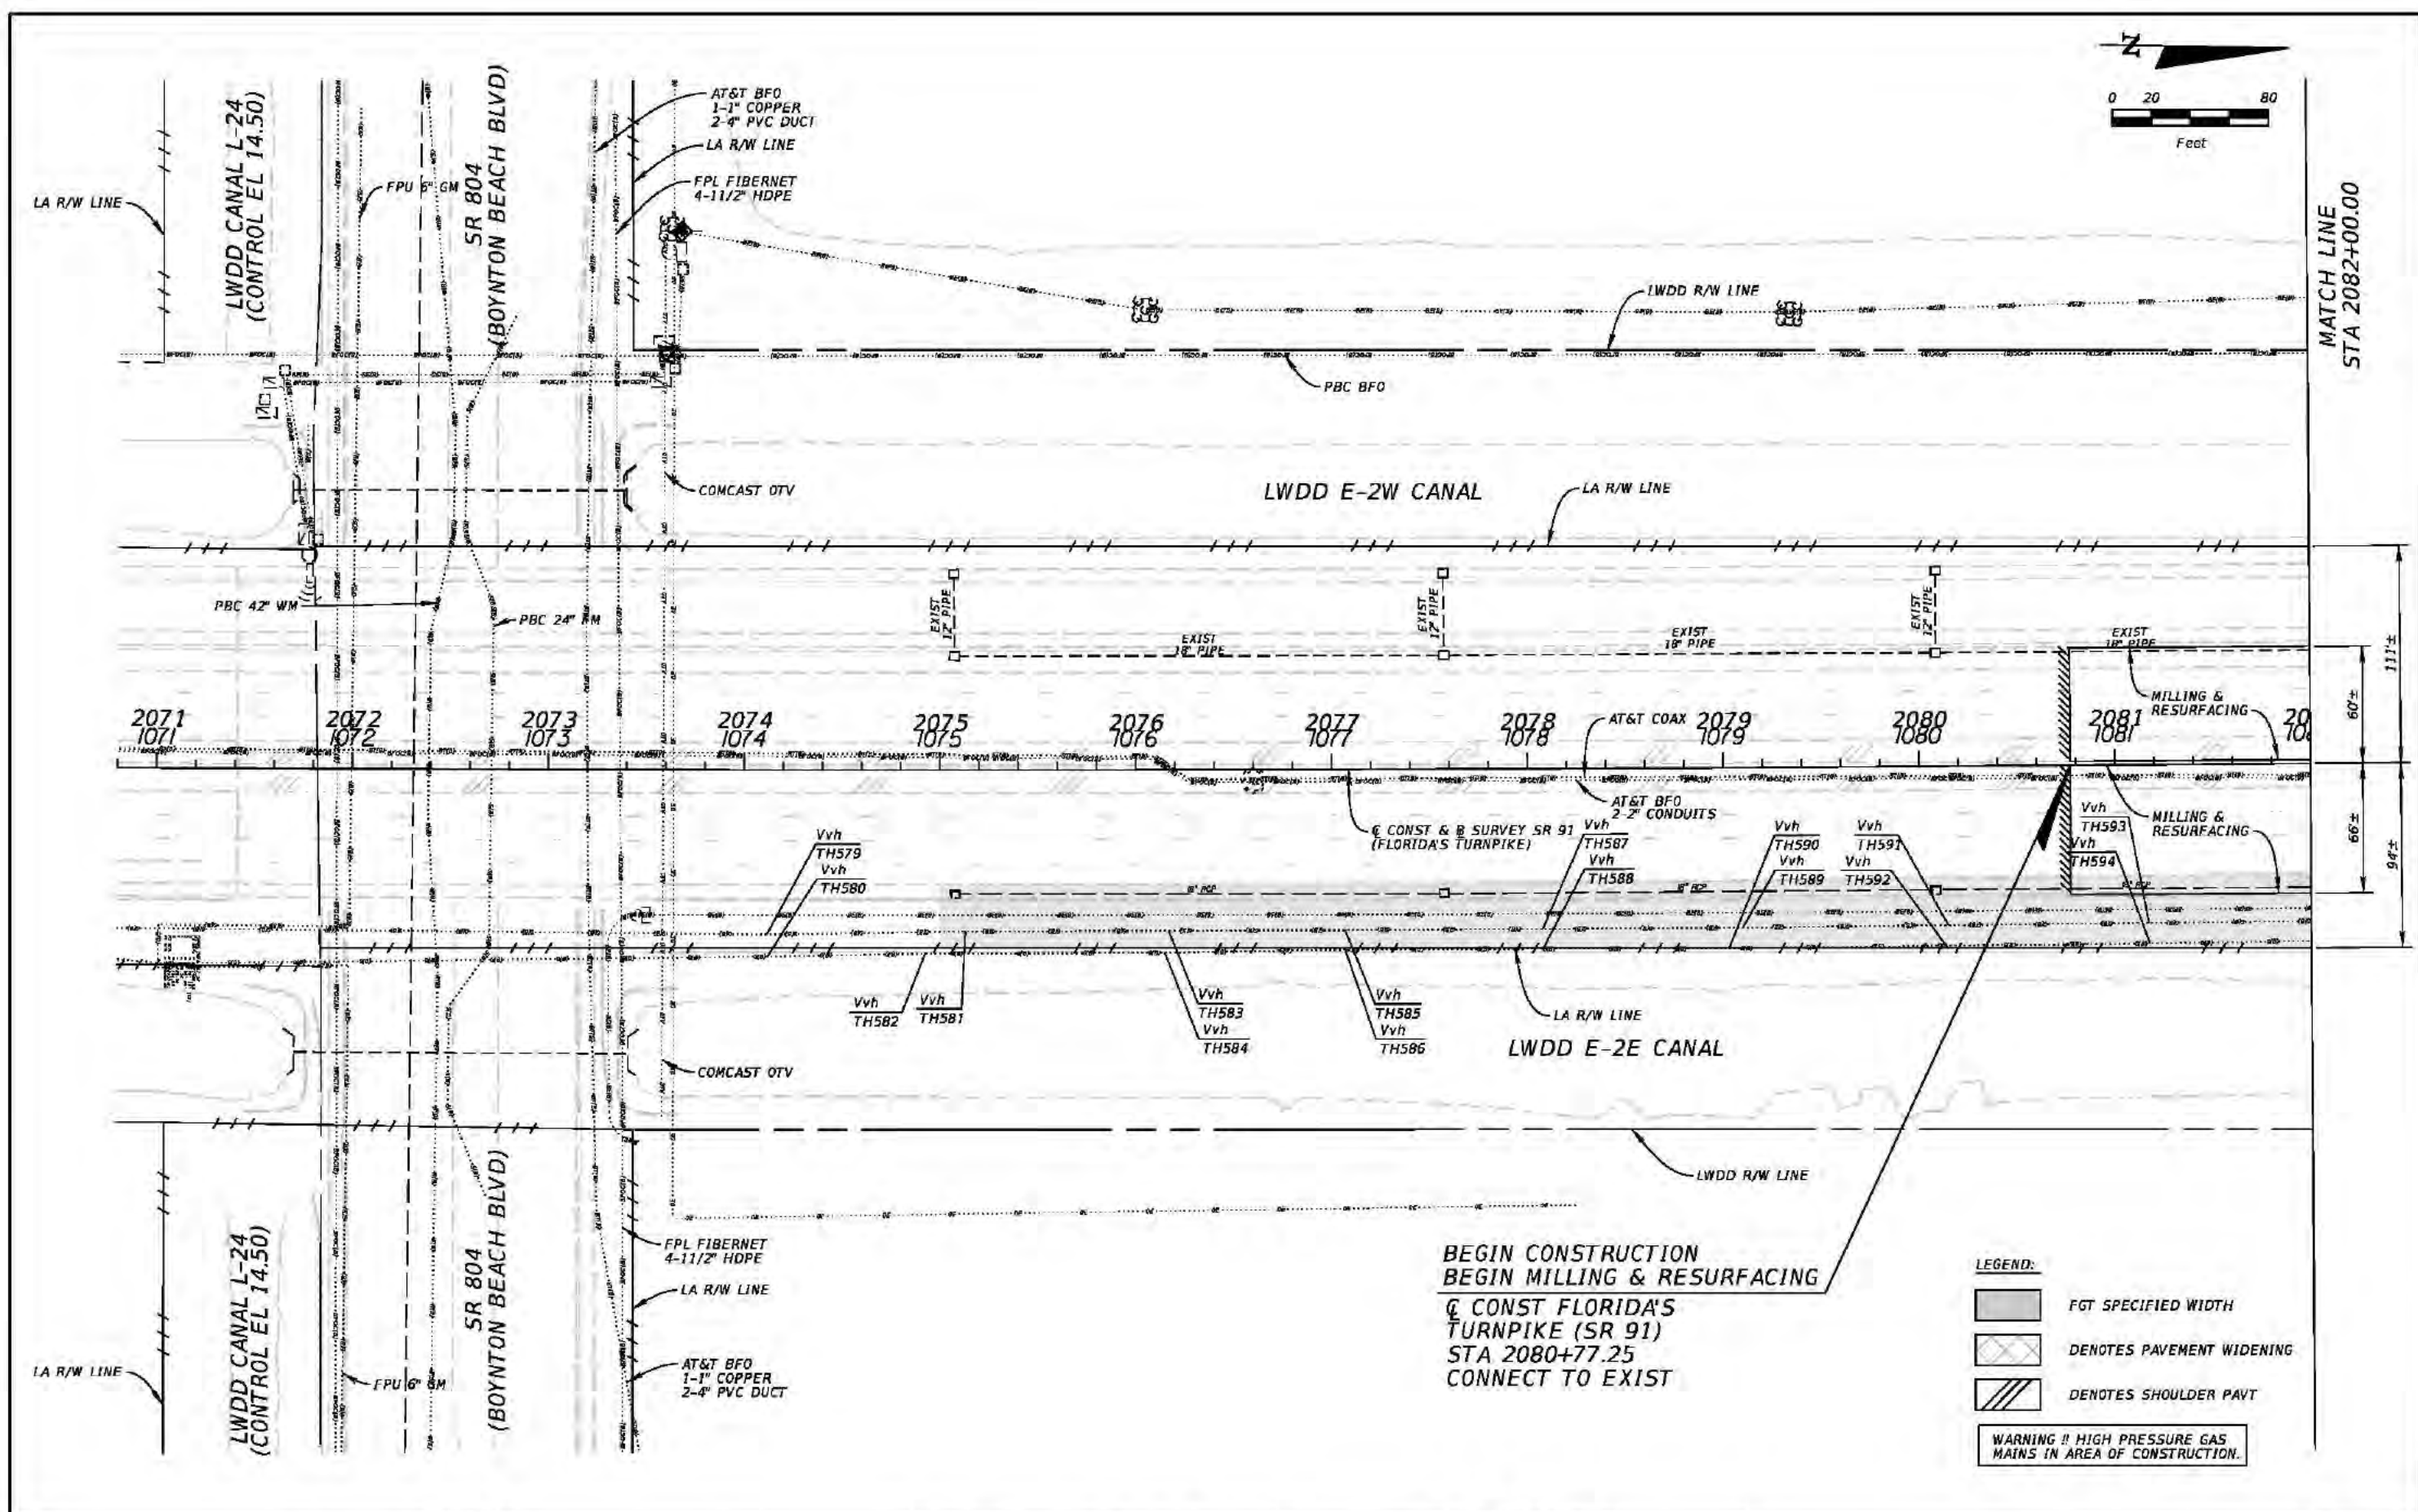


REVISIONS				Kimley-Horn and Associates, Inc. Certificate Of Authorization No. 696 Hool Gin Ng, P.E. P.E. License No. 58123 1920 Wekiva Way, Suite 200 West Palm Beach, Florida 33411	STATE OF FLORIDA			ROADWAY PLAN (00)	SHEET NO.
DATE	DESCRIPTION	DATE	DESCRIPTION		ROAD NO.	COUNTY	FINANCIAL PROJECT ID		
					SR 91	PALM BEACH	406144-1-52-01		
				2/3/2017 3:46:15 PM K:\WPB_Design\040195061_TPK_BB_to_LW\40614415201_Realign\roadway\plans\planrd01.dgn				55	

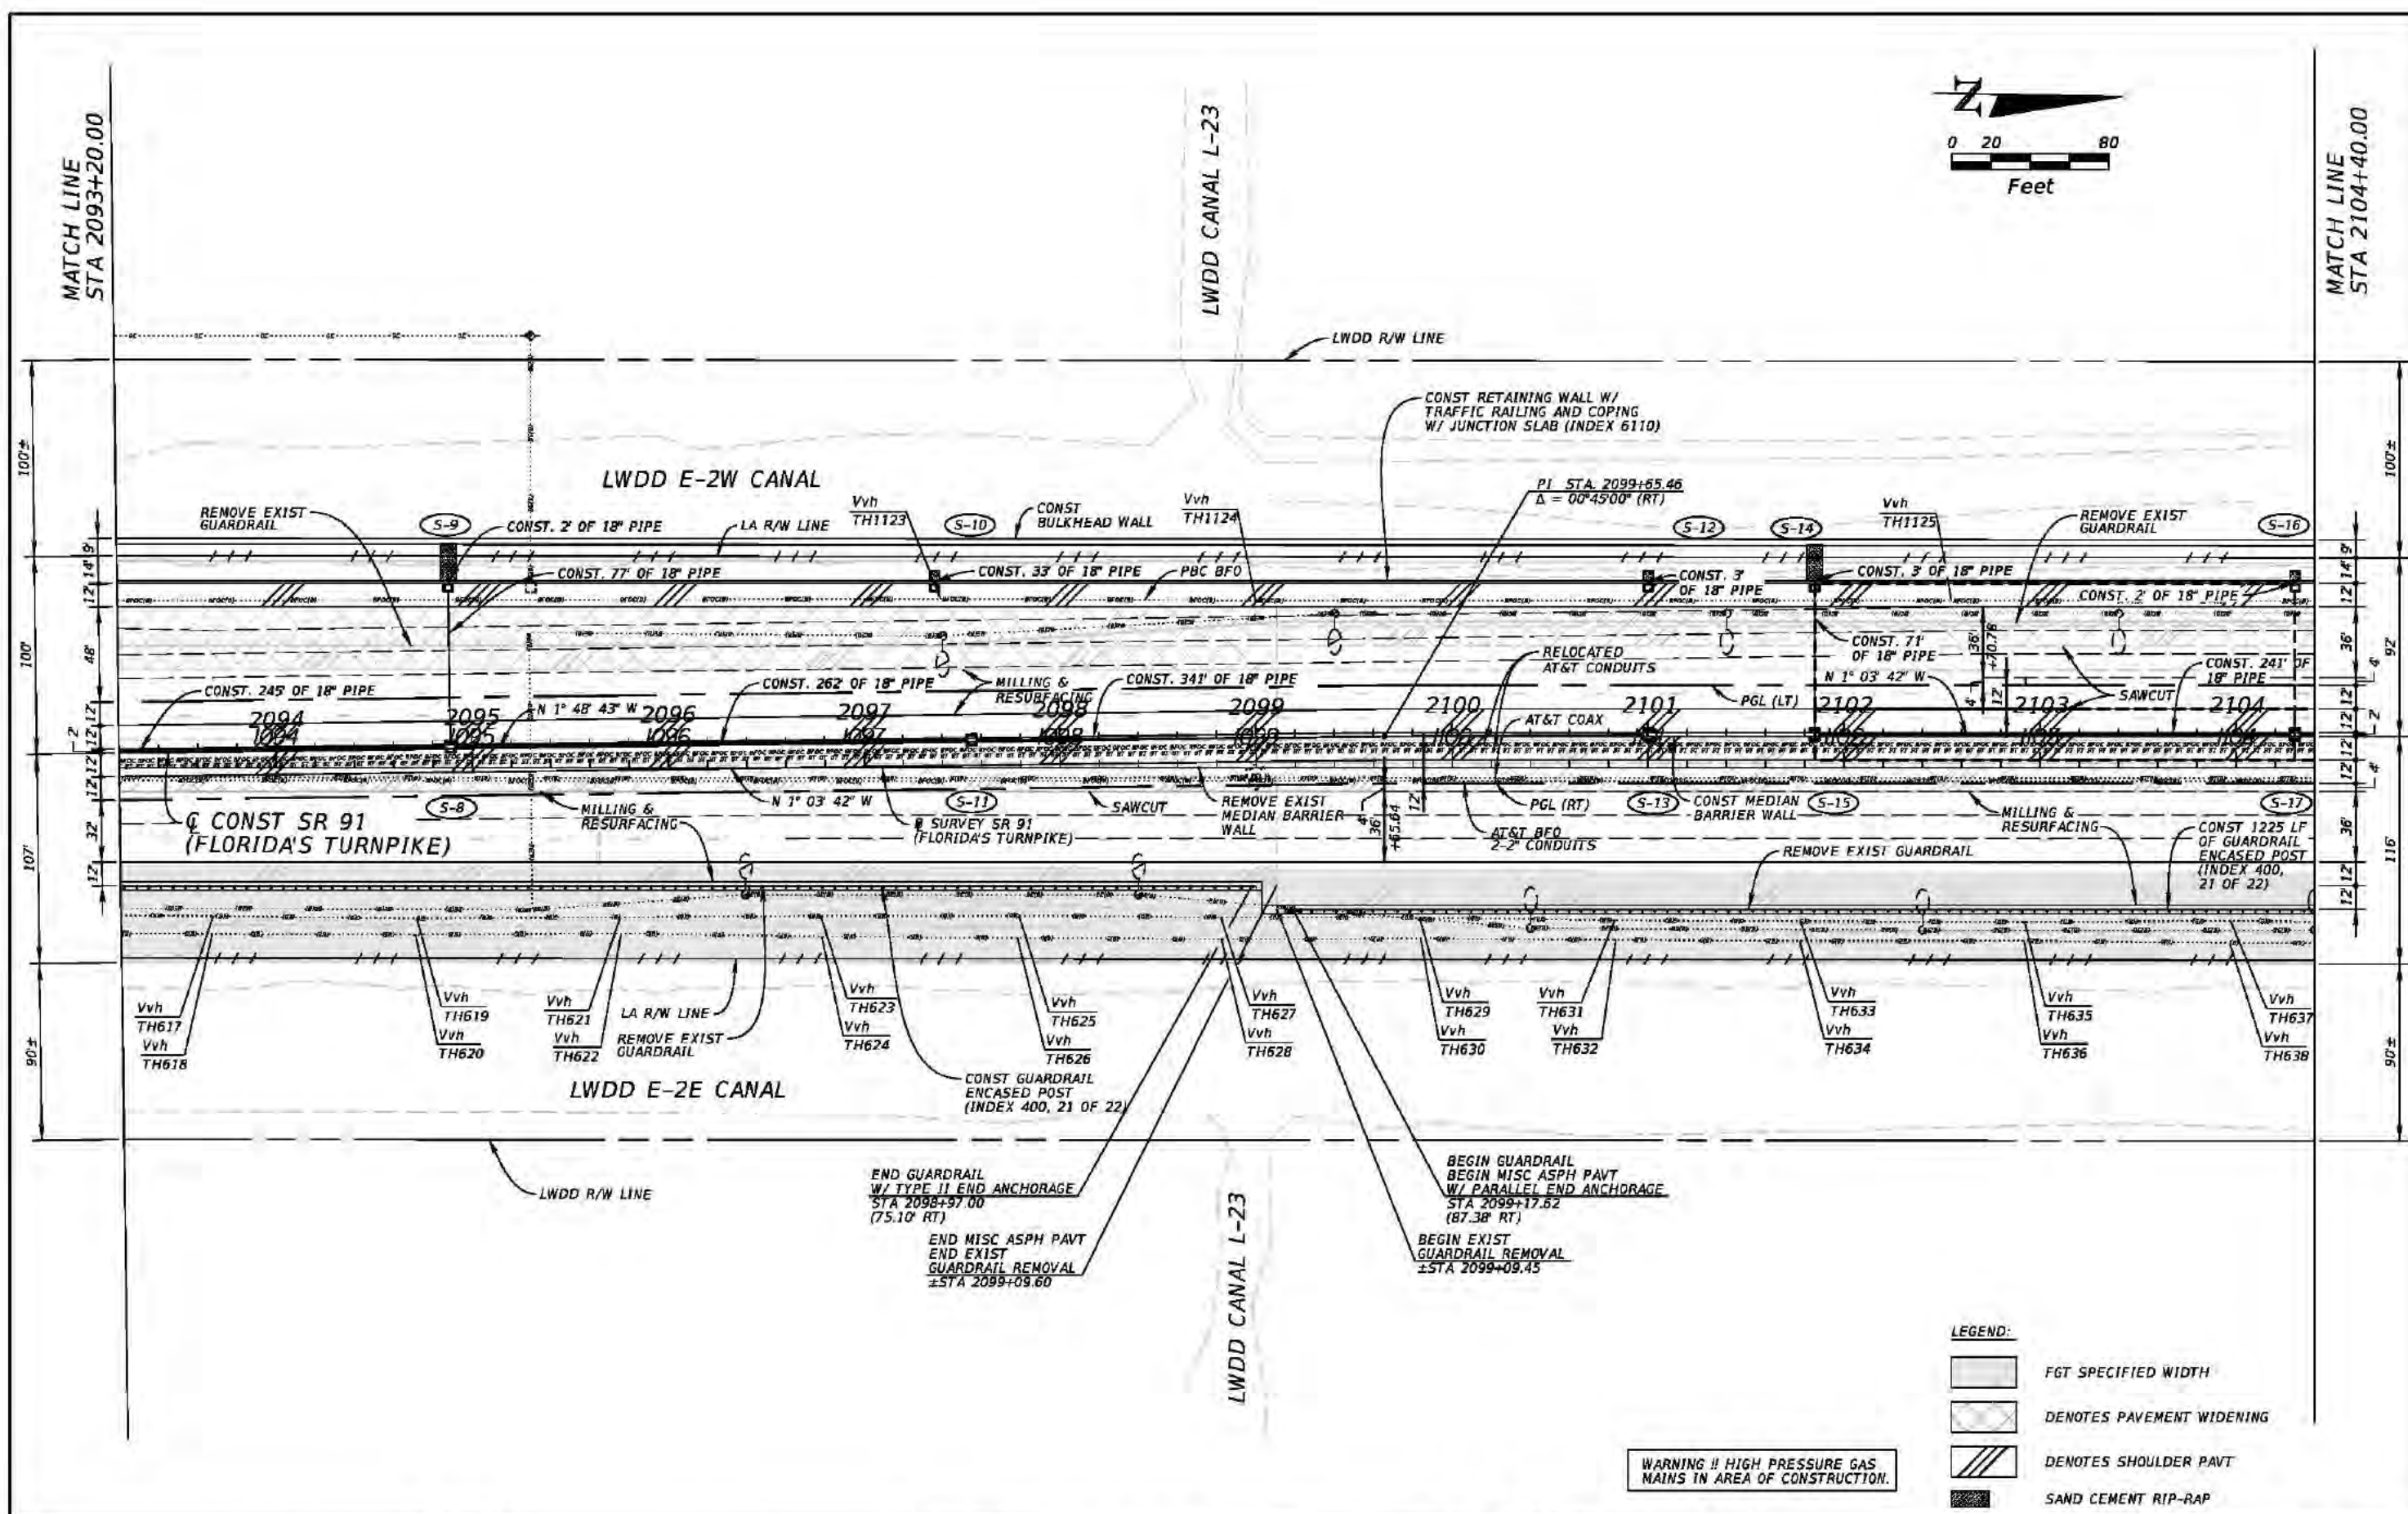

REVISIONS				Kimley-Horn and Associates, Inc. Certificate Of Authorization No. 696 Hool Gin Ng, P.E. P.E. License No. 58123 1920 Wekiva Way, Suite 200 West Palm Beach, Florida 33411	STATE OF FLORIDA DEPARTMENT OF TRANSPORTATION			ROADWAY PLAN (02)	SHEET NO. 57
DATE	DESCRIPTION	DATE	DESCRIPTION		ROAD NO.	COUNTY	FINANCIAL PROJECT ID		
					SR 91	PALM BEACH	406144-1-52-01		

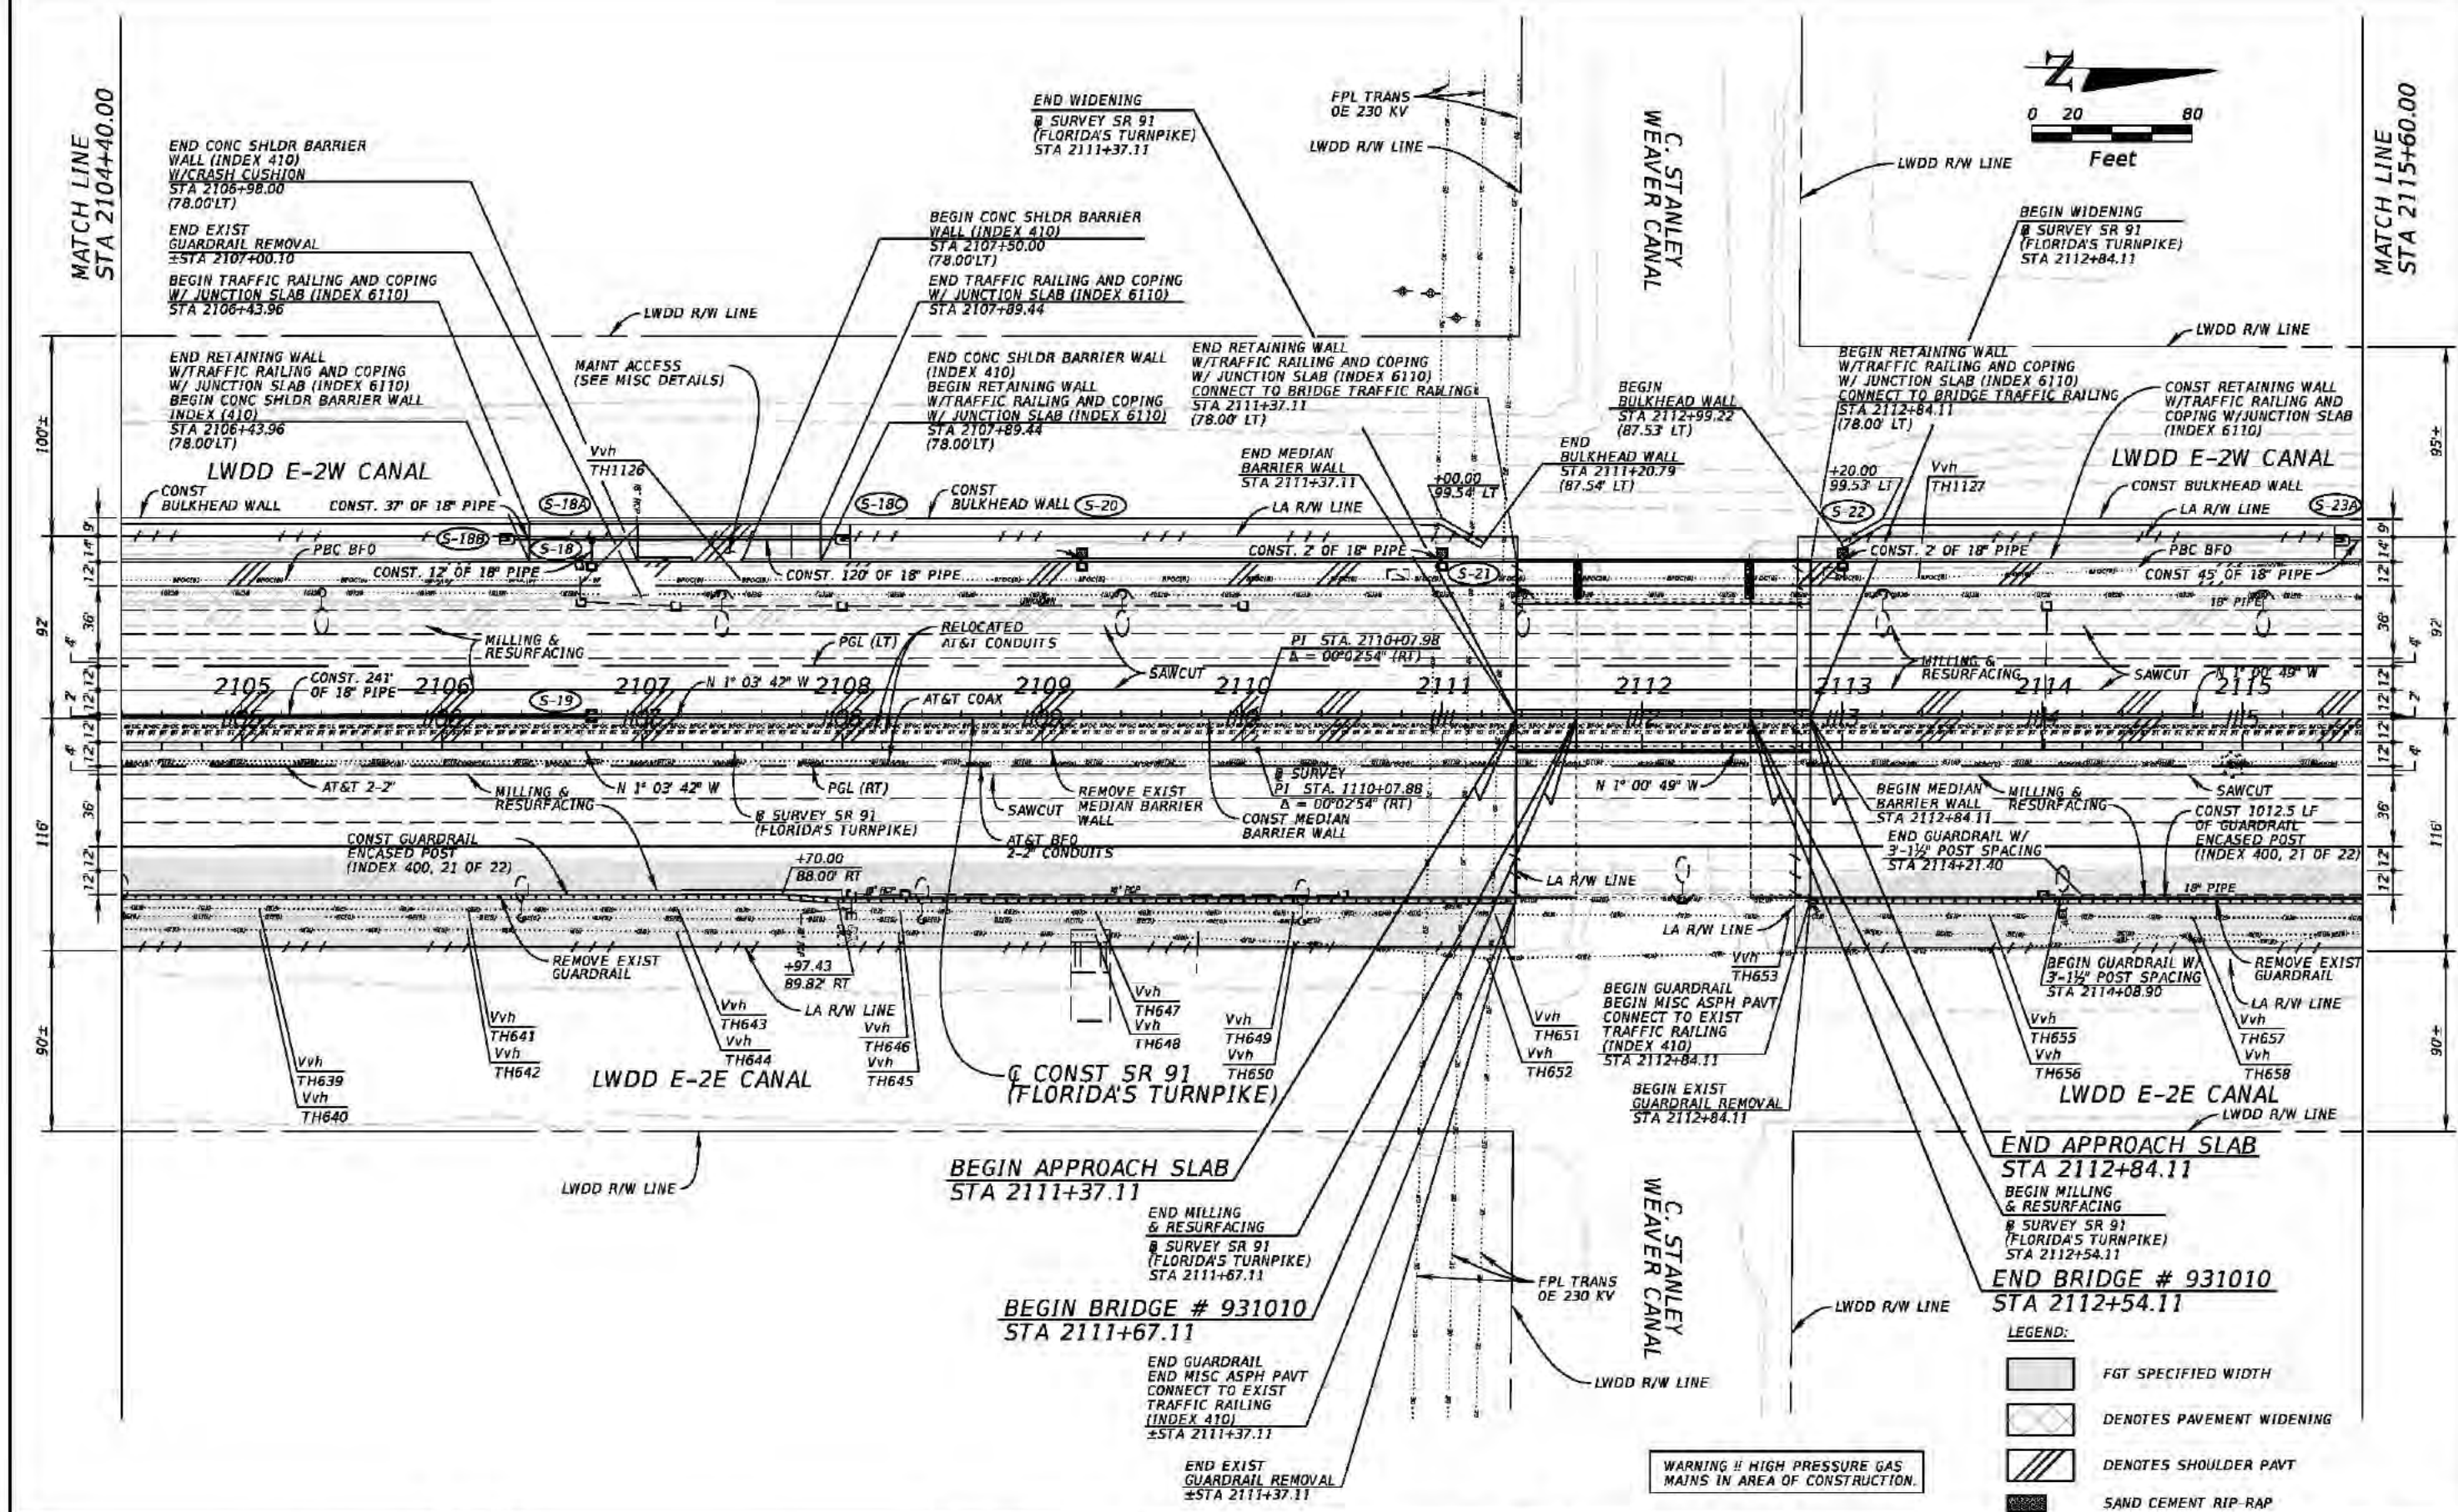

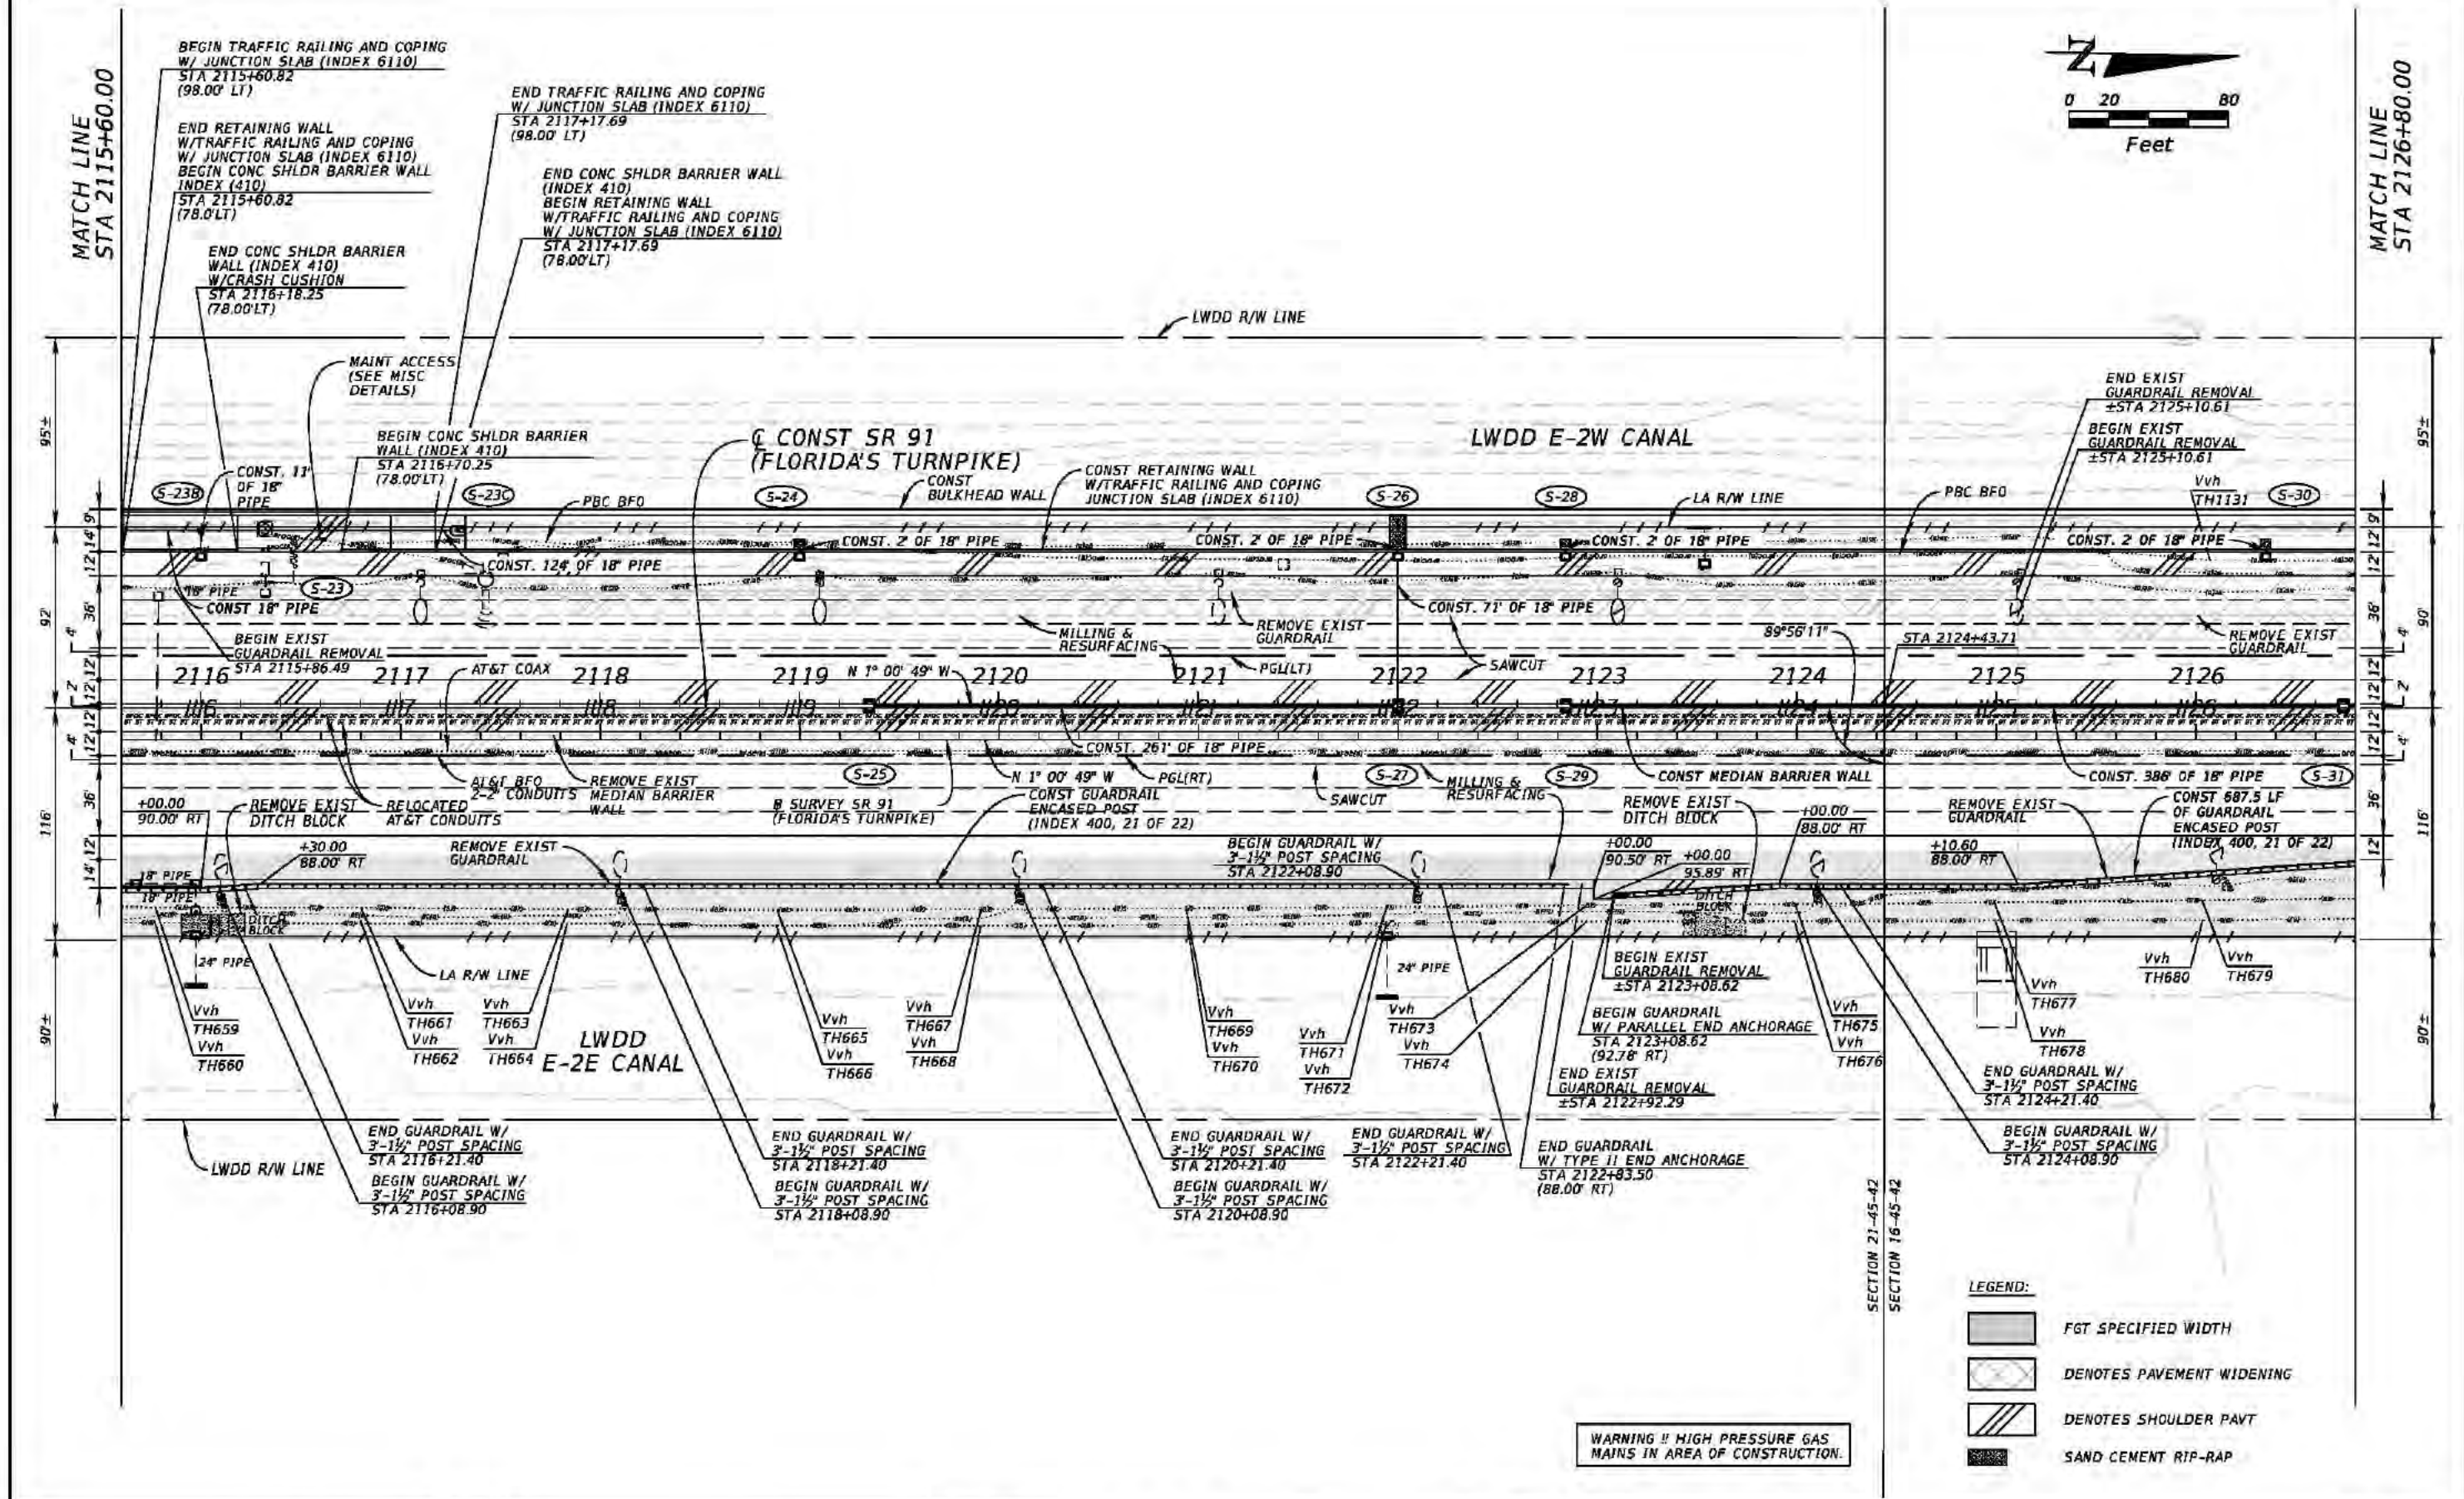


- LEGEND:**
- FGT SPECIFIED WIDTH
 - DENOTES PAVEMENT WIDENING
 - DENOTES SHOULDER PAVT
 - SAND CEMENT RIP-RAP

WARNING !! HIGH PRESSURE GAS
MAINS IN AREA OF CONSTRUCTION.

REVISIONS				Kimley-Horn and Associates, Inc. Certificate Of Authorization No. 696 Hool Gin Ng, P.E. P.E. License No. 58123 1920 Wekiva Way, Suite 200 West Palm Beach, Florida 33411	STATE OF FLORIDA			ROADWAY PLAN (04)	SHEET NO. 59
DATE	DESCRIPTION	DATE	DESCRIPTION		ROAD NO.	COUNTY	FINANCIAL PROJECT ID		
					SR 91	PALM BEACH	406144-1-52-01		

MATCH LINE
STA 2126+80.00

MATCH LINE
STA 2138+00.00

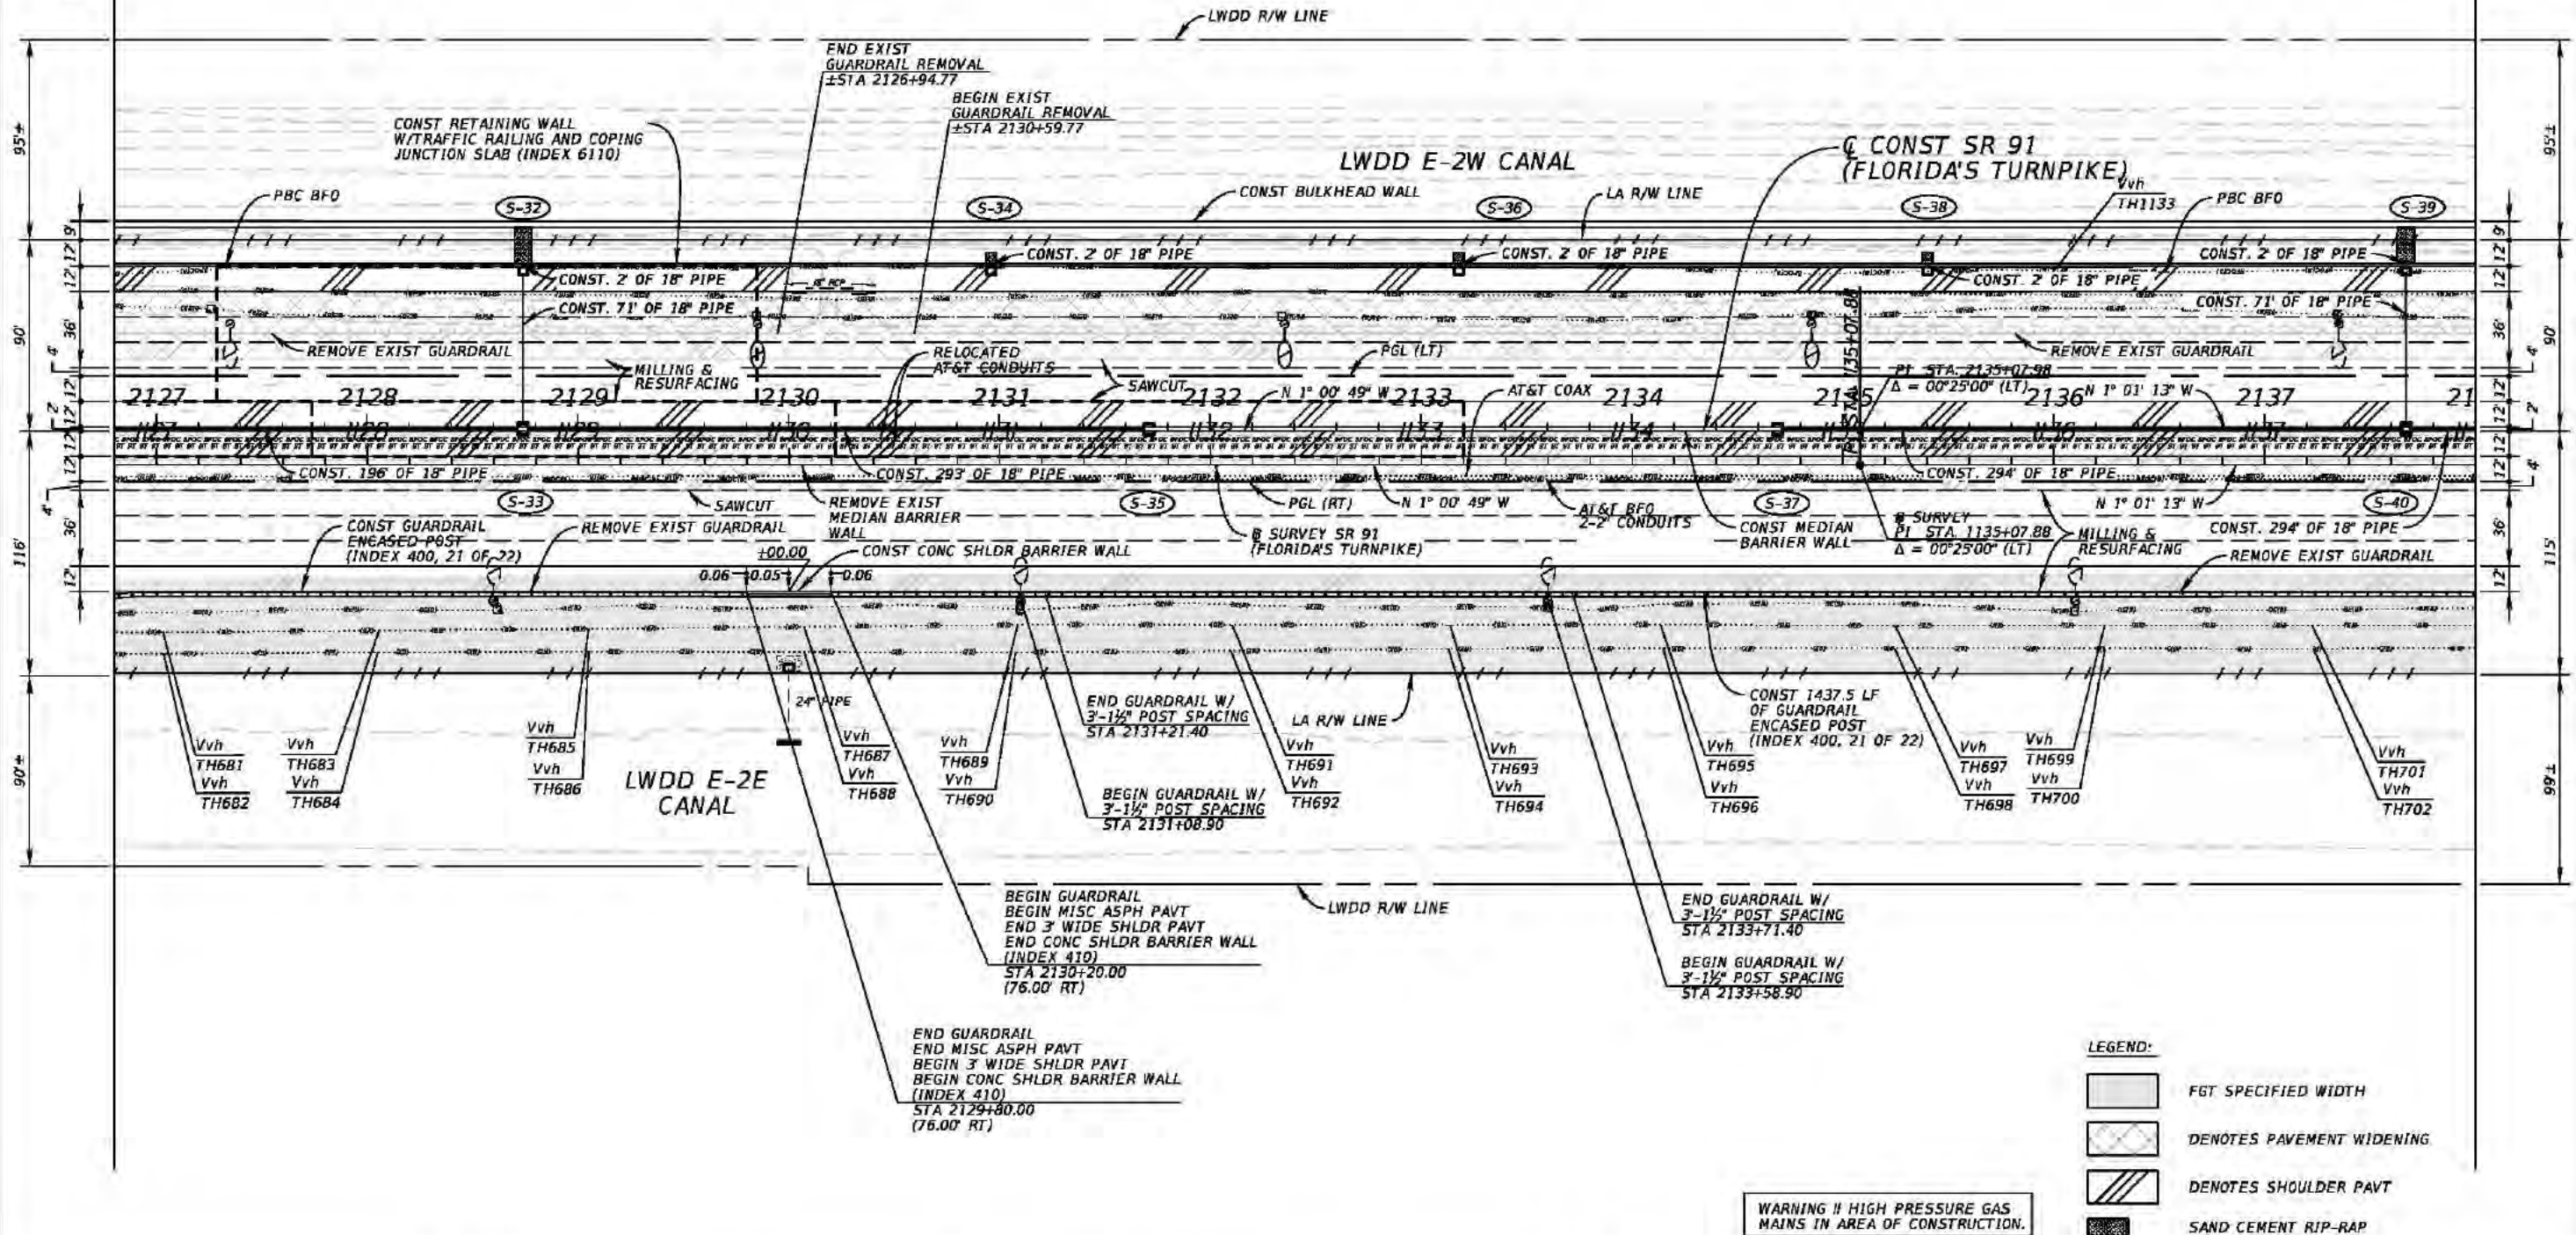


LEGEND:



- FGT SPECIFIED WIDTH
- DENOTES PAVEMENT WIDENING
- DENOTES SHOULDER PAVT
- SAND CEMENT RIP-RAP

WARNING !! HIGH PRESSURE GAS
MAINS IN AREA OF CONSTRUCTION.


REVISIONS				Kimley-Horn and Associates, Inc. Certificate Of Authorization No. 696 Hool Gin Ng, P.E. P.E. License No. 58123 1920 Wekiva Way, Suite 200 West Palm Beach, Florida 33411	STATE OF FLORIDA DEPARTMENT OF TRANSPORTATION			ROADWAY PLAN (05)	SHEET NO. 60
DATE	DESCRIPTION	DATE	DESCRIPTION		ROAD NO.	COUNTY	FINANCIAL PROJECT ID		
					SR 91	PALM BEACH	406144-1-52-01		

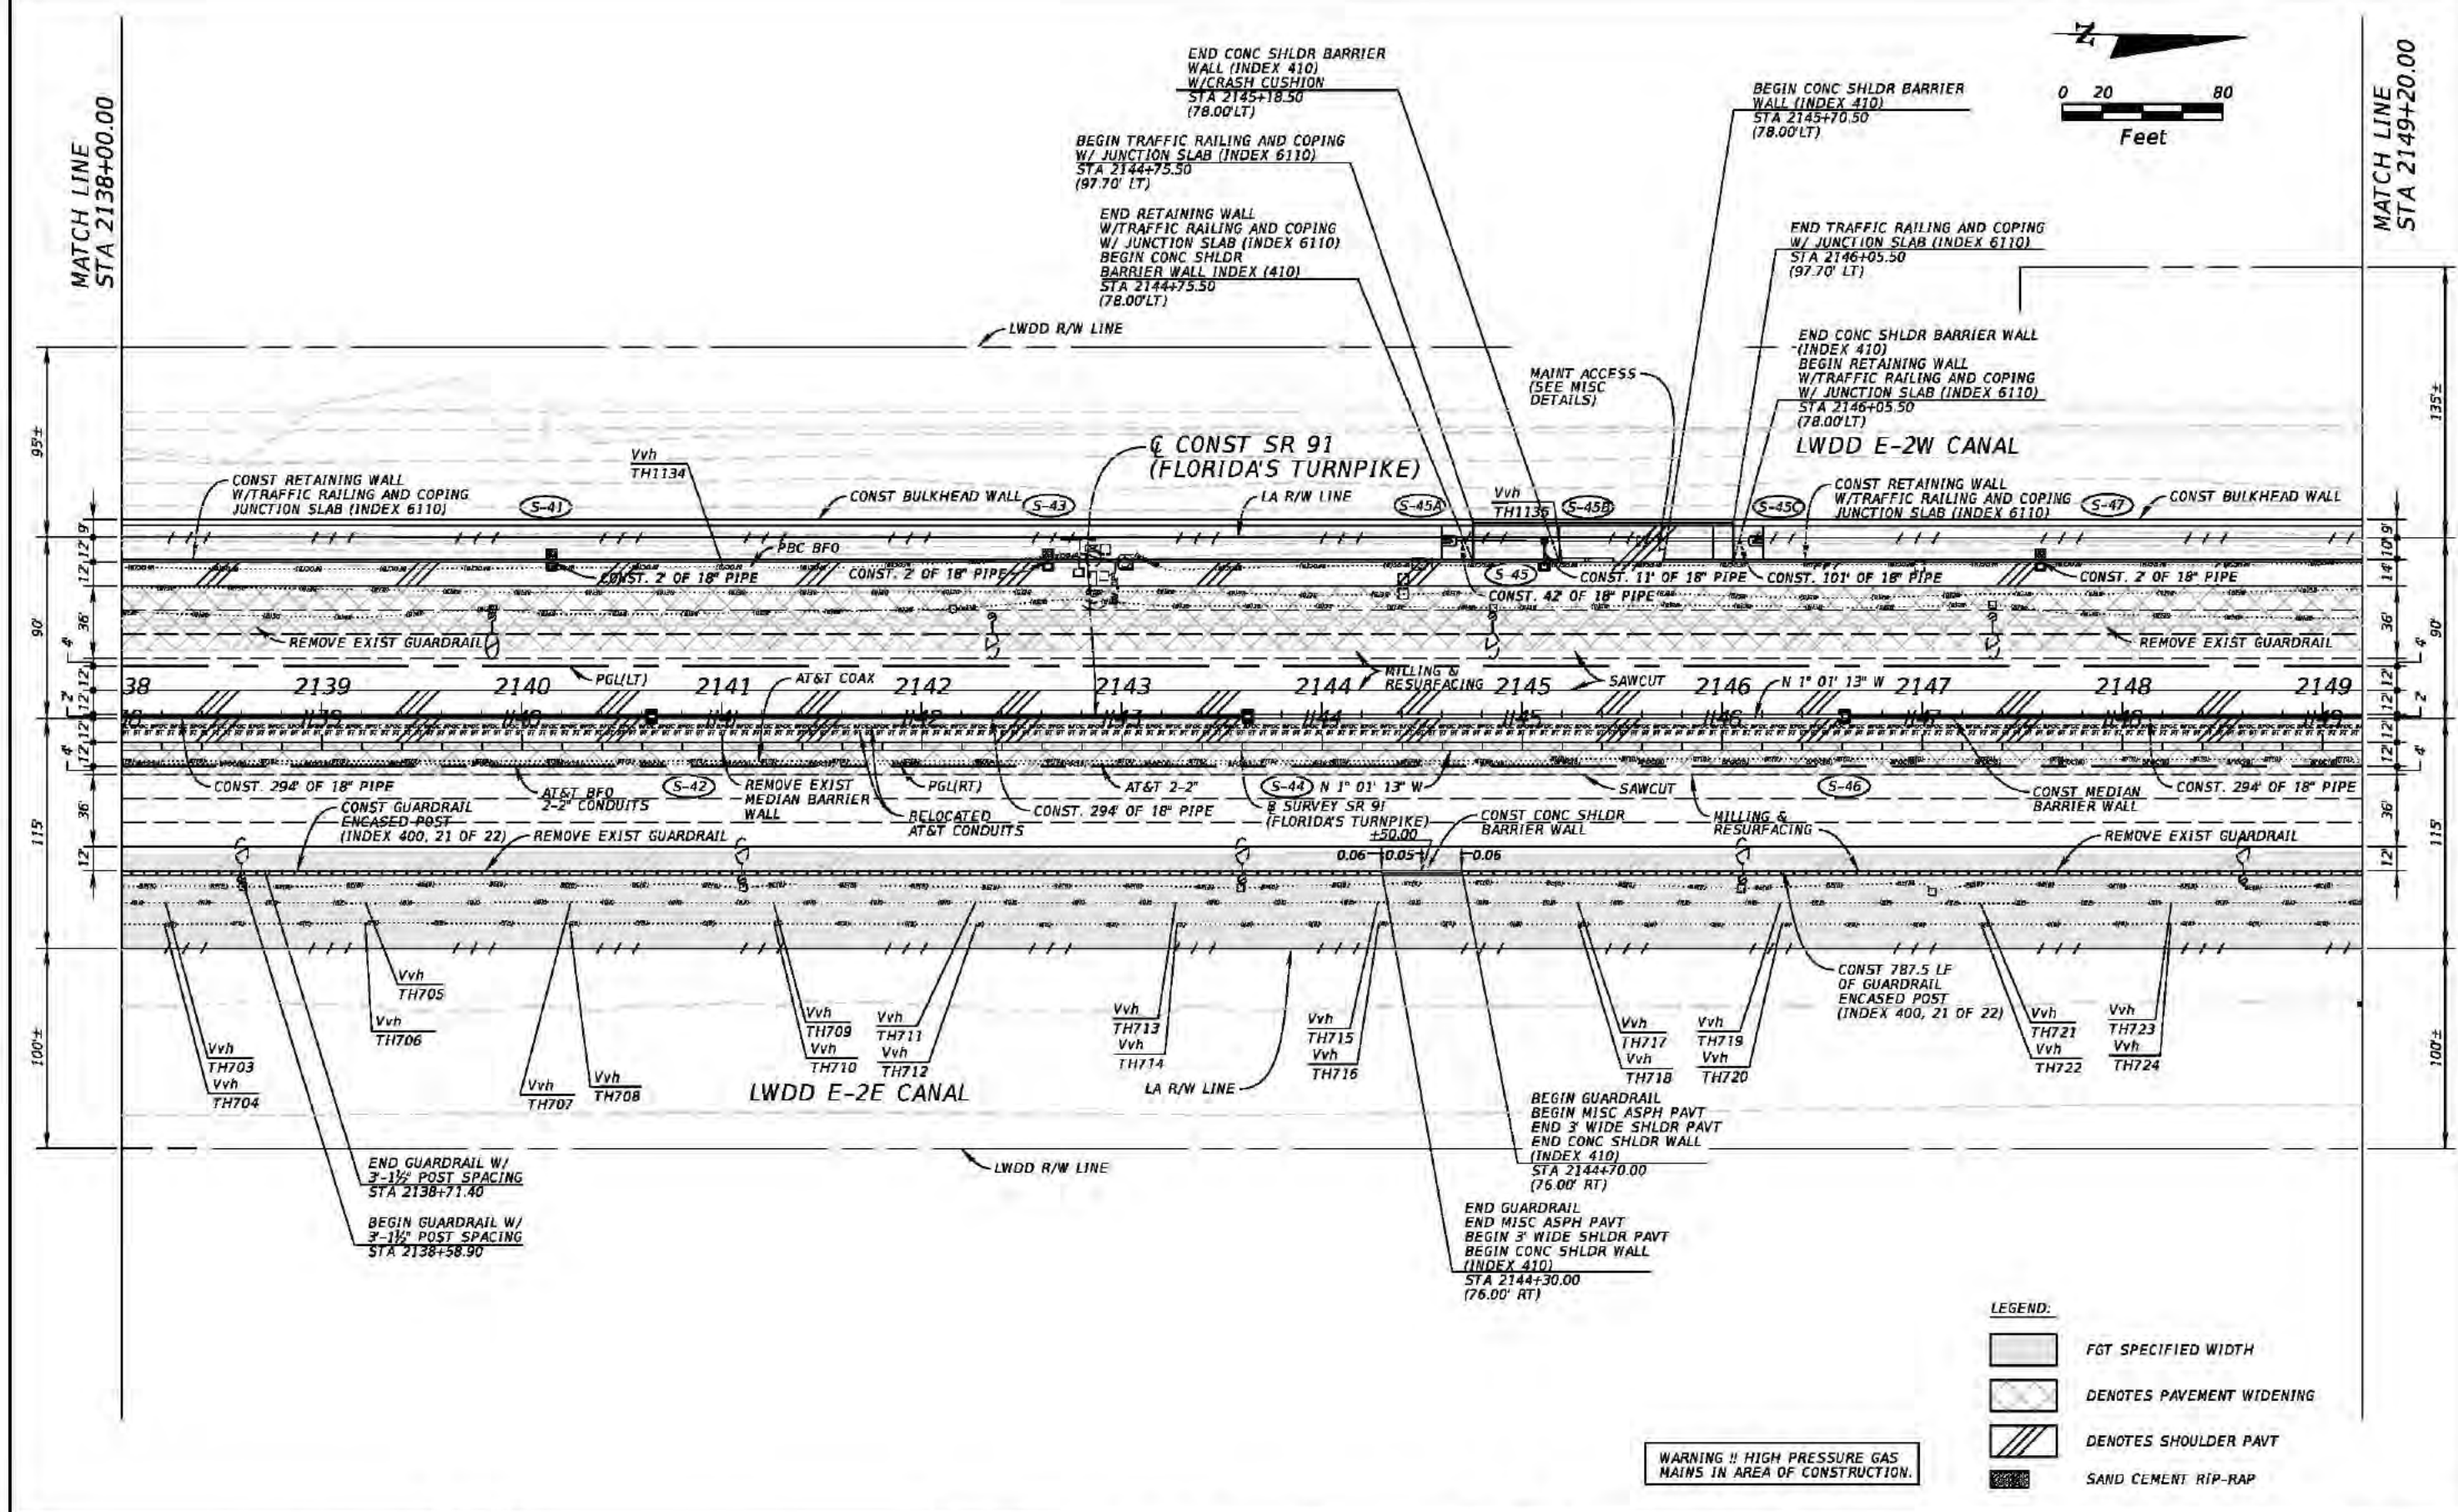

REVISIONS				Kimley-Horn and Associates, Inc. Certificate Of Authorization No. 696 Hool Gin Ng, P.E. P.E. License No. 58123 1920 Wekiva Way, Suite 200 West Palm Beach, Florida 33411	STATE OF FLORIDA			ROADWAY PLAN (06) SHEET NO. 61
DATE	DESCRIPTION	DATE	DESCRIPTION		ROAD NO.	COUNTY	FINANCIAL PROJECT ID	
					SR 91	PALM BEACH	406144-1-52-01	

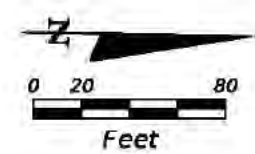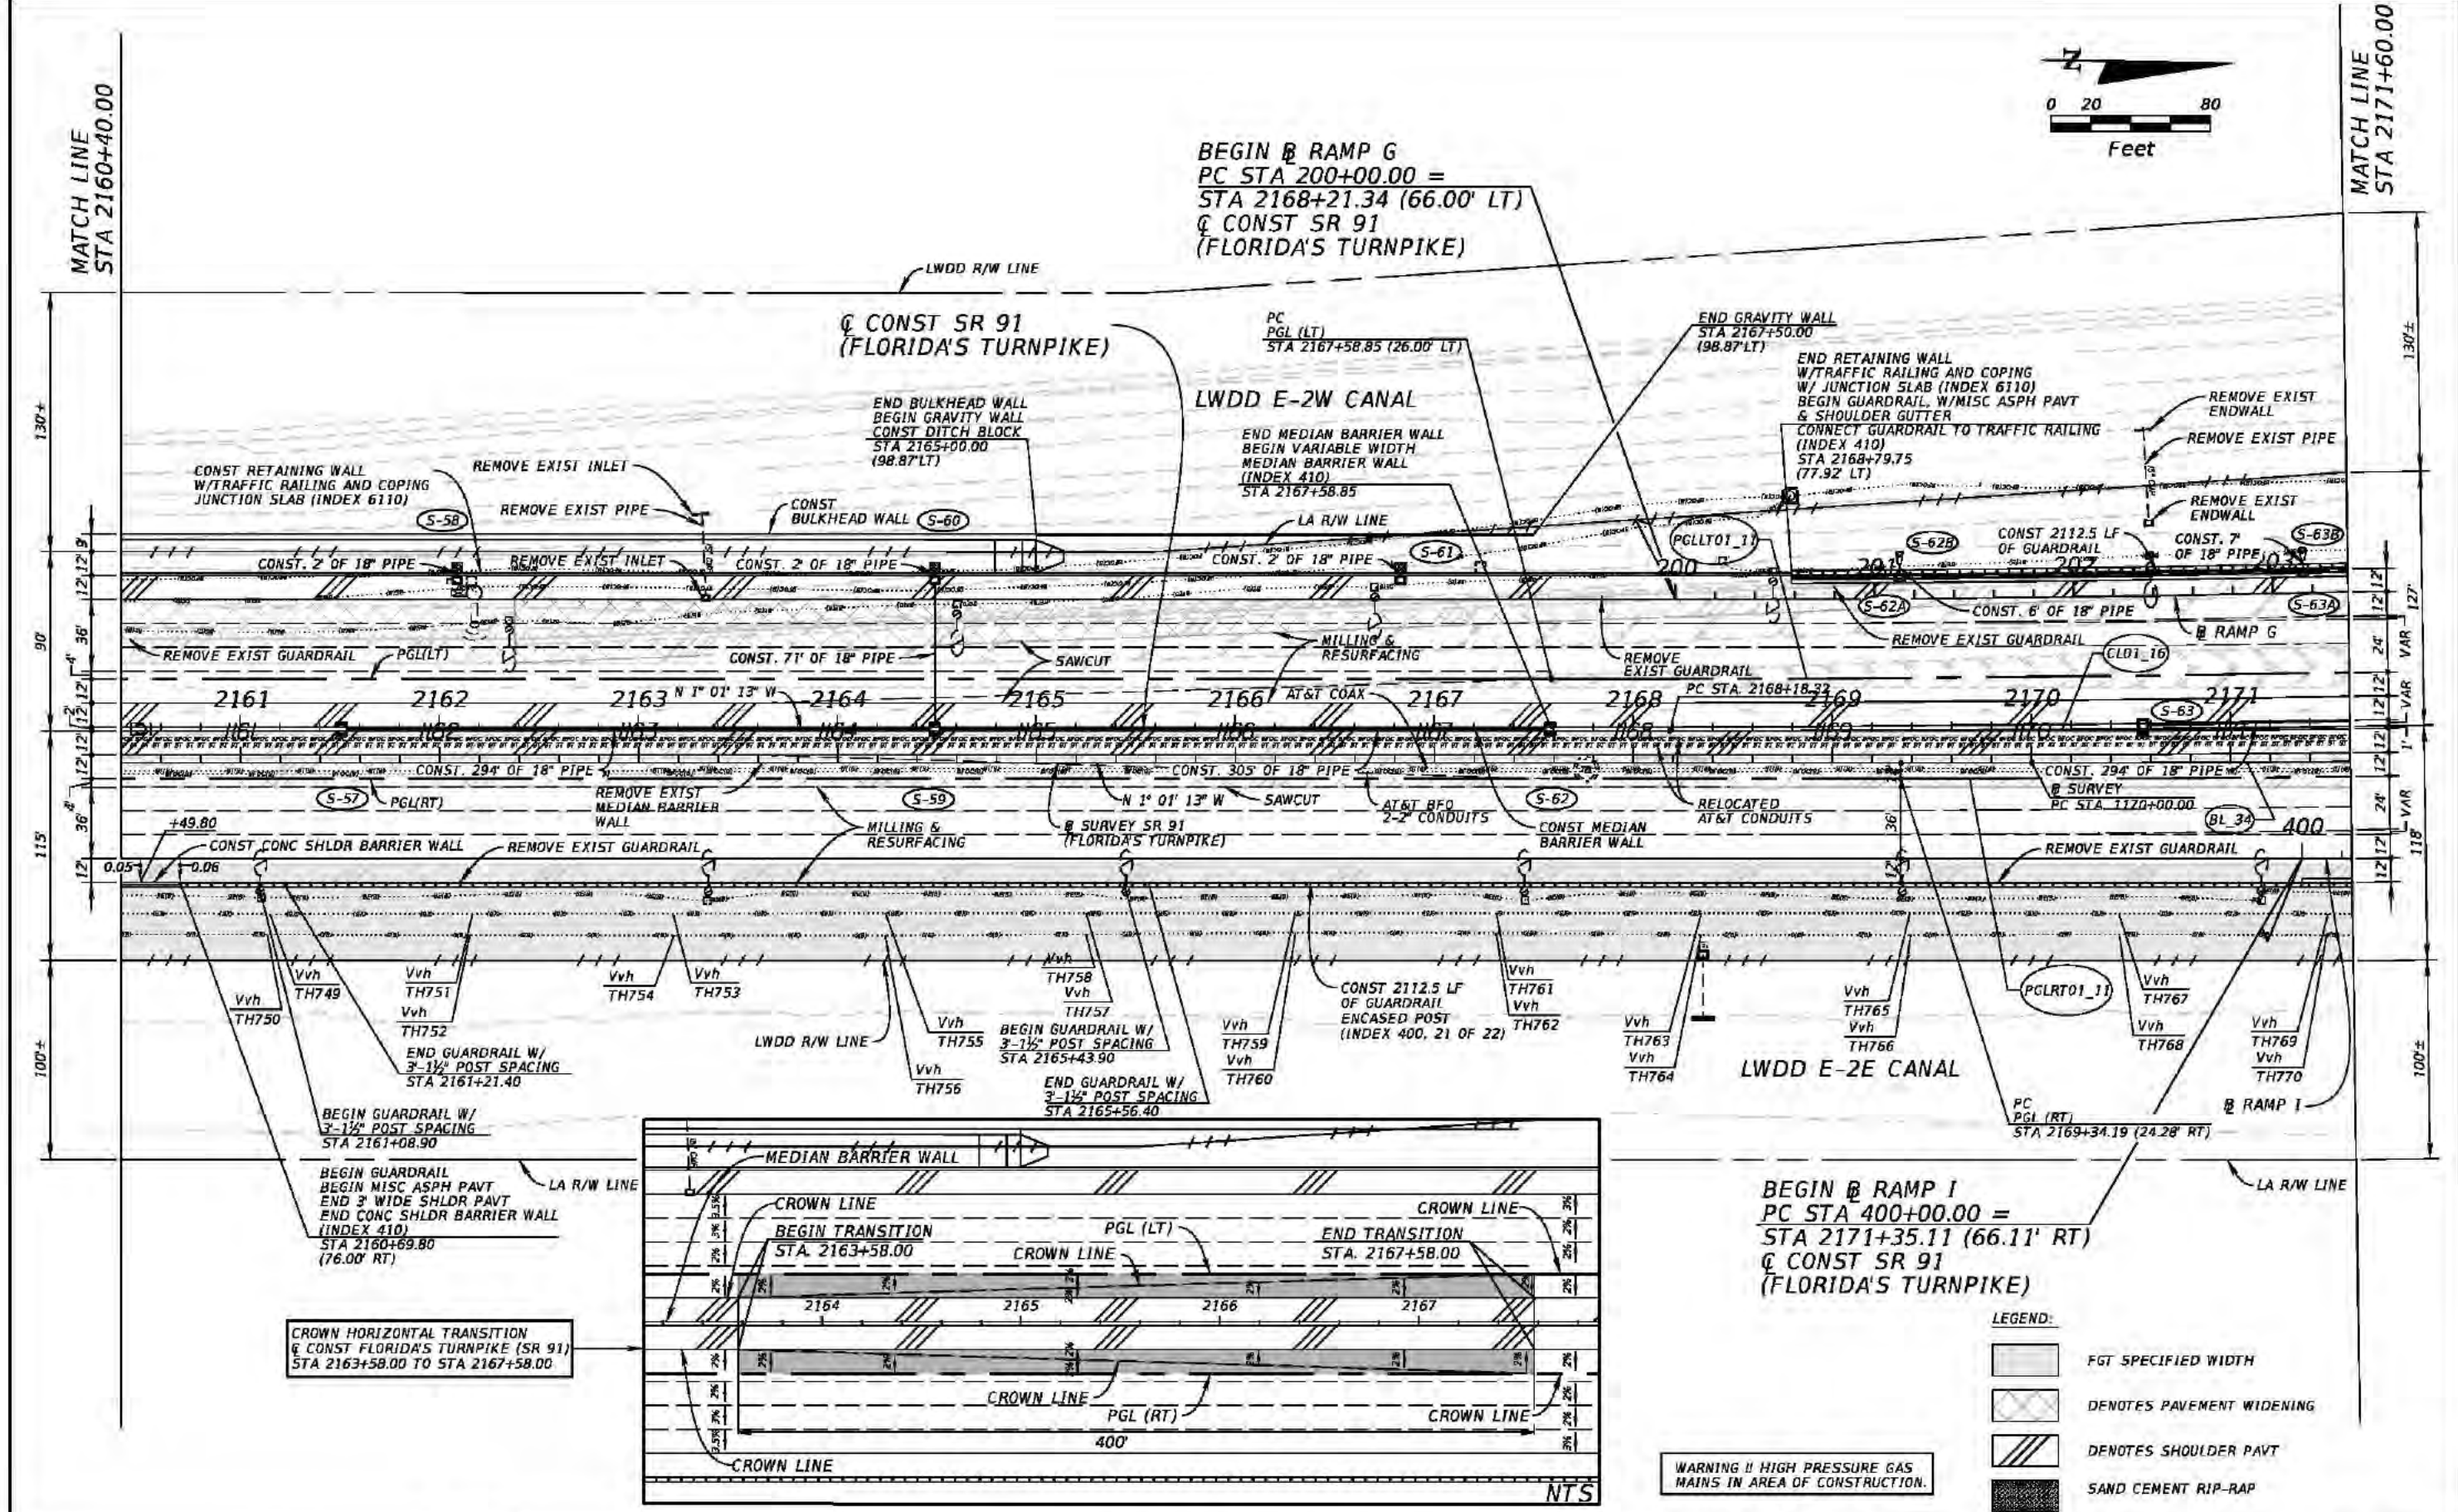


CROWN HORIZONTAL TRANSITION
OF CONST FLORIDA'S TURNPIKE (SR 91)
STA 2163+58.00 TO STA 2167+58.00

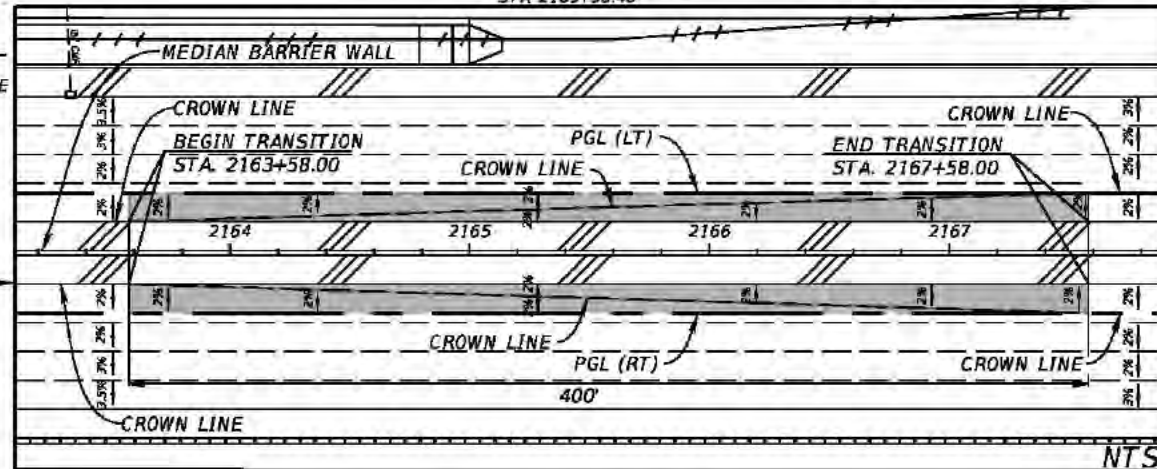

WARNING !! HIGH PRESSURE GAS
MAINS IN AREA OF CONSTRUCTION.


- LEGEND:
- [Pattern] FGT SPECIFIED WIDTH
 - [Pattern] DENOTES PAVEMENT WIDENING
 - [Pattern] DENOTES SHOULDER PAVT
 - [Pattern] SAND CEMENT RIP-RAP

REVISIONS				Kimley-Horn and Associates, Inc. Certificate Of Authorization No. 696 Hool Gin Ng, P.E. P.E. License No. 58123 1920 Wekiva Way, Suite 200 West Palm Beach, Florida 33411	STATE OF FLORIDA DEPARTMENT OF TRANSPORTATION			ROADWAY PLAN (08)	SHEET NO.
DATE	DESCRIPTION	DATE	DESCRIPTION		ROAD NO.	COUNTY	FINANCIAL PROJECT ID		
					SR 91	PALM BEACH	406144-1-52-01		63

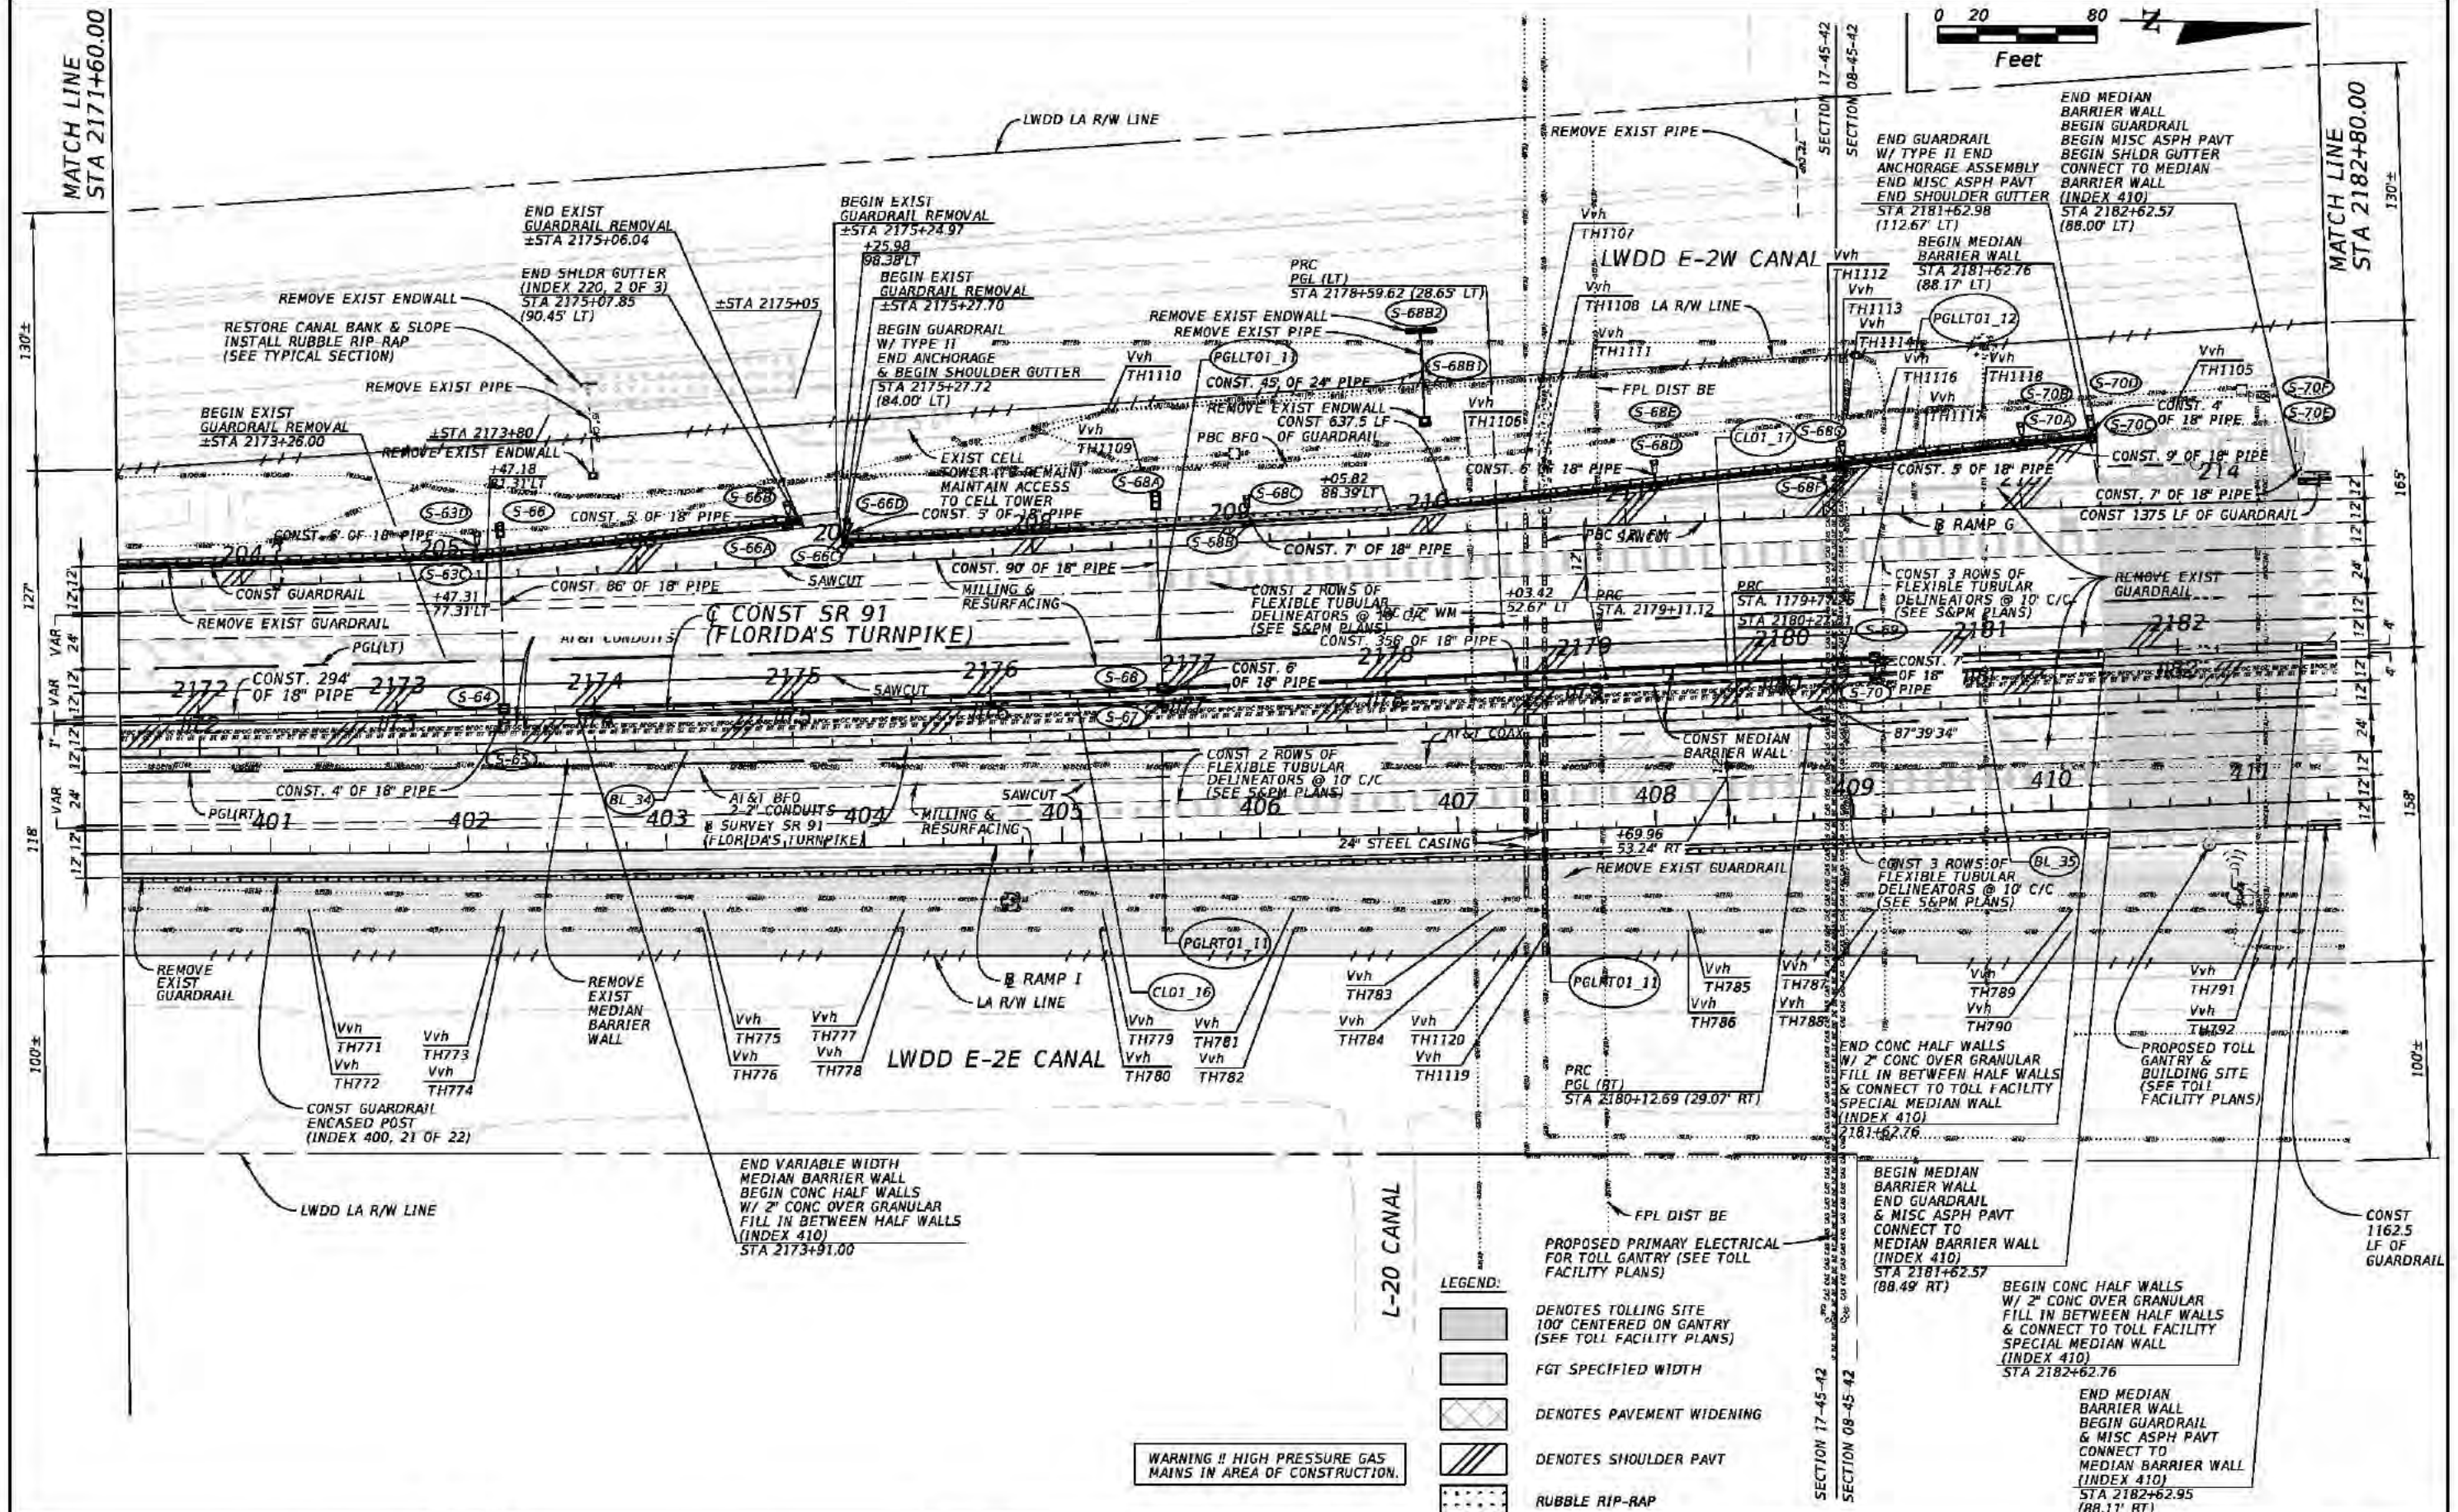


REVISIONS				Kimley-Horn and Associates, Inc. Certificate Of Authorization No. 696 Hool Gin Ng, P.E. P.E. License No. 58123 1920 Wekiva Way, Suite 200 West Palm Beach, Florida 33411	STATE OF FLORIDA DEPARTMENT OF TRANSPORTATION			ROADWAY PLAN (09)	SHEET NO. 64
DATE	DESCRIPTION	DATE	DESCRIPTION		ROAD NO.	COUNTY	FINANCIAL PROJECT ID		
					SR 91	PALM BEACH	406144-1-52-01		


Rob Conklin 2/3/2017 3:46:59 PM K:\WPB Design\040195061 TPK BB to LW\40614415201 Realign\roadway\plans\planrd10.dgn

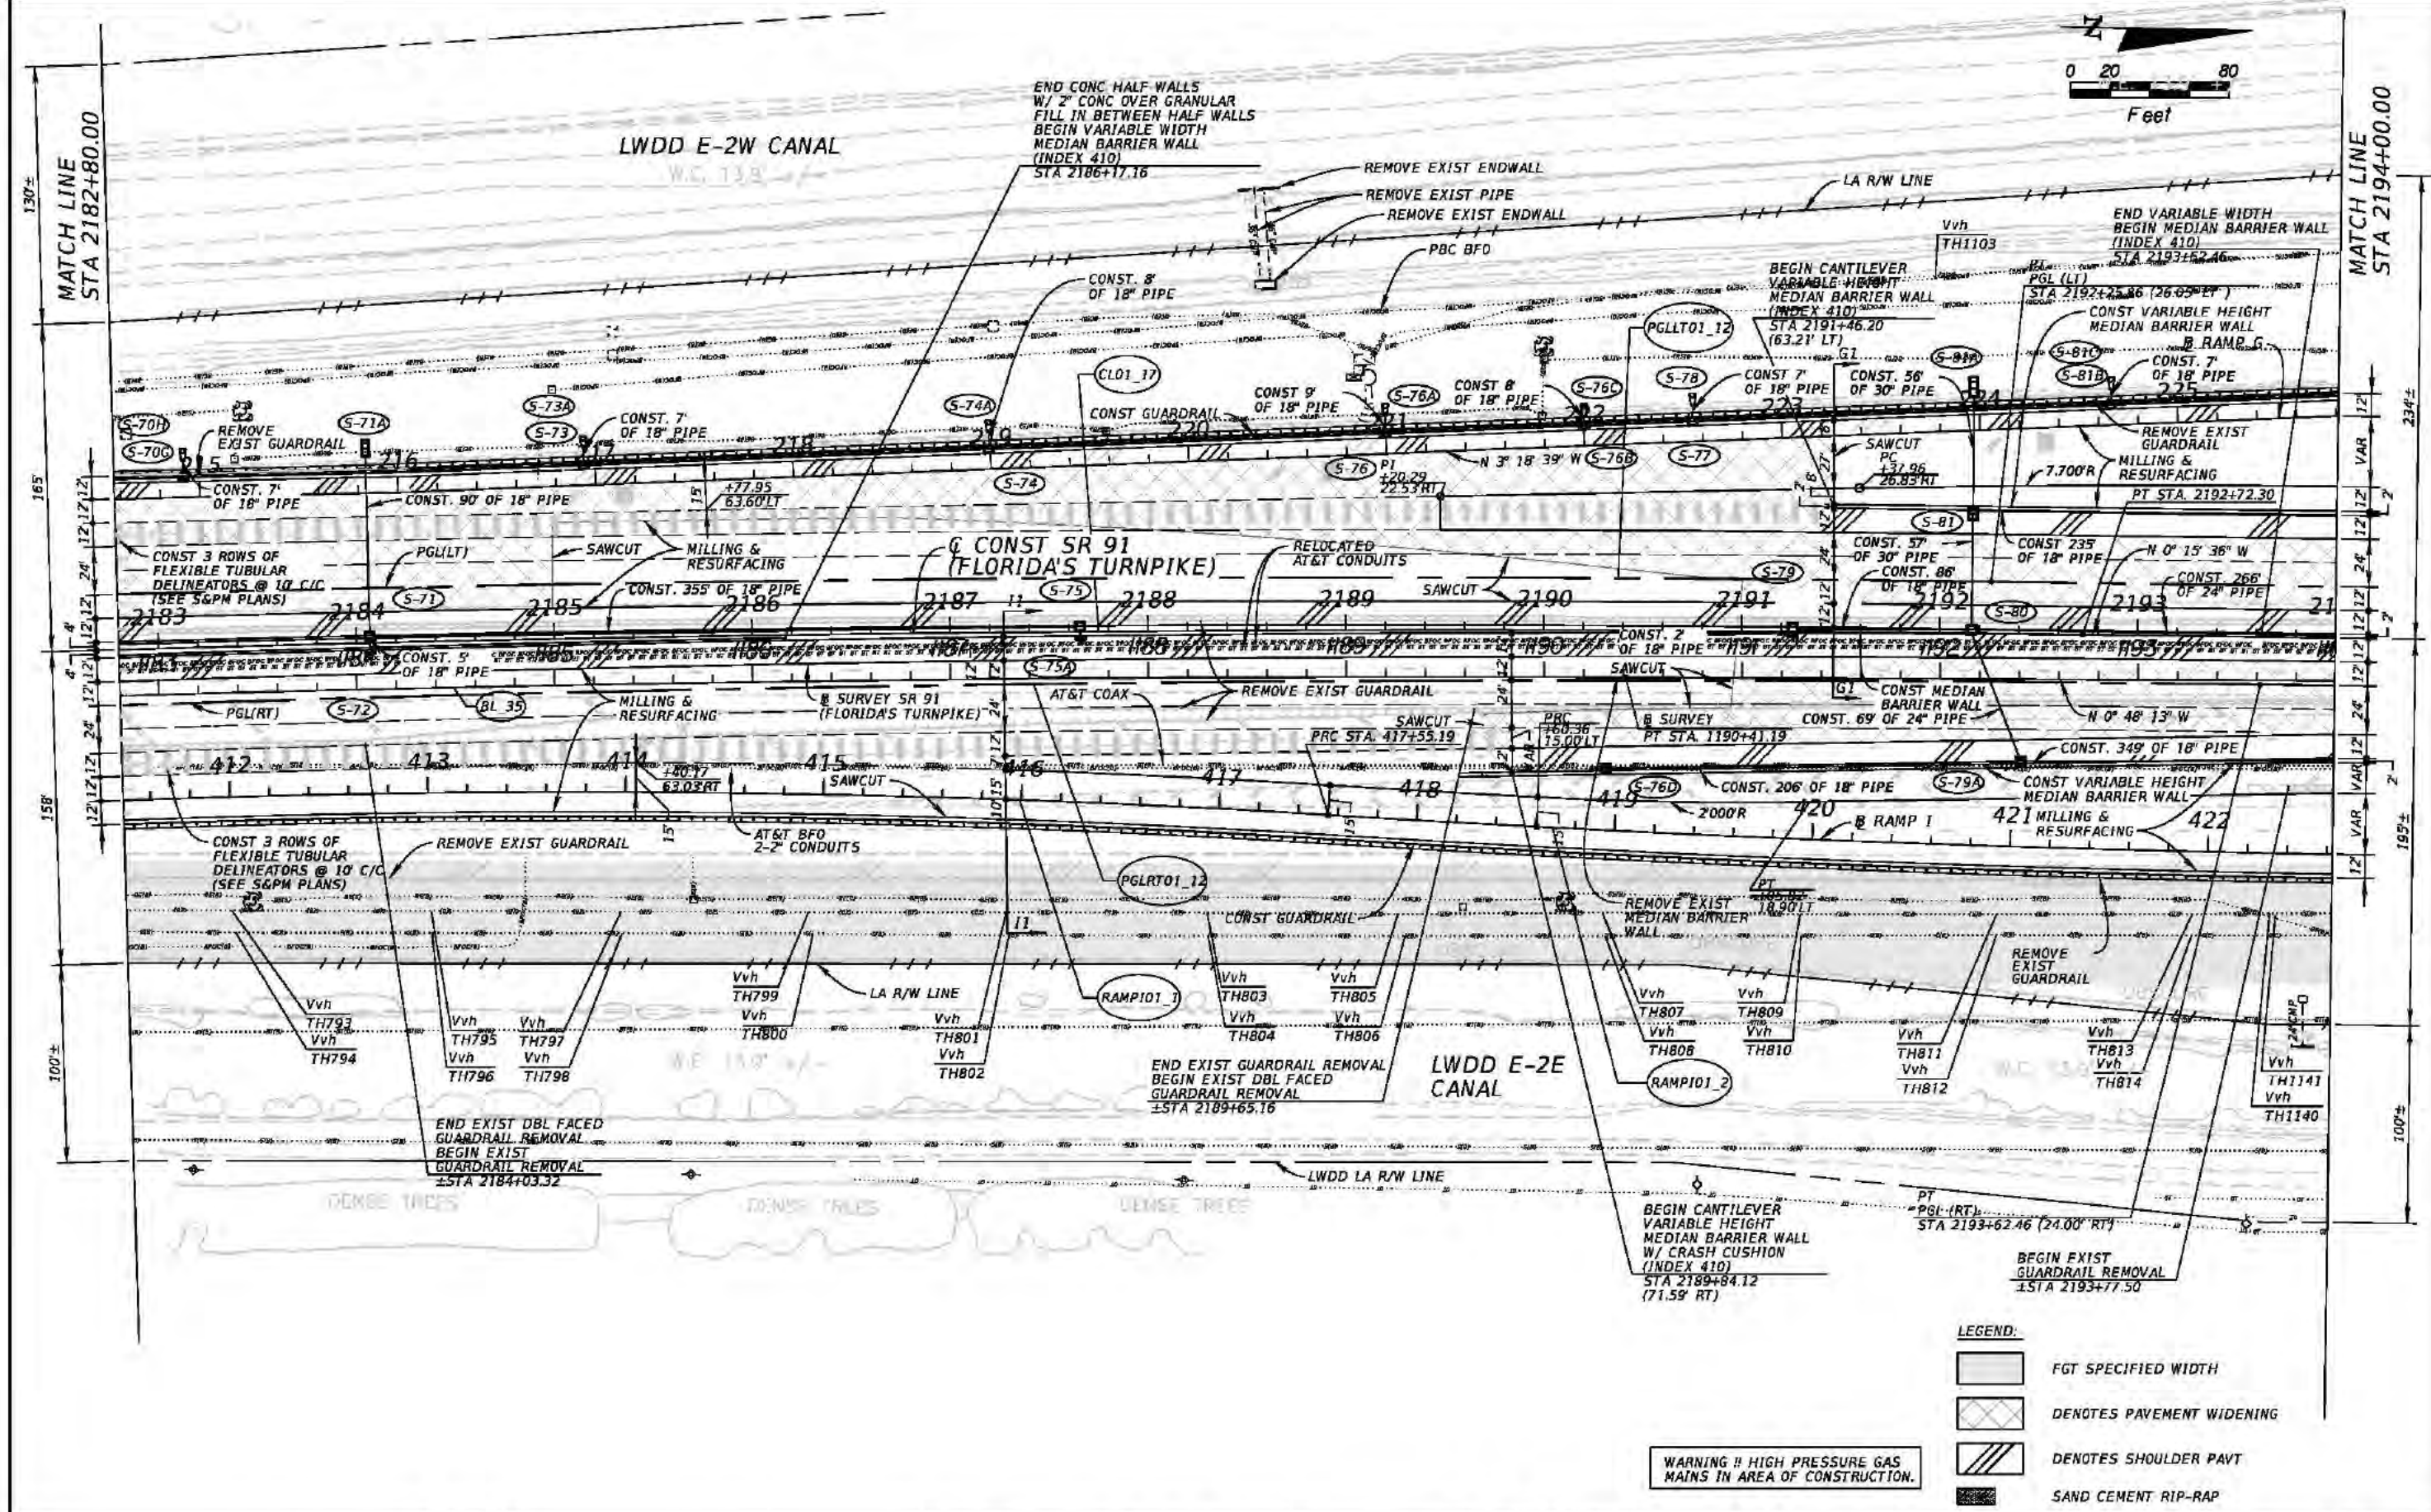

REVISIONS				Kimley-Horn and Associates, Inc. Certificate Of Authorization No. 696 Hool Gin Ng, P.E. P.E. License No. 58123 1920 Wekiva Way, Suite 200 West Palm Beach, Florida 33411	STATE OF FLORIDA DEPARTMENT OF TRANSPORTATION			ROADWAY PLAN (10)	SHEET NO.
DATE	DESCRIPTION	DATE	DESCRIPTION		ROAD NO.	COUNTY	FINANCIAL PROJECT ID		
					SR 91	PALM BEACH	406144-1-52-01		

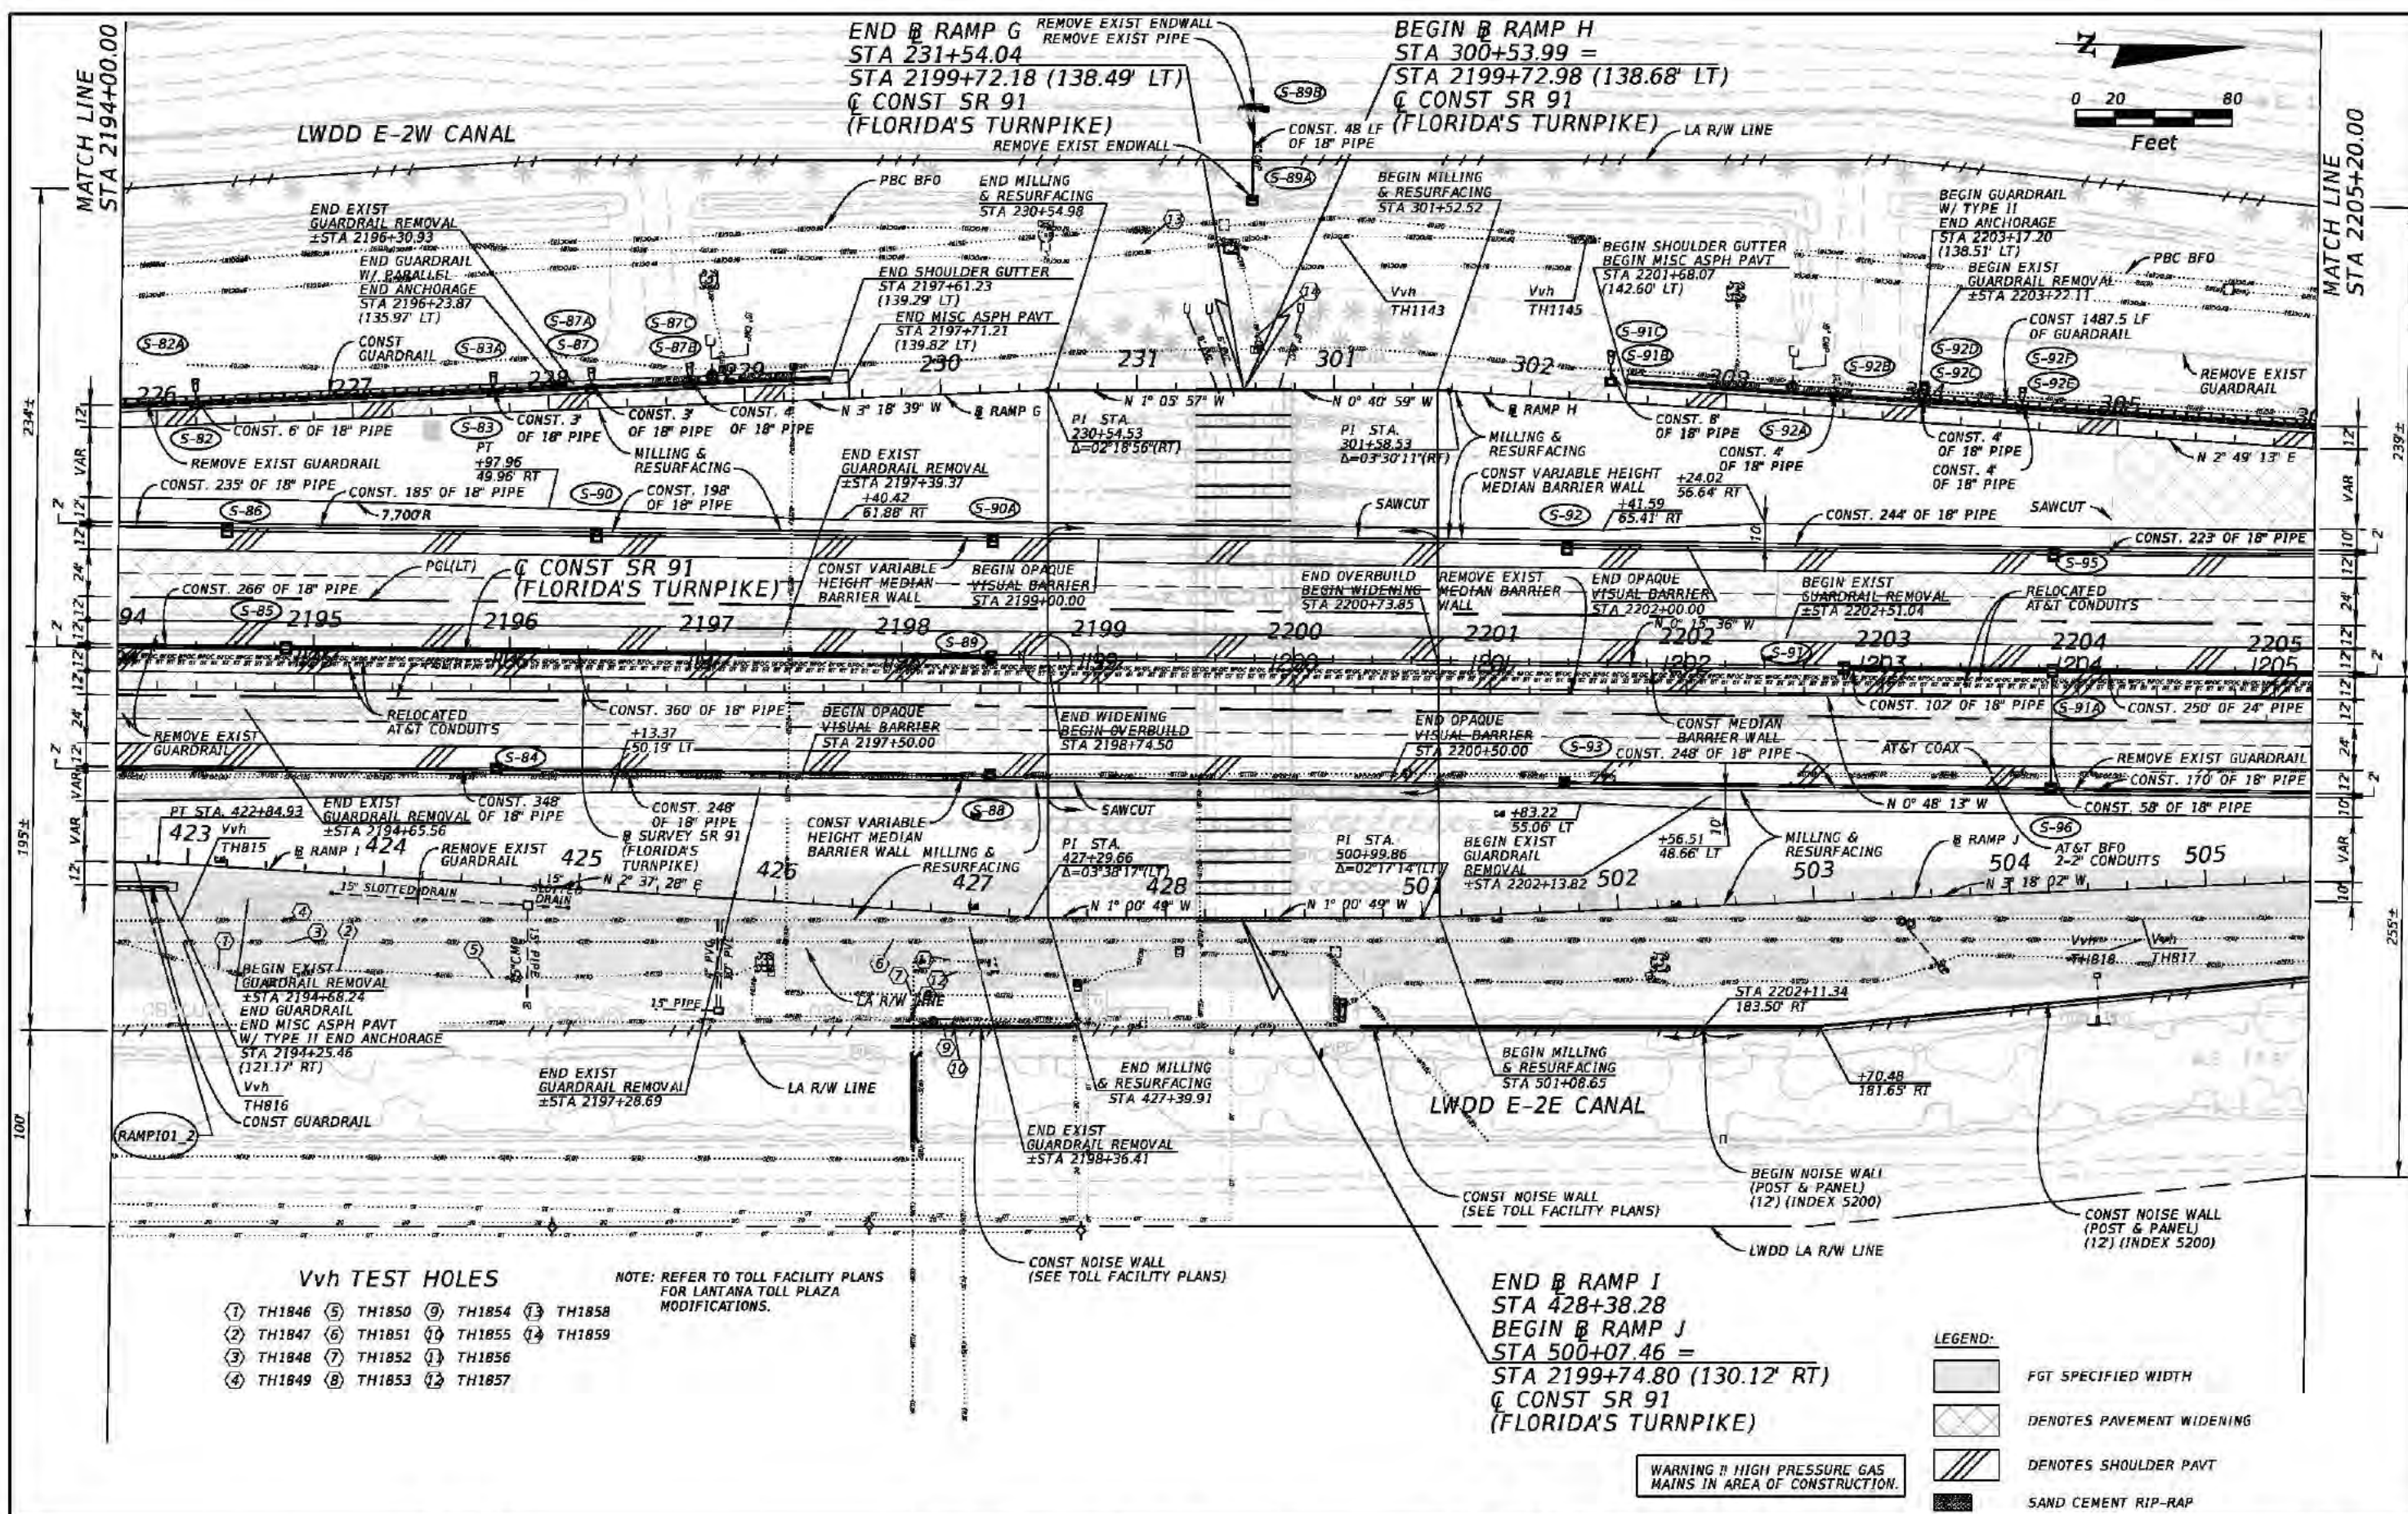


REVISIONS				Kimley-Horn and Associates, Inc. Certificate Of Authorization No. 696 Hool Gin Ng, P.E. P.E. License No. 58123 1920 Wekiva Way, Suite 200 West Palm Beach, Florida 33411	STATE OF FLORIDA DEPARTMENT OF TRANSPORTATION			ROADWAY PLAN (11)	SHEET NO.
DATE	DESCRIPTION	DATE	DESCRIPTION		ROAD NO.	COUNTY	FINANCIAL PROJECT ID		66
					SR 91	PALM BEACH	406144-1-52-01		

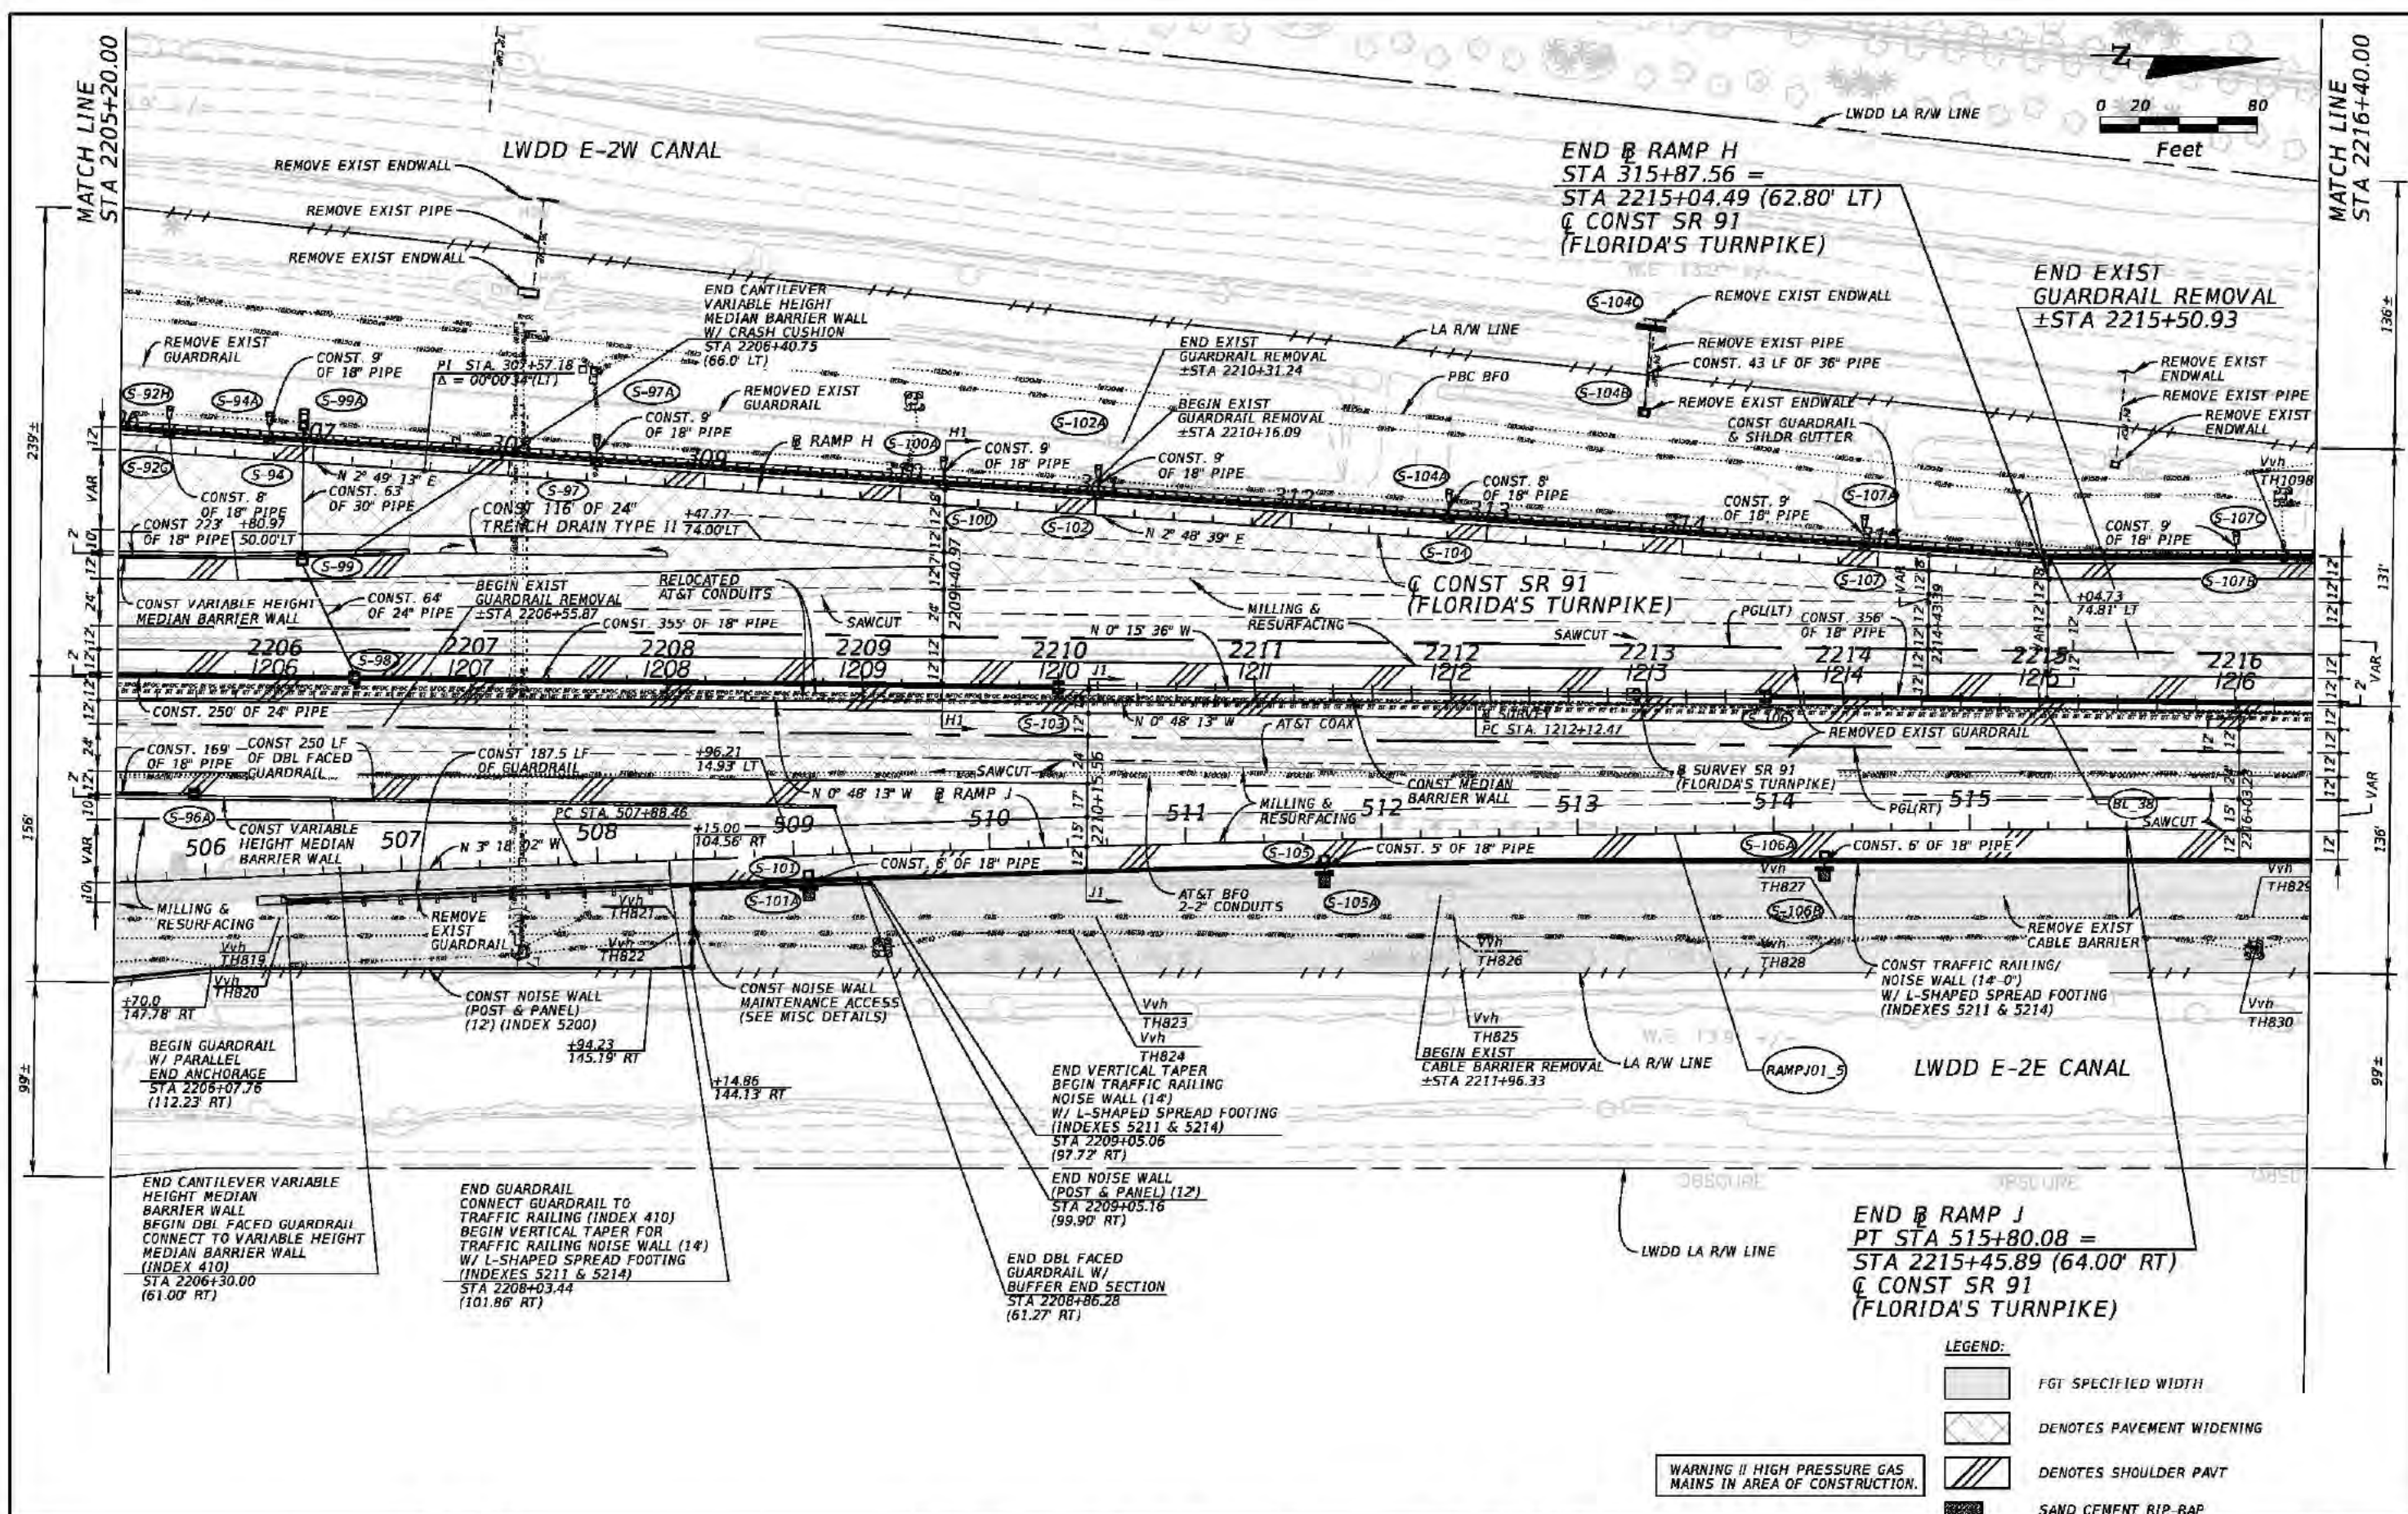

REVISIONS				Kimley-Horn and Associates, Inc. Certificate Of Authorization No. 696 Hool Gin Ng, P.E. P.E. License No. 58123 1920 Wekiva Way, Suite 200 West Palm Beach, Florida 33411	STATE OF FLORIDA DEPARTMENT OF TRANSPORTATION			ROADWAY PLAN (12)	SHEET NO. 67
DATE	DESCRIPTION	DATE	DESCRIPTION		ROAD NO.	COUNTY	FINANCIAL PROJECT ID		
					SR 91	PALM BEACH	406144-1-52-01		

Rob Conklin 2/3/2017 3:49:21 PM K:\WPB_Design\040195061_TPK_BB to LW\40614415201_Roadway\plans\planrd13.dgn


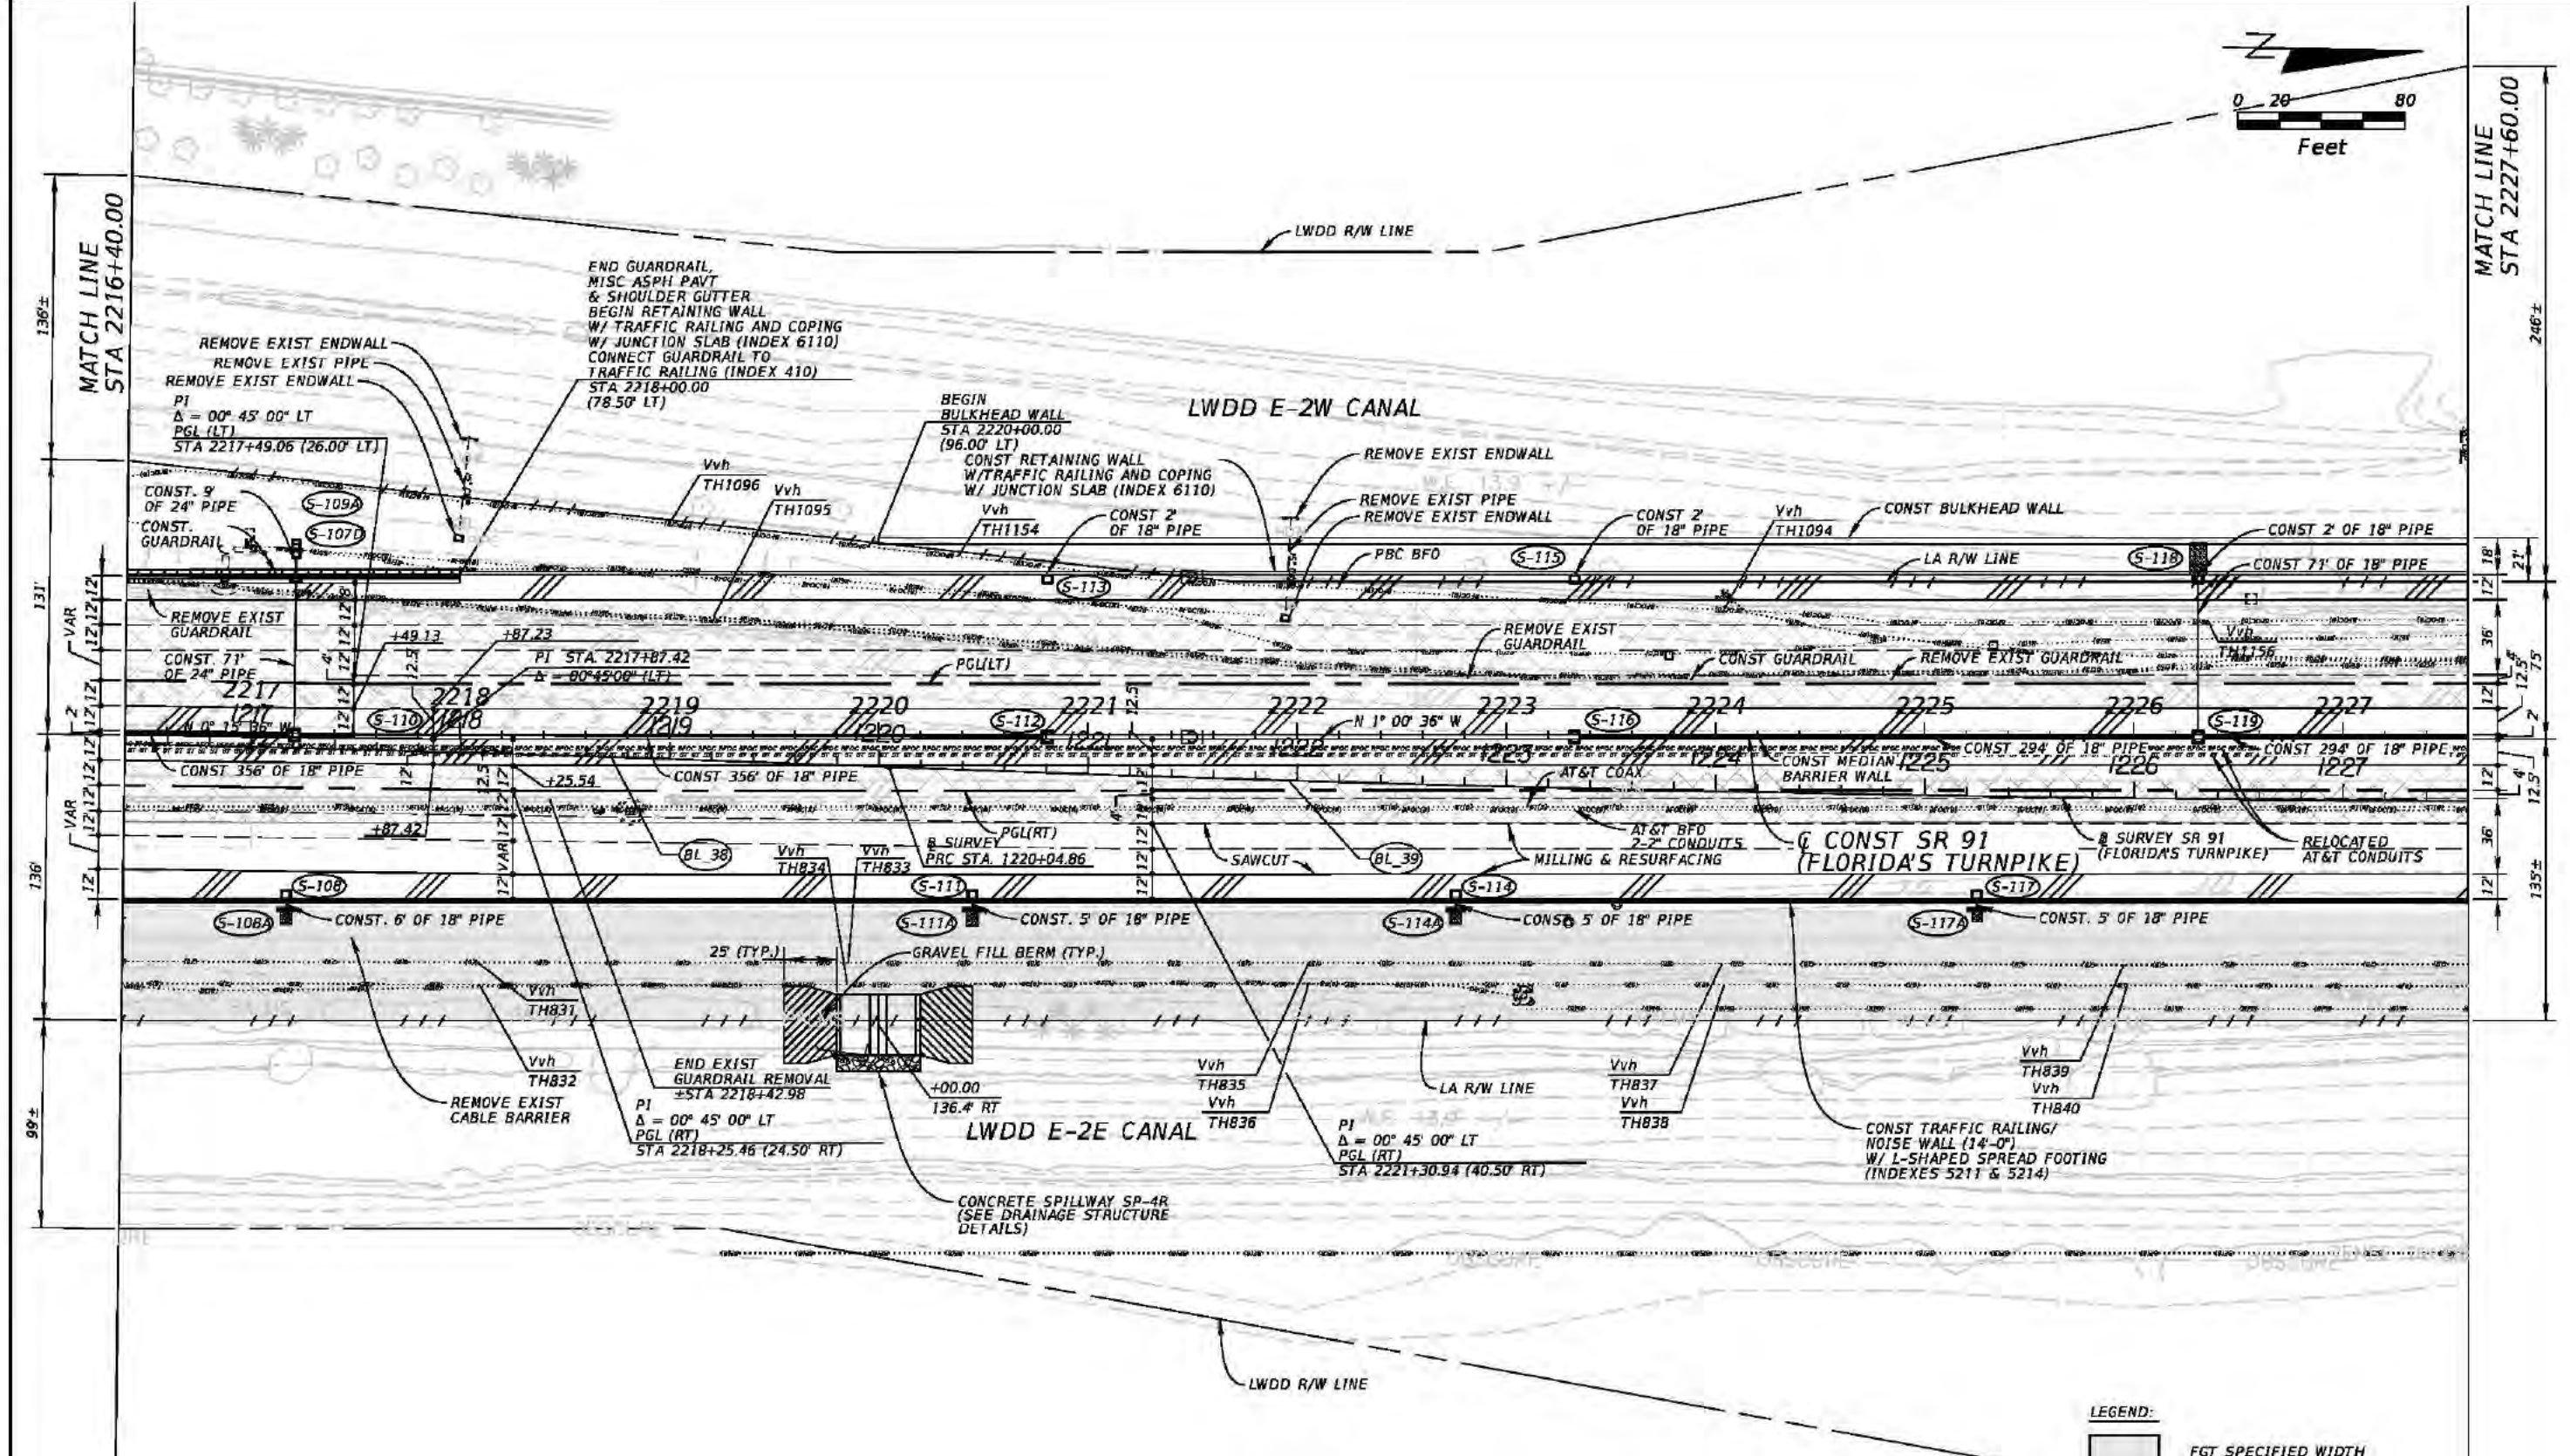


- LEGEND:
- [Pattern] FGT SPECIFIED WIDTH
 - [Pattern] DENOTES PAVEMENT WIDENING
 - [Pattern] DENOTES SHOULDER PAVT
 - [Pattern] SAND CEMENT RIP-RAP

WARNING !! HIGH PRESSURE GAS MAINS IN AREA OF CONSTRUCTION.

REVISIONS				Kimley-Horn and Associates, Inc. Certificate Of Authorization No. 696 Hool Gin Ng, P.E. P.E. License No. 58123 1920 Wekiva Way, Suite 200 West Palm Beach, Florida 33411	STATE OF FLORIDA DEPARTMENT OF TRANSPORTATION			ROADWAY PLAN (13)	SHEET NO. 68
DATE	DESCRIPTION	DATE	DESCRIPTION		ROAD NO.	COUNTY	FINANCIAL PROJECT ID		
					SR 91	PALM BEACH	406144-1-52-01		



Rob Conklin 2/7/2017 12:08:14 PM K:\WPB Design\040195061 TPK BB to LW\40614415201 Realign\roadway\plans\planrd14.dgn

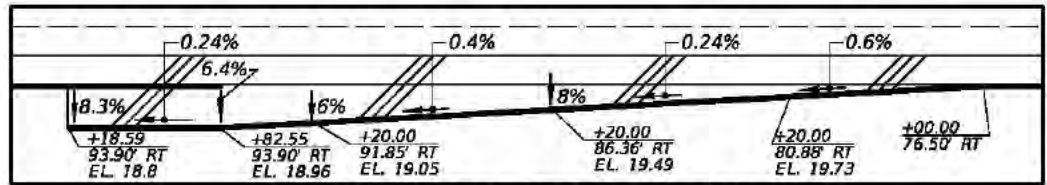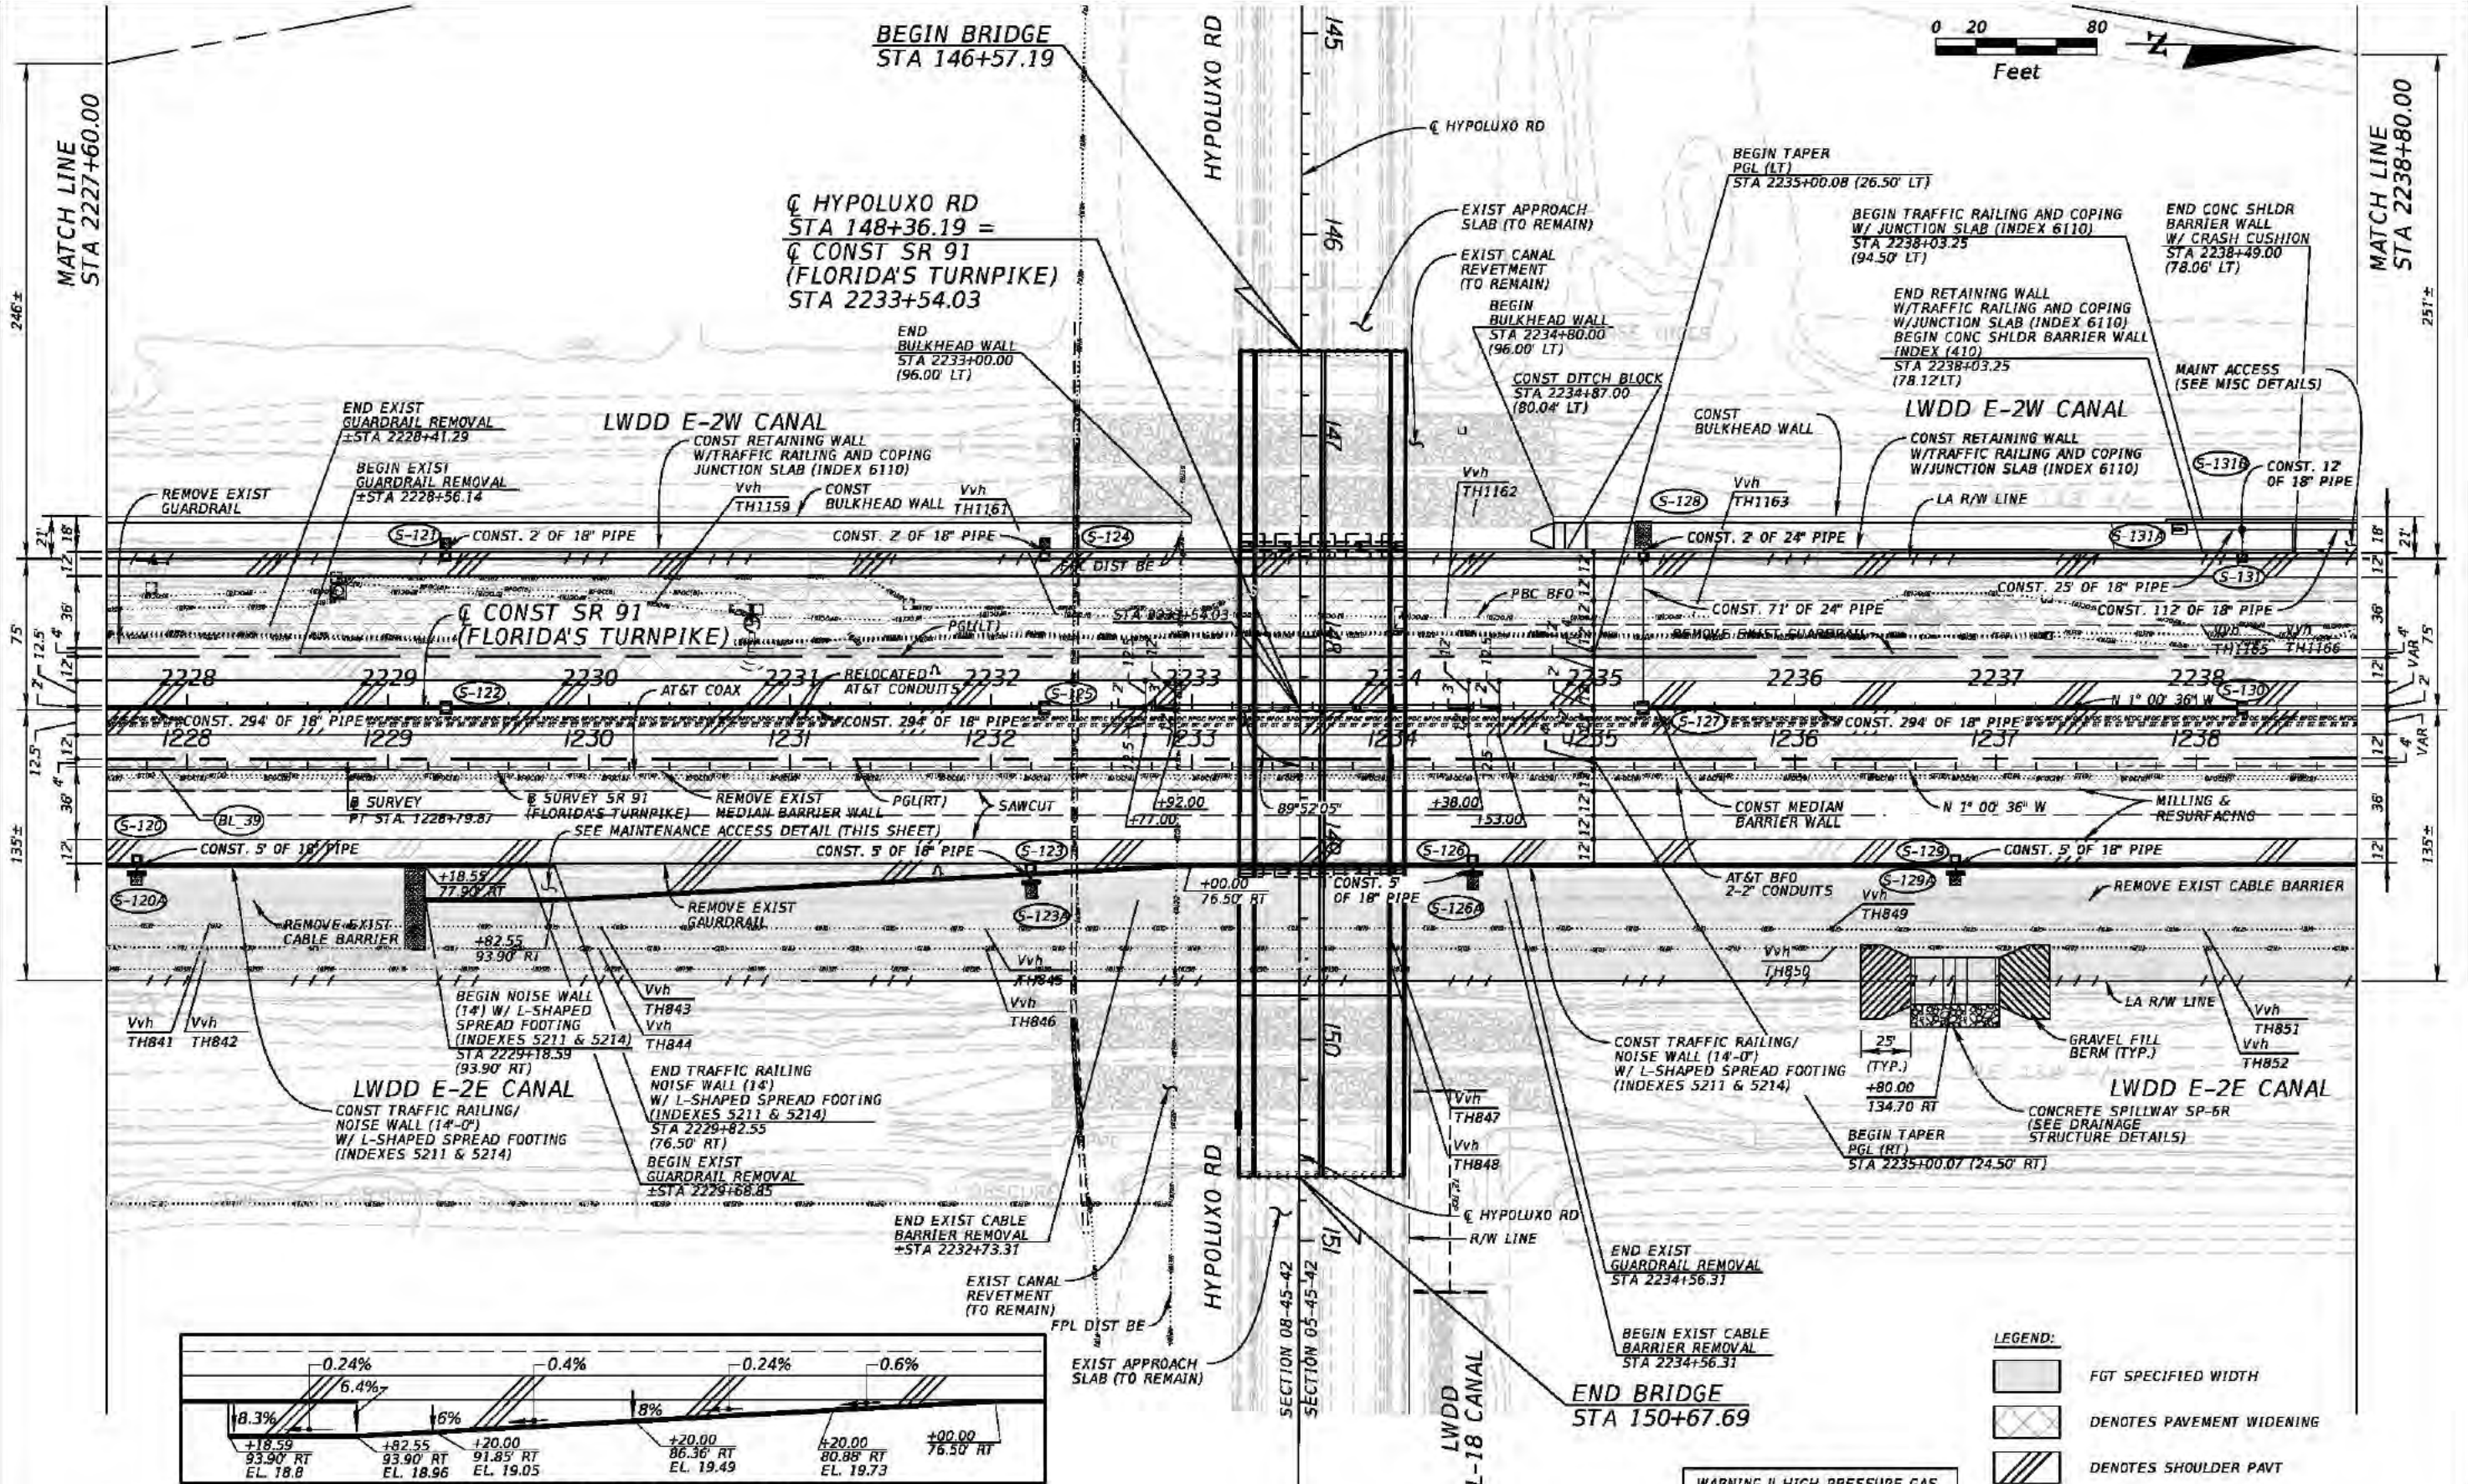

MAINTENANCE ACCESS DETAIL

- LEGEND:
- FGT SPECIFIED WIDTH
 - DENOTES PAVEMENT WIDENING
 - DENOTES SHOULDER PAVT
 - SAND CEMENT RIP-RAP

REVISIONS				Kimley-Horn and Associates, Inc. Certificate Of Authorization No. 696 Hool Gin Ng, P.E. P.E. License No. 58123 1920 Wekiva Way, Suite 200 West Palm Beach, Florida 33411	STATE OF FLORIDA DEPARTMENT OF TRANSPORTATION			ROADWAY PLAN (14)	SHEET NO. 69
DATE	DESCRIPTION	DATE	DESCRIPTION		ROAD NO.	COUNTY	FINANCIAL PROJECT ID		
					SR 91	PALM BEACH	406144-1-52-01		

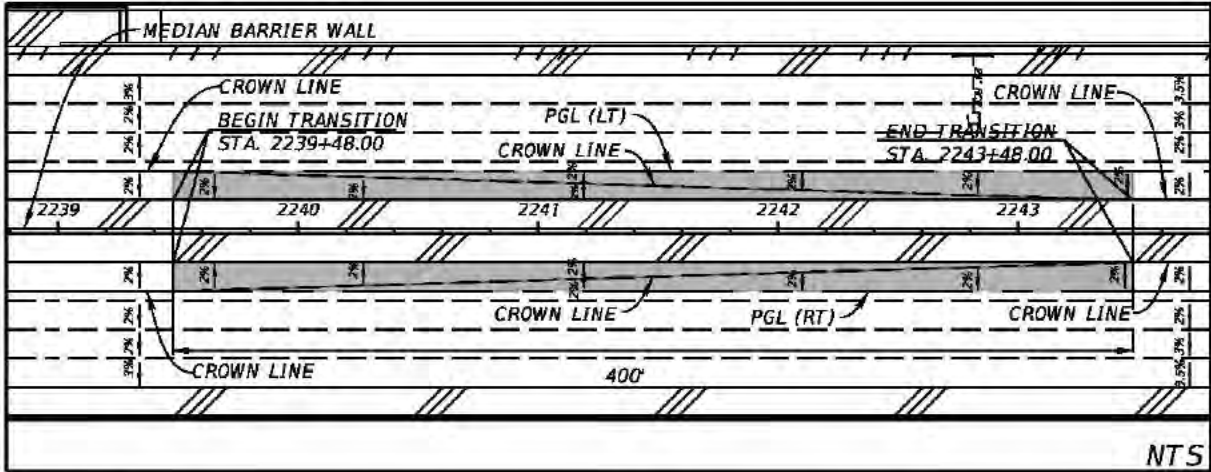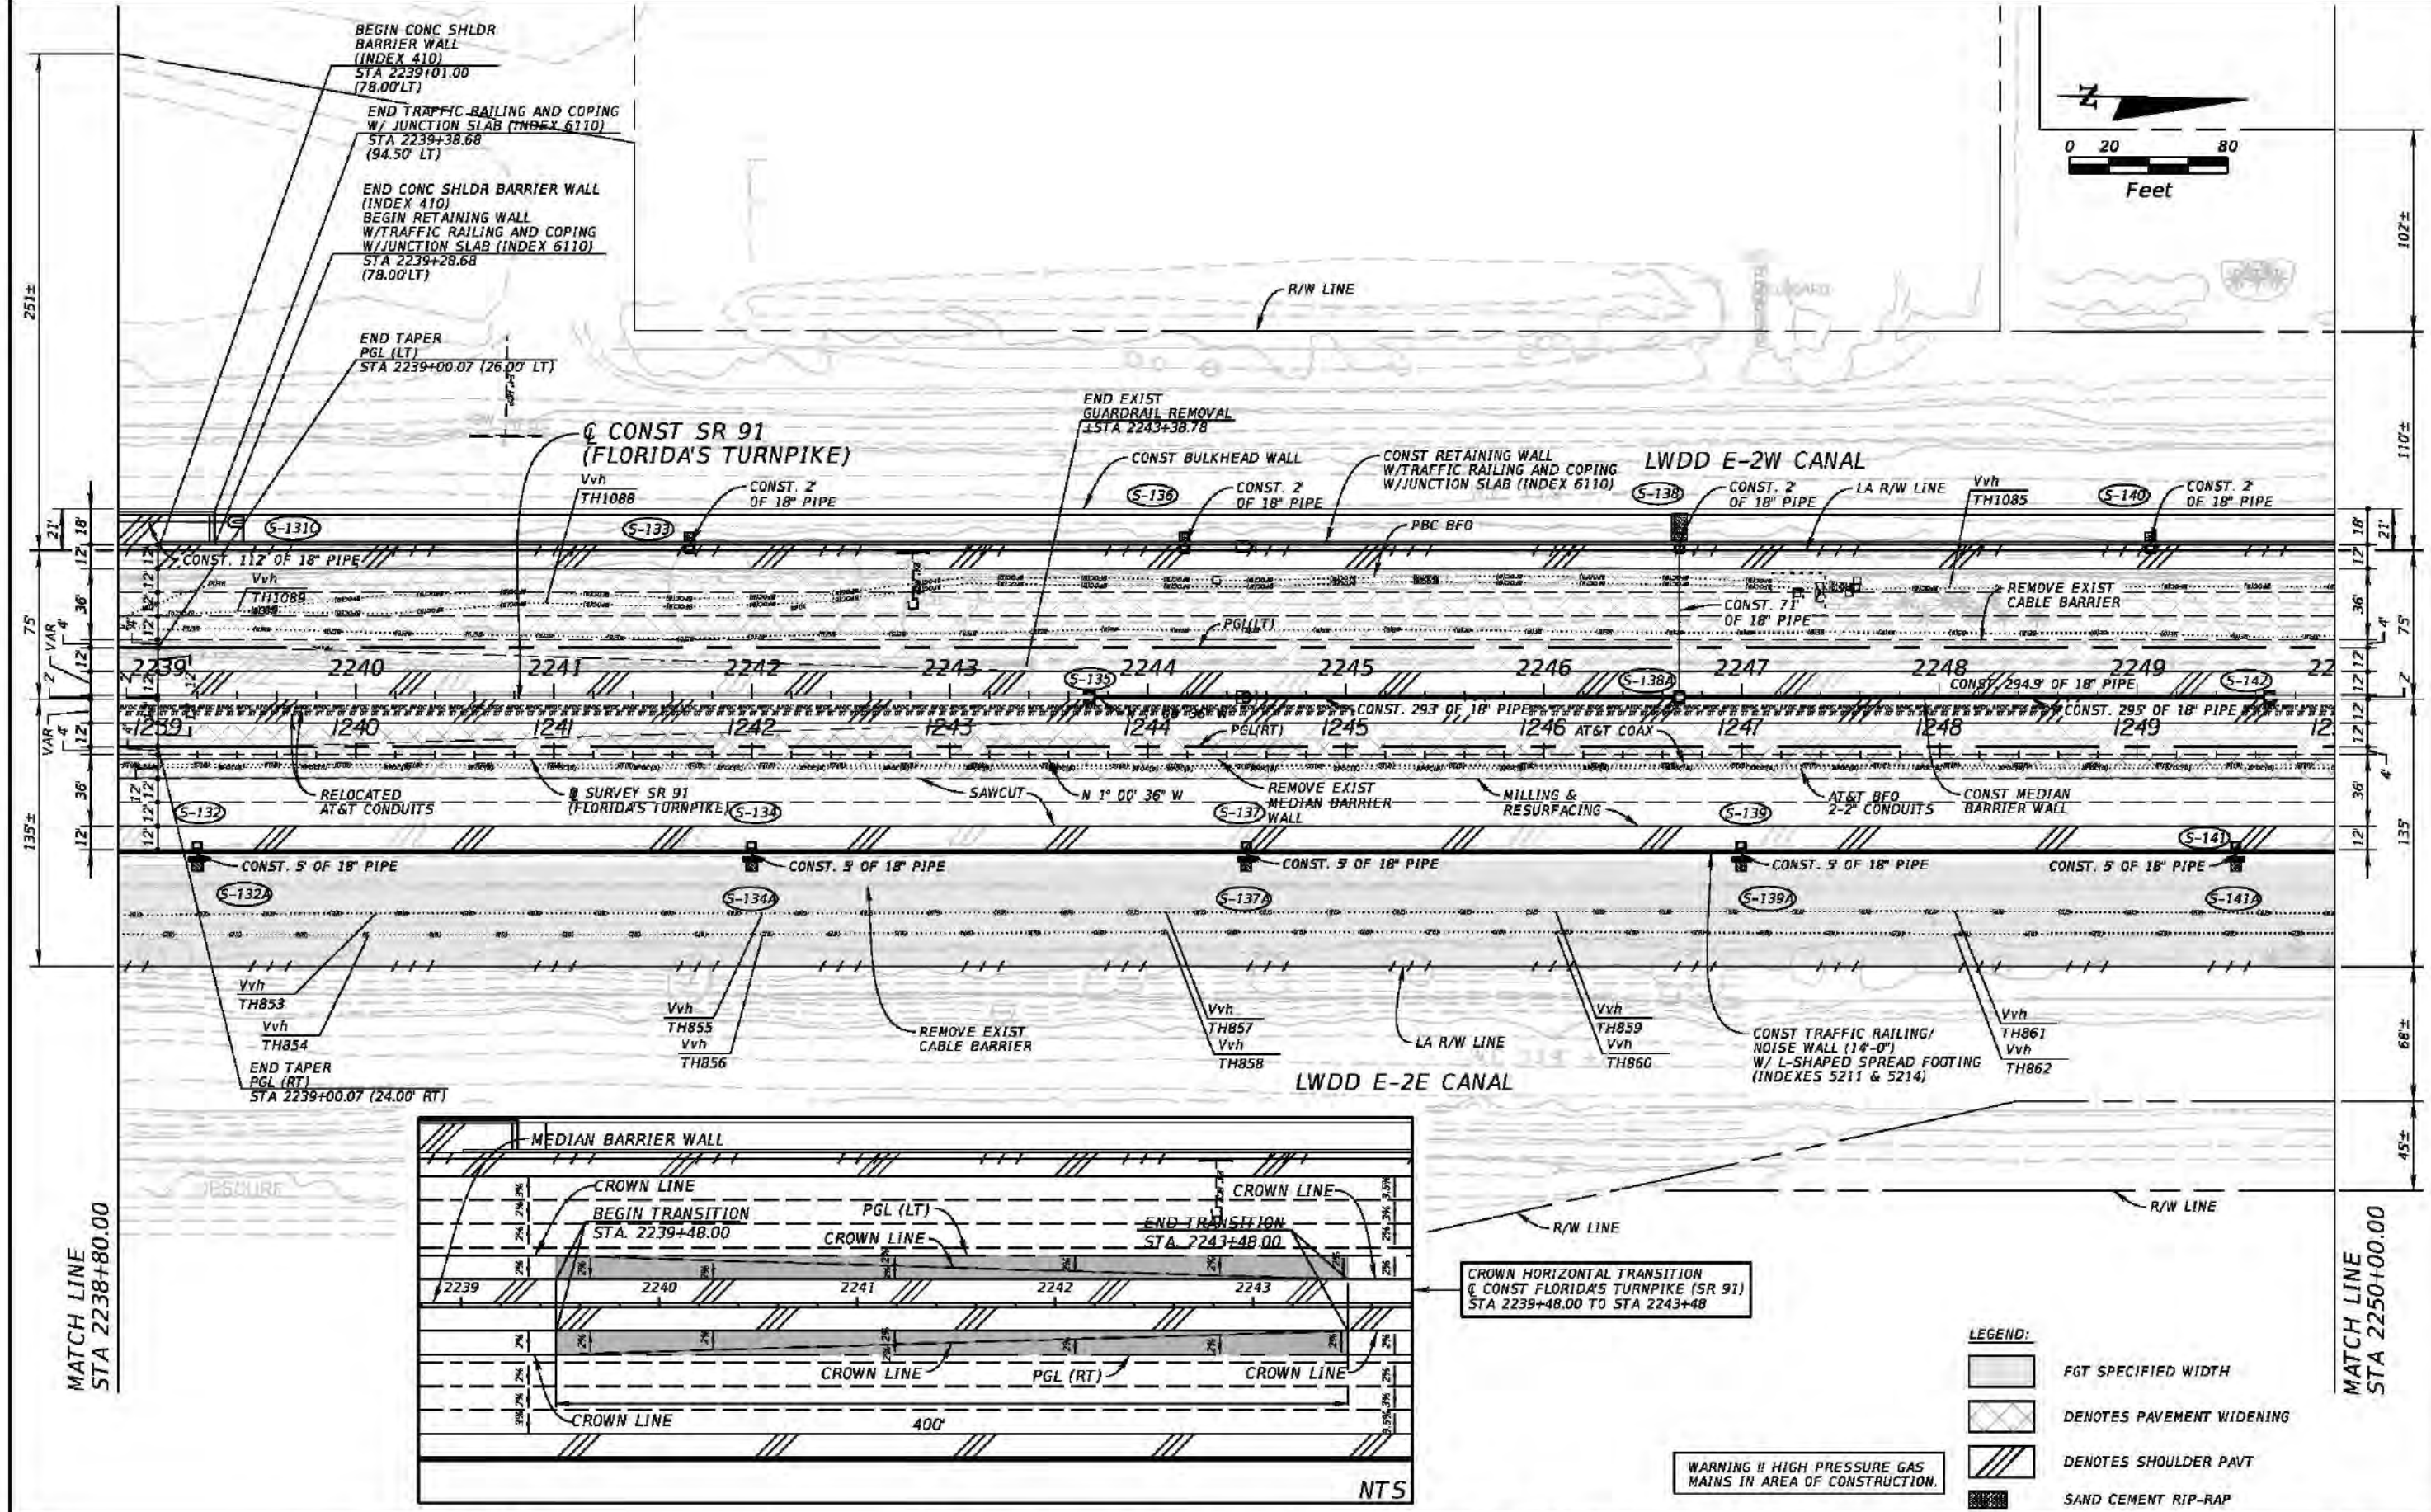

- LEGEND:
- [Pattern] F&T SPECIFIED WIDTH
 - [Pattern] DENOTES PAVEMENT WIDENING
 - [Pattern] DENOTES SHOULDER PAVT
 - [Pattern] SAND CEMENT RIP-RAP

WARNING !! HIGH PRESSURE GAS MAINS IN AREA OF CONSTRUCTION.

REVISIONS			
DATE	DESCRIPTION	DATE	DESCRIPTION


Kimley-Horn and Associates, Inc.
Certificate Of Authorization No. 696
Hool Gin Ng, P.E.
P.E. License No. 58123
1920 Wekiva Way, Suite 200
West Palm Beach, Florida 33411

STATE OF FLORIDA
DEPARTMENT OF TRANSPORTATION

ROAD NO.	COUNTY	FINANCIAL PROJECT ID
SR 91	PALM BEACH	406144-1-52-01

ROADWAY PLAN (15)

SHEET NO. 70


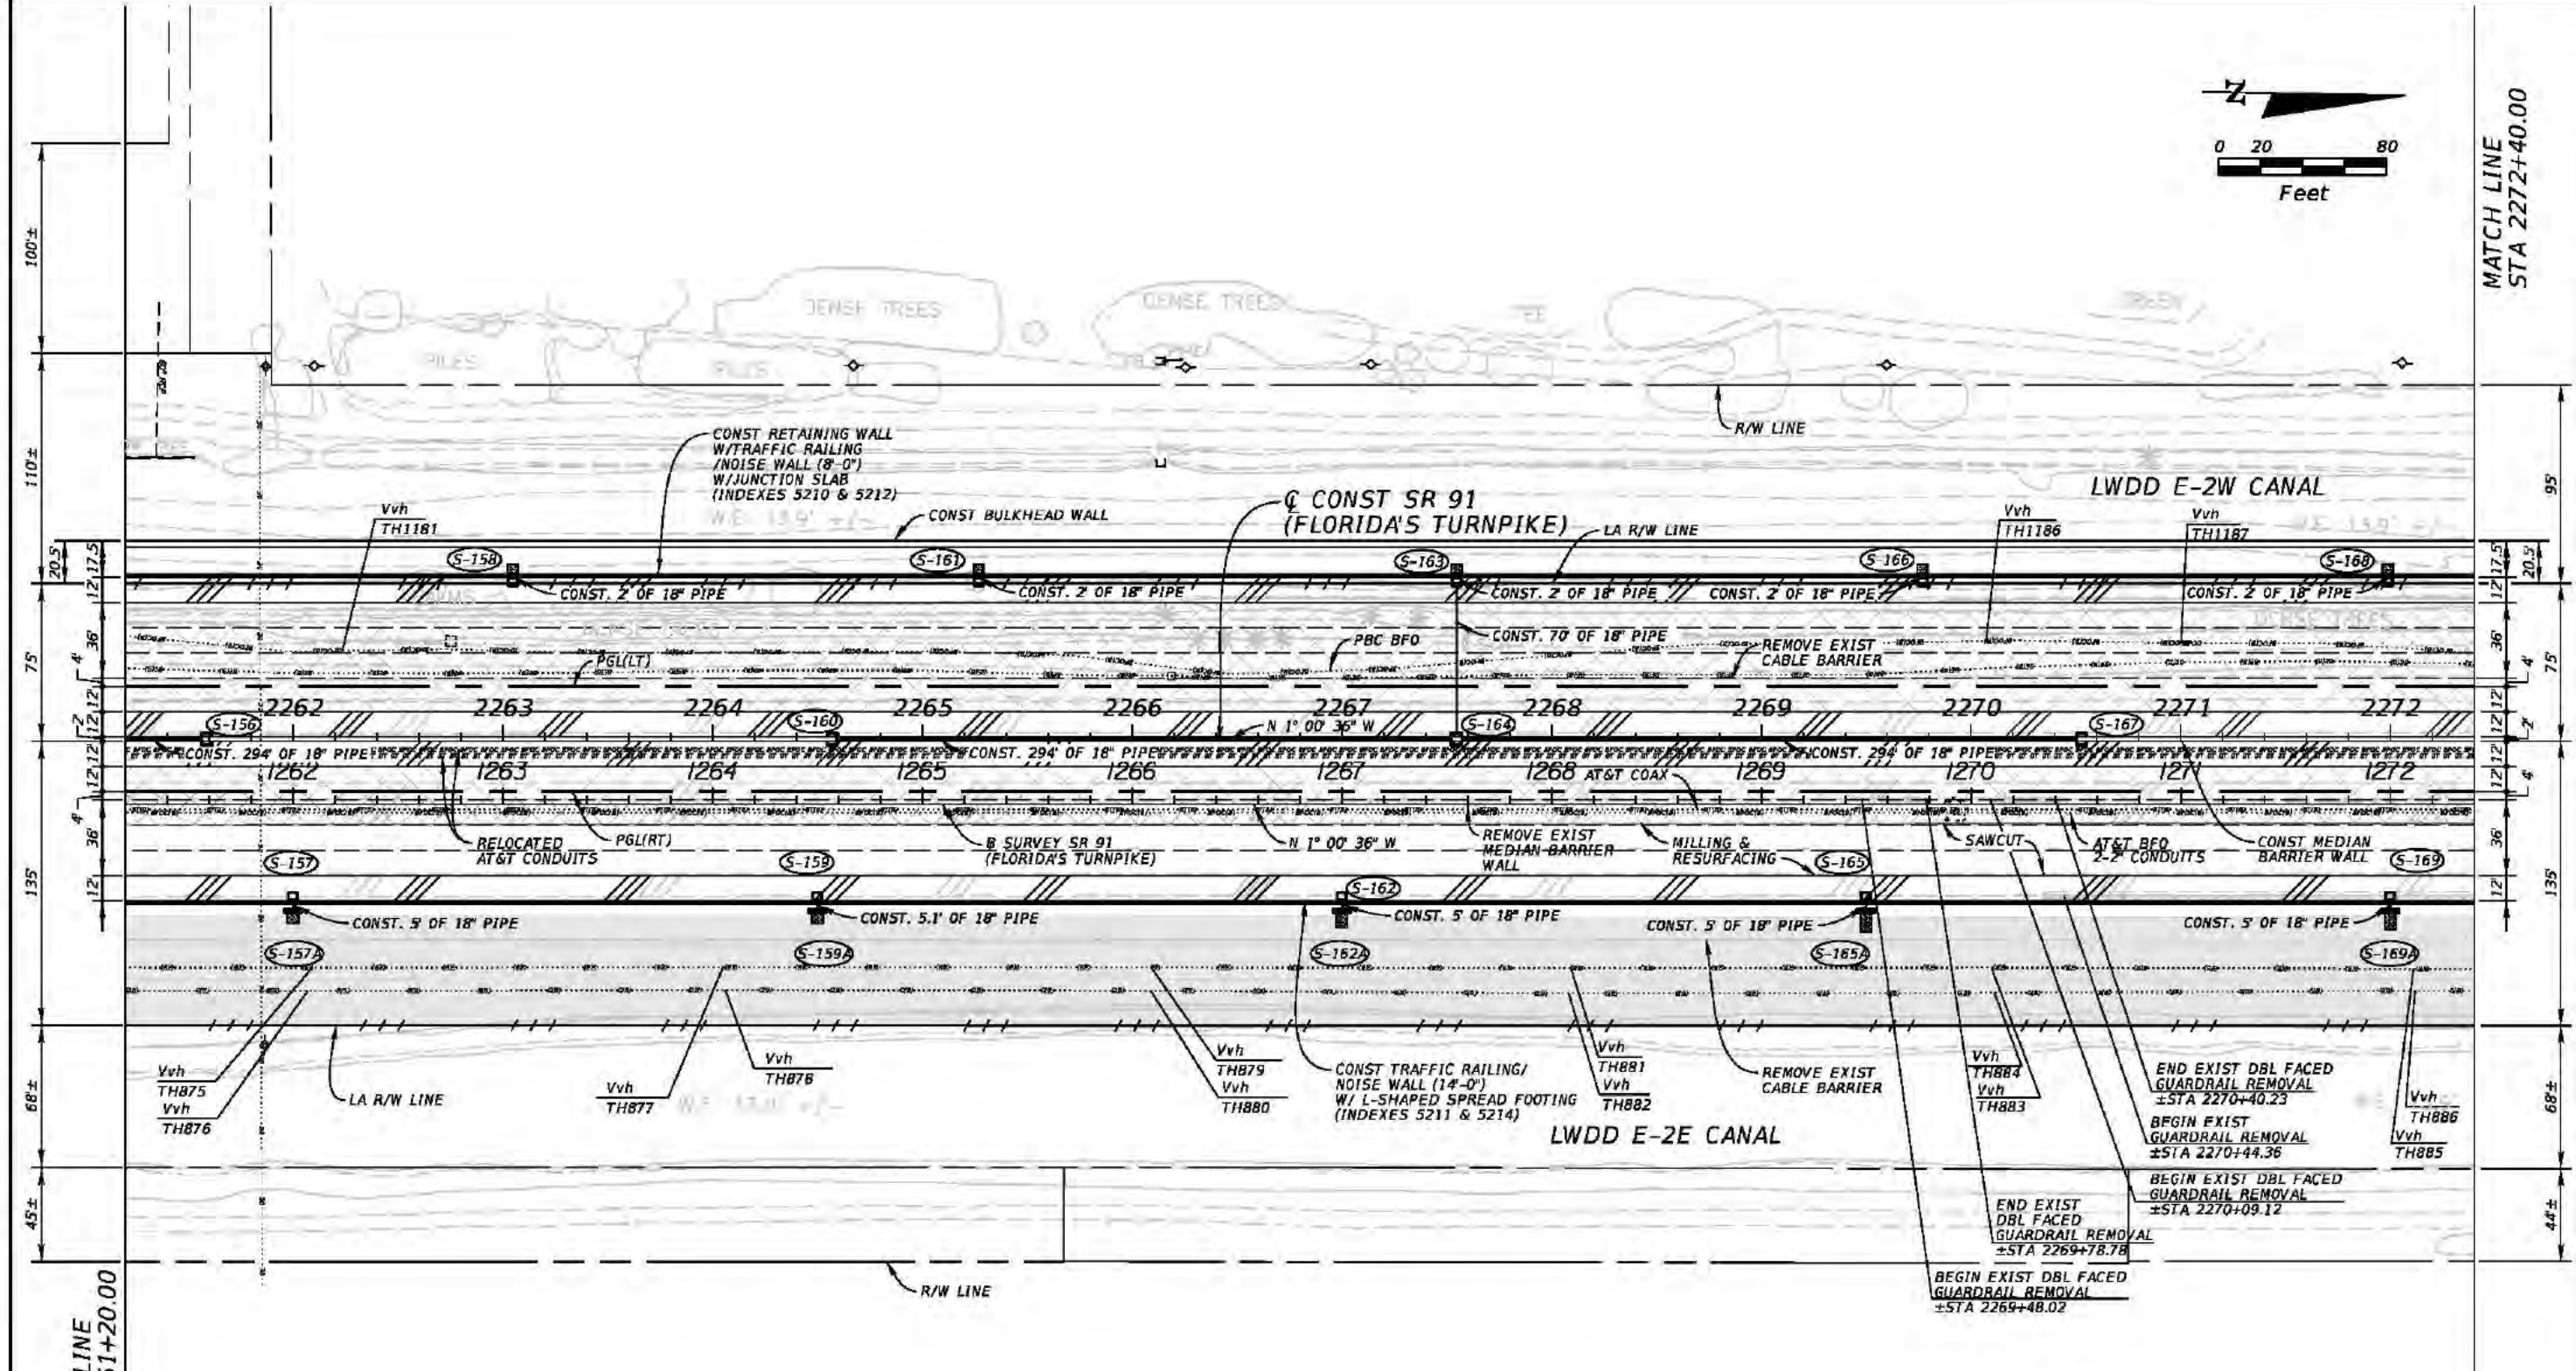


- LEGEND:
- FGT SPECIFIED WIDTH
 - DENOTES PAVEMENT WIDENING
 - DENOTES SHOULDER PAVT
 - SAND CEMENT RIP-RAP

WARNING !! HIGH PRESSURE GAS MAINS IN AREA OF CONSTRUCTION.

REVISIONS				Kimley-Horn and Associates, Inc. Certificate Of Authorization No. 696 Hool Gin Ng, P.E. P.E. License No. 58123 1920 Wekiva Way, Suite 200 West Palm Beach, Florida 33411	STATE OF FLORIDA DEPARTMENT OF TRANSPORTATION			ROADWAY PLAN (17)	SHEET NO. 72
DATE	DESCRIPTION	DATE	DESCRIPTION		ROAD NO.	COUNTY	FINANCIAL PROJECT ID		
					SR 91	PALM BEACH	406144-1-52-01		

2/3/2017 3:49:59 PM K:\WPB_Design\040195061_TPK_BB_to_LW\40614415201_Realign\roadway\plans\planrd18.dgn

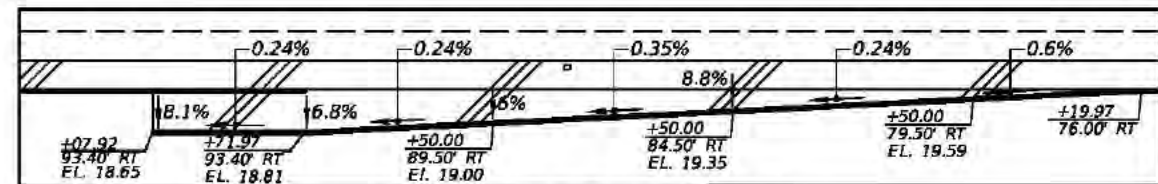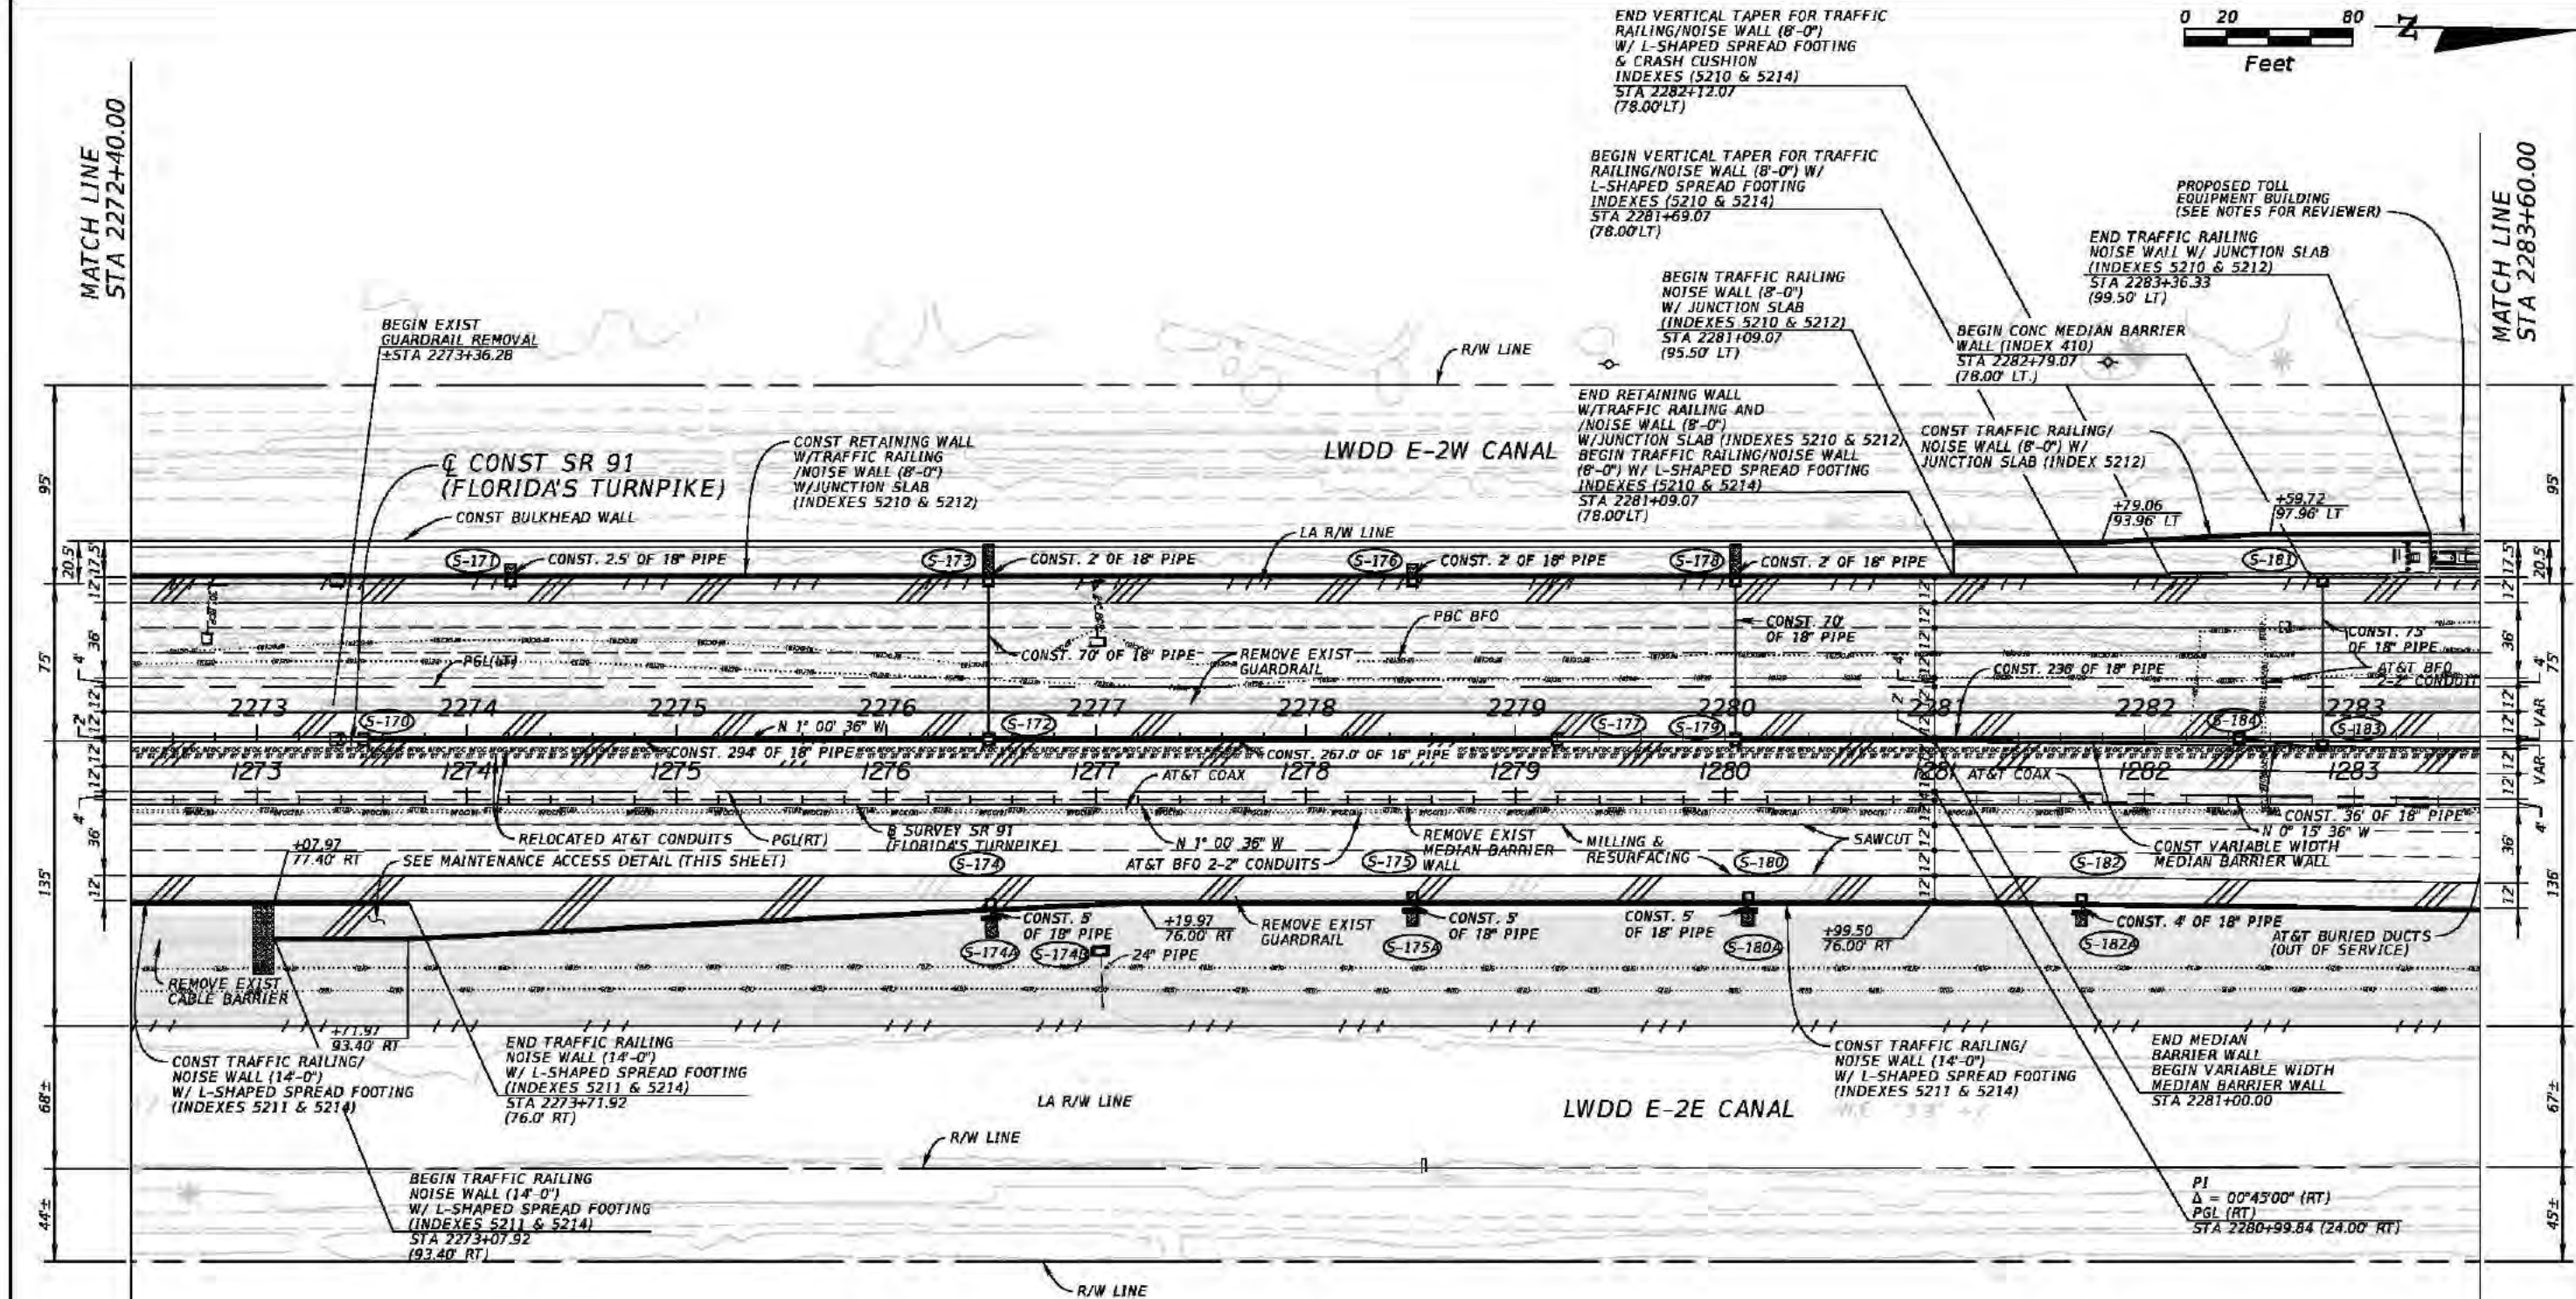


MAINTENANCE ACCESS DETAIL

- LEGEND:
- FGT SPECIFIED WIDTH
 - DENOTES PAVEMENT WIDENING
 - DENOTES SHOULDER PAVT
 - SAND CEMENT RIP-RAP

WARNING !! HIGH PRESSURE GAS MAINS IN AREA OF CONSTRUCTION.


REVISIONS				Kimley-Horn and Associates, Inc. Certificate Of Authorization No. 696 Hool Gin Ng, P.E. P.E. License No. 58123 1920 Wekiva Way, Suite 200 West Palm Beach, Florida 33411	STATE OF FLORIDA DEPARTMENT OF TRANSPORTATION			ROADWAY PLAN (18)	SHEET NO. 73
DATE	DESCRIPTION	DATE	DESCRIPTION		ROAD NO.	COUNTY	FINANCIAL PROJECT ID		
					SR 91	PALM BEACH	406144-1-52-01		


2/3/2017 3:50:03 PM K:\WPB_Design\040195061_TPK_BB_to_LW\40614415201_Realign\roadway\plans\planrd19.DGN

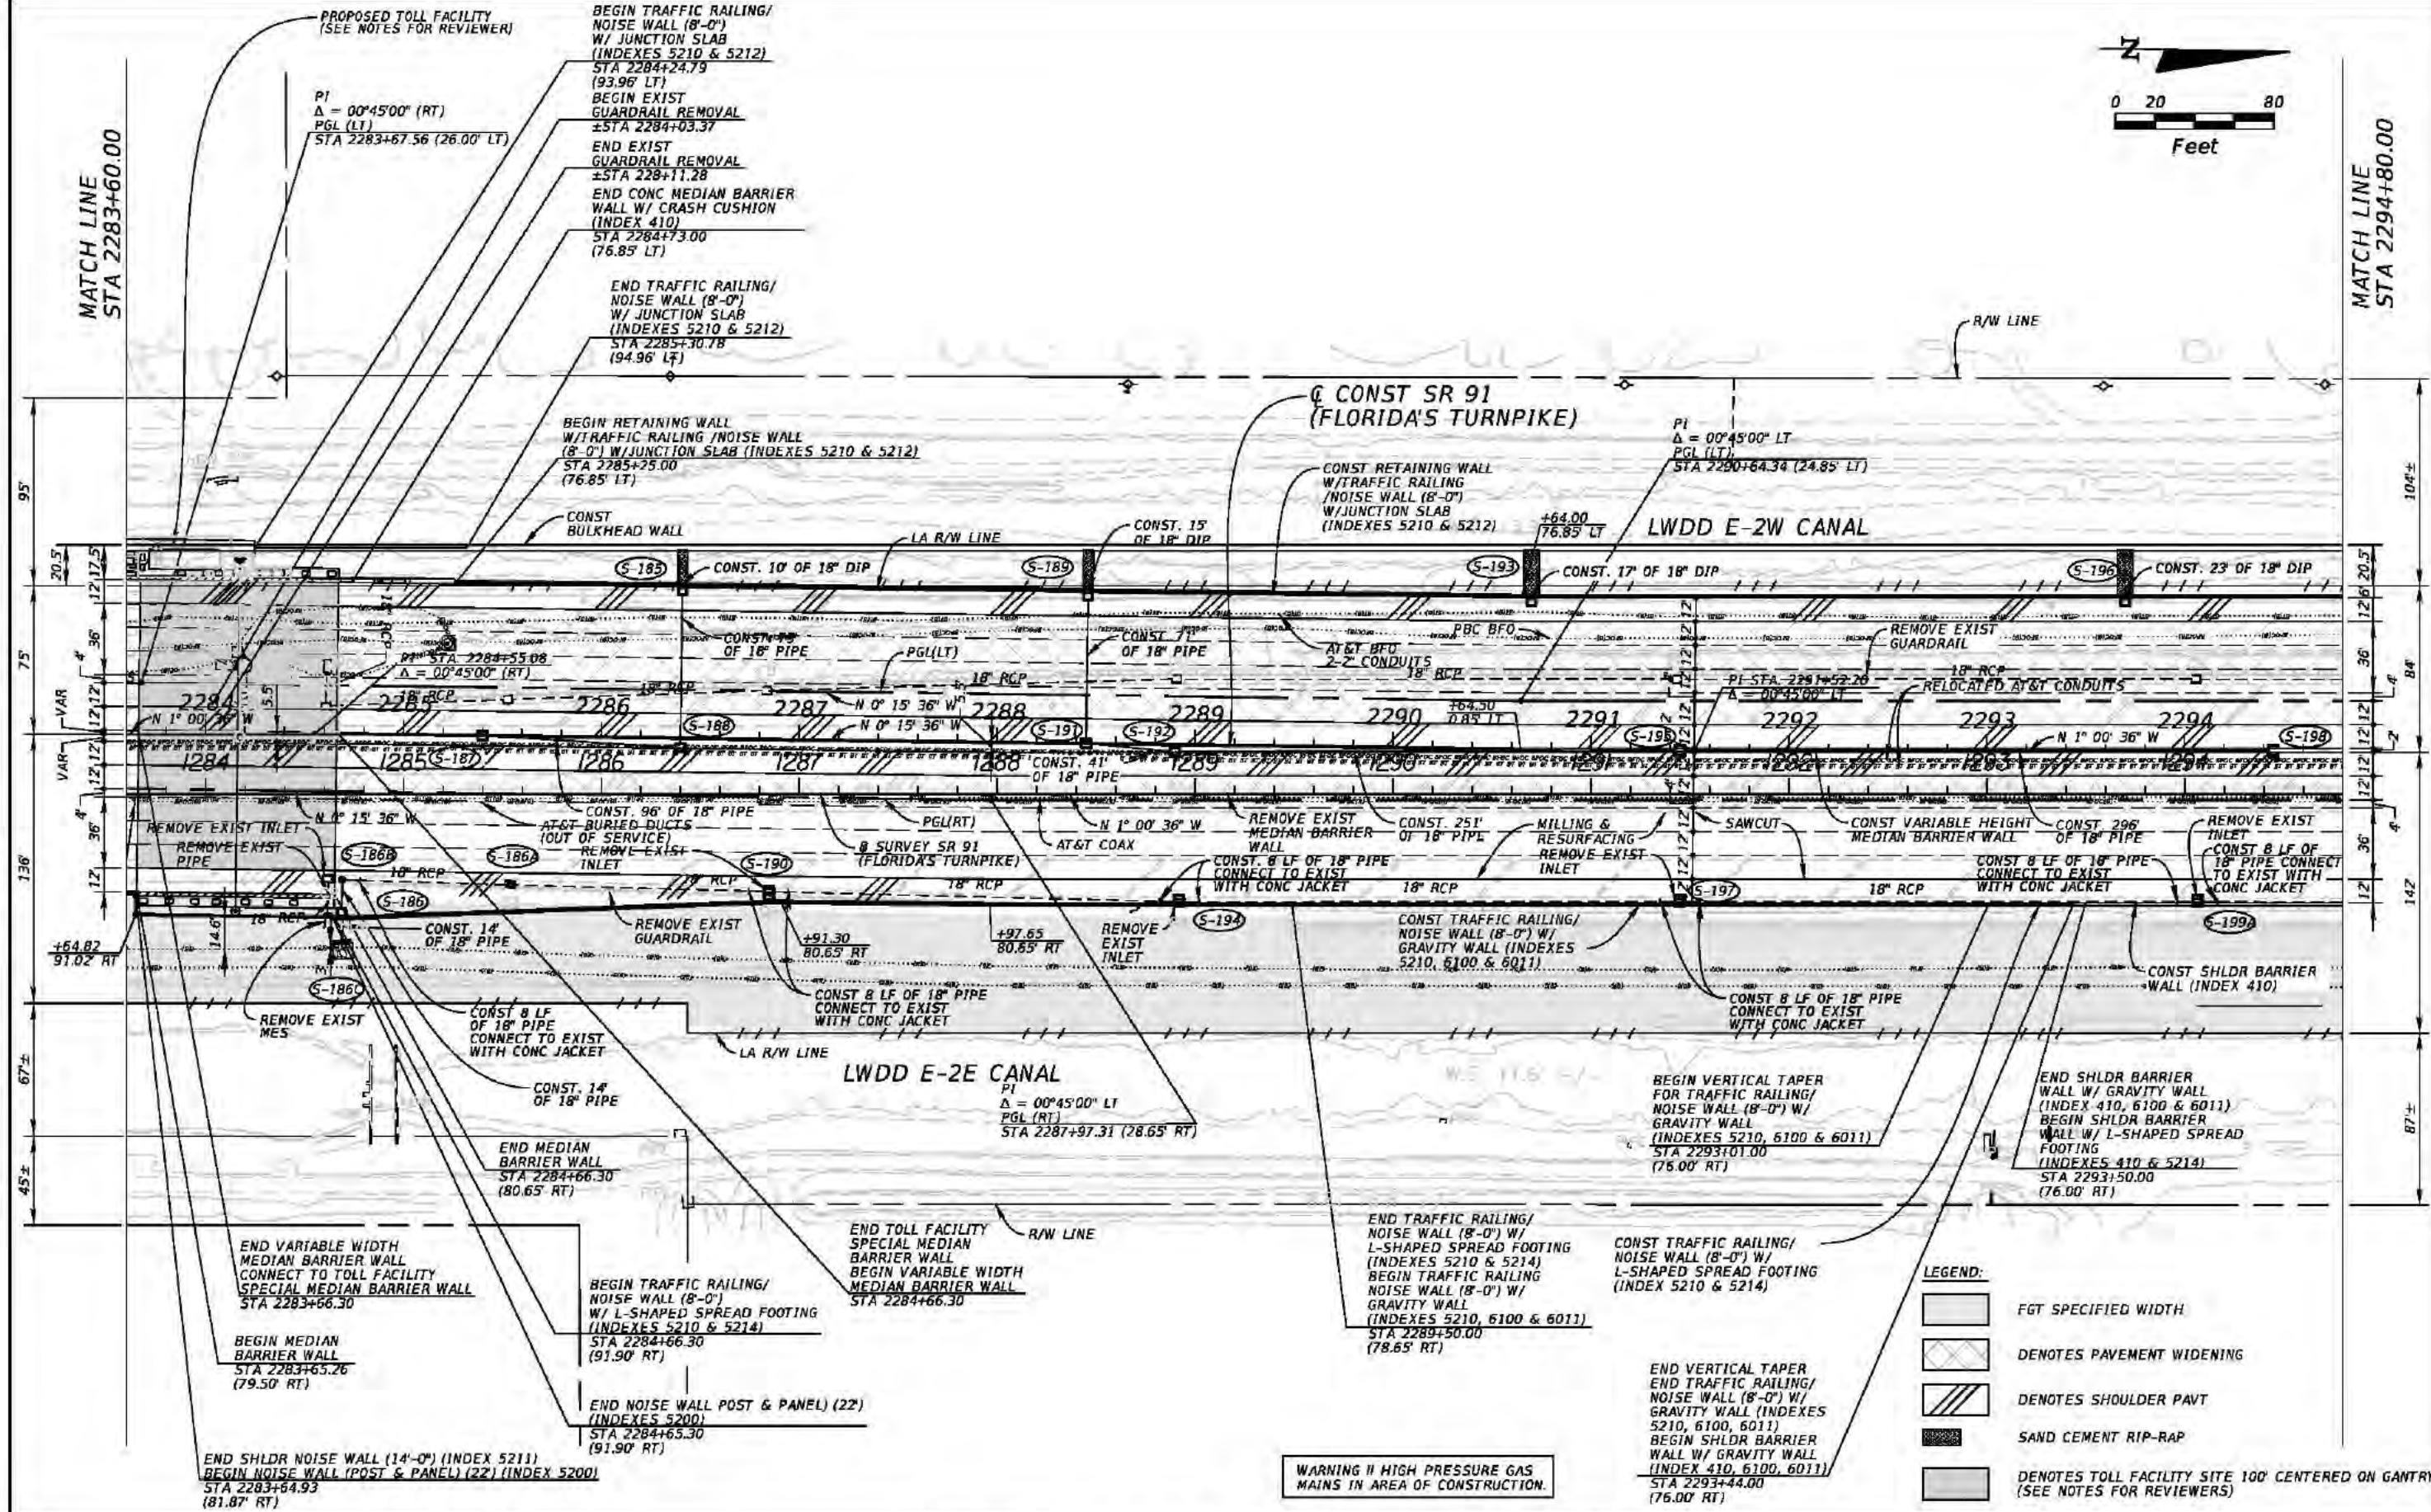

REVISIONS				Kimley-Horn and Associates, Inc. Certificate Of Authorization No. 696 Hool Gin Ng, P.E. P.E. License No. 58123 1920 Wekiva Way, Suite 200 West Palm Beach, Florida 33411	STATE OF FLORIDA DEPARTMENT OF TRANSPORTATION			ROADWAY PLAN (19)	SHEET NO. 74
DATE	DESCRIPTION	DATE	DESCRIPTION		ROAD NO.	COUNTY	FINANCIAL PROJECT ID		
					SR 91	PALM BEACH	406144-1-52-01		

Rob Conklin 2/3/2017 3:50:08 PM K:\WPB Design\040195061 TPK BB to LW\40614415201 Realign\roadway\plans\planrd20.DGN

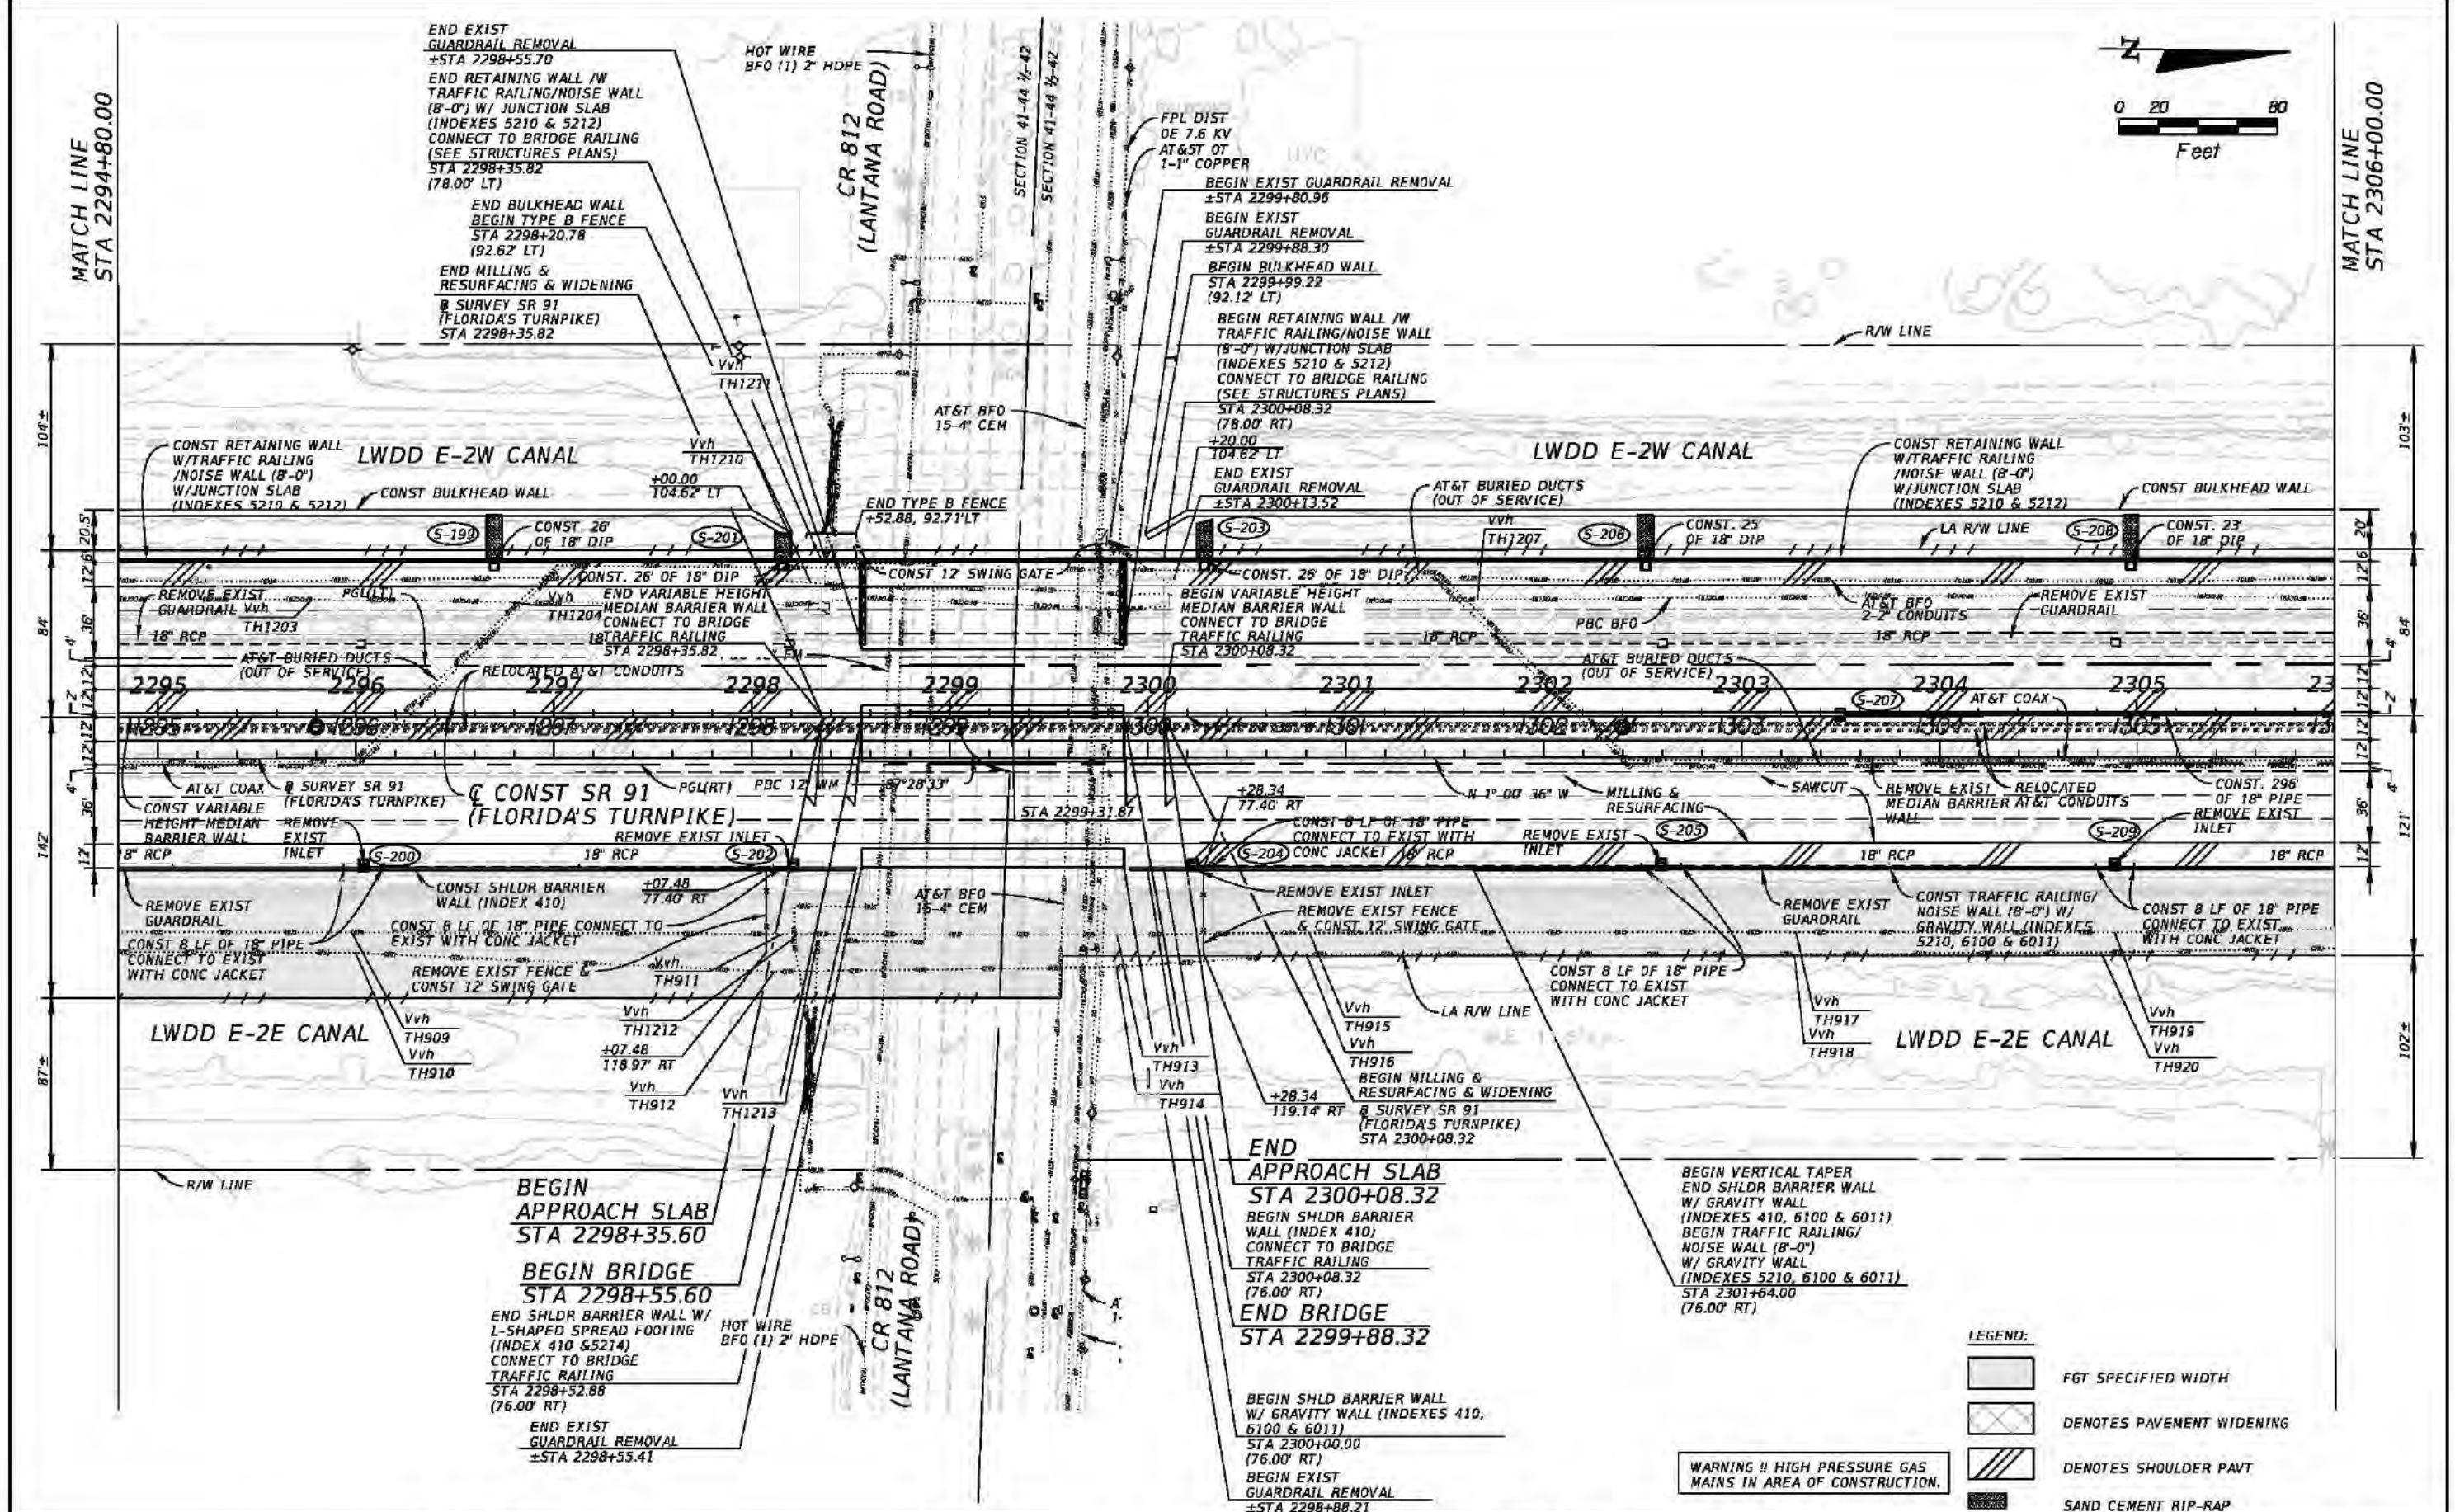


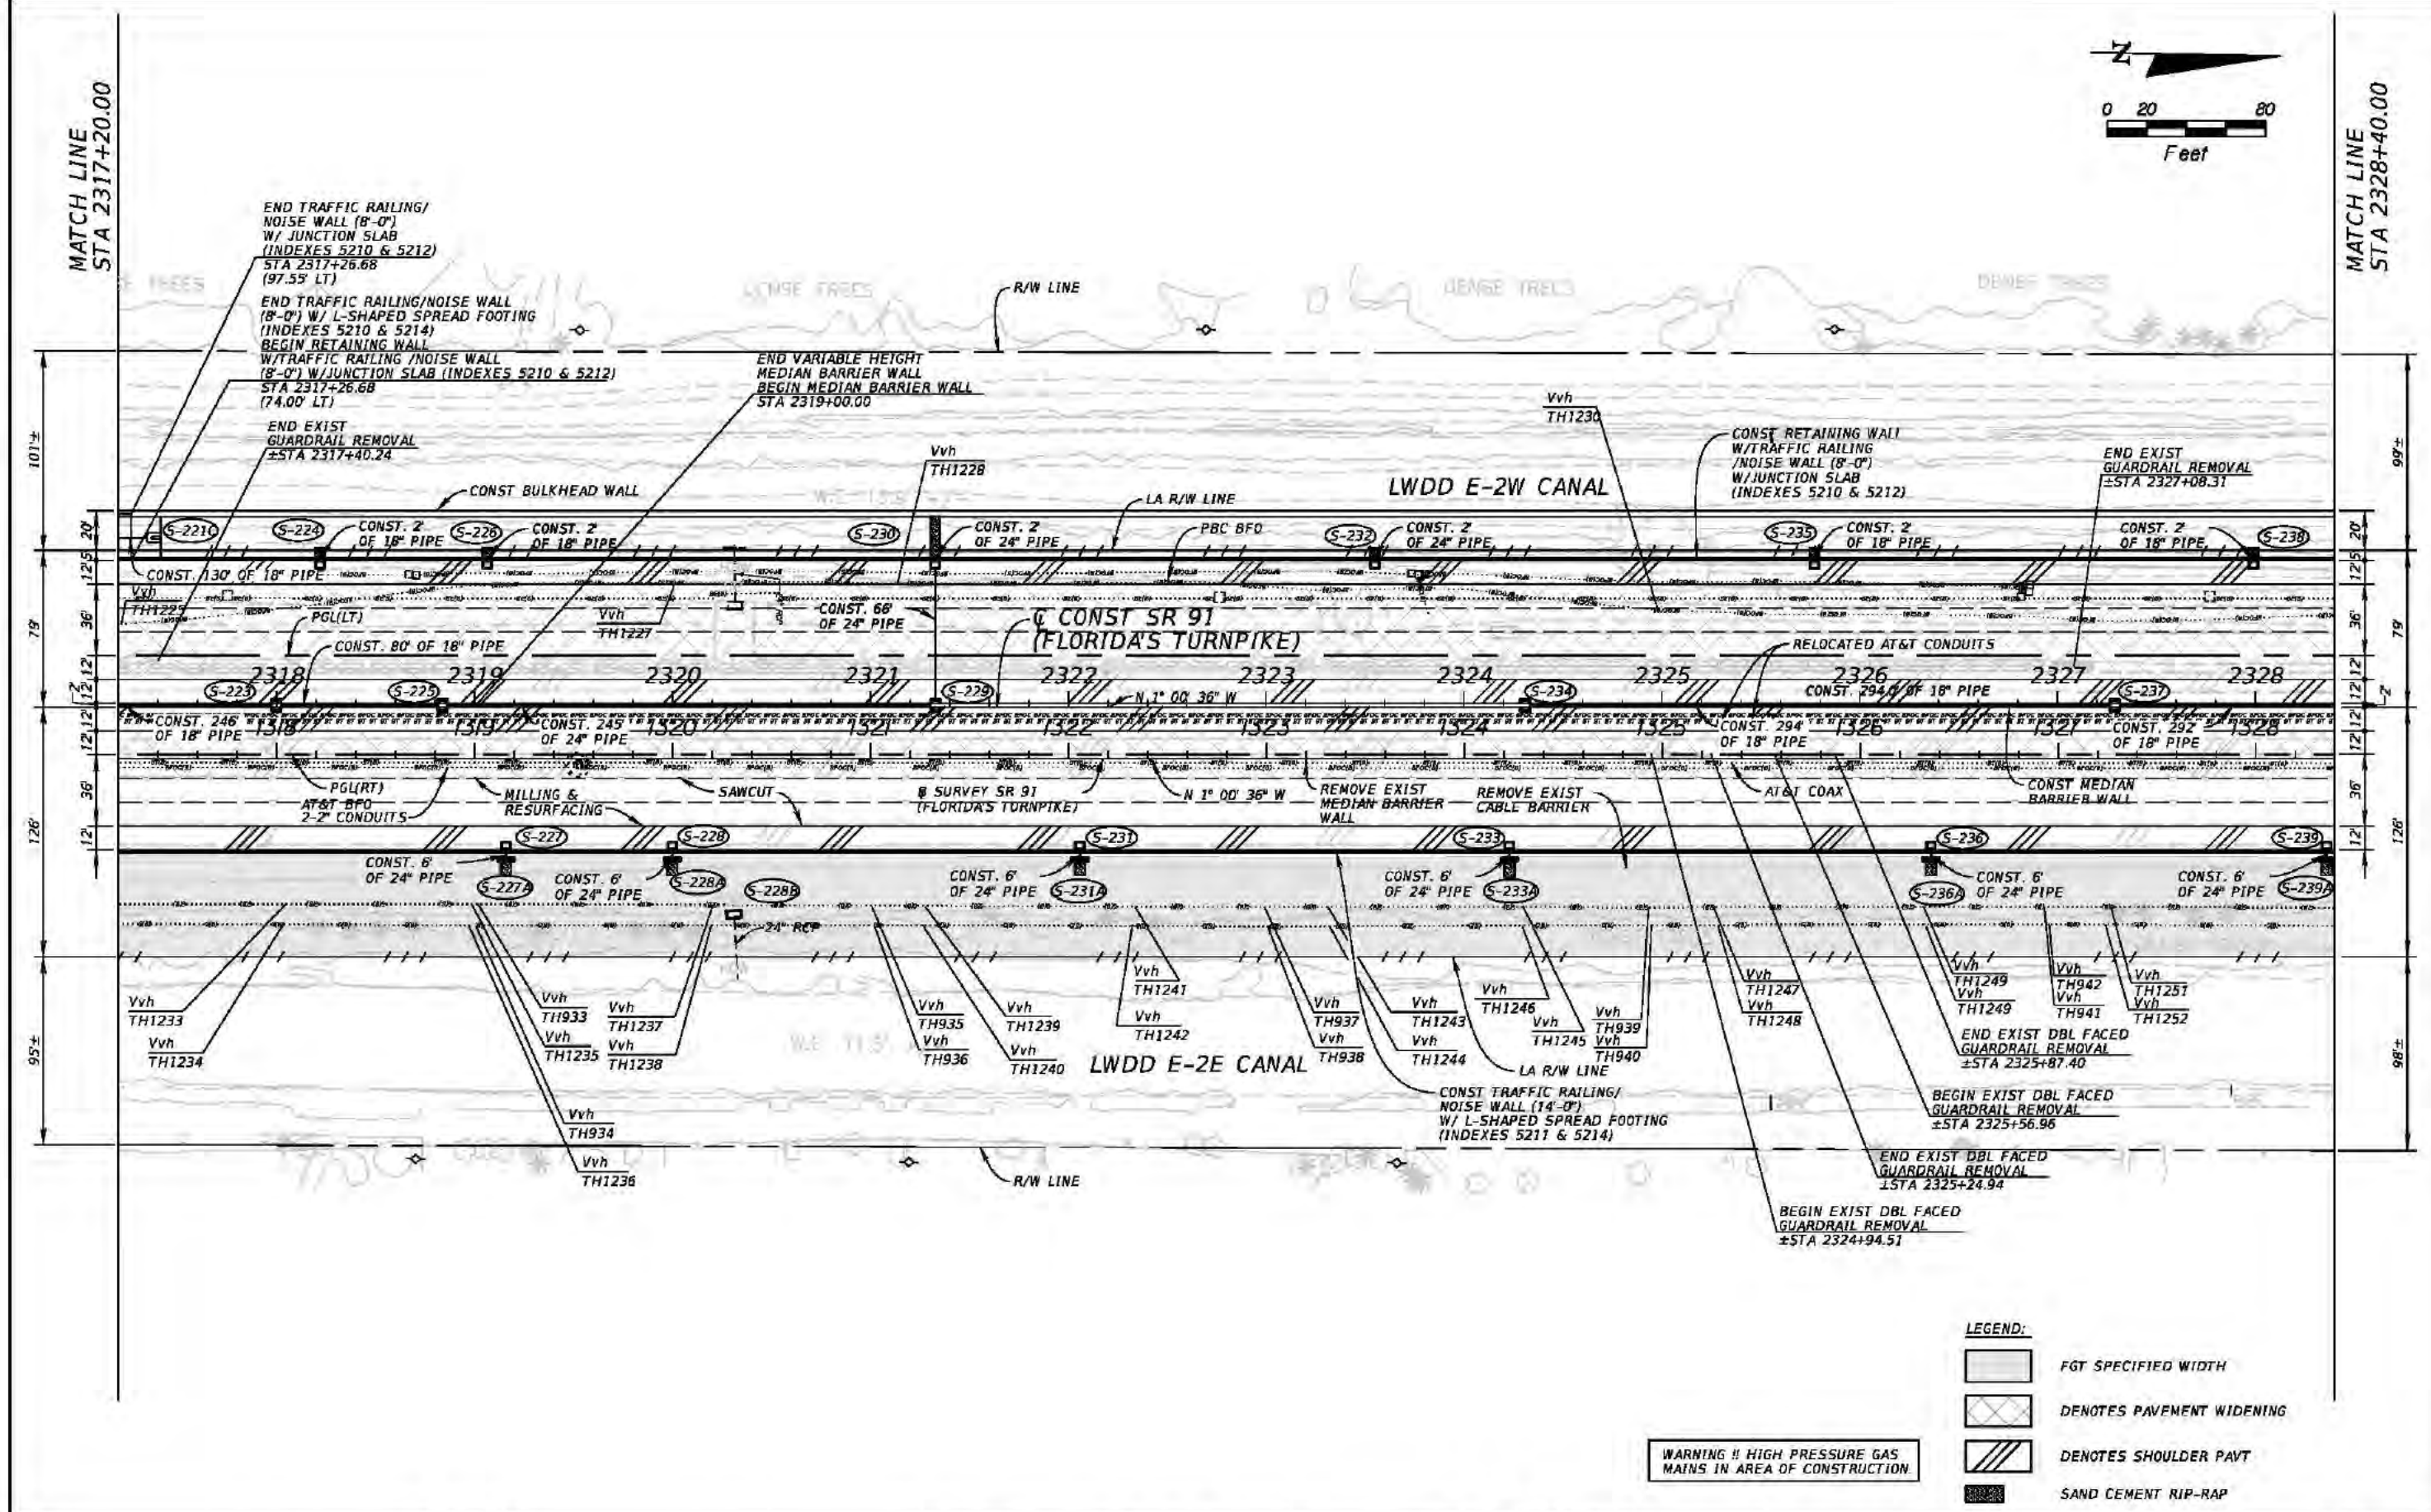

- LEGEND:
- [Pattern] FGT SPECIFIED WIDTH
 - [Pattern] DENOTES PAVEMENT WIDENING
 - [Pattern] DENOTES SHOULDER PAVT
 - [Pattern] SAND CEMENT RIP-RAP

WARNING !! HIGH PRESSURE GAS
MAINS IN AREA OF CONSTRUCTION.


REVISIONS				Kimley-Horn and Associates, Inc. Certificate Of Authorization No. 696 Hool Gin Ng, P.E. P.E. License No. 58123 1920 Wekiva Way, Suite 200 West Palm Beach, Florida 33411	STATE OF FLORIDA DEPARTMENT OF TRANSPORTATION			ROADWAY PLAN (22)	SHEET NO.
DATE	DESCRIPTION	DATE	DESCRIPTION		ROAD NO.	COUNTY	FINANCIAL PROJECT ID		
					SR 91	PALM BEACH	406144-1-52-01		77

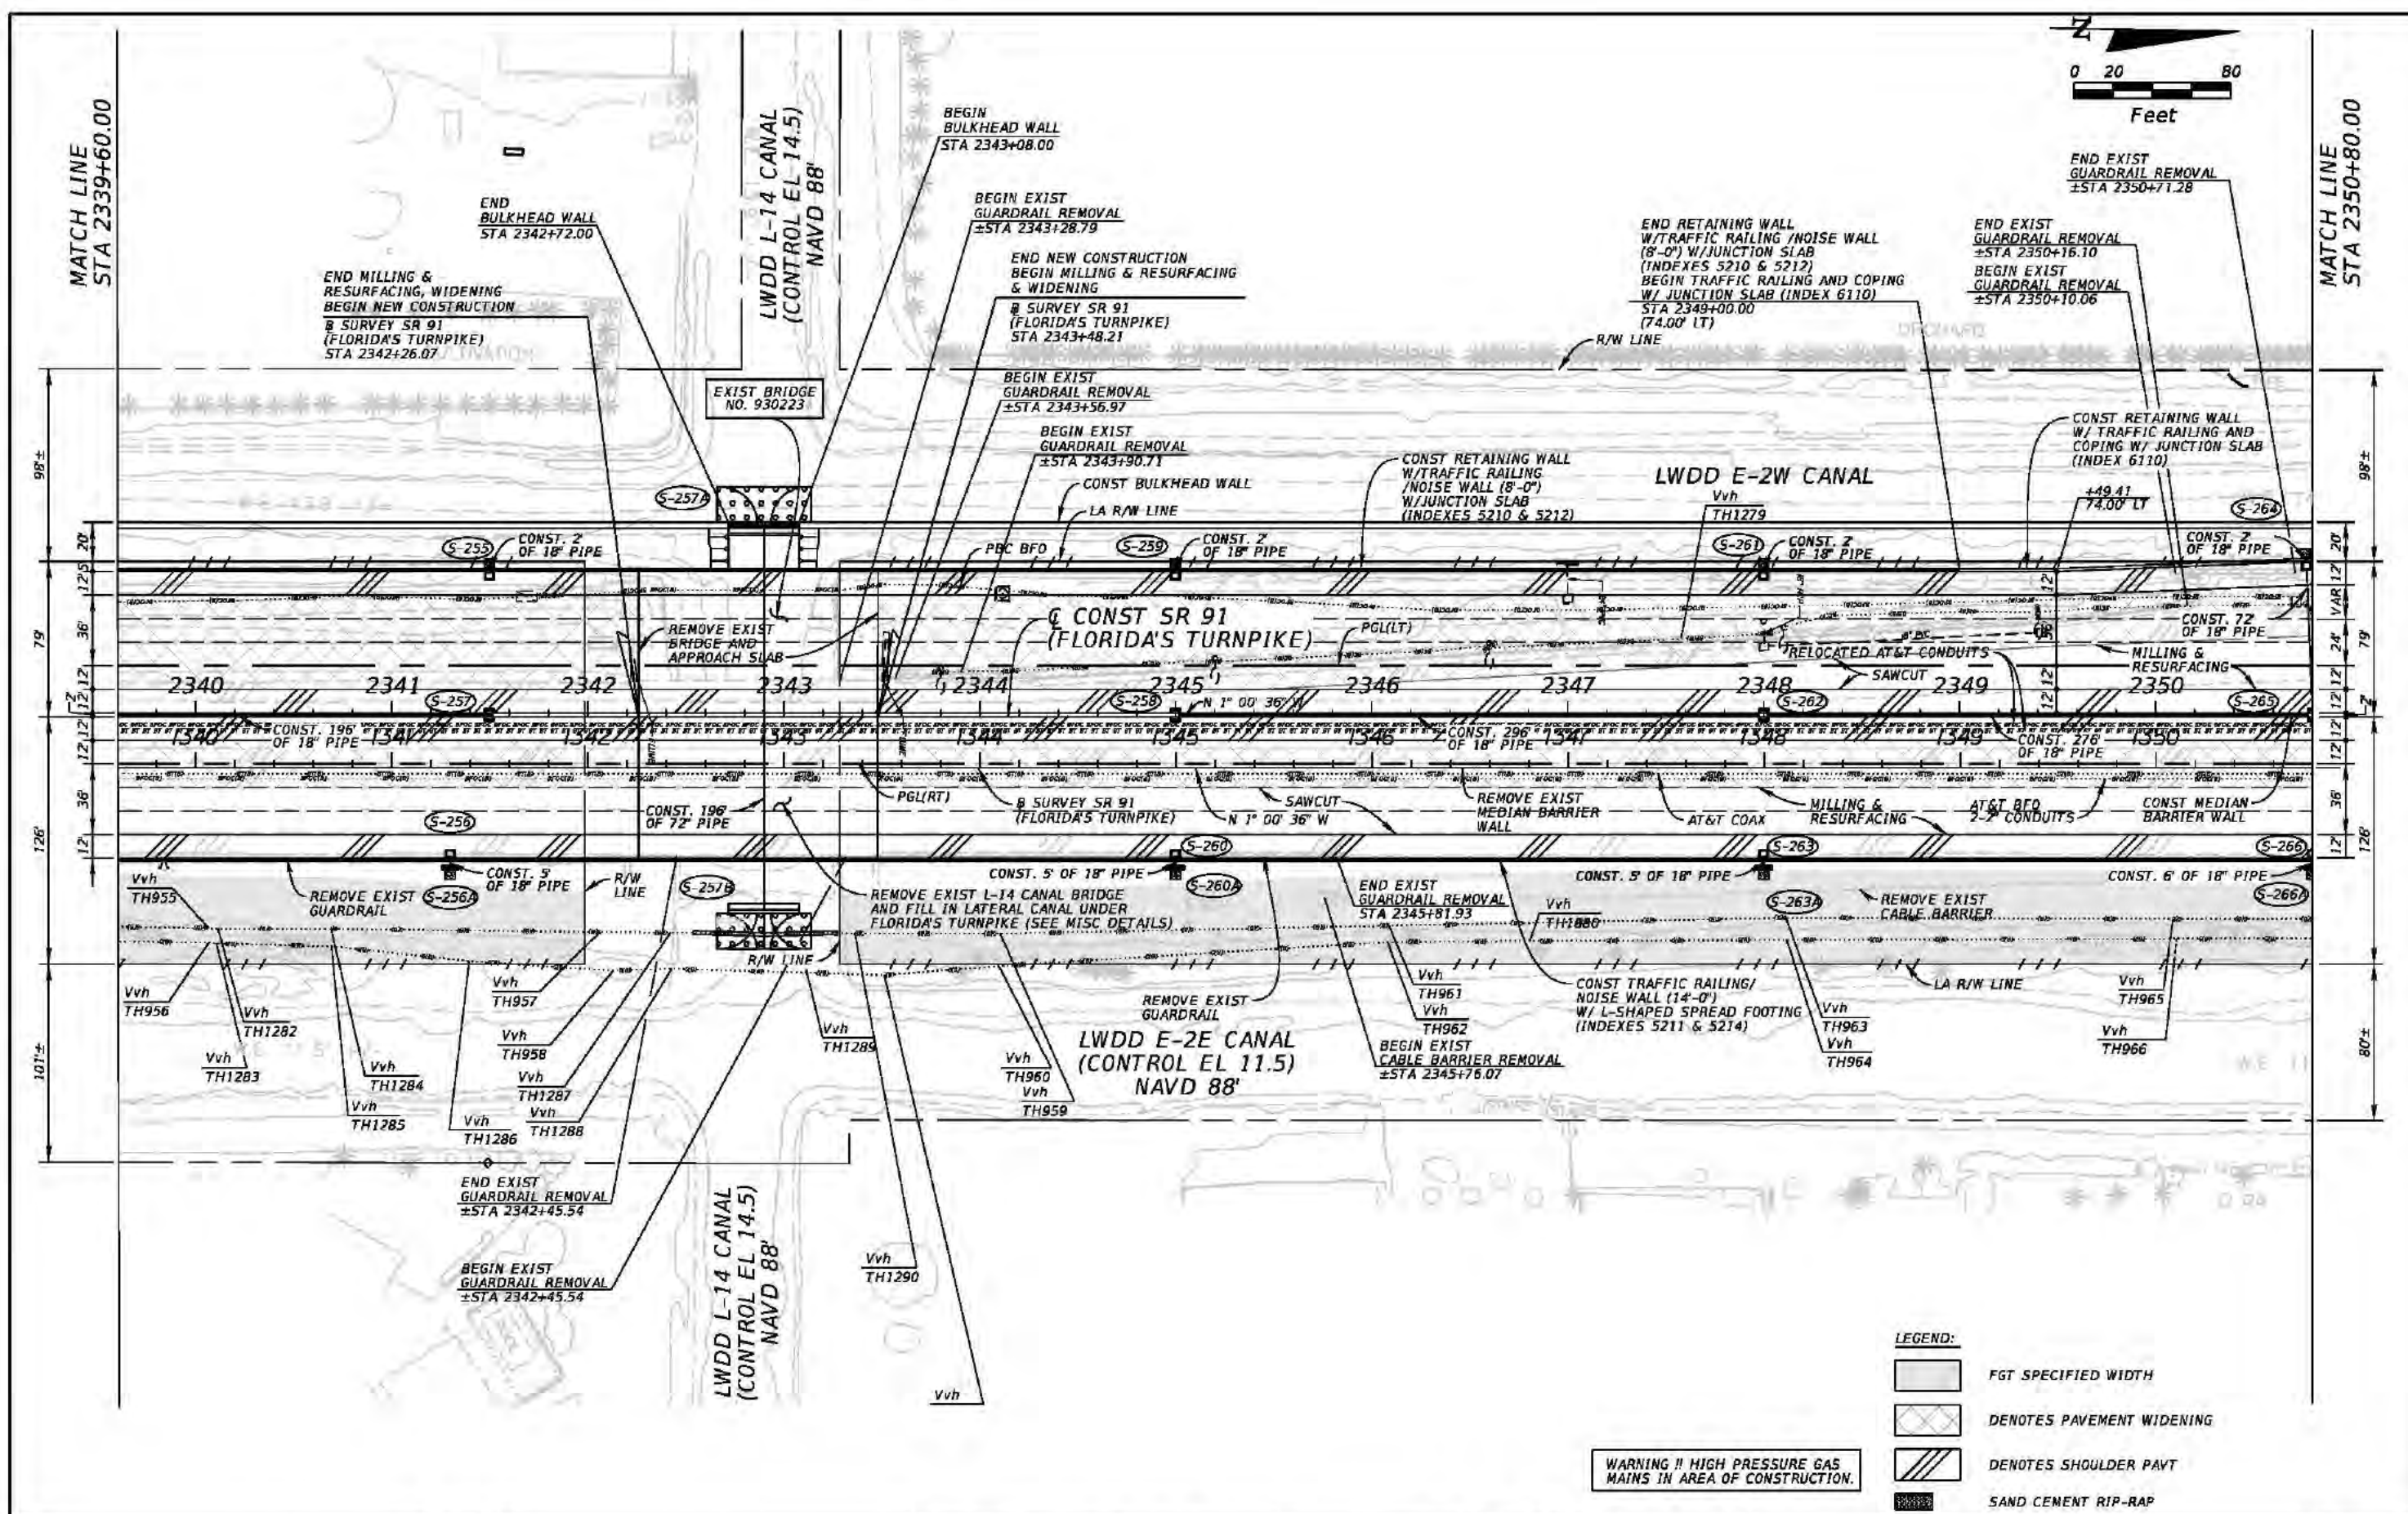


REVISIONS				Kimley-Horn and Associates, Inc. Certificate Of Authorization No. 696 Hool Gin Ng, P.E. P.E. License No. 58123 1920 Wekiva Way, Suite 200 West Palm Beach, Florida 33411	STATE OF FLORIDA DEPARTMENT OF TRANSPORTATION			ROADWAY PLAN (24)	SHEET NO.
DATE	DESCRIPTION	DATE	DESCRIPTION		ROAD NO.	COUNTY	FINANCIAL PROJECT ID		
					SR 91	PALM BEACH	406144-1-52-01		

MATCH LINE
STA 2350+80.00

SECTION 33-44-42
SECTION 28-44-42

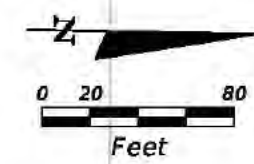



MATCH LINE
STA 2362+00.00

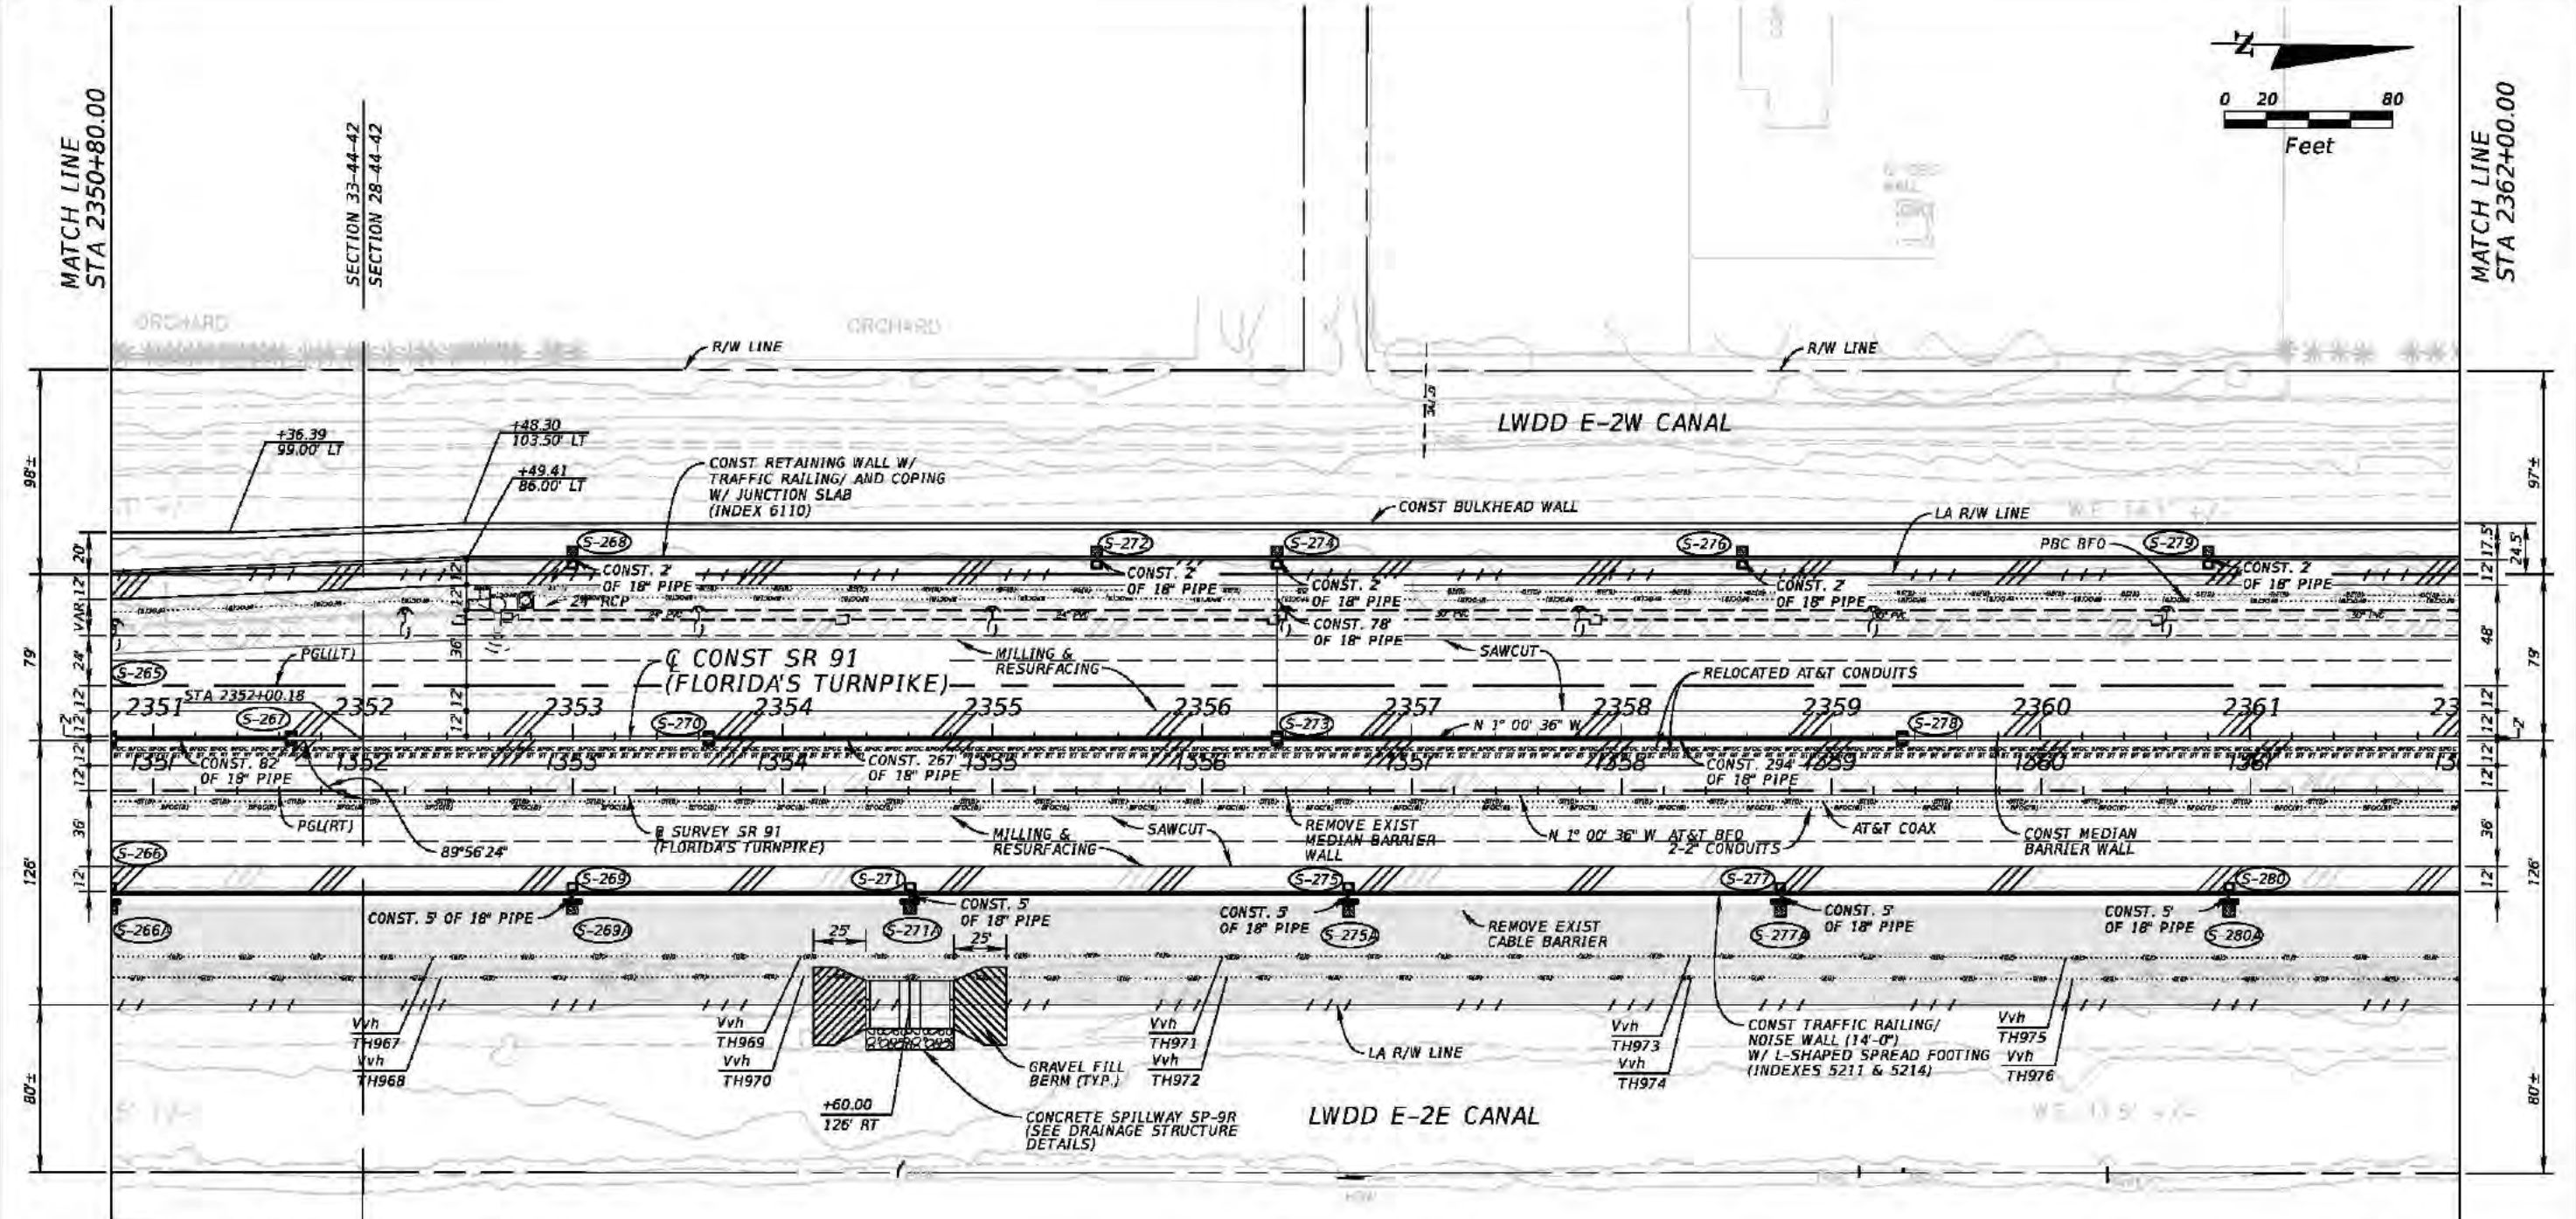

- LEGEND:
- [Pattern] FGT SPECIFIED WIDTH
 - [Pattern] DENOTES PAVEMENT WIDENING
 - [Pattern] DENOTES SHOULDER PAVT
 - [Pattern] SAND CEMENT RIP-RAP
- WARNING !! HIGH PRESSURE GAS MAINS IN AREA OF CONSTRUCTION.

REVISIONS				Kimley-Horn and Associates, Inc. Certificate Of Authorization No. 696 Hool Gin Ng, P.E. P.E. License No. 58123 1920 Wekiva Way, Suite 200 West Palm Beach, Florida 33411	STATE OF FLORIDA DEPARTMENT OF TRANSPORTATION			ROADWAY PLAN (25)	SHEET NO. 80
DATE	DESCRIPTION	DATE	DESCRIPTION		ROAD NO.	COUNTY	FINANCIAL PROJECT ID		
					SR 91	PALM BEACH	406144-1-52-01		

Rob Conklin 2/3/2017 3:50:39 PM K:\WPB_Design\040195061_TPK_BB_to_LW\40614415201_Realign\roadway\plans\planrd26.dgn

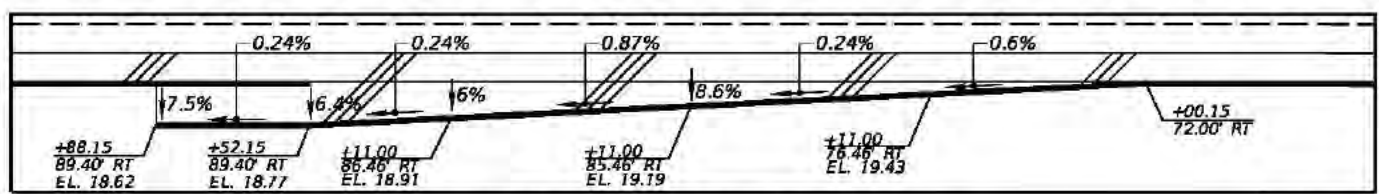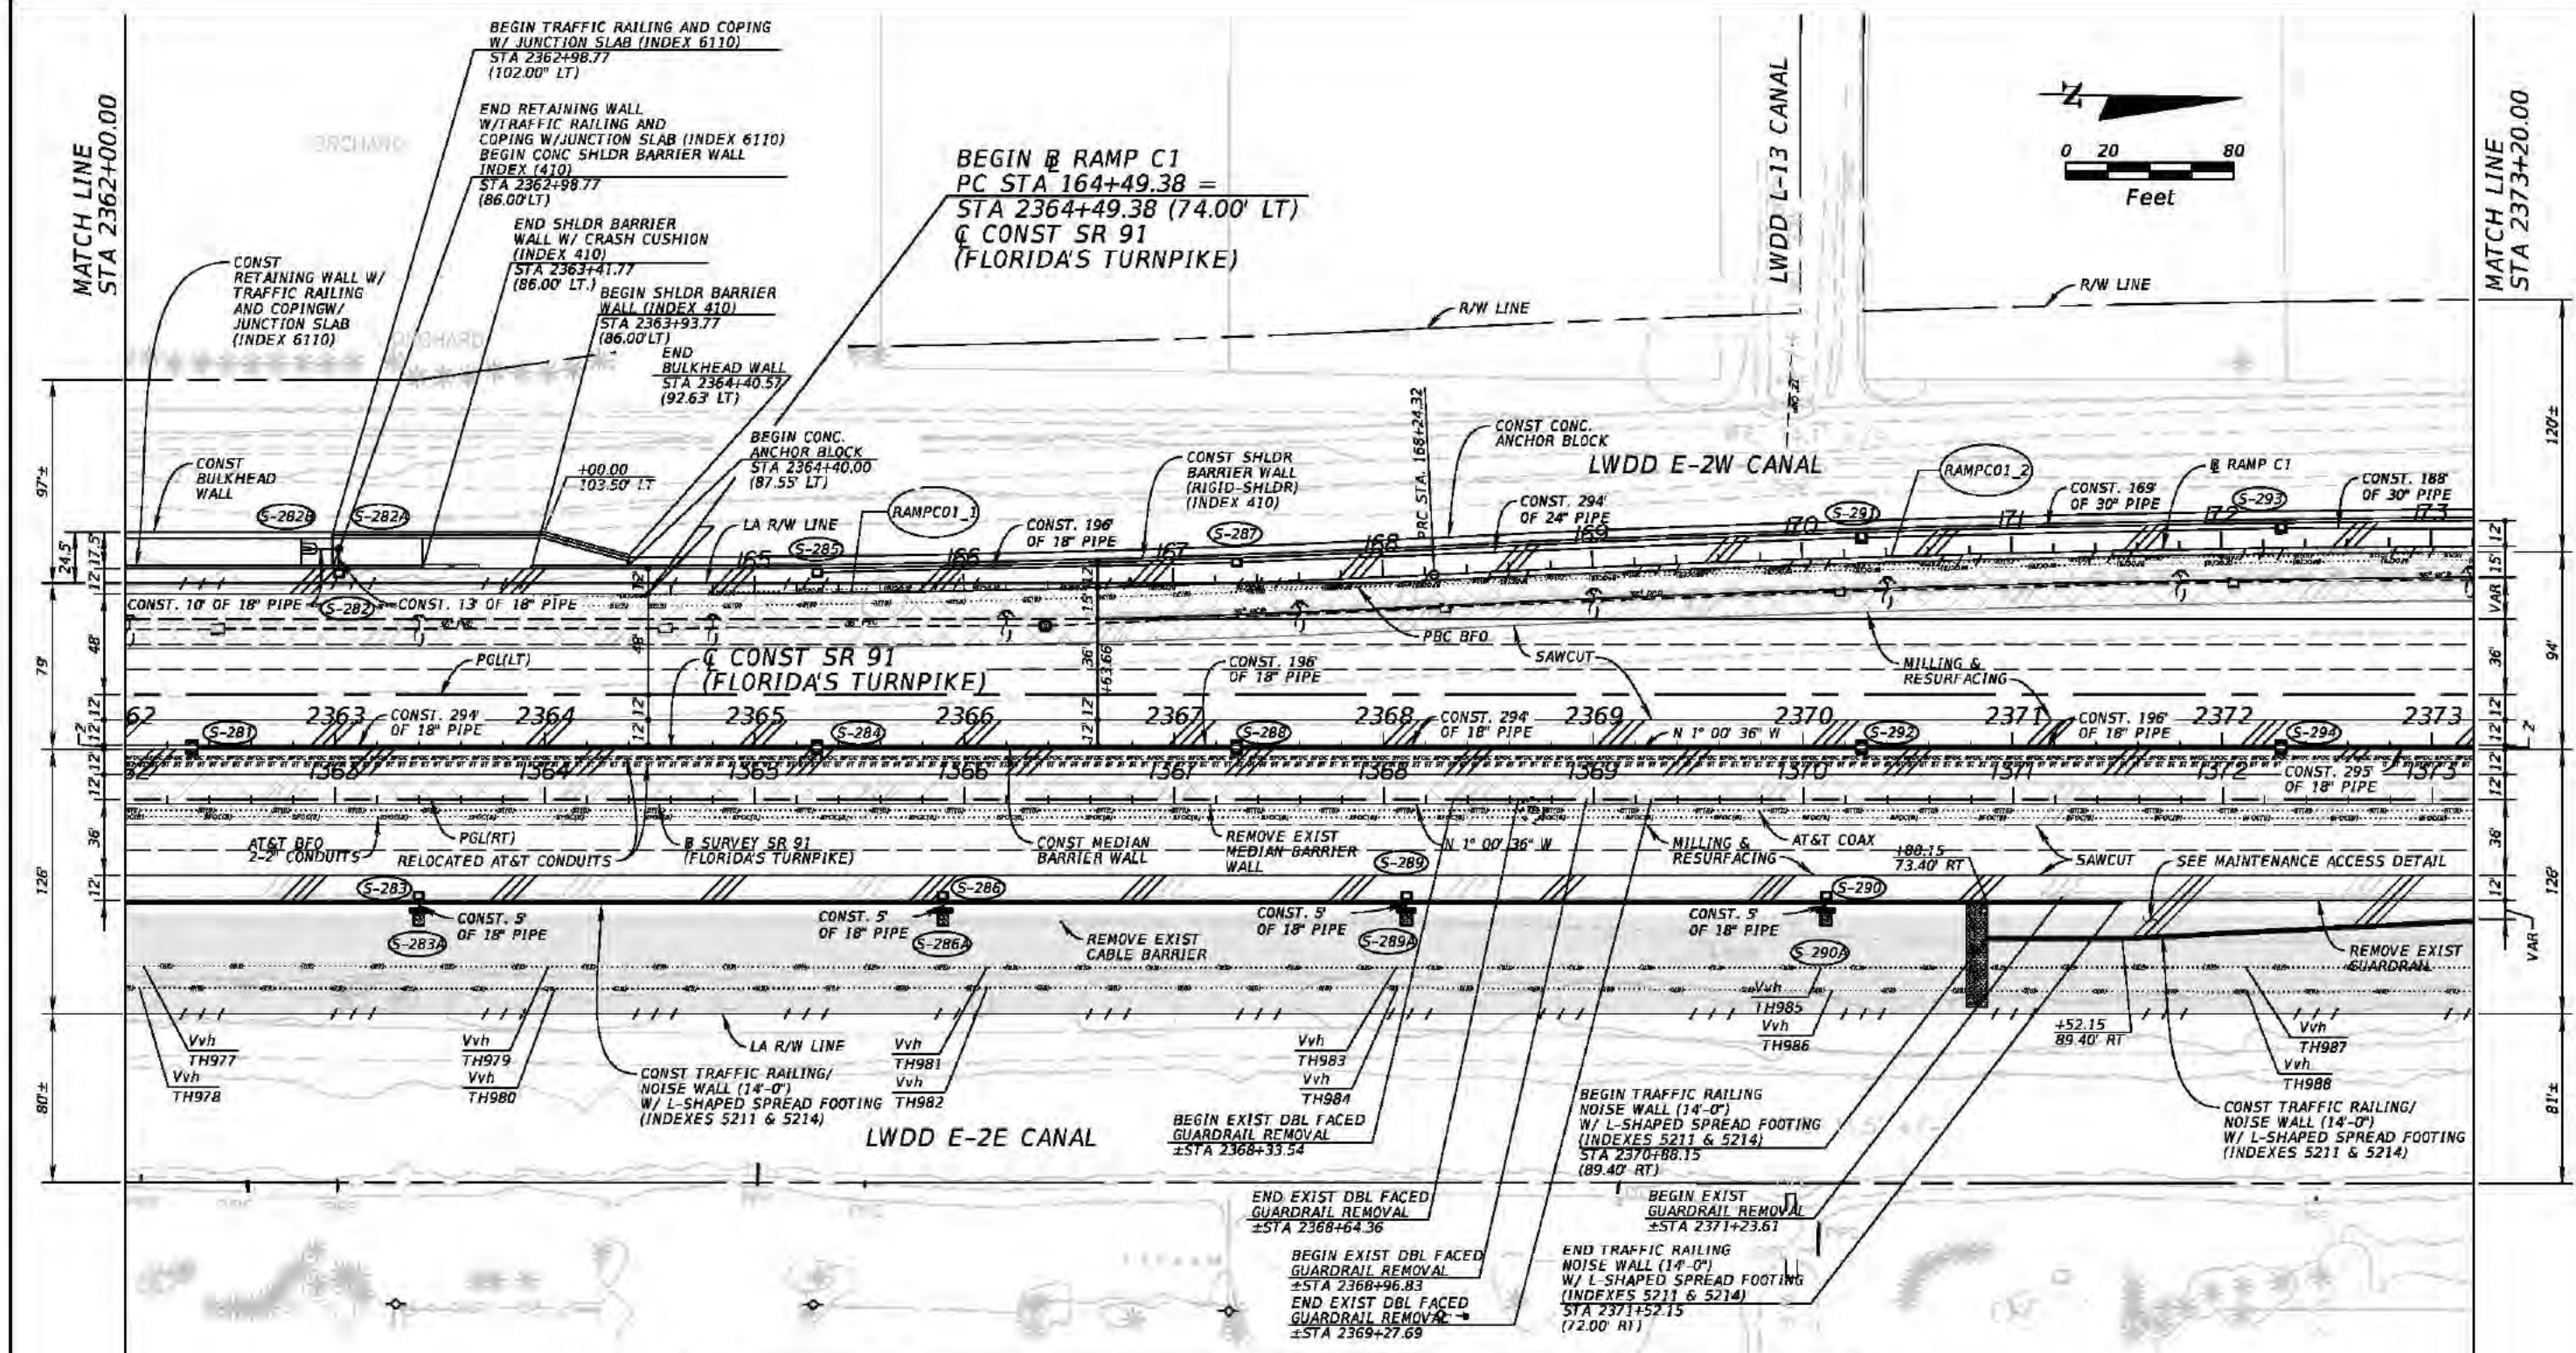


MAINTENANCE ACCESS DETAIL


WARNING !! HIGH PRESSURE GAS MAINS IN AREA OF CONSTRUCTION.

- LEGEND:
- F&T SPECIFIED WIDTH
 - DENOTES PAVEMENT WIDENING
 - DENOTES SHOULDER PAVT
 - SAND CEMENT RIP-RAP



REVISIONS				Kimley-Horn and Associates, Inc. Certificate Of Authorization No. 696 Hool Gin Ng, P.E. P.E. License No. 58123 1920 Wekiva Way, Suite 200 West Palm Beach, Florida 33411	STATE OF FLORIDA			ROADWAY PLAN (26)	SHEET NO. 81
DATE	DESCRIPTION	DATE	DESCRIPTION		ROAD NO.	COUNTY	FINANCIAL PROJECT ID		
					SR 91	PALM BEACH	406144-1-52-01		

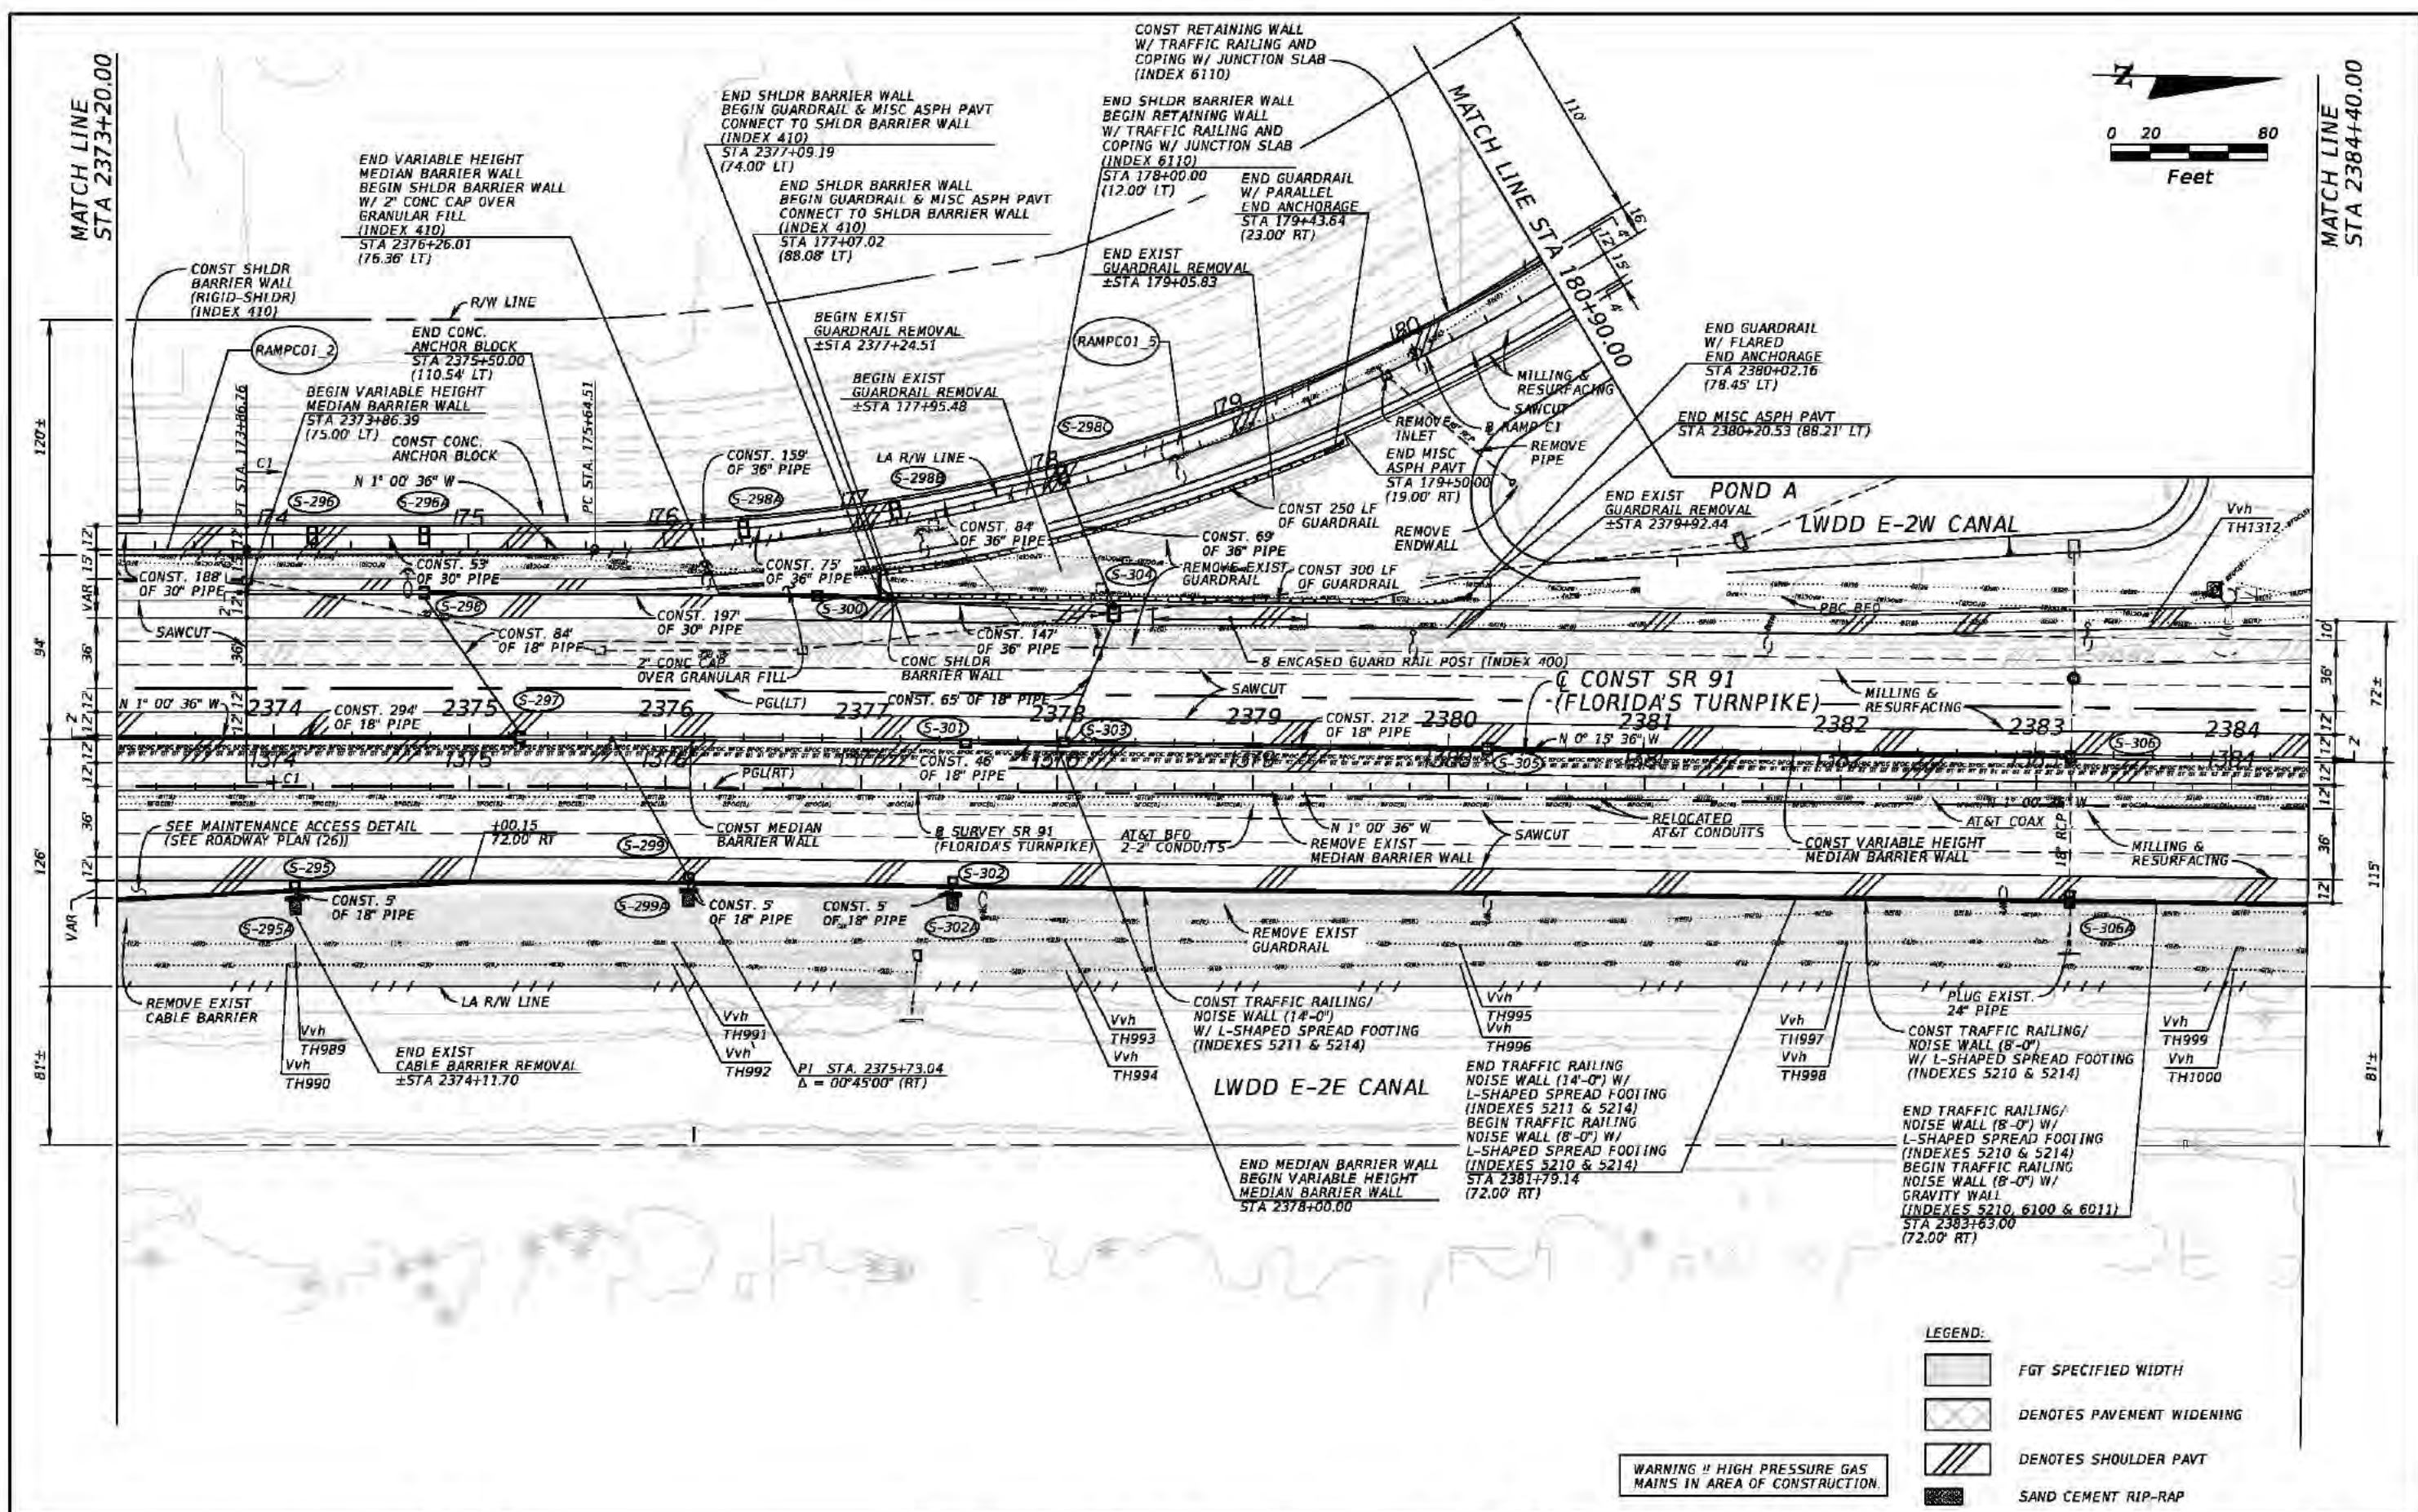

REVISIONS				Kimley-Horn and Associates, Inc. Certificate Of Authorization No. 696 Hool Gin Ng, P.E. P.E. License No. 58123 1920 Wekiva Way, Suite 200 West Palm Beach, Florida 33411	STATE OF FLORIDA DEPARTMENT OF TRANSPORTATION			ROADWAY PLAN (27)	SHEET NO. 82
DATE	DESCRIPTION	DATE	DESCRIPTION		ROAD NO.	COUNTY	FINANCIAL PROJECT ID		
					SR 91	PALM BEACH	406144-1-52-01		

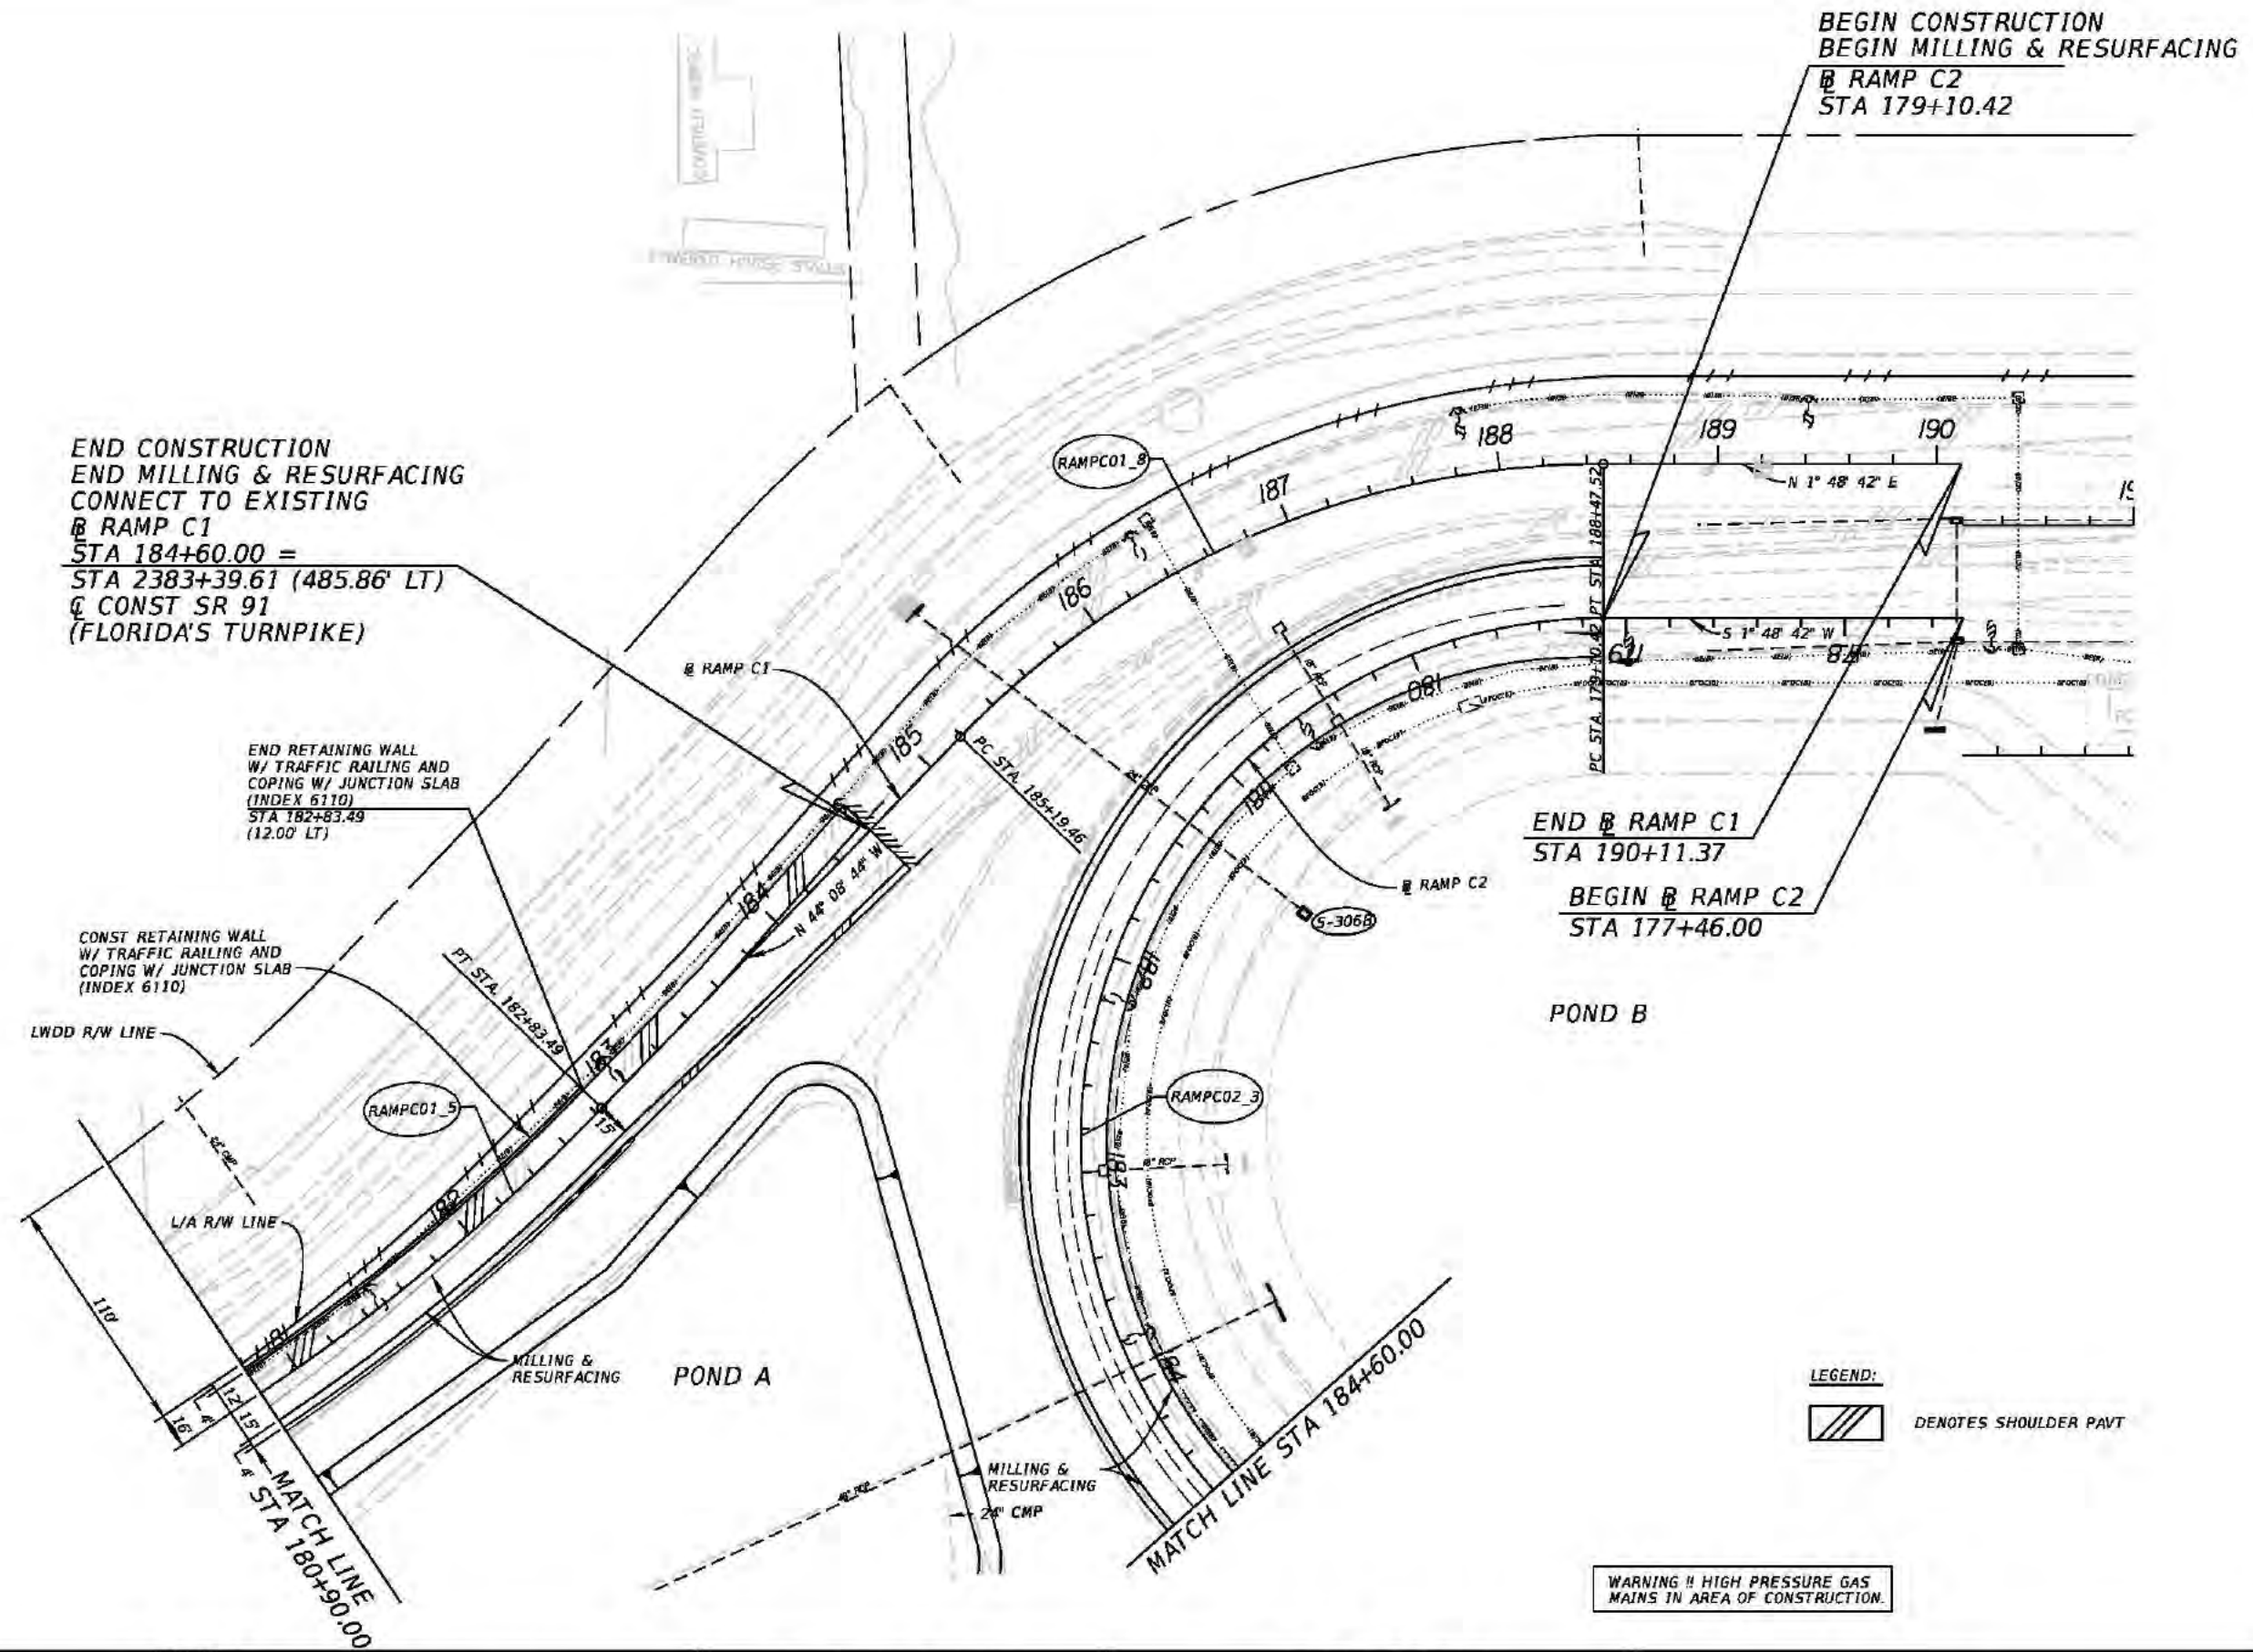

REVISIONS				Kimley-Horn and Associates, Inc. Certificate Of Authorization No. 696 Hool Gin Ng, P.E. P.E. License No. 58123 1920 Wekiva Way, Suite 200 West Palm Beach, Florida 33411	STATE OF FLORIDA DEPARTMENT OF TRANSPORTATION			ROADWAY PLAN (28) SHEET NO. 83
DATE	DESCRIPTION	DATE	DESCRIPTION		ROAD NO.	COUNTY	FINANCIAL PROJECT ID	
					SR 91	PALM BEACH	406144-1-52-01	

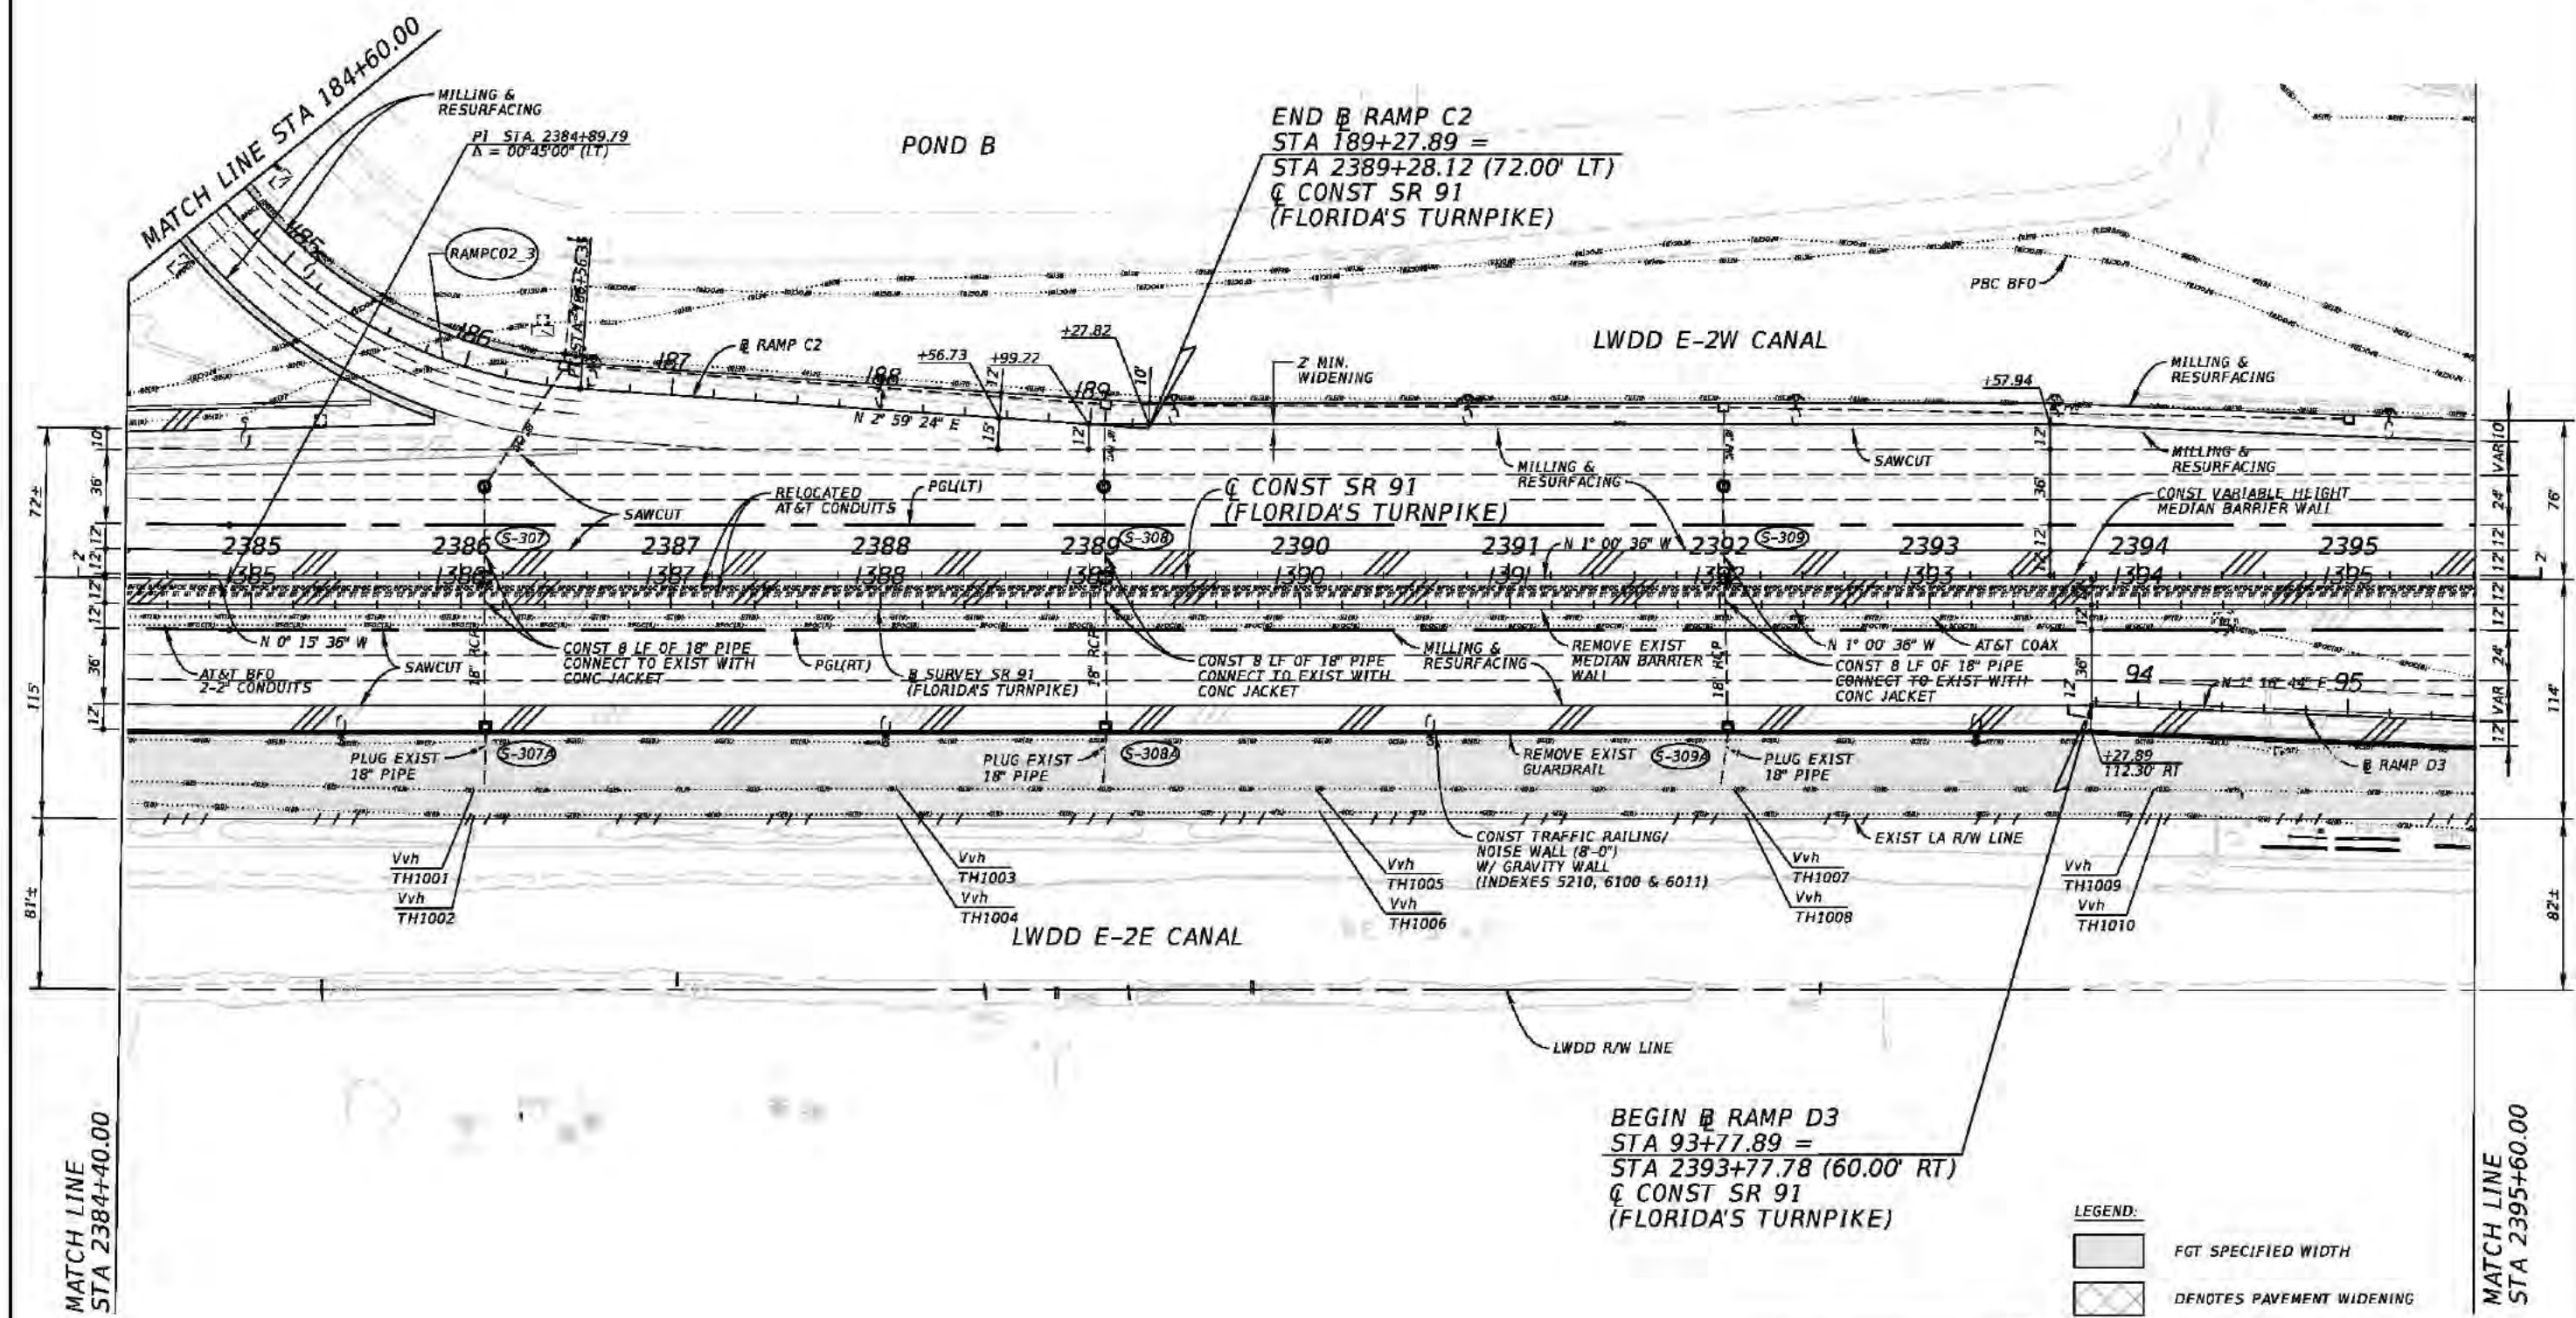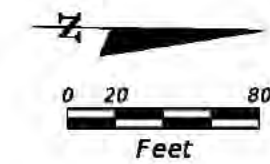


- LEGEND:
- [Pattern] FGT SPECIFIED WIDTH
 - [Pattern] DENOTES PAVEMENT WIDENING
 - [Pattern] DENOTES SHOULDER PAVT
 - [Pattern] SAND CEMENT RIP-RAP


WARNING !! HIGH PRESSURE GAS
MAINS IN AREA OF CONSTRUCTION.

REVISIONS				Kimley-Horn and Associates, Inc. Certificate Of Authorization No. 696 Hool Gin Ng, P.E. P.E. License No. 58123 1920 Wekiva Way, Suite 200 West Palm Beach, Florida 33411	STATE OF FLORIDA DEPARTMENT OF TRANSPORTATION			ROADWAY PLAN (29)	SHEET NO. 84
DATE	DESCRIPTION	DATE	DESCRIPTION		ROAD NO.	COUNTY	FINANCIAL PROJECT ID		
					SR 91	PALM BEACH	406144-1-52-01		

Rob Conklin 2/3/2017 3:50:57 PM K:\WPB_Design\040195061_TPK_BB_to_LW\40614415201_Realign\roadway\plans\planrd29.dgn

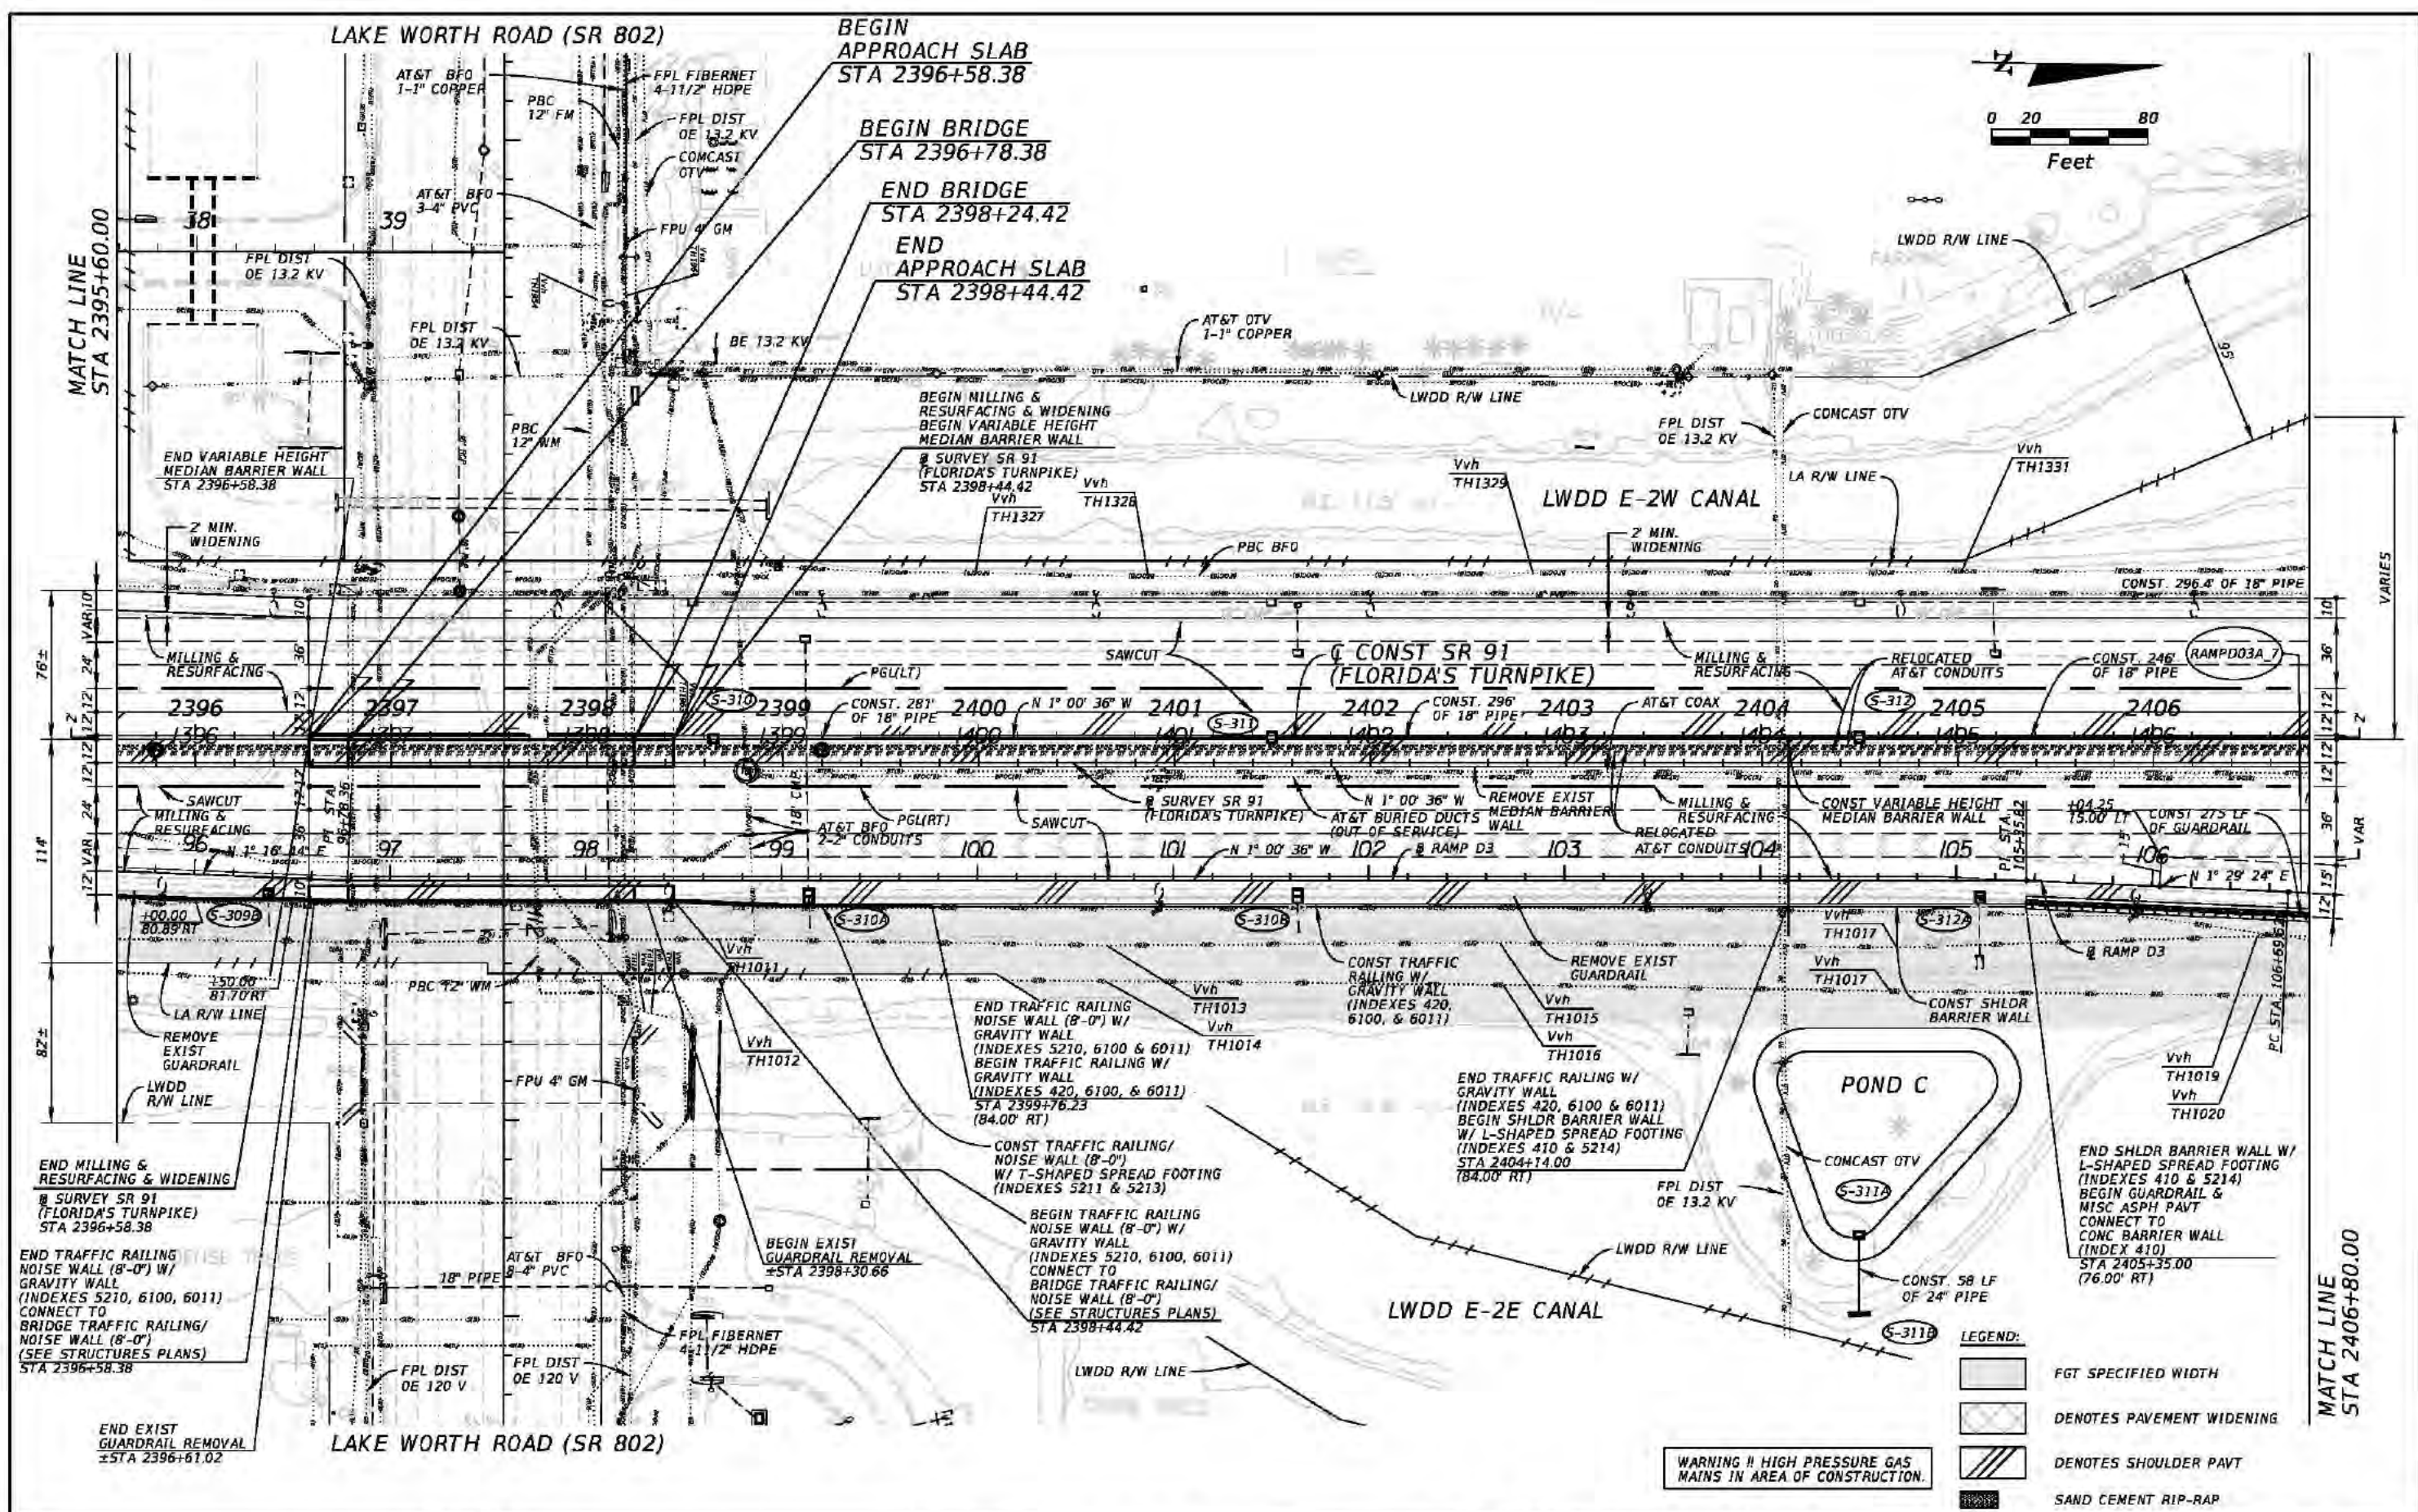

REVISIONS				Kimley-Horn and Associates, Inc. Certificate Of Authorization No. 696 Hool Gin Ng, P.E. P.E. License No. 58123 1920 Wekiva Way, Suite 200 West Palm Beach, Florida 33411	STATE OF FLORIDA DEPARTMENT OF TRANSPORTATION			ROADWAY PLAN (30)	SHEET NO.
DATE	DESCRIPTION	DATE	DESCRIPTION		ROAD NO.	COUNTY	FINANCIAL PROJECT ID		
					SR 91	PALM BEACH	406144-1-52-01		85

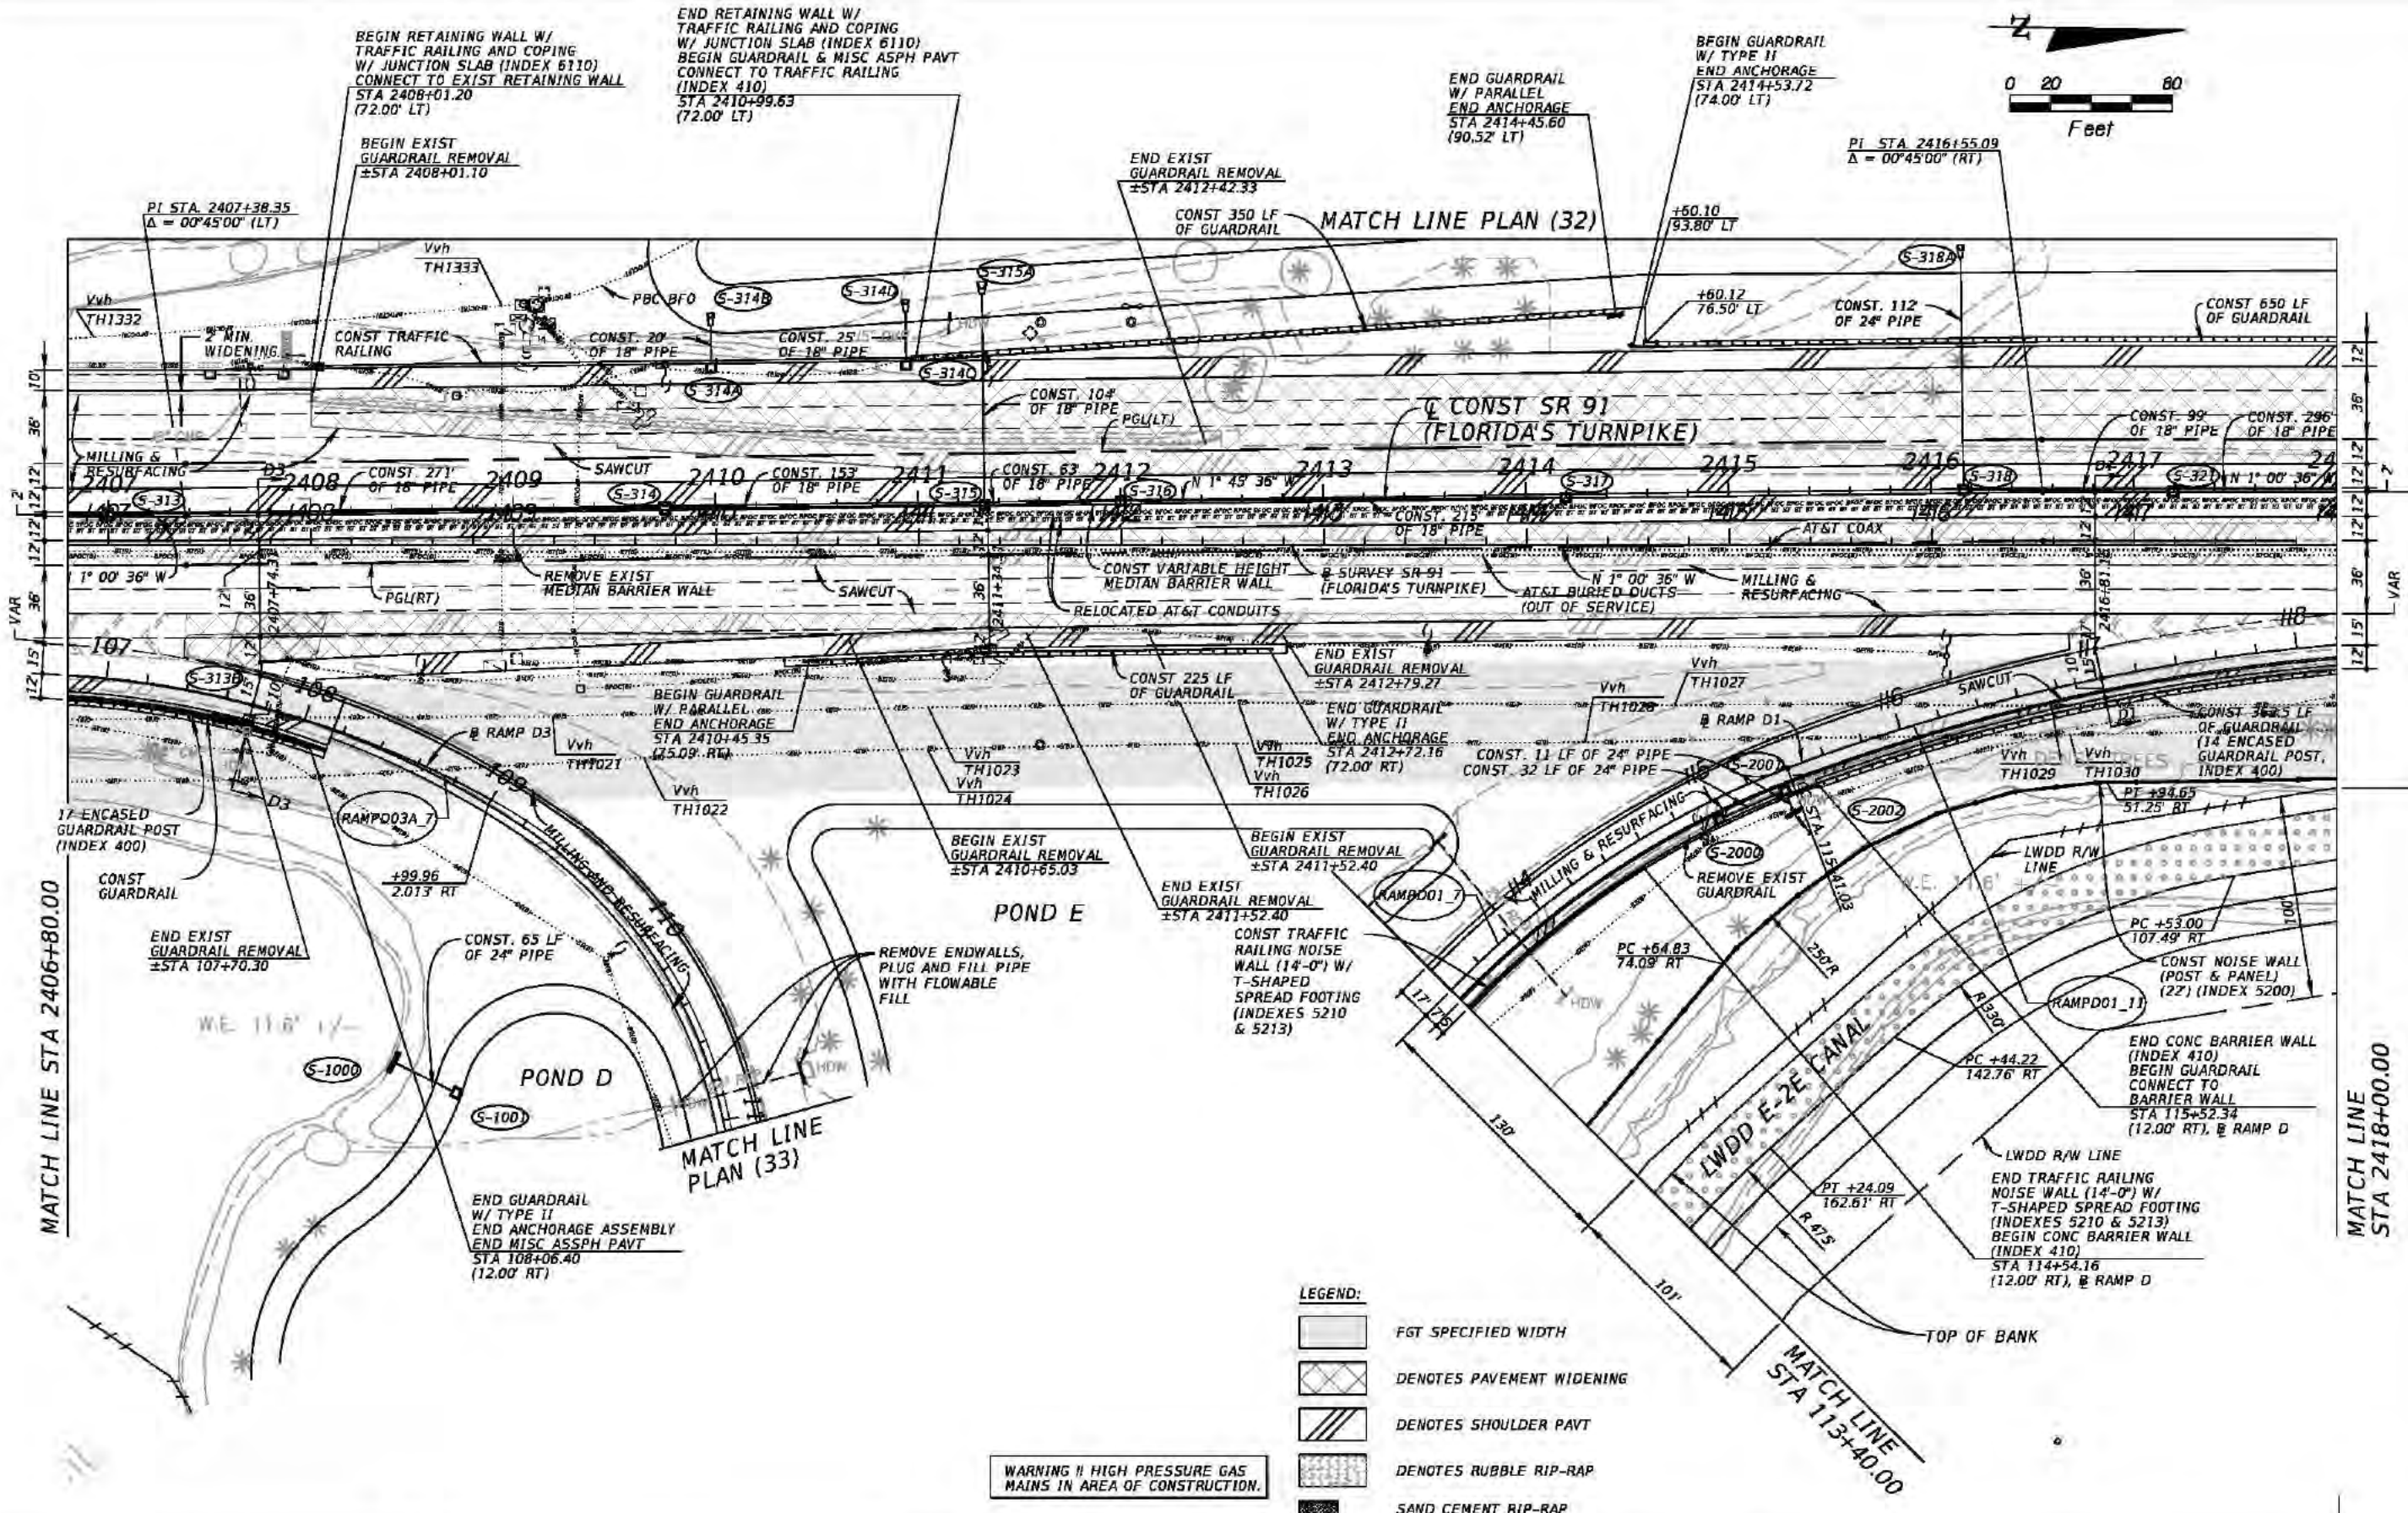

BEGIN RETAINING WALL W/
TRAFFIC RAILING AND COPING
W/ JUNCTION SLAB (INDEX 6110)
CONNECT TO EXIST RETAINING WALL
STA 2408+01.20
(72.00' LT)


BEGIN EXIST
GUARDRAIL REMOVAL
±STA 2408+01.10

END RETAINING WALL W/
TRAFFIC RAILING AND COPING
W/ JUNCTION SLAB (INDEX 6110)
BEGIN GUARDRAIL & MISC ASPH PAVT
CONNECT TO TRAFFIC RAILING
(INDEX 410)
STA 2410+99.63
(72.00' LT)

END GUARDRAIL
W/ PARALLEL
END ANCHORAGE
STA 2414+45.60
(90.52' LT)

BEGIN GUARDRAIL
W/ TYPE II
END ANCHORAGE
STA 2414+53.72
(74.00' LT)

PI STA 2416+55.09
Δ = 00°45'00" (RT)

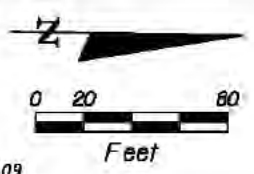

MATCH LINE PLAN (32)

CONST SR 91
(FLORIDA'S TURNPIKE)

CONST SR 91
(FLORIDA'S TURNPIKE)

POND E



POND D

MATCH LINE
PLAN (33)

MATCH LINE STA 2406+80.00


MATCH LINE
STA 2418+00.00

MATCH LINE
STA 113+40.00

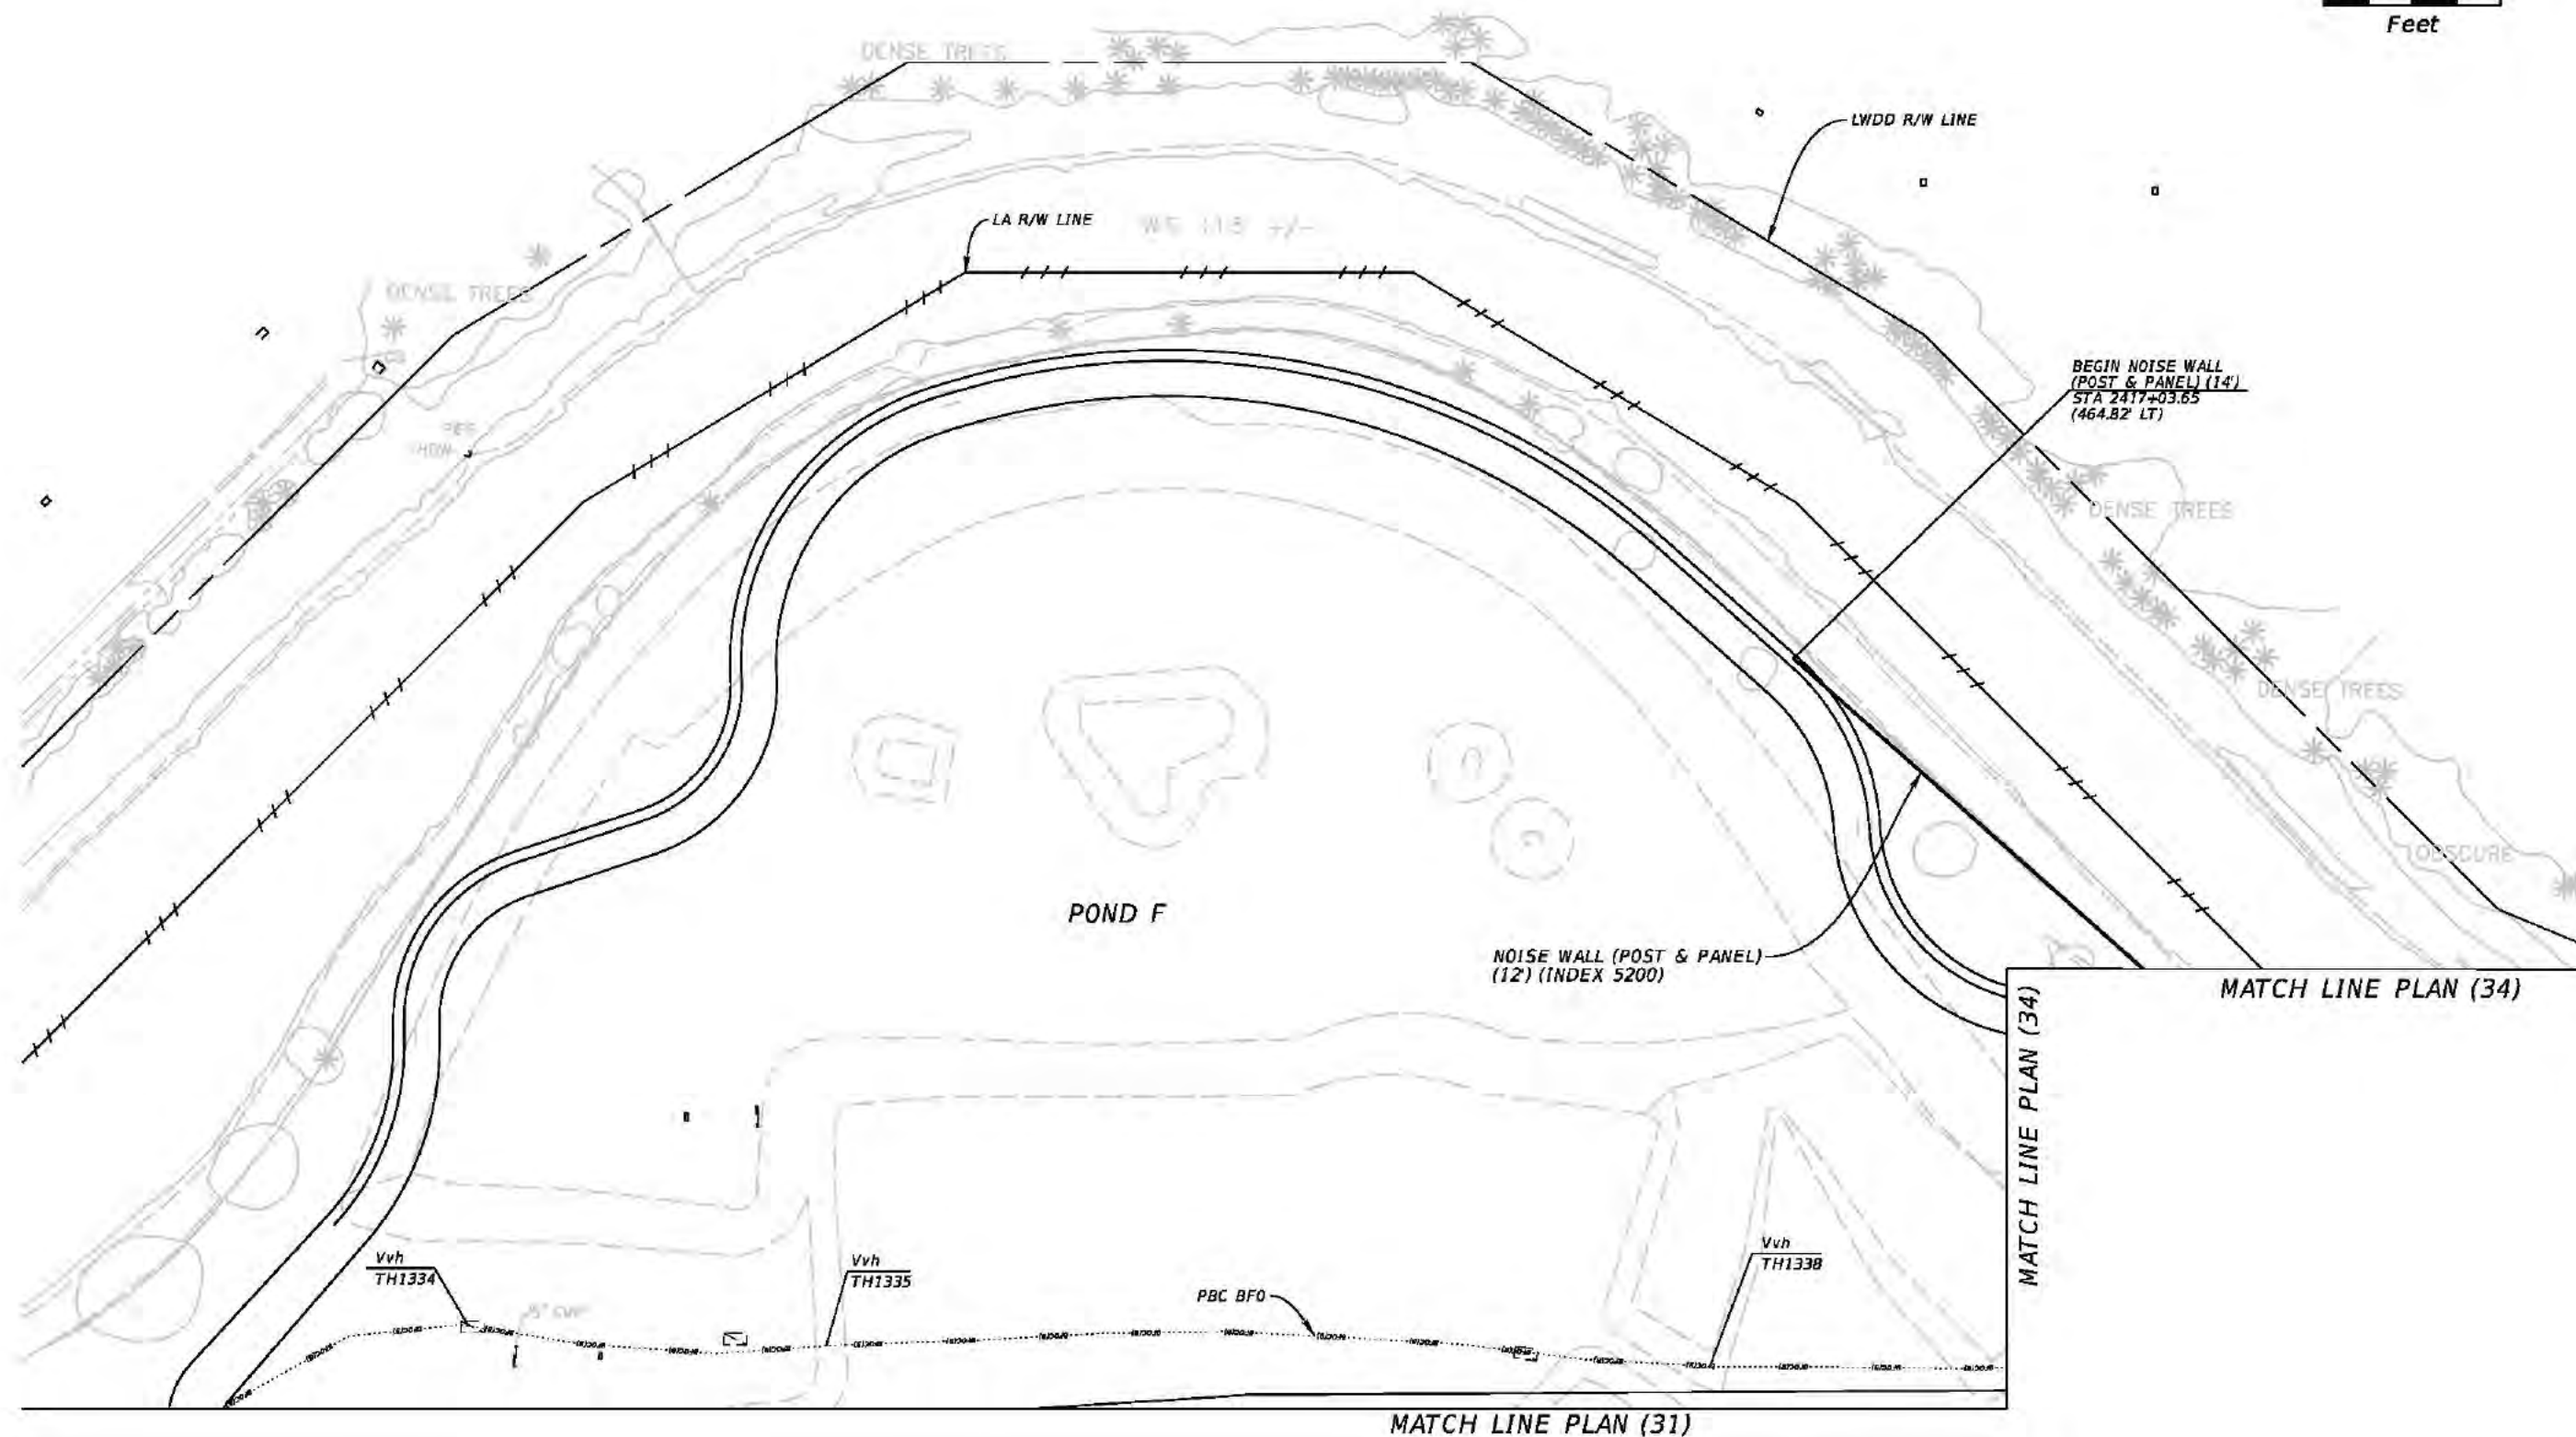
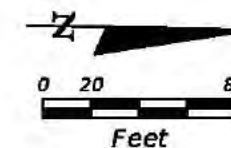


WARNING !! HIGH PRESSURE GAS
MAINS IN AREA OF CONSTRUCTION.

REVISIONS				Kimley-Horn and Associates, Inc. Certificate Of Authorization No. 696 Hooi Gin Ng, P.E. P.E. License No. 58123 1920 Wekiva Way, Suite 200 West Palm Beach, Florida 33411	STATE OF FLORIDA DEPARTMENT OF TRANSPORTATION			ROADWAY PLAN (32)	SHEET NO.
DATE	DESCRIPTION	DATE	DESCRIPTION		ROAD NO.	COUNTY	FINANCIAL PROJECT ID		87
					SR 91	PALM BEACH	406144-1-52-01		

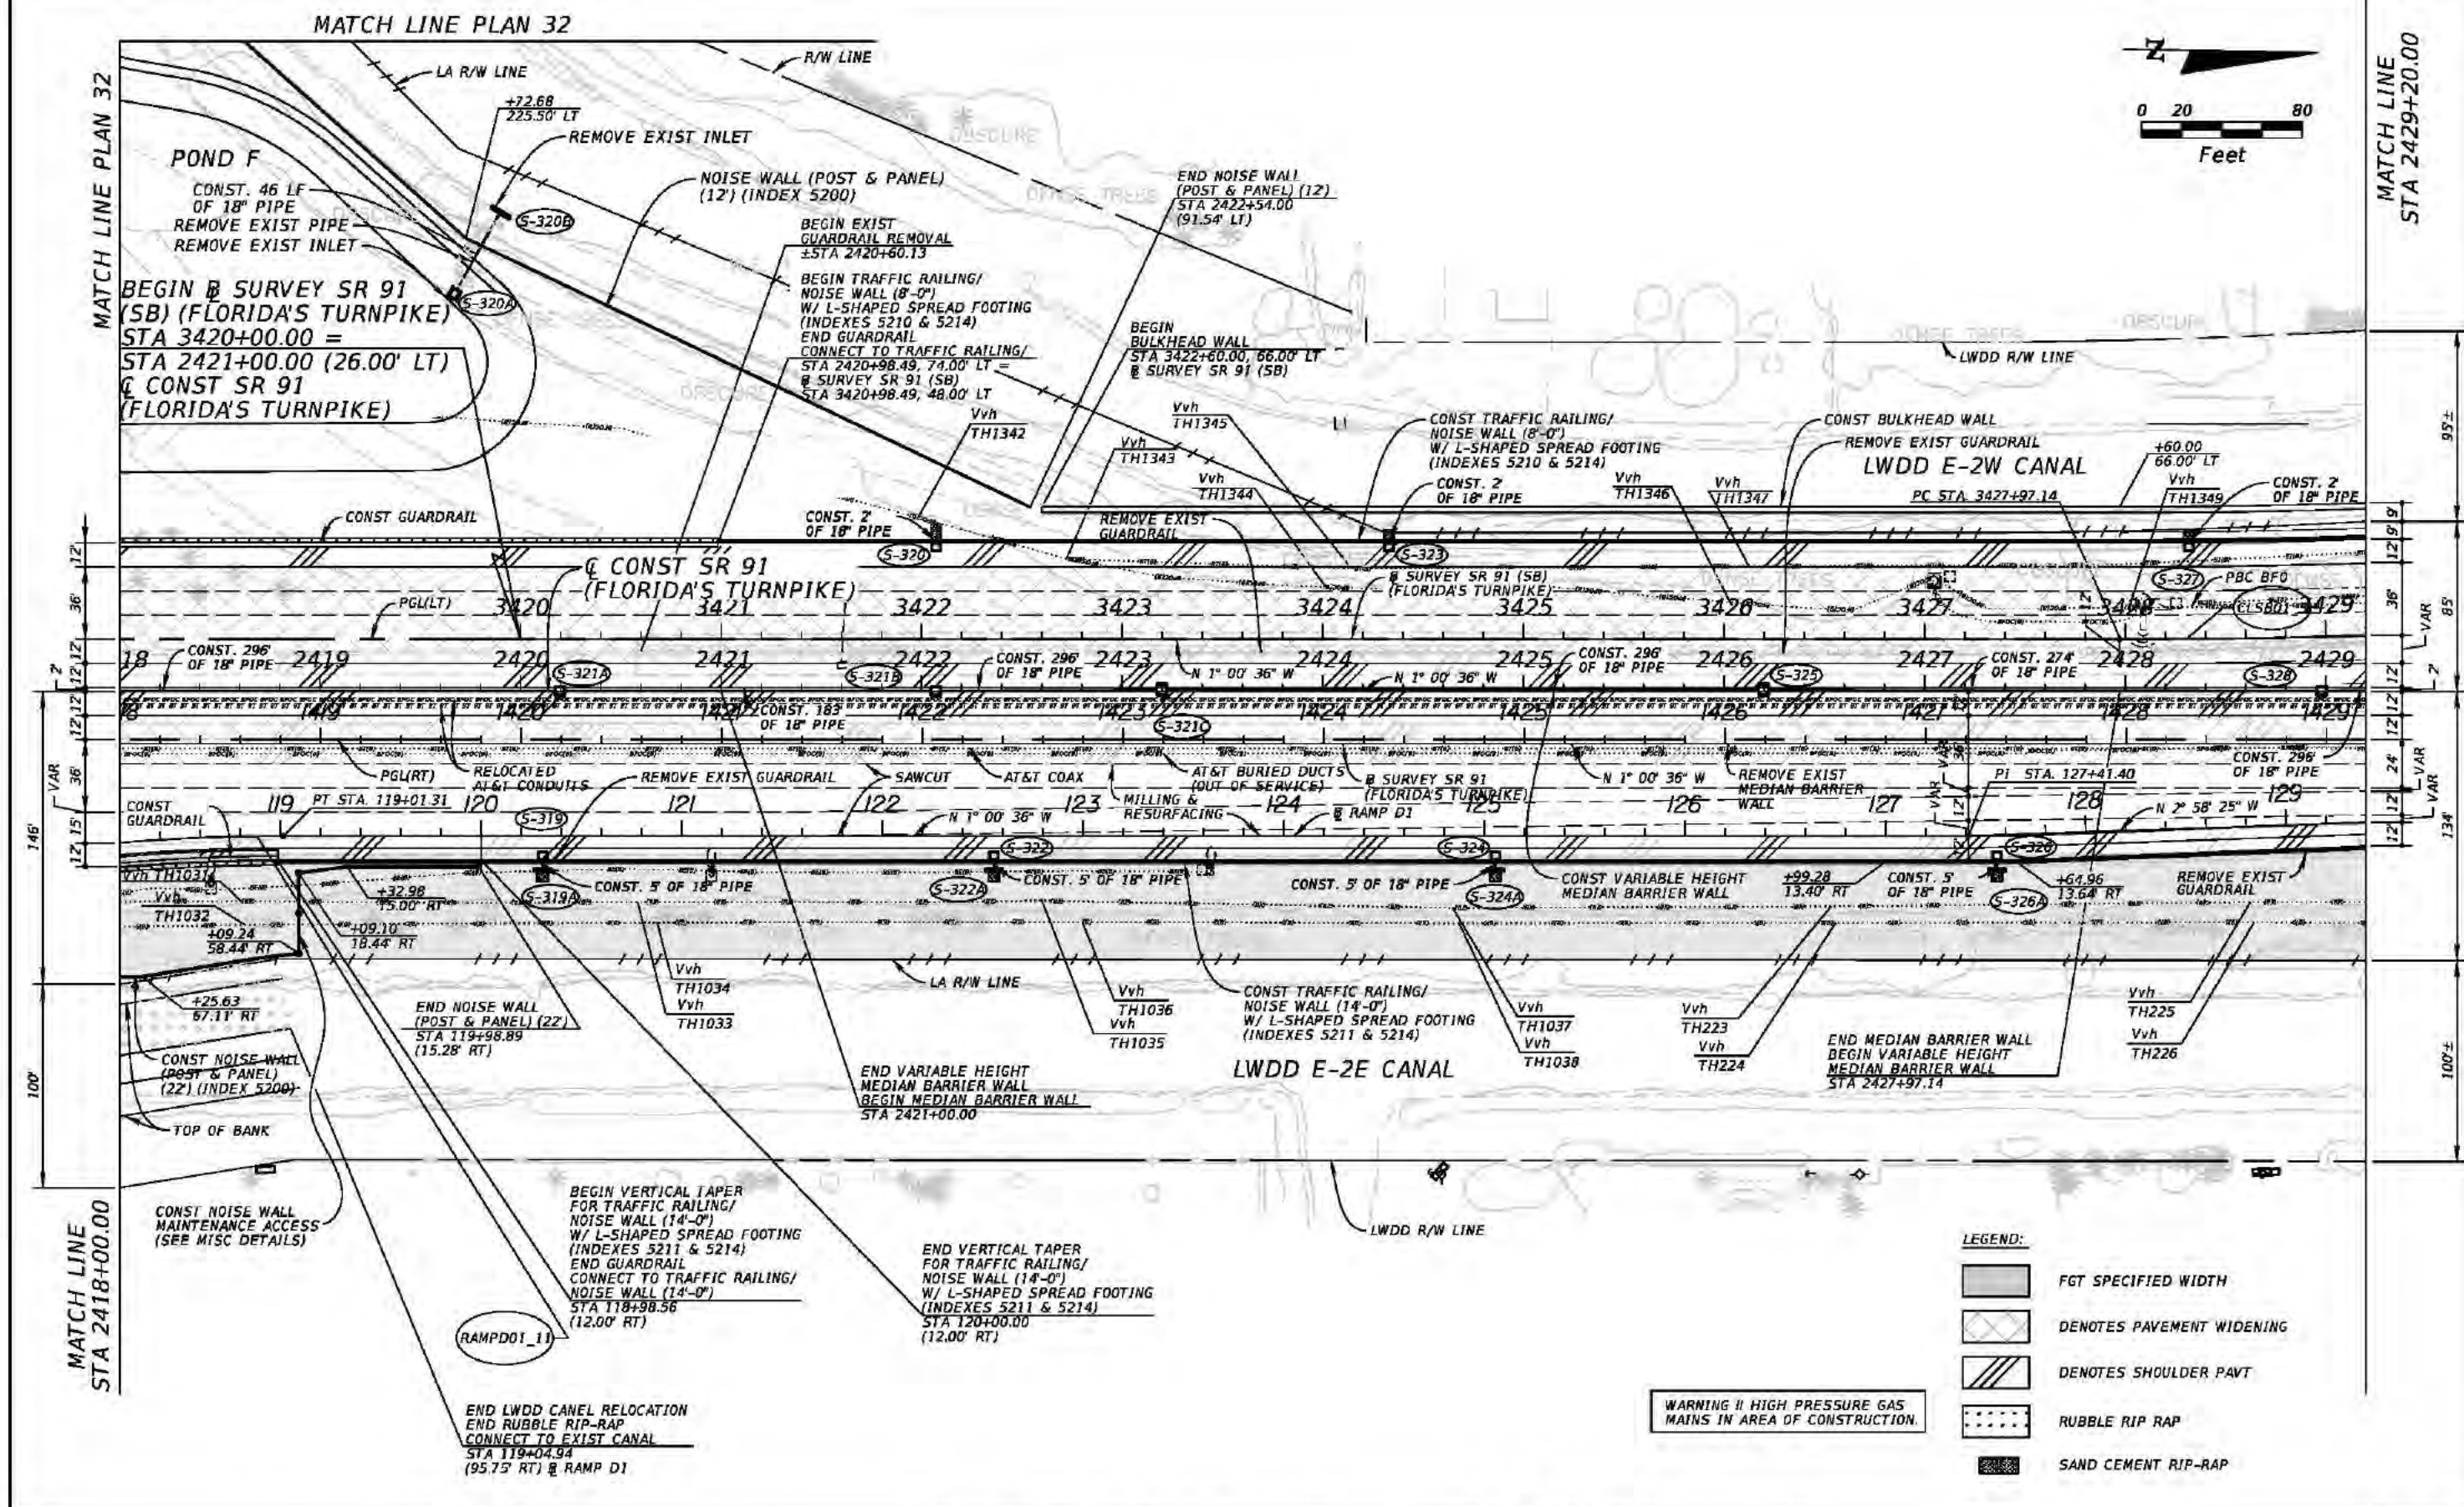

REVISIONS				Kimley-Horn and Associates, Inc. Certificate Of Authorization No. 696 Hool Gin Ng, P.E. P.E. License No. 58123 1920 Wekiva Way, Suite 200 West Palm Beach, Florida 33411	STATE OF FLORIDA DEPARTMENT OF TRANSPORTATION			ROADWAY PLAN (34)	SHEET NO.
DATE	DESCRIPTION	DATE	DESCRIPTION		ROAD NO.	COUNTY	FINANCIAL PROJECT ID		
					SR 91	PALM BEACH	406144-1-52-01		89

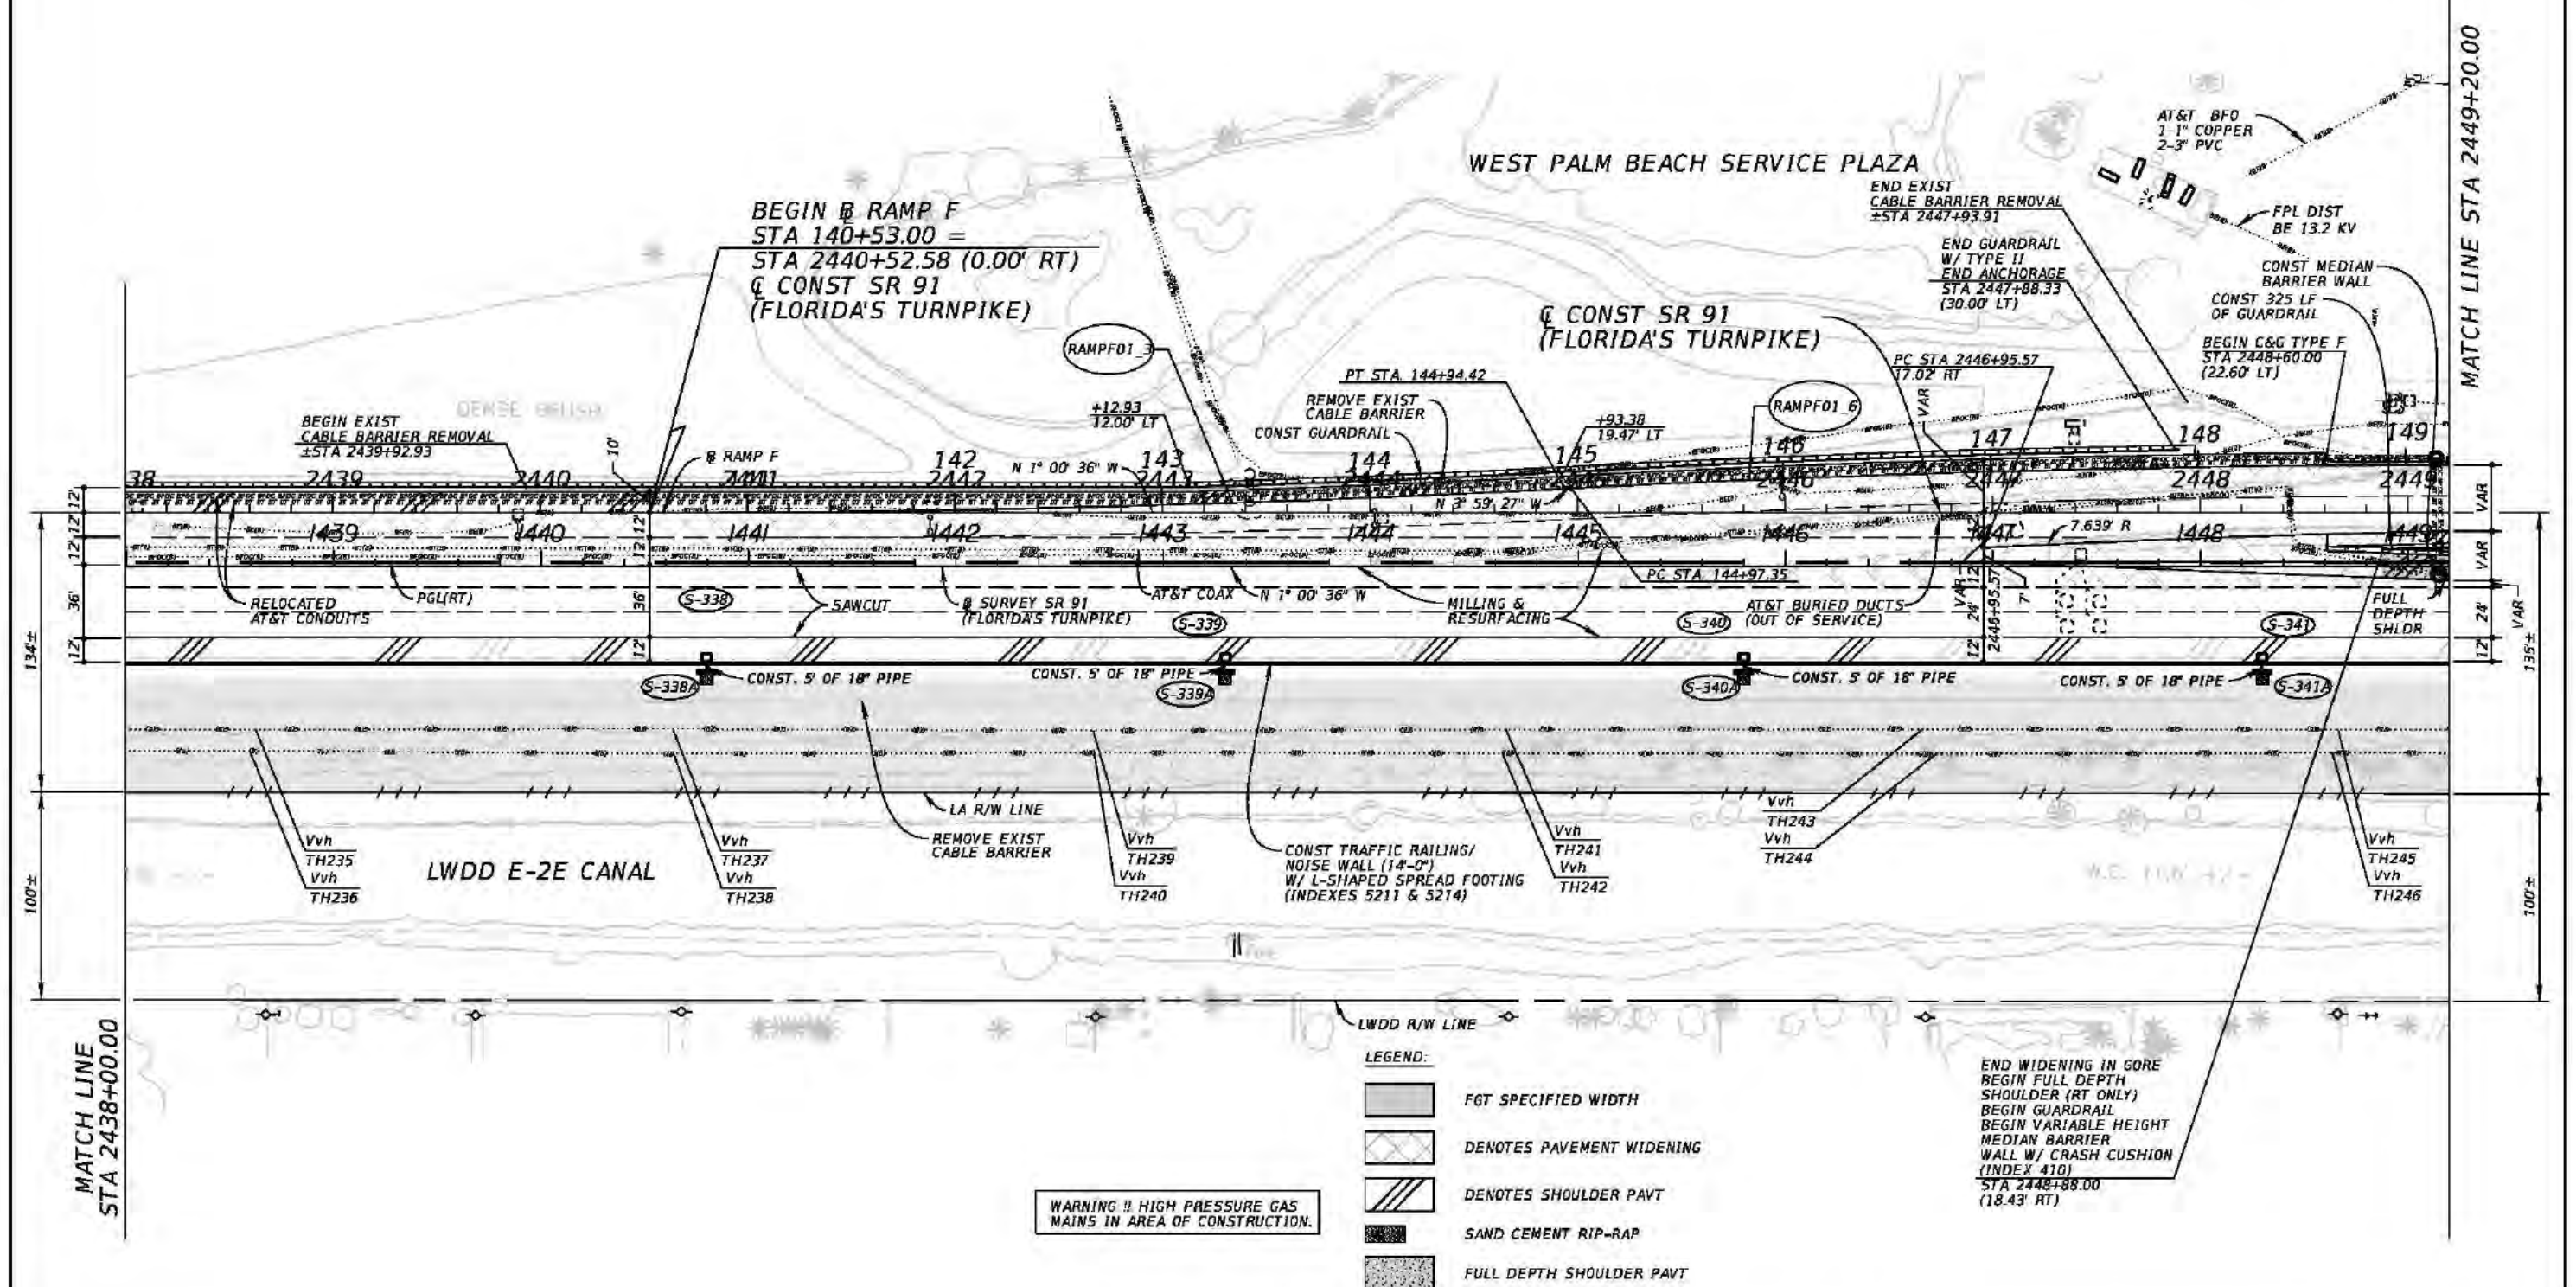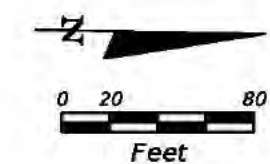


WARNING !! HIGH PRESSURE GAS
MAINS IN AREA OF CONSTRUCTION.



- LEGEND:
- FGT SPECIFIED WIDTH
 - DENOTES PAVEMENT WIDENING
 - DENOTES SHOULDER PAVT
 - SAND CEMENT RIP-RAP
 - FULL DEPTH SHOULDER PAVT

END WIDENING IN GORE
BEGIN FULL DEPTH
SHOULDER (RT ONLY)
BEGIN GUARDRAIL
BEGIN VARIABLE HEIGHT
MEDIAN BARRIER
WALL W/ CRASH CUSHION
(INDEX 410)
STA 2448+88.00
(18.43' RT)

REVISIONS				Kimley-Horn and Associates, Inc. Certificate Of Authorization No. 696 Hool Gin Ng, P.E. P.E. License No. 58123 1920 Wekiva Way, Suite 200 West Palm Beach, Florida 33411	STATE OF FLORIDA DEPARTMENT OF TRANSPORTATION			ROADWAY PLAN (36)	SHEET NO. 91
DATE	DESCRIPTION	DATE	DESCRIPTION		ROAD NO.	COUNTY	FINANCIAL PROJECT ID		
					SR 91	PALM BEACH	406144-1-52-01		

2/3/2017 3:51:33 PM K:\WPB_Design\040195061_TPK_BB_to_LW\40614415201_Roadway\roadway\plans\planrd36.dgn


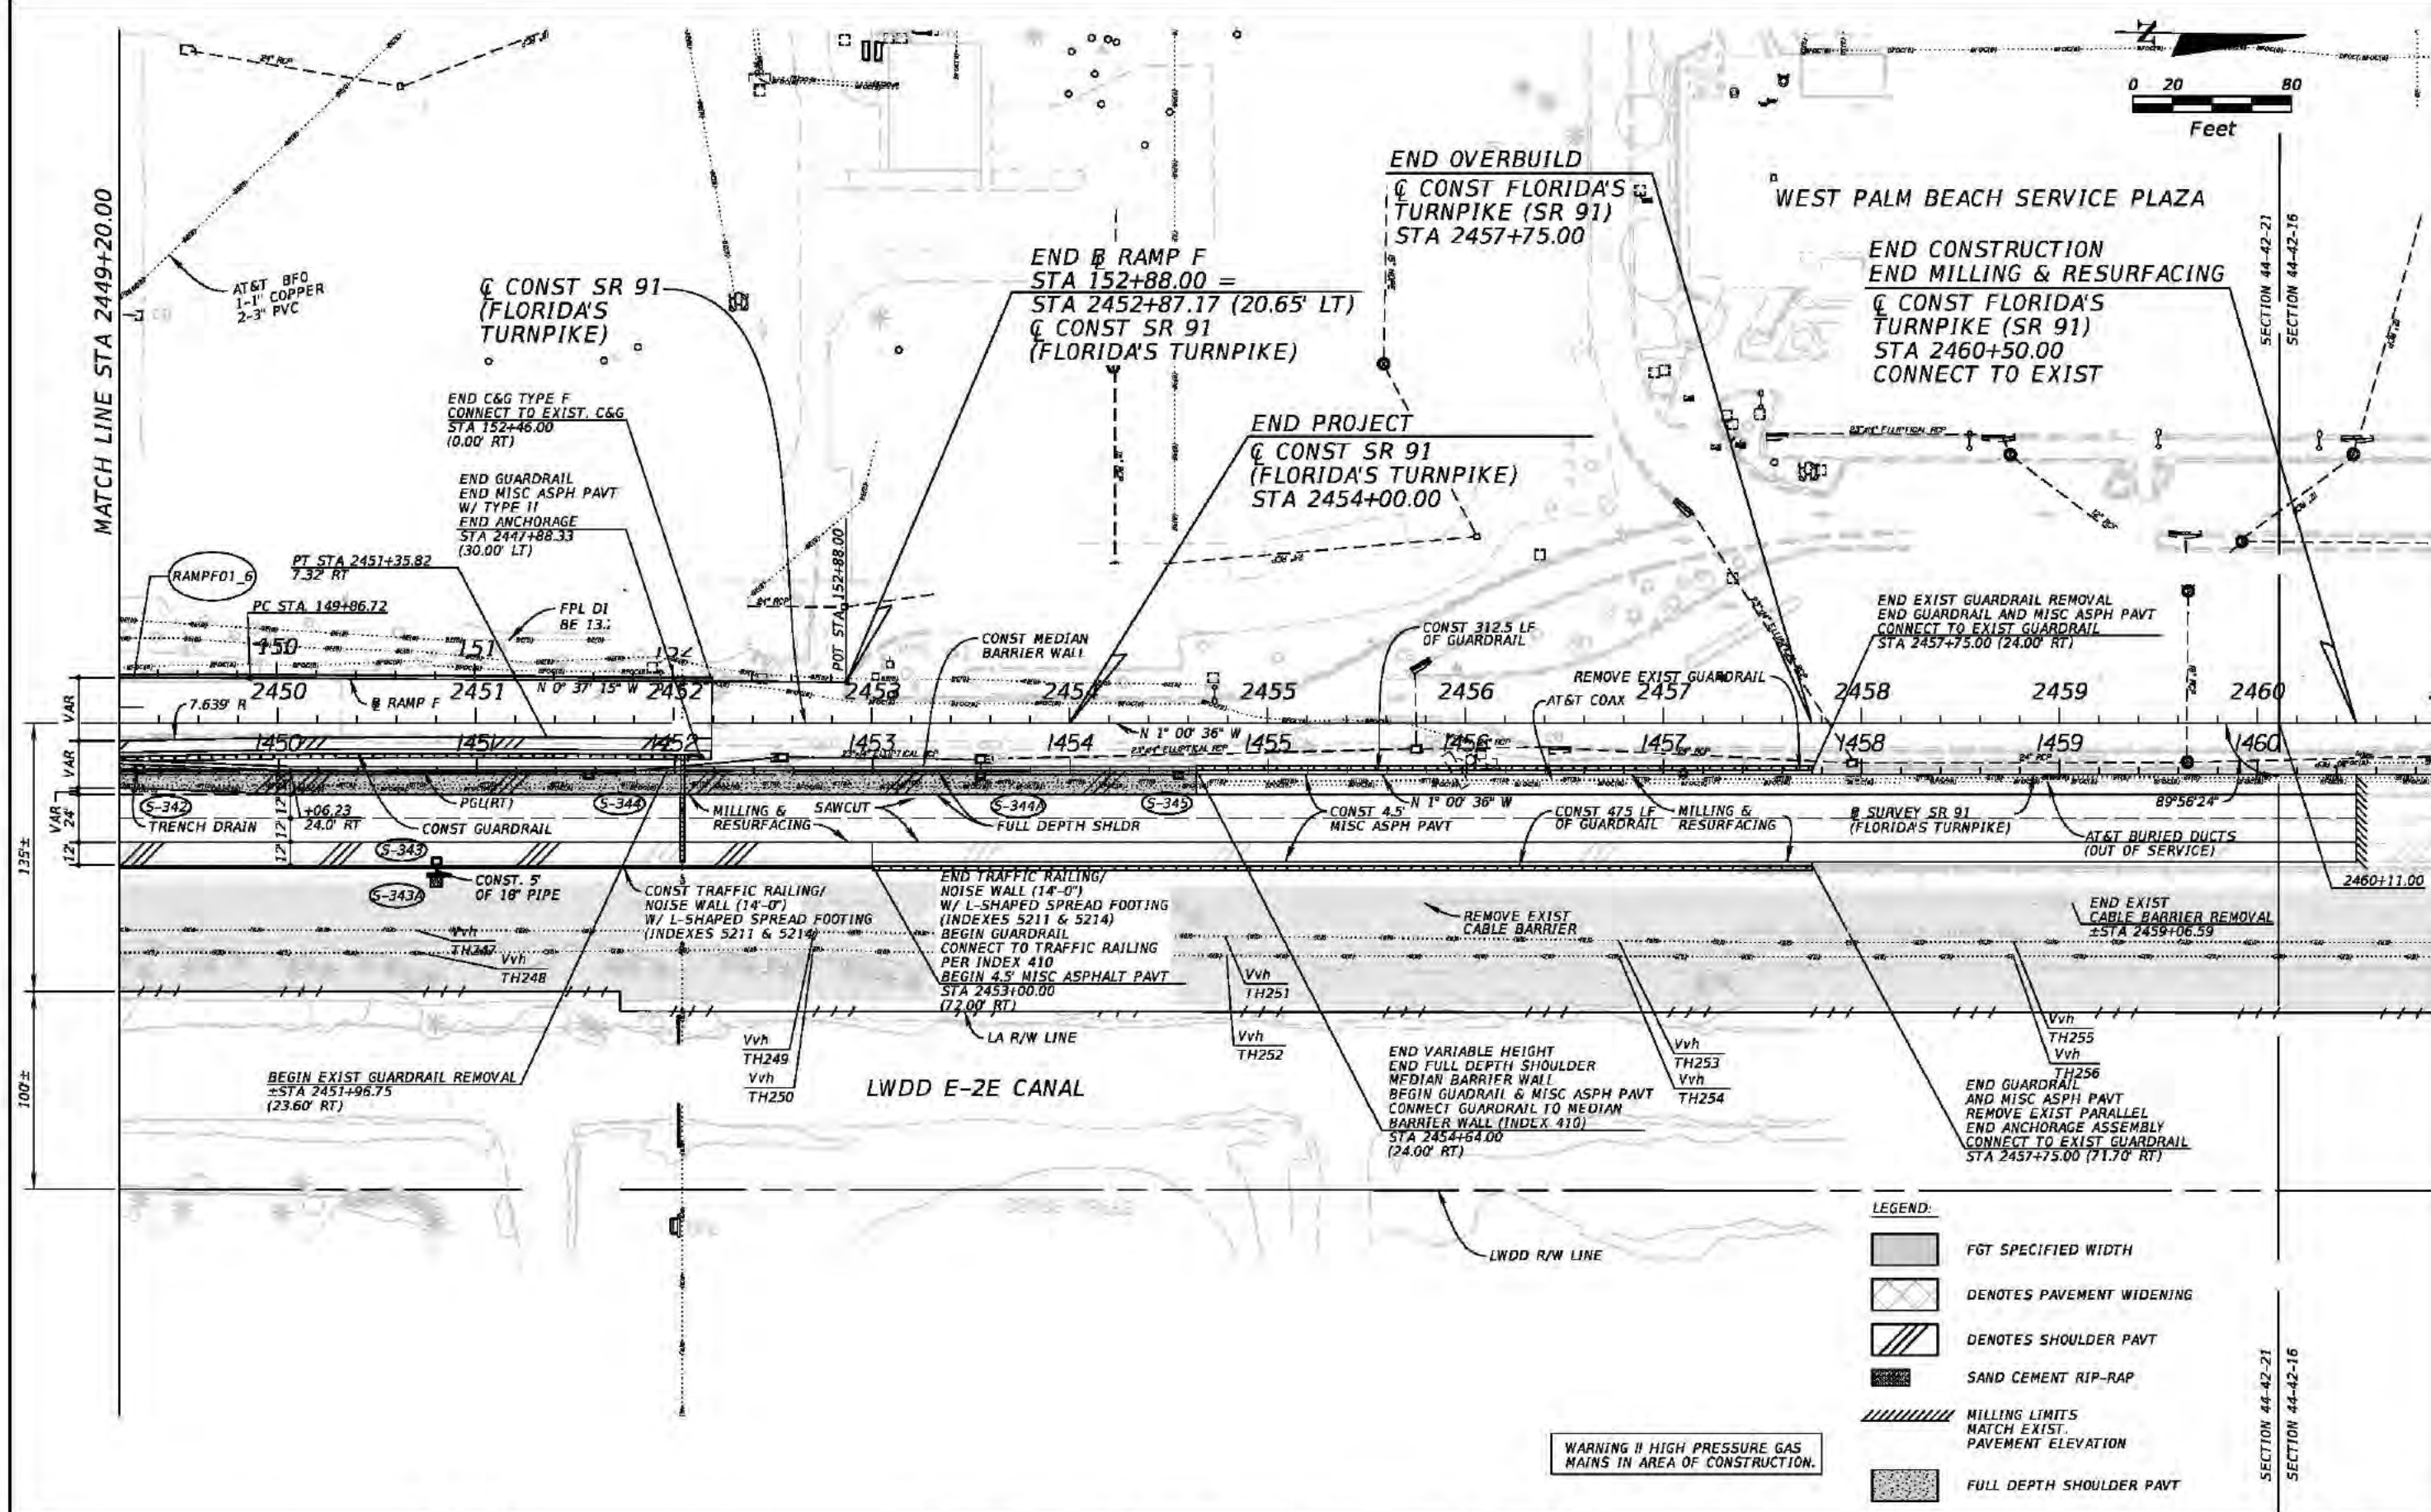


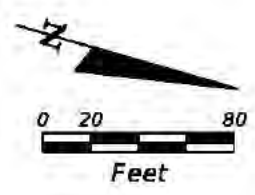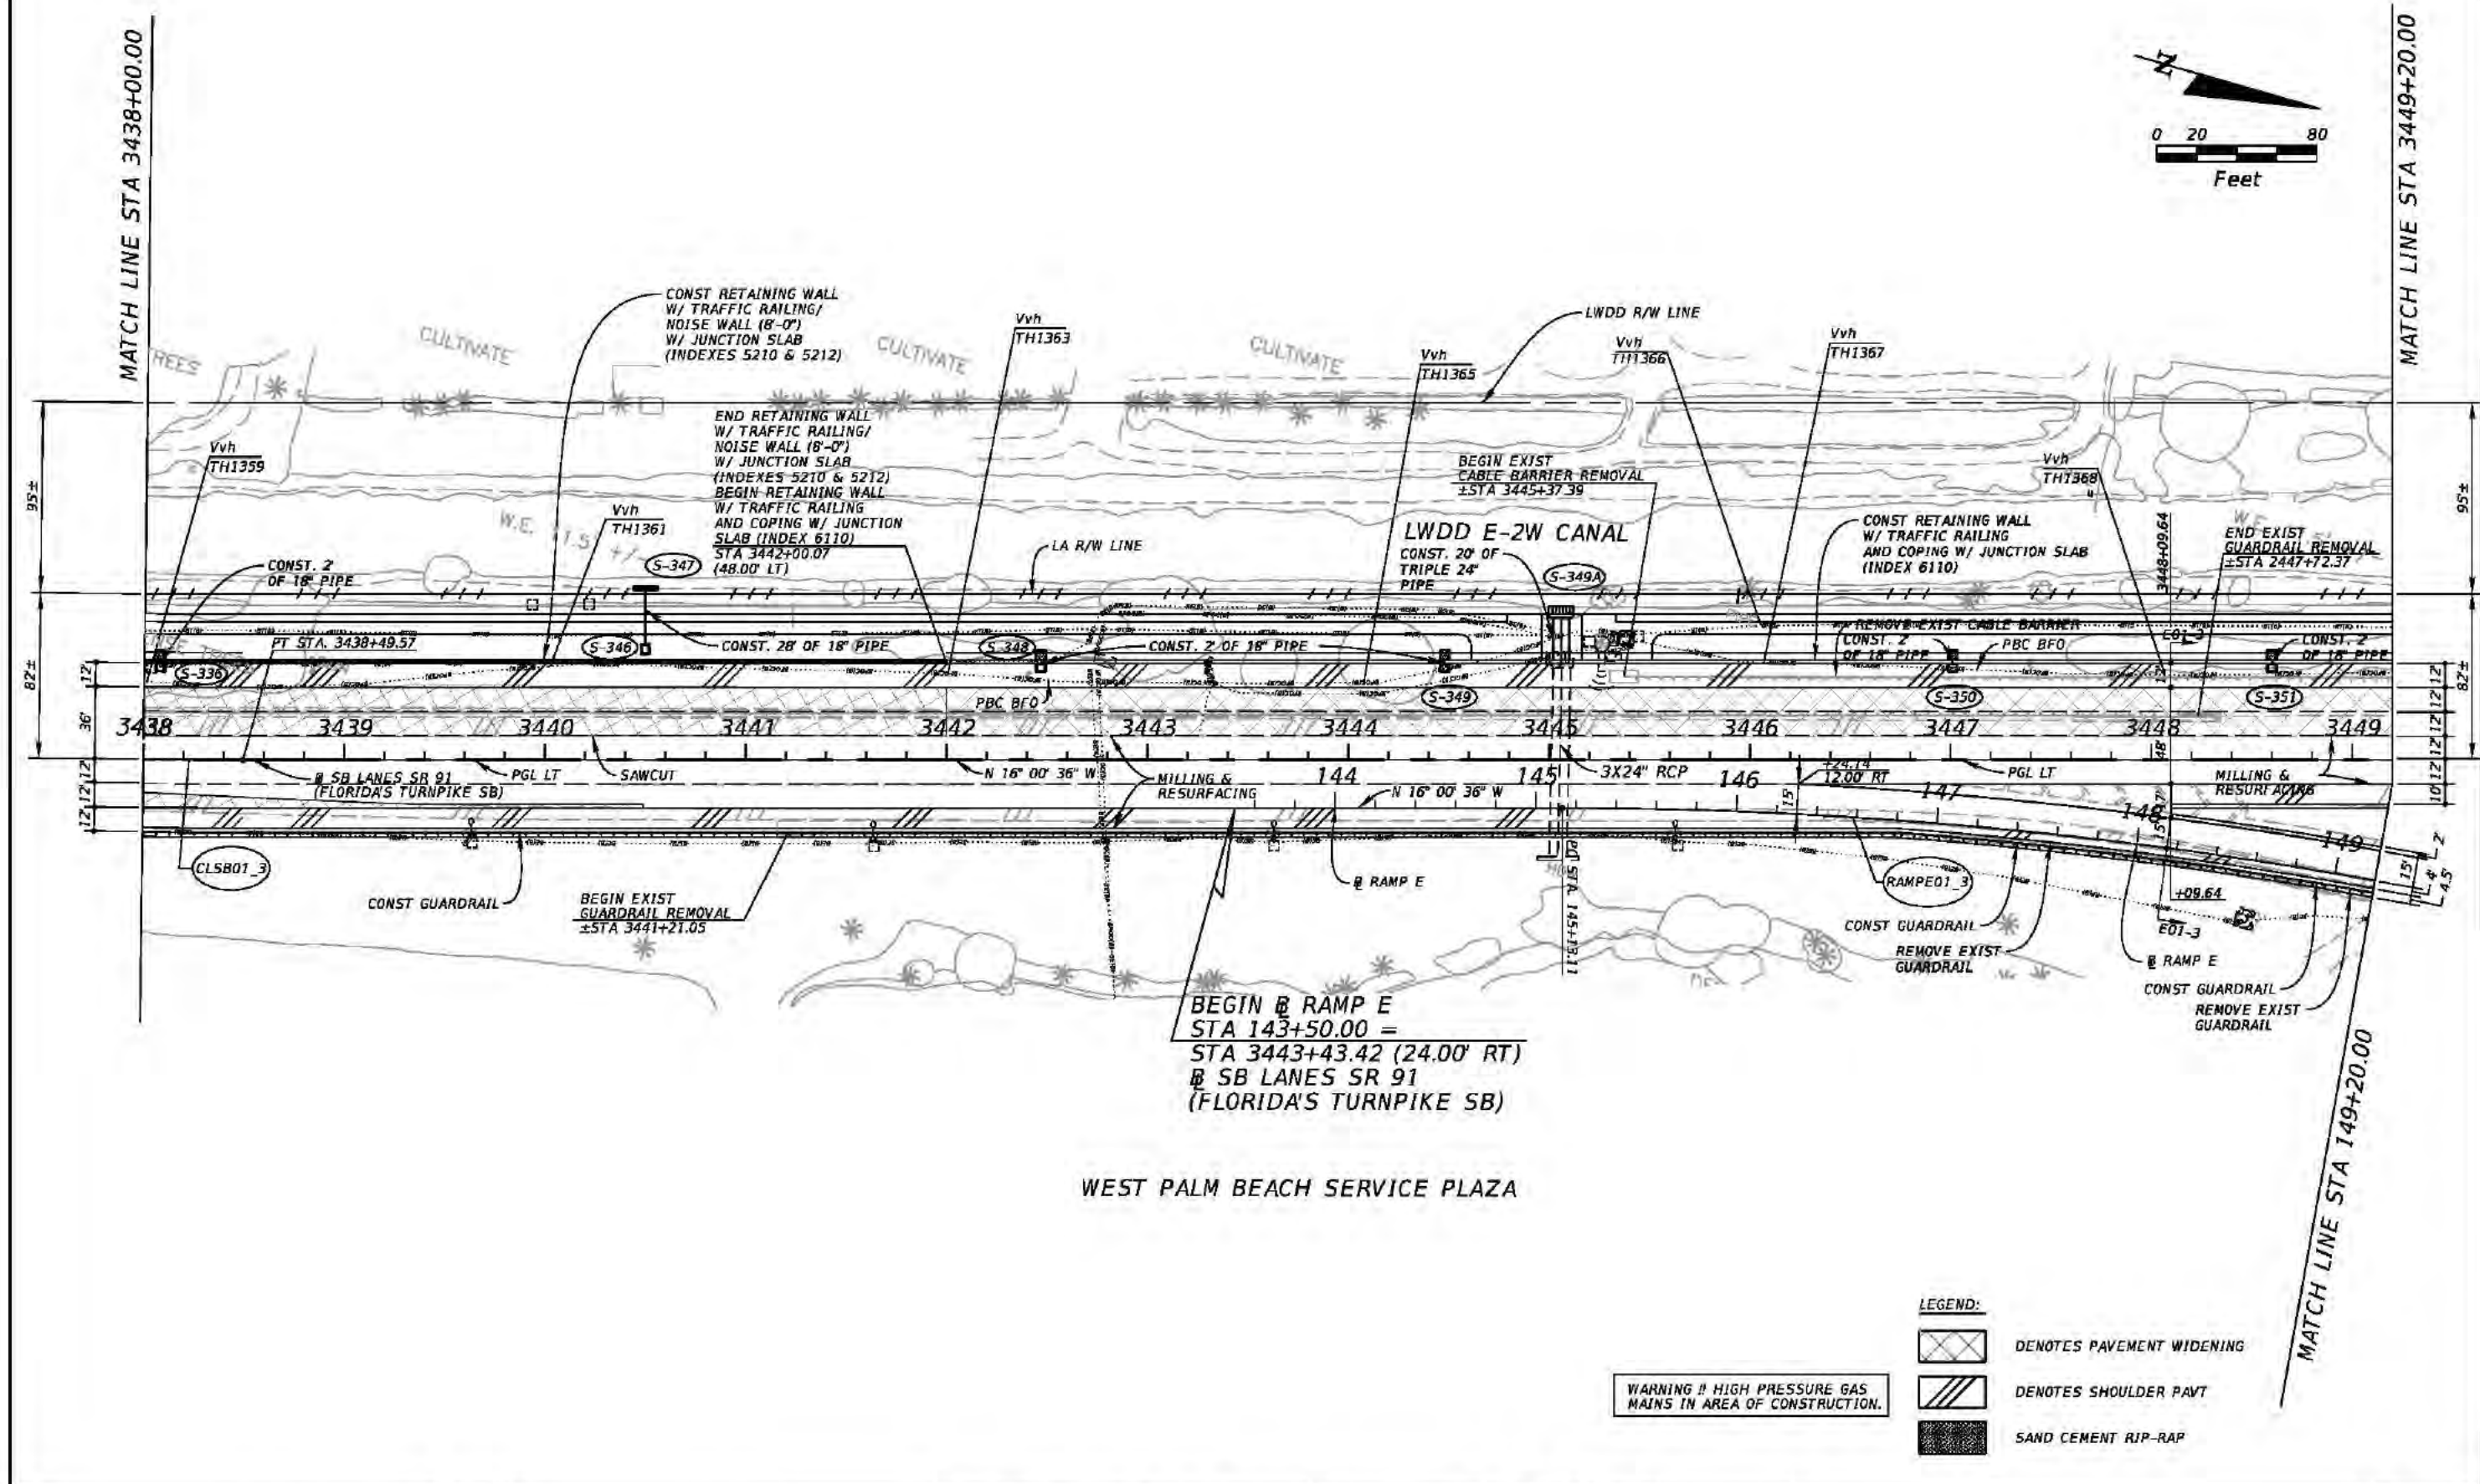

- LEGEND:**
- DENOTES PAVEMENT WIDENING
 - DENOTES SHOULDER PAVT
 - SAND CEMENT RIP-RAP



WARNING !! HIGH PRESSURE GAS MAINS IN AREA OF CONSTRUCTION.

REVISIONS				Kimley-Horn and Associates, Inc. Certificate Of Authorization No. 696 Hool Gin Ng, P.E. P.E. License No. 58123 1920 Wekiva Way, Suite 200 West Palm Beach, Florida 33411	STATE OF FLORIDA DEPARTMENT OF TRANSPORTATION			ROADWAY PLAN (38)	SHEET NO. 93
DATE	DESCRIPTION	DATE	DESCRIPTION		ROAD NO.	COUNTY	FINANCIAL PROJECT ID		
					SR 91	PALM BEACH	406144-1-52-01		

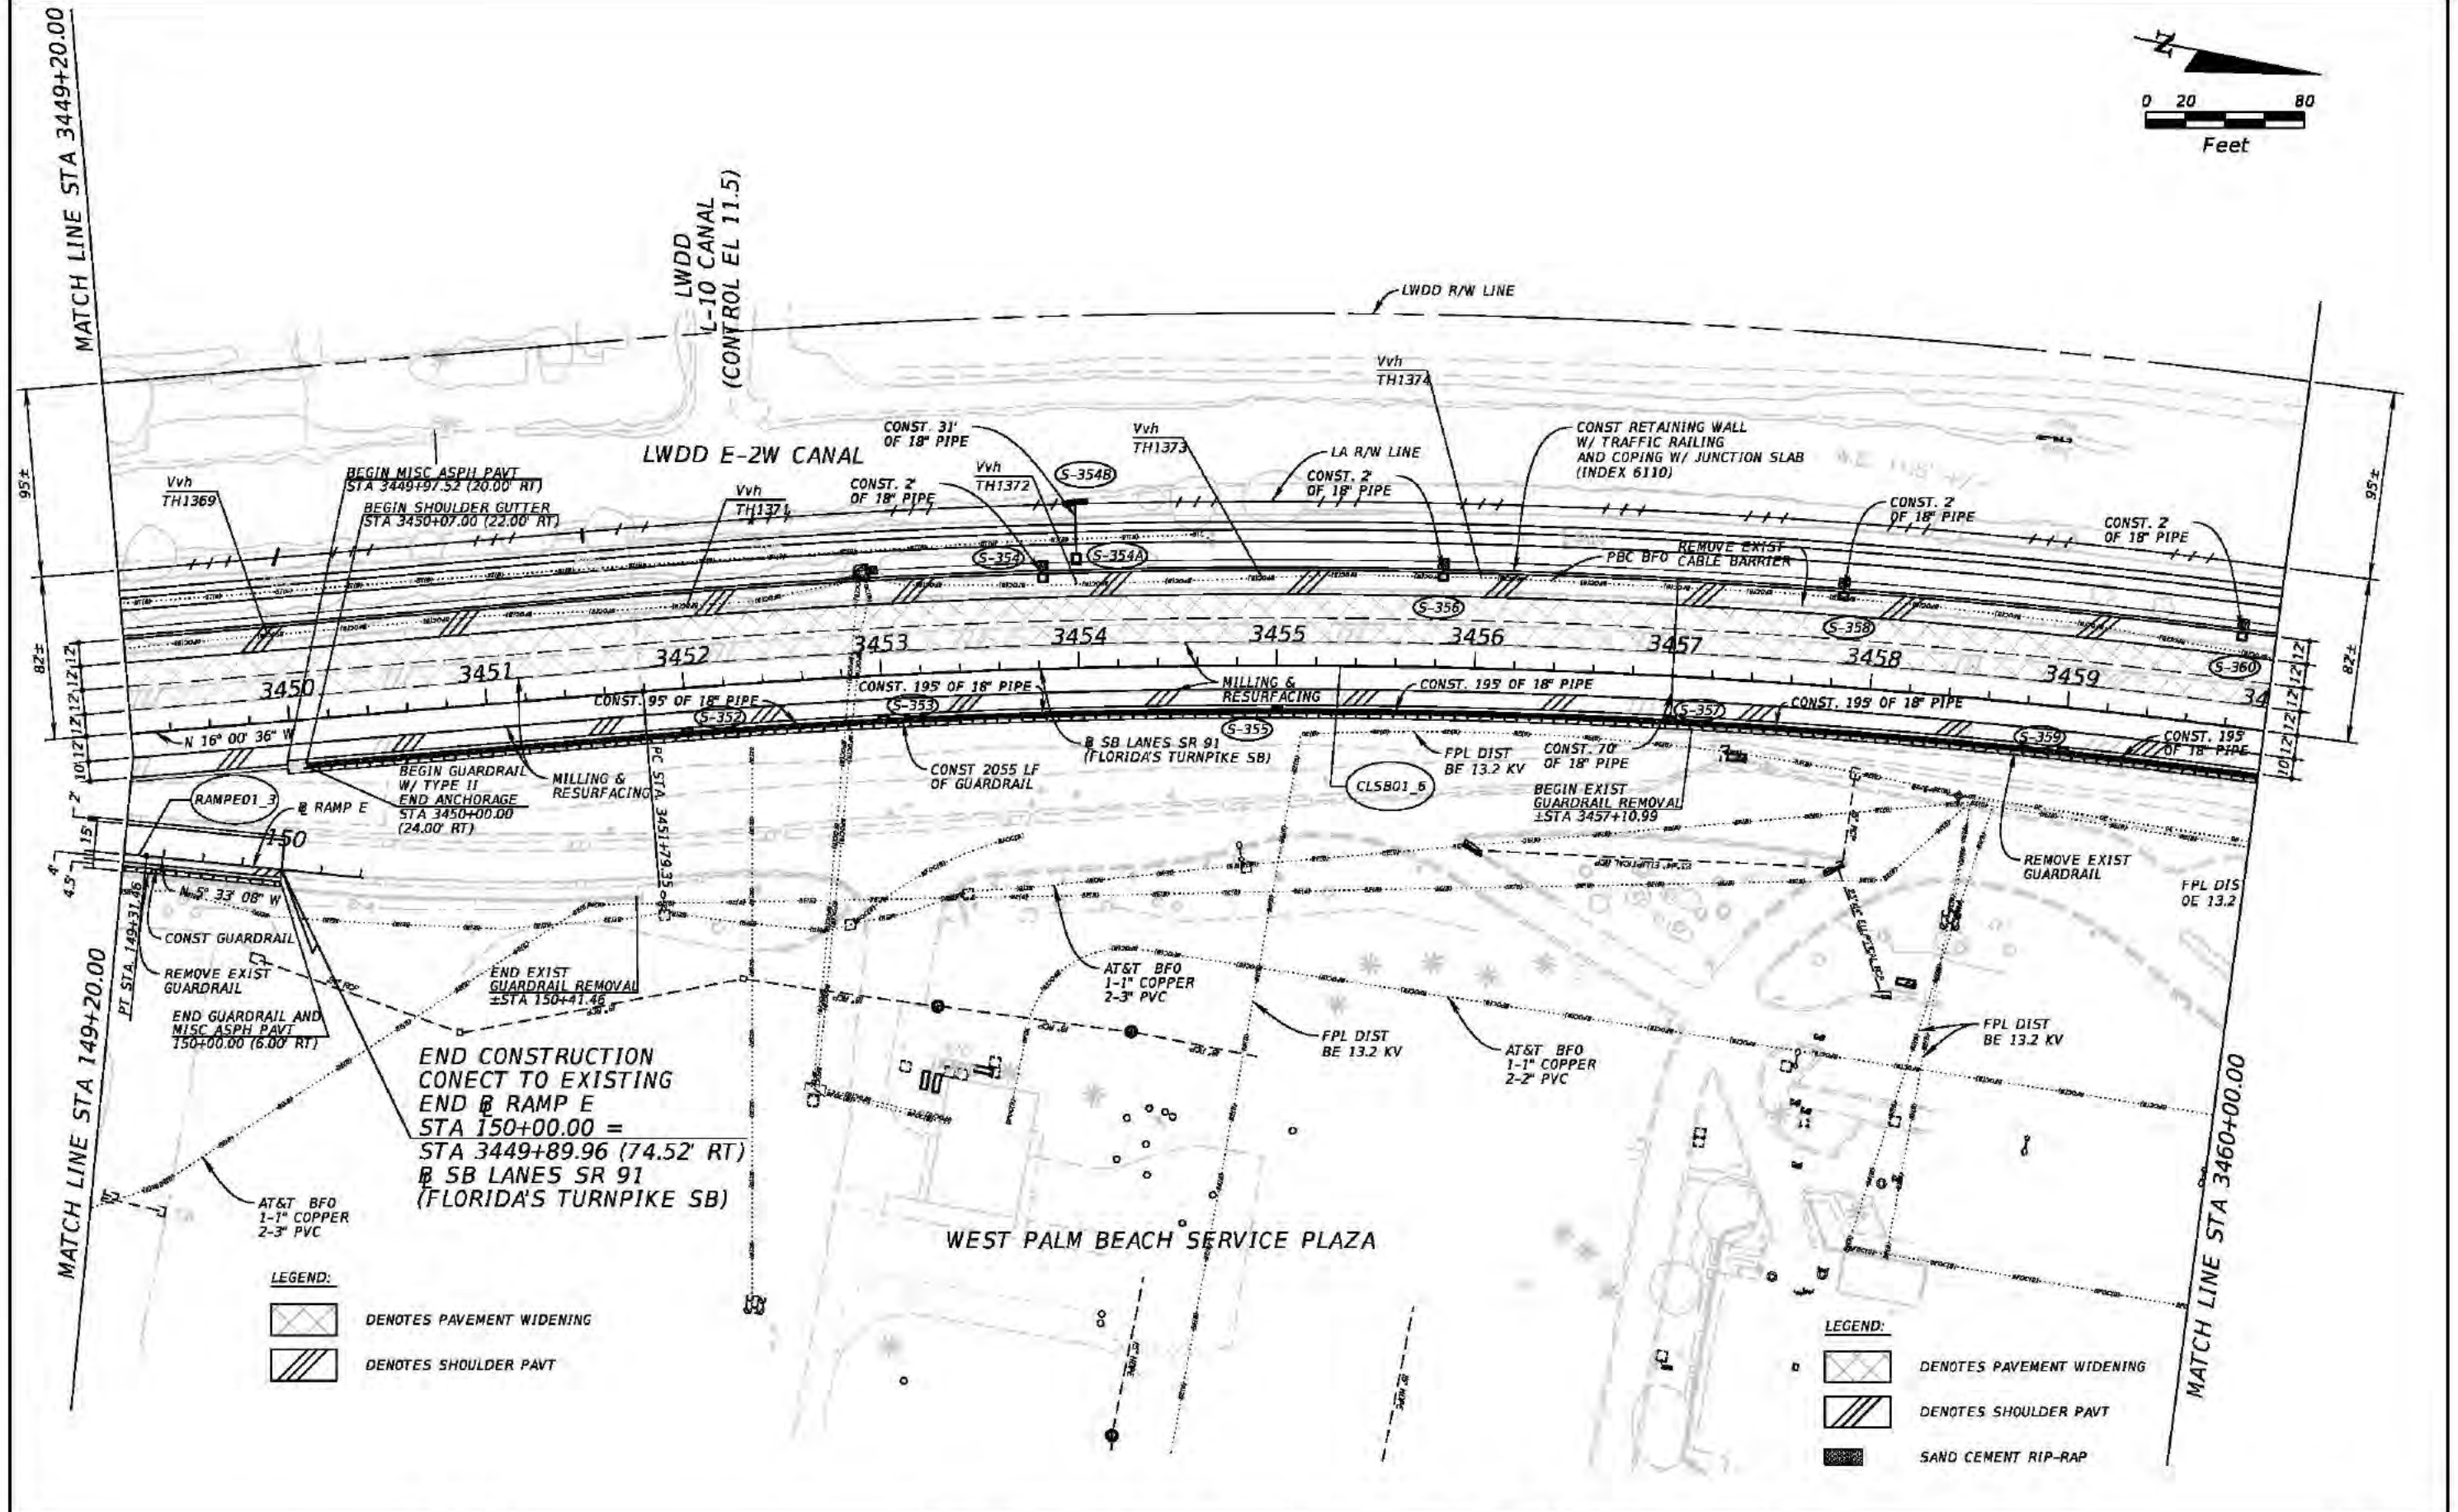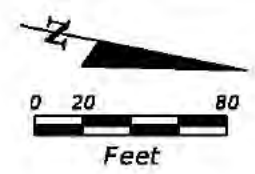

REVISIONS				Kimley-Horn and Associates, Inc. Certificate Of Authorization No. 696 Hool Gin Ng, P.E. P.E. License No. 58123 1920 Wekiva Way, Suite 200 West Palm Beach, Florida 33411	STATE OF FLORIDA DEPARTMENT OF TRANSPORTATION			ROADWAY PLAN (39)	SHEET NO. 94
DATE	DESCRIPTION	DATE	DESCRIPTION		ROAD NO.	COUNTY	FINANCIAL PROJECT ID		
					SR 91	PALM BEACH	406144-1-52-01		

2/3/2017 3:51:44 PM K:\WPB_Design\040195061_TPK_BB_to_LW\40614415201_Realign\roadway\plans\planrd39.dgn

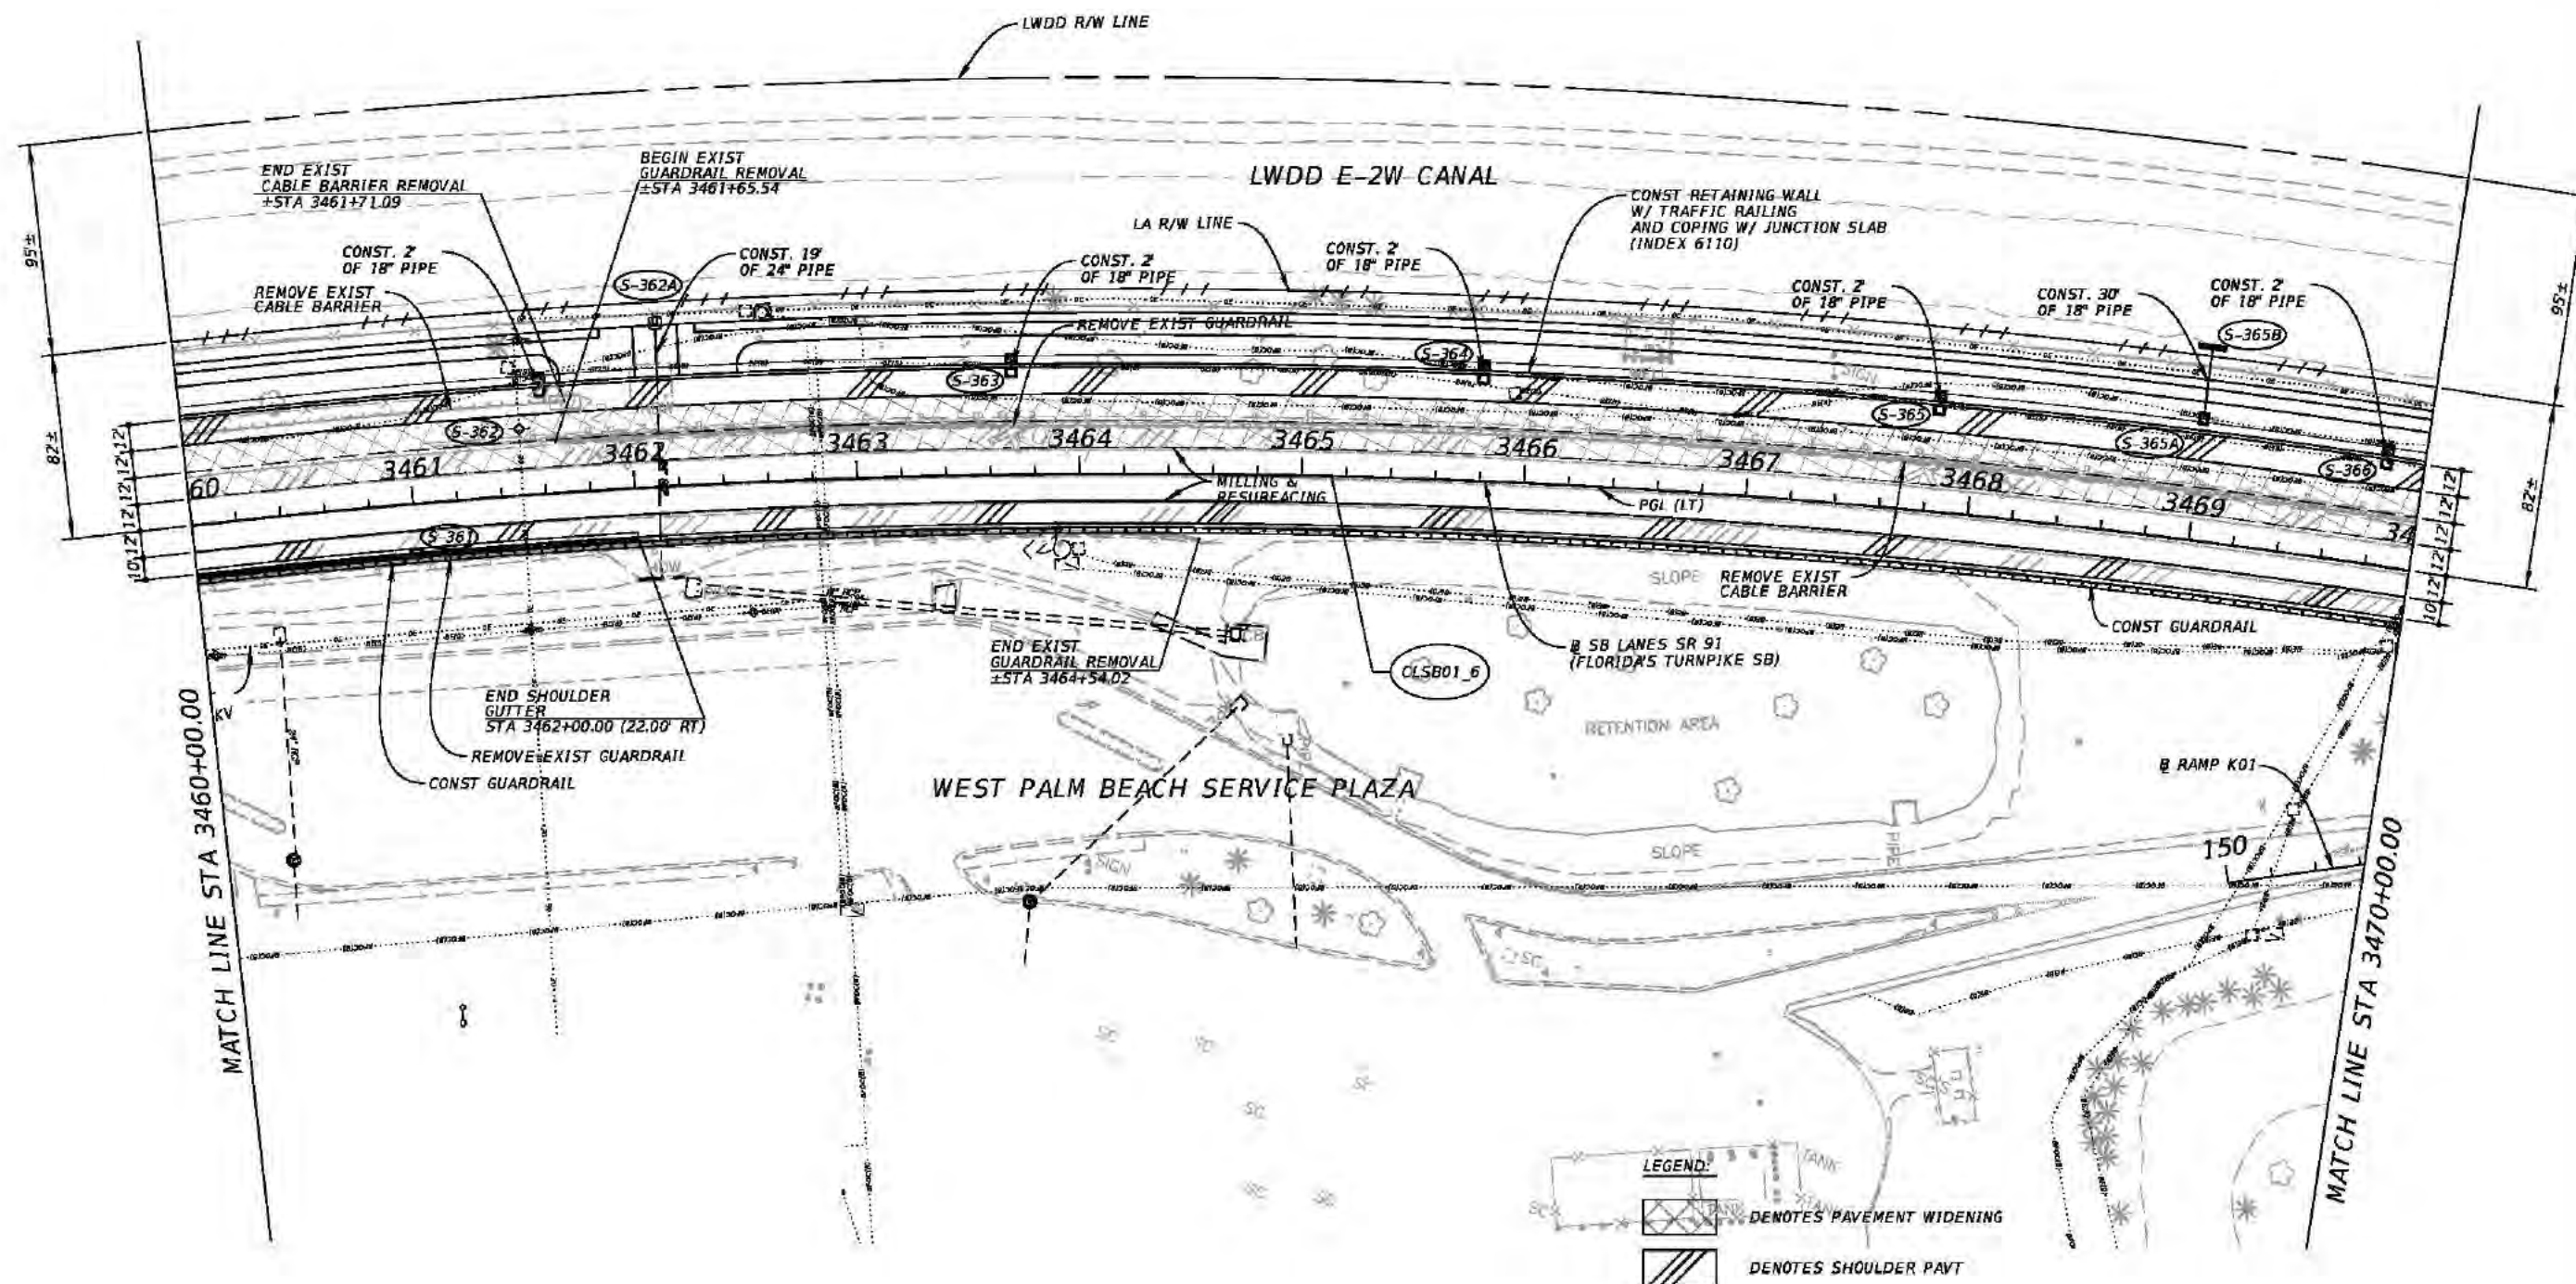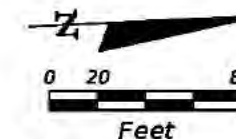

REVISIONS			
DATE	DESCRIPTION	DATE	DESCRIPTION



Kimley-Horn and Associates, Inc.
 Certificate Of Authorization No. 696
 Hool Gin Ng, P.E.
 P.E. License No. 58123
 1920 Wekiva Way, Suite 200
 West Palm Beach, Florida 33411

STATE OF FLORIDA
 DEPARTMENT OF TRANSPORTATION


ROAD NO.	COUNTY	FINANCIAL PROJECT ID
SR 91	PALM BEACH	406144-1-52-01

ROADWAY PLAN (40)

SHEET
 NO.
 95

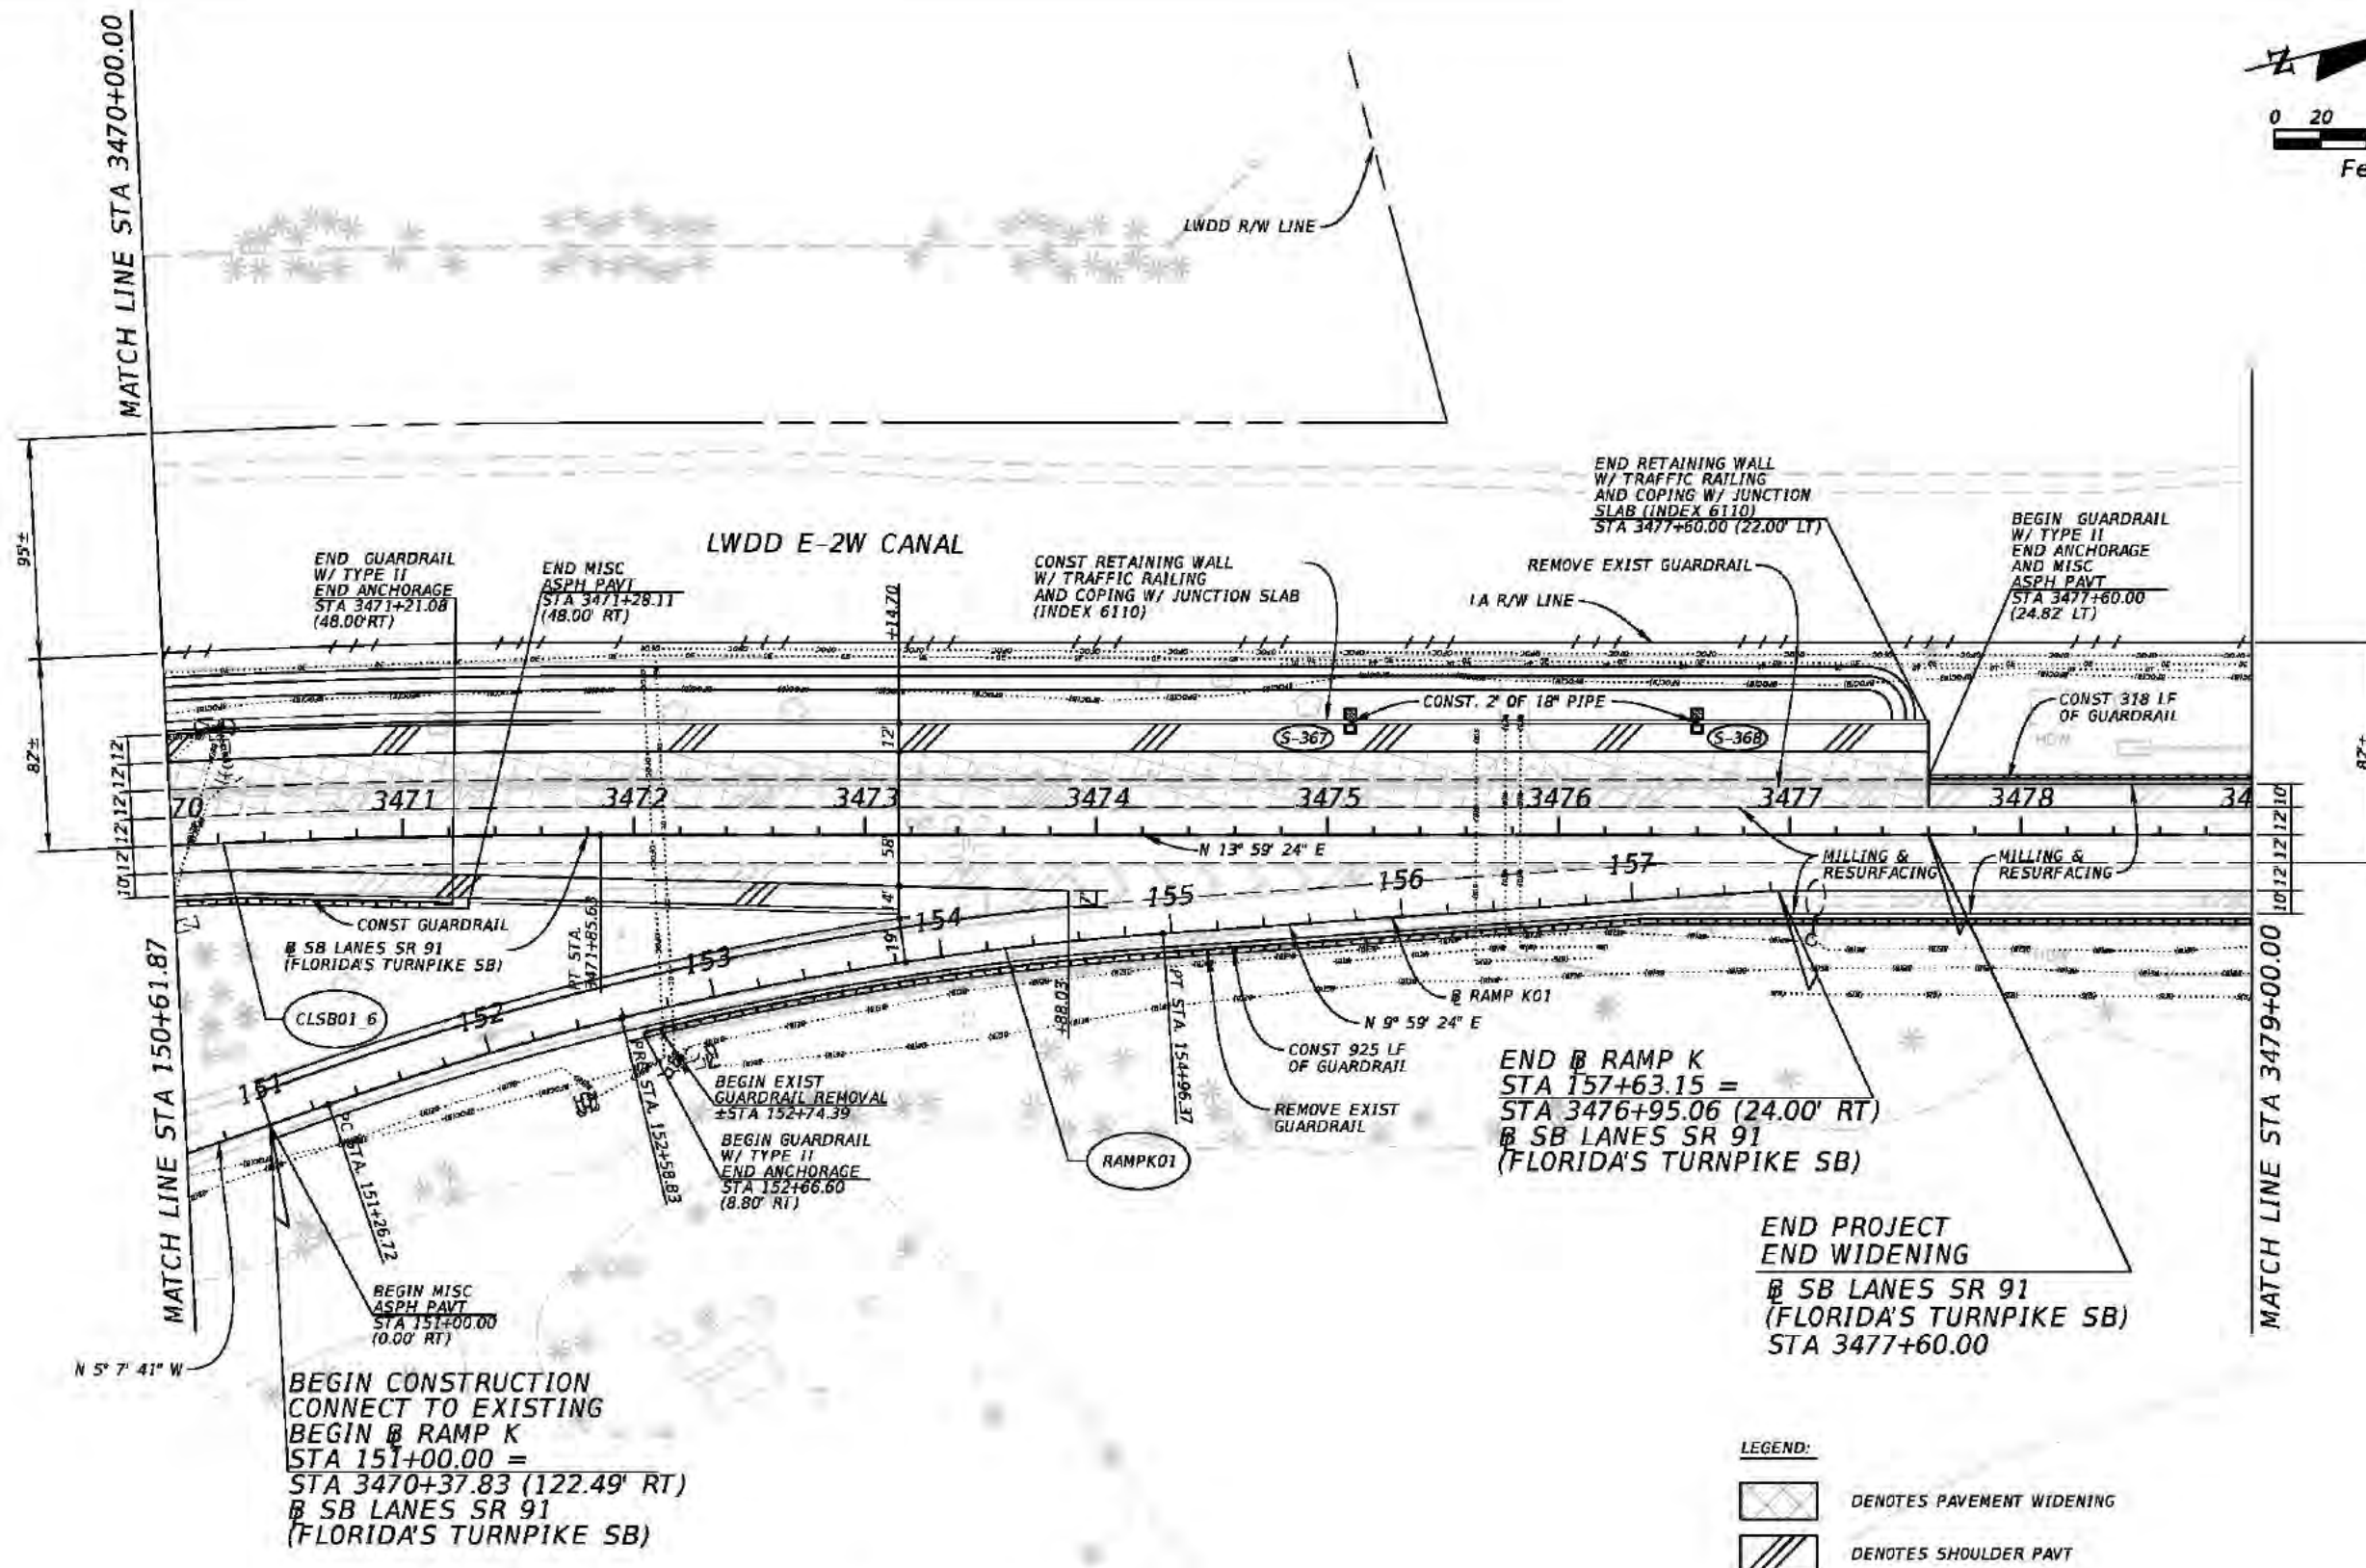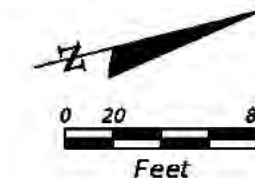

REVISIONS				Kimley-Horn and Associates, Inc. Certificate Of Authorization No. 696 Hool Gin Ng, P.E. P.E. License No. 58123 1920 Wekiva Way, Suite 200 West Palm Beach, Florida 33411	STATE OF FLORIDA DEPARTMENT OF TRANSPORTATION			ROADWAY PLAN (41)	SHEET NO. 96
DATE	DESCRIPTION	DATE	DESCRIPTION		ROAD NO.	COUNTY	FINANCIAL PROJECT ID		
					SR 91	PALM BEACH	406144-1-52-01		

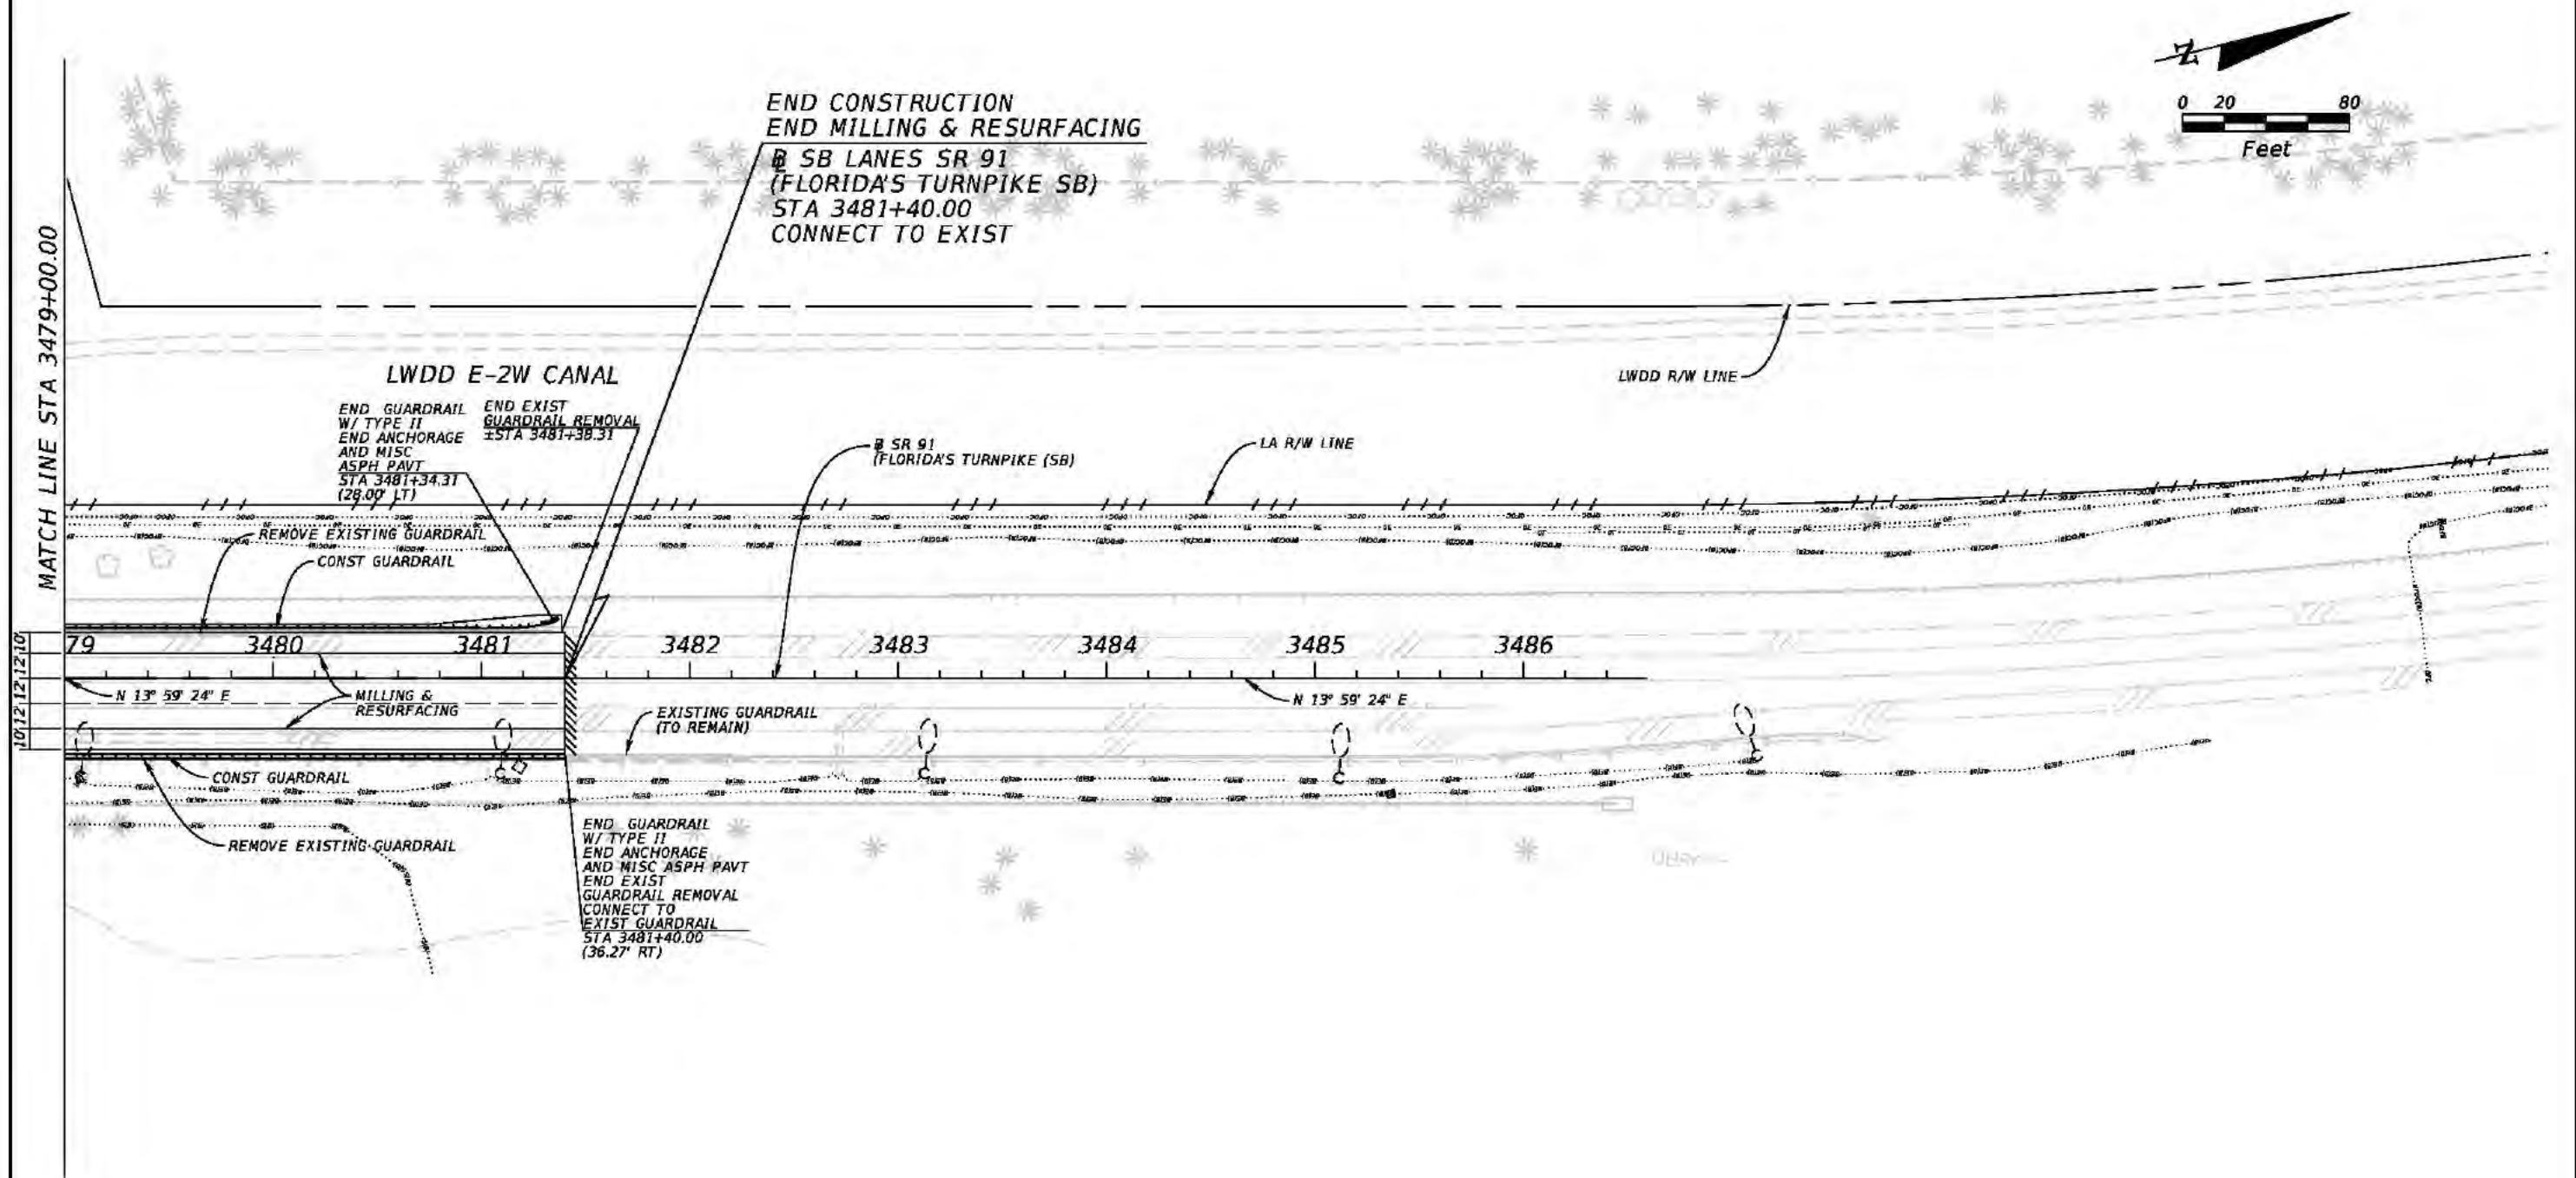

LEGEND:

	DENOTES PAVEMENT WIDENING
	DENOTES SHOULDER PAVT

REVISIONS				Kimley-Horn and Associates, Inc. Certificate Of Authorization No. 696 Hool Gin Ng, P.E. P.E. License No. 58123 1920 Wekiva Way, Suite 200 West Palm Beach, Florida 33411	STATE OF FLORIDA DEPARTMENT OF TRANSPORTATION			ROADWAY PLAN (42)	SHEET NO. 97
DATE	DESCRIPTION	DATE	DESCRIPTION		ROAD NO.	COUNTY	FINANCIAL PROJECT ID		
					SR 91	PALM BEACH	406144-1-52-01		

Rob Conklin 2/3/2017 3:51:52 PM K:\WPB_Design\040195061_TPK_BB_to_LW\40614415201_Realign\roadway\plans\planrd42.dgn